




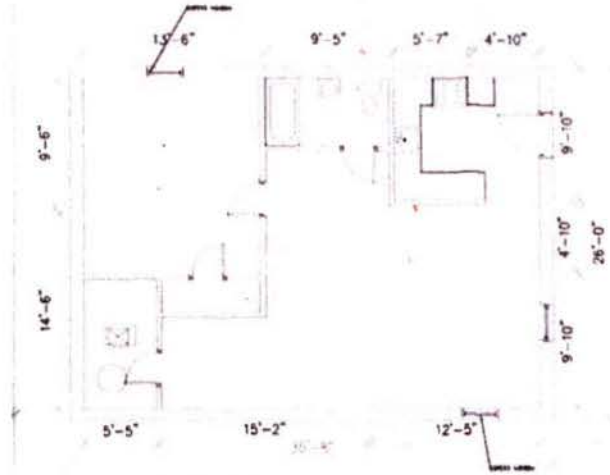


EXISTING BASEMENT FLOOR PLAN

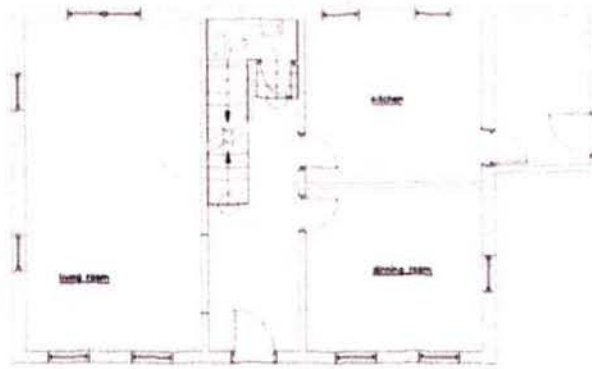

EXISTING FIRST FLOOR PLAN

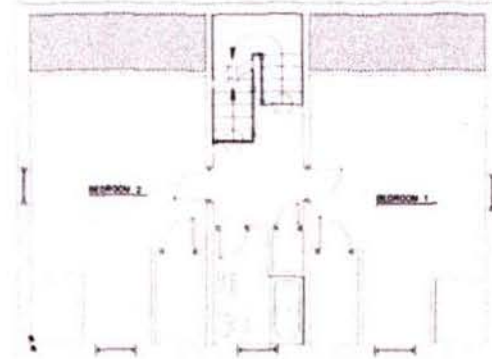

EXISTING ATTIC FLOOR PLAN

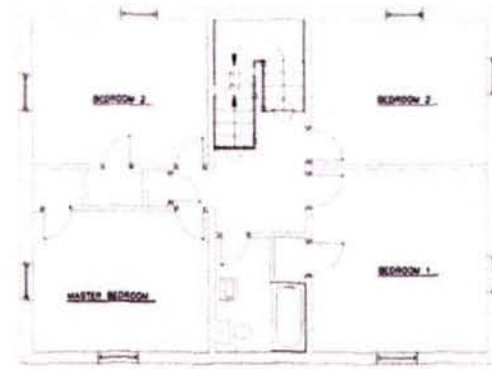

EXISTING SECOND FLOOR PLAN

JUL 31

BOARD OF ZONING ADJUSTMENT
District of Columbia

CASE NO. 18389

EXHIBIT NO. 24

PRINTED:

DRAWN:

1206 CRITTENDEN STREET NW
WASHINGTON DC 20011
SQUARE 2920 LOT 034

DESIGNED BY
CAS PERMITS SERVICES
747 KENTON ST NW
WASHINGTON, D.C. 20010
PHONE: 571-451-3790
E-MAIL: CASPERMITS@GMAIL.COM

A

FLOOR CEILING SYSTEMS WITH LAMINATE




Notes:
1. Laminate shall be 1/2" thick.
2. Laminate shall be 4' wide.
3. Laminate shall be 4' long.

The floor-ceiling system with laminate is a system that is designed to provide a finished floor and ceiling. The system is designed to be installed in a room that is 4' wide and 4' long. The system is designed to be installed in a room that is 4' wide and 4' long. The system is designed to be installed in a room that is 4' wide and 4' long.

FLOOR PLAN

TRUCK SCHEDULE

TRUCK	TRUCK	TRUCK	TRUCK
1. 1/2" thick laminate	1. 1/2" thick laminate	1. 1/2" thick laminate	1. 1/2" thick laminate
2. 1/2" thick laminate	2. 1/2" thick laminate	2. 1/2" thick laminate	2. 1/2" thick laminate
3. 1/2" thick laminate	3. 1/2" thick laminate	3. 1/2" thick laminate	3. 1/2" thick laminate
4. 1/2" thick laminate	4. 1/2" thick laminate	4. 1/2" thick laminate	4. 1/2" thick laminate

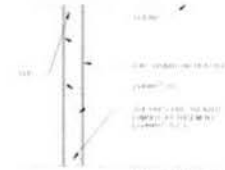


Notes:
1. Laminate shall be 1/2" thick.
2. Laminate shall be 4' wide.
3. Laminate shall be 4' long.

GENERAL NOTES

1. ALL DIMENSIONS TO CENTER LINE
2. FLOOR FINISH TO BE 1/2" MIN.
3. CEILING FINISH TO BE 1/2" MIN.
4. WALLS TO BE 1/2" MIN.
5. STAIRS TO BE 1/2" MIN.
6. CHAIR WHEELS TO BE 1/2" MIN.
7. 1/2" MIN.
8. 1/2" MIN.
9. 1/2" MIN.
100. 1/2" MIN.

INDEX
A EXISTING FLOOR PLANS
M MECH PLANS
E ELECTRICAL PLANS
R RISERS PLANS

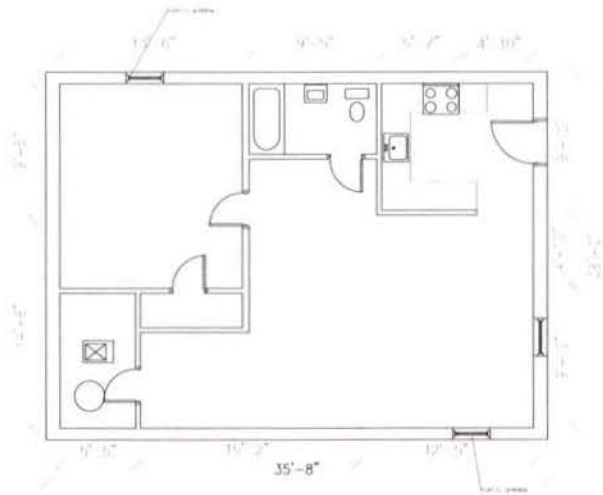

BASMENT FLOOR PLAN
SCALE: 1/4"=1'-0" 900 sq ft



FIRST FLOOR PLAN
SCALE: 1/4"=1'-0" 980 sq ft

PRINTED

OWNER

SHOWN BY:
C/S PERITS SERVICES
747 KENYON ST NW
WASHINGTON, D.C. 20010
PHONE: 571-451-5790
E-MAIL: C/S PERITS@GMAIL.COM

1230 COTTAGE STREET NW
WASHINGTON, D.C. 20010
SUITE 200 20010

A1