

EARTH DIKE		A-2, B-3
STRAIN BALE DIKE		SRD
SILT FENCE		SF
TEMPORARY SWALE		A-2, B-3
STABILIZED CONSTRUCTION ENTRANCE		SEA
GRADE STABILIZATION STRUCTURE		PS-2 PSO-12
PIPE SLOPE DRAIN		PSD-12
PERIMETER DIKE/SWALE		PD/S-1
CURB INLET PROTECTION		CIP
DIVERSION		
GRASSED WATERWAY		
LINED WATERWAY		
ROCK OUTLET PROTECTION		ROPS
SUBSURFACE DRAIN		
JERSEY BARRIER		
TURBIDITY CURTAIN		TC

Diagram illustrating a stabilized construction entrance. A dump truck is shown driving through a bed of stabilized material. A worker is operating a roller behind the truck. Labels include 'FLOW', 'VEHICLE WASH AREA', and 'STABILIZED CONSTRUCTION ENTRANCE'.

BRICKBATS

3" TO 4" DEPTH
PRIOR TO
COMPACTION OF
BRICKBATS

DENUDED EARTH

STANDARDS AND SPECIFICATIONS

CONSTRUCTION SPECIFICATIONS

3. BALES SHALL BE PLACED AT THE TOE OF A SLOPE, ON THE
CONTOUR, AND IN A ROW WITH THE ENDS OF EACH BALE TIGHTLY
ABUTTING THE ADJACENT BALES.
4. EACH BALE SHALL BE EXTENDED IN THE SOIL A MINIMUM OF 4"
AND PLACED SO THE BINDINGS ARE HORIZONTAL.
5. BALES SHALL BE SECURELY ANCHORED IN PLACE BY EITHER TWO
STAKES OR RE-BARS DRIVEN THROUGH THE BALE 12" TO 18" INTO
THE GROUND. THE FIRST STAKE IN EACH BALE SHALL BE DRIVEN
TOWARD THE PREVIOUSLY LAID BALE AT AN ANGLE TO FORCE THE BALES
TOGETHER. STAKES SHALL BE DRIVEN FLUSH WITH THE TOP OF THE
BALE.
6. STRAIN BALE DINES SHALL BE INSPECTED FREQUENTLY AND AFTER
EACH RAIN EVENT AND MAINTENANCE PERFORMED AS NECESSARY.
7. ALL BALES SHALL BE REMOVED WHEN THE SITE HAS BEEN
STABILIZED. THE TRENCH WHERE THE BALES WERE LOCATED SHALL BE
GRADED, FLUSH AND STABILIZED.

1. LENGTH - MIN. OF 50' RAMP x 30' RAMP FOR SINGLE RESIDENCE LOT.
2. WIDTH - 10" MINIMUM, SHOULD BE PLACED AT THE EXISTING ROAD TO PROVIDE A TURNING RADIUS.
3. GEOTEXTILE FABRIC (FLYER GLOTH) SHALL BE PLACED OVER THE EXISTING GROUND PRIOR TO PLACING STONE.
4. STONE - CRUSHED AGGREGATE (2" TO 3") OR RECLAIMED OR RECYCLED CONCRETE EQUIVALENT SHALL BE PLACED AT LEAST 6" DEEP OVER THE LENGTH AND WIDTH OF THE ENTRANCE.
5. SURFACE WATER - ALL SURFACE WATER FLOWING TO OR DIVERTED TOWARD CONSTRUCTION ENTRANCES SHALL BE PIPED THROUGH THE ENTRANCE. MAINTAINING POSITIVE DRAINAGE. PIPE INSTALLED THROUGH THE STABILIZED CONSTRUCTION ENTRANCE SHALL BE PROTECTED WITH A MOUNTAIN BERM WITH 5:1 SLOPES AND MIN. OF 8" OF STONE OVER THE PIPE. PIPE SHALL BE TO BE SIZED ACCORDING TO THE DRAINAGE. WHEN THE SIZ IS LOCATED AT A HIGH SPOT AND HAS NO DRAINAGE TO CONVEY, A PIPE WILL NOT BE NECESSARY. PIPE SHALL BE SIZED ACCORDING TO THE AMOUNT OF RUNOFF TO BE CONVEYED. A 6" MIN. WILL BE REQUIRED.
6. LOCATION - A STABILIZED CONSTRUCTION ENTRANCE SHALL BE LOCATED AT THE POINT WHERE CONSTRUCTION TRAFFIC ENTERS OR LEAVES A CONSTRUCTION SITE. VEHICLES LEAVING THE SITE MUST TRAVEL OVER THE ENTIRE LENGTH OF THE STABILIZED CONSTRUCTION ENTRANCE.
7. MAINTENANCE - THE ENTRANCE SHALL BE MAINTAINED IN CONDITION WHICH WILL PREVENT TRACKING OR FLOoding OF SEDIMENT ONTO PUBLIC RIGHTS-OF-WAY THIS MAY REQUIRE PERIODIC TOP DRESSING WITH ADDITIONAL STONE AS CONDITIONS DEMAND AND REPAIR AND/OR FOR CLEANOUT OF ANY MEASURES THAT MAY BE USED TO REMOVE SEDIMENT SPILLED, EXPOSED, WASHED OR TRACKED ONTO PUBLIC RIGHTS-OF-WAY MUST BE REMOVED IMMEDIATELY.
8. WASHING - WHEELS SHALL BE CLEANED TO REMOVE SEDIMENT PRIOR TO ENTRANCE ONTO PUBLIC RIGHT-OF-WAY WHEN WASHING IS REQUIRED. IT SHALL BE THE RESPONSIBILITY OF THE CONTRACTOR WITH STONE WHICH DRAINS INTO A APPROVED SEDIMENT TRAPPING DEVICE.
9. PERIODIC INSPECTION AND NEEDED MAINTENANCE SHALL BE PROVIDED AFTER THE CONSTRUCTION IS COMPLETED.

1. THE CONTRACTOR SHALL CONDUCT OPERATIONS AND MAINTAIN THE PROJECT SITE SO AS TO MINIMIZE THE CREATION AND DISPERSION OF DUST. DUST CONTROL SHALL BE USED THROUGHOUT THE WORK AT THE SITE.
2. THE CONTRACTOR MUST PROVIDE CLEAN WATER, FREE FROM SALT, OIL AND OTHER DELETERIOUS MATERIAL, TO BE USED FOR ON-SITE DUST CONTROL.
3. THE CONTRACTOR SHALL SUPPLY WATER SPRAYING EQUIPMENT CAPABLE OF ACCESSING ALL THE AREAS.
4. THE CONTRACTOR SHALL IMPLEMENT STRICT DUST CONTROL MEASURES DURING ACTIVE CONSTRUCTION PHASES ON-SITE. THESE CONTROL MEASURES WILL GENERALLY CONSIST OF WATER APPLICATIONS THAT SHALL BE APPLIED A MINIMUM OF ONCE PER DAY DURING DRY WEATHER OR MORE OFTEN AS REQUIRED TO PREVENT DUST EMISSIONS.
5. FOR WATER APPLICATION TO UNDISTURBED SOIL SURFACES, THE CONTRACTOR SHALL:
 - A. APPLY WATER WITH EQUIPMENT CONSISTING OF TANK, SPRAY BAR/PUMP WITH DISCHARGE GAUGE.
 - B. ARRANGE SPRAY BAR HEIGHT, NOZZLE SPACING AND SPRAY PATTERN TO PROVIDE COMPLETE COVERAGE OF GROUND WITH WATER.
 - C. DISPERSE WATER THROUGH NOZZLES ON SPRAY BAR AT 20 PS (13.8bpsi), MINIMUM. KEEP AREAS DAMP WITHOUT CREATING NUSSANCE CONDITIONS SUCH AS PONDING.
6. FOR WATER APPLICATION TO SOIL SURFACES DURING DEMOLITION AND/OR EXCAVATION, THE CONTRACTOR SHALL:
 - A. APPLY WATER WITH EQUIPMENT CONSISTING OF A TANK, PUMP WITH DISCHARGE GAUGE, HOSES AND MIST NOZZLES.
 - B. LOCATE TANK AND SPRAYING EQUIPMENT SO THAT THE ENTIRE EXCAVATION AREA CAN BE MISTED WITHOUT INTERFERING WITH DEMOLITION AND/OR EXCAVATION EQUIPMENT OR OPERATIONS. KEEP AREAS DAMP WITHOUT CREATING NUSSANCE CONDITIONS SUCH AS PONDING.
 - C. APPLY WATER TO EXCAVATION IN A MANNER TO PREVENT MOVEMENT OF SPRAY GROUND. THE SITE SHOULD BE MISTED THROUGHOUT THE DEMOLITION AND/OR EXCAVATION PHASES.

RECEIVED
D.C. OFFICE OF ZONING
2012 MAY 16 PM 2:34

Issue Date:		
Revisions		
No.	Date	Description
1		
2		

NEW RESIDENCE
451 S STREET N.W.
UNIT-A AND UNIT-B
WASHINGTON,DC 20001
SQUARE E475 LOT 22

Project Number:	Drawn By:
Designed By:	Checked By:
Sheet Title: EROSION & SEDIMENT CONTROL DETAILS 1	
Sheet Number:	

C-1



RECEIVED
D.C. OFFICE OF ZONING
2012 MAY 16 PM 2:34

Issue Date	Revisions
No.	Date
1	
2	

NEW RESIDENCE
2000 N.W. 15th Street
UNIT B
AND A-11N
S 15th
LOT 22
E 475
SQUARES

Project Number: Drawn By:
Designed By: Checked By:

Sheet Title:
EROSION & SEDIMENT
CONTROL DETAILS 2

Sheet Number:
C-2

SILT BAG FOR PUMPED DIRTY WATER

I. INSTALLATION/USE

1. UNFOLD THE SILT BAG AND SET INSIDE THE FABRICATED BOX (WOOD, METAL, OR PLASTIC).
2. INSERT PUMP DISCHARGE HOSE INTO HANDY SEWN-IN SPOUT AND SECURE WITH THE ATTACHED STRAPS.
3. CONNECT OUTFALL PIPE OR HOSE TO THE OUTLET PIPE OF BOX AND RUN TO THE NEAREST CATCH BASIN.
4. PUMP DIRTY WATER INTO BAG. THE BAG COLLECTS THE SILT AS THE CLEAN WATER GENTLY FILTERS OUT FROM ALL SIDES.


II. MAINTENANCE

1. REPLACE THE SILT BAG AFTER IT IS FILLED WITH SILT.

SILT BAG FOR PUMPED DIRTY WATER

II. SPECIFICATIONS FOR SILT BAG 10'x15'(3.05 m x 4.57 m), 12 1/2'x15', (3.81 m x 4.54 m), AND 15'x15' (4.54 m x 4.54 m) SIZES.

PROPERTIES	TEST METHOD	UNITS / METRIC	WOVEN
WEIGHT	ASTM D-3776	OZ./YD.	8 (271.8)
GRAB TENSIL	ASTM D-4632	LBS.	300 (136.4)
PUNCTURE	ASTM D-4833	LBS.	120 (54.5)
FLOW RATE	ASTM D-4481	GAL./MIN./FT ²	40 (1622.7)
PERMITTIVITY	ASTM D-4991	"SEC.	0.55
UV RESISTANCE	ASTM D-4355	%	80

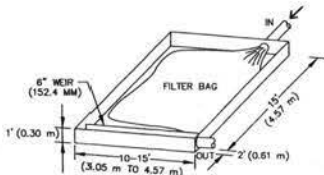

SILT FENCE

SILT FENCE DESIGN CRITERIA

SLOPE STEEPNESS	(MAXIMUM) SLOPE LENGTH	(MAXIMUM) SILT FENCE LENGTH
FLATTER THAN 50:1	UNLIMITED	UNLIMITED
50:1 TO 10:1	125 FT.	1,000 FT.
10:1 TO 5:1	100 FT.	750 FT.
5:1 TO 3:1	60 FT.	500 FT.
3:1 TO 2:1	40 FT.	250 FT.
2:1 AND STEEPER	20 FT.	125 FT.

NOTE: IN AREAS OF LESS THAN 2% SLOPE AND SANDY SOILS (USDA GENERAL CLASSIFICATION SYSTEM SOIL CLASS A) MAXIMUM SLOPE LENGTH AND SILT FENCE LENGTH WILL BE UNLIMITED. IN THESE AREAS SILT FENCE MAY BE THE ONLY PERIMETER CONTROL REQUIRED.




CONSTRUCTION SPECIFICATIONS

1. FENCE POST SHALL BE A MINIMUM OF 36" LONG DRIVEN 16" MINIMUM INTO THE GROUND. WOOD POST SHALL BE 1 1/2" SQUARE (MINIMUM) CUT, OR 1 3/4" DIAMETER (MINIMUM) ROUND AND SHALL BE OF SOUND QUALITY HARDWOOD. STEEL POST WILL BE STANDARD T OR U SECTION WEIGHING NOT LESS THAN 1.00 POUND PER LINEAR FOOT.
2. GEOTEXTILE SHALL BE FASTENED SECURELY TO EACH FENCE POST WITH WIRE TIES OR STAPLES AT TOP AND MID-SECTION AND SHALL MEET THE FOLLOWING REQUIREMENTS FOR GEOTEXTILE CLASS F:




TENSILE STRENGTH	50 LBS./IN. (MIN)	TEST: MSMT 509
TENSILE MODULUS	20 LBS./IN. (MIN.)	TEST: MSMT 509
FLOW RATE	0.3 GAL./FT ² /MIN.(MAX)	TEST: MSMT 322
FILTERING EFFICIENCY	75% (MIN.)	TEST: MSMT 322

3. WHERE ENDS OF GEOTEXTILE FABRIC COME TOGETHER, THEY SHALL BE OVERLAPPED, FOLDED AND STAPLED TO PREVENT SEDIMENT BYPASS.
4. SILT FENCE SHALL BE INSPECTED AFTER EACH RAINFALL EVENT AND MAINTAINED WHEN BULGES OCCUR OR WHEN SEDIMENT ACCUMULATION REACHES 50% OF THE FABRIC HEIGHT.

  SILT FENCE DETAIL

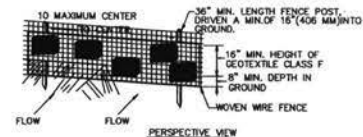

DETAIL 23B - AT GRADE INLET PROTECTION

  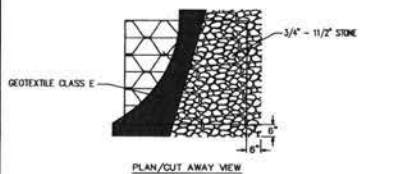

CONSTRUCTION SPECIFICATIONS


1. LIFT GRATE AND WRAP WITH GEOTEXTILE CLASS E TO COMPLETELY COVER ALL OPENINGS THEN SET GRATE BACK IN PLACE.
2. PLACE 3/4" TO 1 1/2" STONE, 4"-6" THICK ON THE GRATE TO SECURE THE FABRIC AND PROVIDE ADDITIONAL FILTRATION.

CURB INLET PROTECTION NOTES


CONSTRUCTION SPECIFICATIONS

1. ATTACH A CONTINUOUS PIECE OF WIRE MESH 30" MIN. WIDTH BY THROAT LENGTH PLUS 4" TO THE 2"x4" WEIR (MEASURING THROAT LENGTH) PLUS 2" AS SHOWN ON THE STANDARD DRAWING.
2. PLACE A CONTINUOUS PIECE OF GEOTEXTILE CLASS E THE SAME DIMENSIONS AS THE WIRE MESH OVER THE WIRE MESH AND SECURELY ATTACH IT TO THE 2"x4" WEIR.
3. SECURELY NAIL THE 2"x4" WEIR TO A 9" LONG VERTICAL SPACER TO BE LOCATED BETWEEN THE WEIR AND THE INLET FACE (MAX. 4" APART).
4. PLACE THE ASSEMBLY AGAINST THE INLET THROAT AND NAIL (MIN. 2' LENGTHS OF 2"x4" TO THE TOP OF THE WEIR AT SPACER LOCATIONS). THE 2"x4" ANCHORS SHALL EXTEND ACROSS THE INLET TOP AND BE HELD IN PLACE BY SANDBAGS OR ALTERNATE WEIGHT.
5. THE ASSEMBLY SHALL BE PLACED SO THAT THE END SPACERS ARE A MIN. 1' (0.31 m) BEYOND BOTH ENDS OF THE THROAT OPENING.
6. FORM THE 1/2"x1/2" WIRE MESH AND THE GEOTEXTILE FABRIC TO THE CONCRETE GUTTER AND AGAINST THE FACE OF THE CURB ON BOTH SIDES OF THE INLET. PLACE CLEAN 3/4"x1/2" STONE OVER THE WIRE MESH AND GEOTEXTILE IN SUCH A MANNER TO PREVENT WATER FROM ENTERING THE INLET UNDER OR AROUND THE GEOTEXTILE.
7. THIS TYPE OF PROTECTION MUST BE INSPECTED FREQUENTLY AND THE FILTER CLOTH AND STONE REPLACED WHEN CLOGGED WITH SEDIMENT.
8. ASSURE THAT STORM FLOW DOES NOT BYPASS THE INLET BY INSTALLING A TEMPORARY EARTH OR ASPHALT DIKE TO DIRECT FLOW TO THE INLET.

CURB INLET PROTECTION (COG OR COS INLETS)

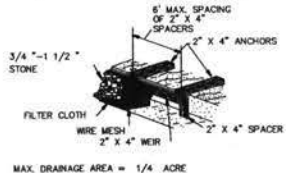

MAX. DRAINAGE AREA = 1/4 ACRE

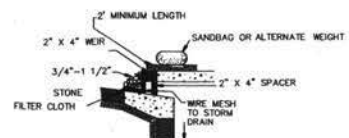

STREET SWEEPING

1. STREETS WITHIN ONE MILE (1.6km) SHALL BE INSPECTED DAILY, ANY DROPPED SOIL, DUST AND/OR DEBRIS SHALL BE REMOVED.
2. VACUUM TYPE STREET CLEANER SHALL BE USED TO EFFECTIVELY REMOVE TOTAL DUST AND DIRT ON PAVED SURFACES.
3. ROADS SHALL BE SWEEPED ON A WEEKLY BASIS (MINIMUM) DURING ALL ON AND OFF SITE HAULING OPERATIONS FOR UP TO ONE MILE (1.6km) ALONG HAUL ROUTES.

SEDIMENT AND EROSION CONTROL MEASURES SHALL BE INSTALLED BEFORE THE START OF ANY EXCAVATION AND/OR CONSTRUCTION AS PER STANDARDS AND SPECIFICATIONS FOR SOIL EROSION AND SEDIMENT CONTROL FOR THE DISTRICT OF COLUMBIA. IF AN ON-SITE INSPECTION REVEALS FURTHER EROSION CONTROL MEASURES ARE NECESSARY, THE SAME SHALL BE PROVIDED.

8. ALLEY AND/OR STREETS/SIDEWALKS SHALL BE SWEEPED CLEAN AT ALL TIMES DURING DEMOLITION, EXCAVATION AND CONSTRUCTION.

5. IF ANY CATCH BASINS OR DRAINS BECOME CLOGGED AS A RESULT OF DEMOLITION, EXCAVATION OR CONSTRUCTION THE CONTRACTOR SHALL BE RESPONSIBLE FOR ITS CLEANING.

ANY STOCKPILING, REGARDLESS OF LOCATION SHALL BE STABILIZED WITHIN SEVEN DAYS AND COVERED WITH PLASTIC OR CANVAS, AFTER ITS ESTABLISHMENT AND FOR DURATION OF THE PROJECT.

THE SITE'S APPROVAL LETTER, APPROVED EROSION AND SEDIMENT CONTROL PLANS, DAILY LOG BOOKS AND TEST REPORTS SHALL BE AVAILABLE AT THE SITE FOR INSPECTION BY AUTHORIZED OFFICIALS OF DCRA RESPONSIBLE FOR PROJECT.

11. VEGETATIVE STABILIZATION SHALL BE PERFORMED IN ACCORDANCE WITH THE DORA STANDARDS AND SPECIFICATIONS FOR SOIL EROSION AND SEDIMENT CONTROL. REFER TO APPROPRIATE SPECIFICATIONS FOR TEMPORARY SEEDING, PERMANENT SEEDING, MULCHING, SODDING AND GROUND COVERS.

2. SEDIMENT REMOVED FROM TRAPS (AND BASINS) SHALL BE PLACED AND STABILIZED IN APPROVED AREAS, BUT NOT WITHIN A FLOODPLAIN, WETLAND OR TREE-SAVE AREA. WHEN PUMPING SEDIMENT LADEN WATER, THE DISCHARGE MUST BE DIRECTED TO A SEDIMENT TRAPPING DEVICE PRIOR TO RELEASE FROM THE SITE. A SUMP PIT MAY BE USED IF SEDIMENT TRAPS THEMSELVES ARE BEING PUMPED OUT.

14. SEDIMENT CONTROL FOR UTILITY CONSTRUCTION FOR AREAS OUTSIDE OF
DESIGNED CONTROLS OR AS DIRECTED BY ENGINEER OR DORA INSPECTOR:

(B) EXCAVATED TRENCH MATERIAL SHALL BE PLACED ON THE HIGH SIDE OF THE TRENCH.

(D) TEMPORARY SILT FENCE SHALL BE PLACED IMMEDIATELY DOWNSTREAM OF ANY DISTURBED AREA INTENDED TO REMAIN DISTURBED FOR MORE THAN ONE DAY.

OFF-SITE SPOIL, WASTE, OR BORROW AREAS IN THE DISTRICT OF COLUMBIA
MUST HAVE PRIOR APPROVAL BY DCRA. ALL WASTE AND BORROW AREAS

MEASURES OFF-SITE MUST BE PROTECTED BY SEDIMENT CONTROL STABILIZED IN ACCORDANCE WITH THE ORDINANCES OF REGULATIONS OF THE JURISDICTION WHERE THE SPOIL, WASTE, OR BORROW AREA IS LOCATED/STABILIZED.

TOTAL AREA OF SITE	0.0179	ACRES
AREA DISTURBED	0.016	ACRES
BUILDING AREA	0.0137	ACRES
IMPERVIOUS AREA	0.0086	ACRES
TOTAL CUT	0.071	CU. YDS.
TOTAL FILL	0	CU. YDS.

OFFSITE WASTE/BORROW AREA LOCATION	TO BE SUBMITTED BY CONTRACTOR FOR APPROVAL
---------------------------------------	---

PERMANENT OR TEMPORARY STABILIZATION SHALL BE COMPLETED WITHIN (A) SEVEN CALENDAR DAYS AS TO THE SURFACE OF ALL SEDIMENT CONTROL PRACTICES SUCH AS DIVERSIONS, GRADE STABILIZATION STRUCTURES, BERMS, DIKES, GRASSED WATERWAYS, SEDIMENT BASINS, PERIMETER SLOPES, AND ALL SLOPES GREATER THAN 3 HORIZONTAL TO 1 VERTICAL (3:1) AND (B) FOURTEEN DAYS AS TO ALL OTHER DISTURBED OR GRADED AREAS ON THE PROJECT SITE.

THE TOP LAYER OF SOIL SHALL BE LOOSENED, LIMED AND FERTILIZED BY RAKING DISCHING OR HARROWING OR OTHER ACCEPTABLE MEANS BEFORE SEEDING. FLAT AREAS AND SLOPES UP TO 3 TO 1 GRADE SHALL BE LOOSE AND FRIABLE TO A DEPTH OF AT LEAST 3 INCHES. SLOPES STEEPER THAN 3 TO 1 SHALL HAVE THE TOP 1-3 INCHES OF SOIL LOOSE AND FRIABLE BEFORE SEEDING. APPLY SEED UNIFORMLY WITH A CYCLONE SEEDER, DRILL CULTIPACKER, SEEDER OR HYDRO-SEEDER ON A FIRM MOIST SEEDER.

LIME AND FERTILIZE ACCORDING TO SOIL TESTS. IN LIEU OF SOIL TEST APPLY THE FOLLOWING:

FERTILIZER 1 TON PER ACRE OR 46 LB/1,000
(TEMPORARY) 10-10-10 OR EQUIVALENT AT
1,000 LBS PER ACRE OR 23 LBS PER
1,000 SQ. FT. (PERMANENT AND SODDING)

SEED: *KENTUCKY 31* TALL FESCUE AT 60 LBS/ACRE OR 1.38 LBS/1,000 SQ. FT AND ITALIAN (ANNUAL) RYEGRASS AT 40 LBS/ACRE OR .91 LBS/1,000 SQ. FT.

DATES: 1/2 - 4/30 5/1 - 8/14 WITH IRRIGATION, 8/15 - 10/31

SEED: ITALIAN OR PERENNIAL RYEGRASS AT 40 LBS/ACRE
OR .92 LBS/1,000 SQ. FT.

DATES: 2/1 - 4/30 AND 8/15 - 11/30
SEED: MILLET AT 40 LBS/ACRE OR .92 LBS/1,000 SQ. FT.
DATES: 5/1 - 8/14

A. RESIDENTIAL AND HIGH MAINTENANCE AREAS

1. KENTUCKY BLUEGRASS, "PLUSH", "BIRKA", "PARADE", "VANTAGE", "COLUMBIA", "MERION", "ADELPHI", "SOUTH DAKOTA", "KENBLUE". ANY THREE VARIETIES AT 30 LBS. TO MAKE 90 LBS./ACRE OR 2 LBS./1,000 SQ.FT. AND RED FESCUE - "PENNLAWN" OR JAMESTOWN AT 10 LBS./1000 SQ.FT.

DATES: 2/1 - 4/30 AND 8/15 - 10/31.

KENTUCKY 31 TALL FESCUE AT
40 LBS/ACRE OR 0.92 LBS/1,000 SQ. FT.
AND *INTERSTATE* SERICEA LESPEDEZA AT
(INOCULATED) 20 LBS/ACRE OR 0.46 LBS/1,000 SQ. FT.

DATES: 2/1 - 4/30 AND 8/15 - 10/31

"KENTUCKY 31" TALL FESCUE AT
60 LBS./ACRE OR 1.38 LBS./1,000 SQ.FT.

ALL SEEDINGS REQUIRE MULCHING. USE MULCH ONLY DURING NON-SEEDING DATES UNTIL SEEDING CAN BE ACCOMPLISHED.

MULCH SHALL BE 2 TONS/ACRE, UNCHOPPED SMALL GRASS STRAW APPLIED AT A RATE OF 1 TO 2 TONS/ACRE OR 70-90 LBS/1,000 SQ. FT. (2 BALES) MULCH MATERIALS SHALL BE RELATIVELY FREE OF ALL KINDS OF WEED SEEDS AND SHALL BE FREE OF PROHIBITED NOXIOUS WEEDS. SPREAD MULCH UNIFORMLY, MECHANICALLY, OR BY HAND. MULCH ANCHORING TOLL SHALL BE ACCOMPLISHED IMMEDIATELY AFTER MULCH PLACEMENT TO MINIMIZE LOSS BY WIND OR WATER. THIS MAY BE DONE BY MULCH NETTING, MULCH ANCHORING TOLL, PEG AND TWIN OR LIQUID BINDERS. LIQUID MULCH BINDERS SHALL BE RAPID CURING CUTBACK ASPHALT AT A RATE OF 200 GAL/ACRE OR 5 GAL. PER 1,000 SQ. FT. SLOPES 8 FEET OR MORE HIGH USE 348 GAL/ACRE OR 8 GAL./1,000 SQ. FT.

CLASS OF TURFGRASS SOD SHALL BE MARYLAND OR VIRGINIA STATE CERTIFIED OR MARYLAND OR VIRGINIA STATE APPROVED SOD. SOD SHALL BE HARVESTED, DELIVERED AND INSTALLED WITHIN A PERIOD OF 36 HOURS. SOD IS TO BE LAID WITH THE LONG EDGES PARALLEL TO THE CONTOUR WITH STAGGERED JOINTS WITH ALL ENDS TIGHTLY ABUTTING AND NOT OVERLAPPING. SOD SHALL BE ROLLED AND THOROUGHLY WATERED WITHIN EIGHT HOURS OF INSTALLATION. DAILY WATERING TO MAINTAIN A 4 INCH DEPTH OF MOISTURE FOR THE FIRST WEEK IS REQUIRED IN THE ABSENCE OF RAINFALL. SOD IS NOT TO BE APPLIED ON FROZEN GROUND.

A. IRRIGATION - WHEN SOIL MOISTURE BECOMES DEFICIENT, IRRIGATE TO PREVENT LOSS OF STAND OF PROTECTIVE VEGETATION.

B. REPAIRS - IF STAND IS INADEQUATE FOR EROSION CONTROL, OVERSEED AND FERTILIZE USING HALF OF THE RATES ORIGINALLY APPLIED. IF STAND IS OVER 60% DAMAGED, REESTABLISH FOLLOWING ORIGINAL RATES AND PROCEDURES.

NOTE: USE OF THIS INFORMATION DOES NOT PRECLUDE MEETING ALL OF THE REQUIREMENTS OF THE 1987 DISTRICT OF COLUMBIA DEPARTMENT OF CONSUMER AND REGULATORY AFFAIRS STANDARDS AND SPECIFICATIONS FOR SOIL EROSION AND SEDIMENT CONTROL VEGETATIVE PRACTICES.

1. ALL EROSION AND SEDIMENT CONTROL MEASURES SHALL BE PLACED PRIOR TO OR AS THE FIRST STEP IN GRADING.

- ARCHITECTS
RAOUL USSABET, A.I.A.
ARCHITECTS, LLC

19021 SEDLEY TERRACE
GAITHERSBURG, MARYLAND 20879
Tel: (301) 948-3197
E-Mail: rissabet1@comcast.net



RECEIVED
D.C. OFFICE OF ZONING
2012 MAY 16 PM 2:35

Issue Date: _____

Revisions		
No.	Date	Description
1		
2		

NOTE: USE OF THIS INFORMATION DOES NOT PRECLUDE MEETING ALL OF THE REQUIREMENTS OF THE 1987 DISTRICT OF COLUMBIA DEPARTMENT OF CONSUMER AND REGULATORY AFFAIRS STANDARDS AND SPECIFICATIONS FOR SOIL EROSION AND SEDIMENT CONTROL VEGETATIVE PRACTICES.

NEW RESIDENCE
451 S STREET N.W.
UNIT-A AND UNIT-B
WASHINGTON, DC 20001

Project Number:	Drawn By:
-----------------	-----------

Designed By:	Checked By:
--------------	-------------

Sheet Title:


EROSION & SEDIMENT CONTROL DETAILS

Sheet Number:

C-3

RECEIVED
N.C. OFFICE OF ZONING

2012 MAY 16 PM 2:35

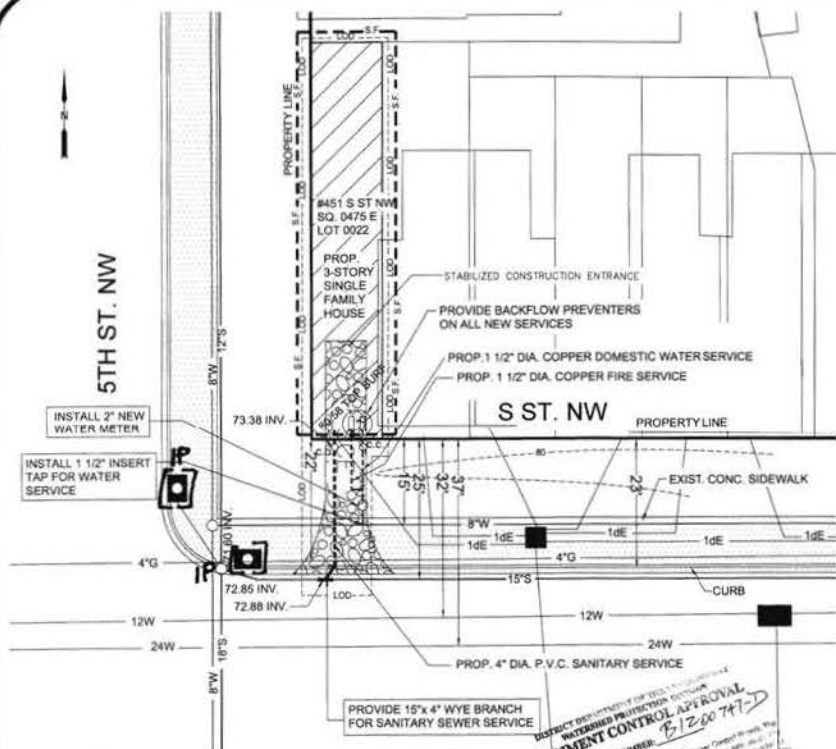

SITE INFORMATION


TOTAL AREA OF SITE	840 SQ. FT.
AREA OF DISTURBANCE	1,164 SQ. FT.
BUILDING AREA	840 SQ. FT.
TOTAL CUT	248.88 CU. YDS.
TOTAL FILL	0 CU. YDS.

SITE DESCRIPTION
PRESENT SITE CONDITION IS EXCELLENT WITH GOOD DRAINAGE AND VEGETATION FOR SOIL STABILIZATION. THE SITE IS VACANT TODAY. THE CONTRACTOR WILL NOT CHANGE PRESENT NATURAL DRAINAGE WHICH WILL ALLOW FOR MINIMUM SOIL EROSION MEASURES.



PLAN
SCALE: 1" = 10'
0 5 10 FT


STORMWATER CONTROL APPROVAL
PLAN NUMBER: 612-00747-2
NOTICE: This approval is for the existing final landscape Control No. 10. The applicant is required to maintain design features as shown. Any change to the design without written approval from the City Engineer will result in the design being void. The applicant is responsible for obtaining all necessary permits from the City Engineer. Approved by: [Signature] Date: 6/12/12

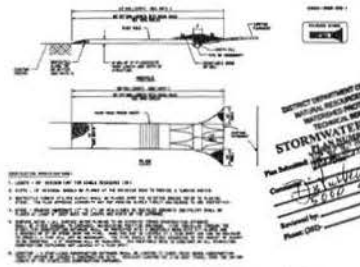


STABILIZED CONSTRUCTION ENTRANCE




LOCATION MAP

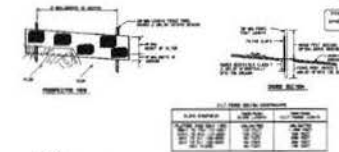

SILT FENCE

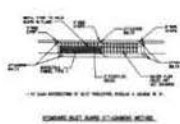

AT GRADE INLET GUARD

 


LEGEND




SEQUENCE OF CONSTRUCTION
1. ALL EXISTING UTILITIES SHALL BE LOCATED AND MARKED PRIOR TO ANY CONSTRUCTION.
2. ALL EXISTING UTILITIES SHALL BE DEEPER THAN THE NEW CONSTRUCTION.
3. ALL EXISTING UTILITIES SHALL BE DEEPER THAN THE NEW CONSTRUCTION.
4. ALL EXISTING UTILITIES SHALL BE DEEPER THAN THE NEW CONSTRUCTION.
5. ALL EXISTING UTILITIES SHALL BE DEEPER THAN THE NEW CONSTRUCTION.

SEDIMENT CONTROL NOTES
1. ALL SEDIMENT CONTROL MEASURES SHALL BE INSTALLED BEFORE THE START OF ANY CONSTRUCTION AND MAINTAINED THROUGHOUT THE CONSTRUCTION PERIOD. IF AN IN-SITU SEDIMENT CONTROL MEASURE IS REQUIRED, THE SAME SHALL BE PROVIDED.
2. ALL SEDIMENT CONTROL MEASURES SHALL BE MAINTAINED THROUGHOUT THE CONSTRUCTION PERIOD.
3. ALL SEDIMENT CONTROL MEASURES SHALL BE MAINTAINED THROUGHOUT THE CONSTRUCTION PERIOD.
4. ALL SEDIMENT CONTROL MEASURES SHALL BE MAINTAINED THROUGHOUT THE CONSTRUCTION PERIOD.
5. ALL SEDIMENT CONTROL MEASURES SHALL BE MAINTAINED THROUGHOUT THE CONSTRUCTION PERIOD.

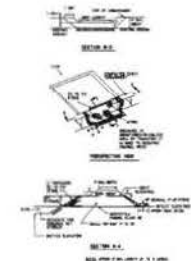

STONE / RIP-RAP - OUTLET SEDIMENT TRAP

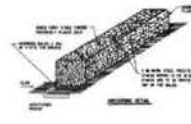

STRAW BALE DIKE



LEGEND

No.	Revision/Issue	Date
First Name and Surname David L. Smith		
Project Name and Address NEW WATER & SEWER SERVICE SOIL EROSION PLAN #451 S ST. NW		
Project	Sheet	
Date	January 10, 2012	ER-1
Scale	AS SHOWN	

THIS DRAWING TO BE USED FOR PERMIT PURPOSES ONLY.



[Signature]

RECEIVED
D.C. OFFICE OF ZONING
2012 MAY 16 PM 2:35

Issue Date	Revisions
No. Date	Description
1	
2	

NEW RESIDENCE
S STREET N.W.
AND UNIT-B
154
WASHINGTON, DC 20001

Project Number: Drawn By:
Designed By: Checked By:
Sheet Title:
EROSION & SEDIMENT
CONTROL DETAILS
Sheet Number:

EC-1

CIVIL NARRATIVE

THIS PLAN INCLUDES THE EROSION AND SEDIMENT CONTROL FOR THE CONSTRUCTION OF A 2 UNIT DWELLING @ 451 S ST. N.W. WASHINGTON DC. THE PRESENT SITE IS A VACANT FLAT LOT WITH NO CONTOURS (VERY FLAT). MINIMUM EXCAVATION WILL BE PERFORMED AS THE LOT IS A VERY SMALL LOT OF TOTAL 844 SQFT. THIS PROJECT WILL ALSO INCLUDE THE INSTALLATION OF SANITARY WATER, SEWER, GAS AND ELECTRIC SERVICES WHICH WILL BE PERFORMED UNDER CUT AND COVER INSTRUCTIONS PER DCRA AND DDOT SPECIFICATIONS. THIS SITE WILL BE SEEDED AND STABILIZED WITH THOSE AREAS RETURNING TO 100% PREVIOUS AT COMPLETION. REFER TO DRAWINGS SET FOR SPECIFICATION SECTION SUMMARY OF ADDITIONAL PROJECT NARRATIVES.

PROJECT SEQUENCE OF CONSTRUCTION

1. OBTAIN ALL REQUIRED BUILDING AND PUBLIC SPACE PERMITS
2. THE CONTRACTOR MUST NOTIFY DCRA-DDOE AT LEAST 48 HOURS PRIOR TO THE START OF CONSTRUCTION
3. THE LIMITS OF DISTURBANCE MUST BE FIELD MARKED PRIOR TO THE INSTALLATION OF SEDIMENT CONTROL MEASURES. CONSTRUCTION OR OTHER LAND DISTURBING ACTIVITIES.
4. INSTALL PERIMETER SEDIMENT AND EROSION CONTROL MEASURES.
5. THE STRUCTURE WILL BE BUILT ACCORDING TO PROJECT PLANS IN SEQUENCE TO FLOOR, WALLS AND TOP FASHION.
6. REFER TO EROSION AND SEDIMENT CONTROL DETAILS SHEET FOR DUST CONTROL REQUIREMENTS.
7. ALL EROSION AND SEDIMENT CONTROLS SHALL BE CHECKED DAILY AND ADJUSTED OR REPLACED AS NECESSARY TO FULLY CONTAIN AND CONTROL SEDIMENT ON SITE.

451 S St NW, Washington, DC 20001

VICINITY MAP 451 S St NW
Washington DC

On the 1/7/12, the following map is to be used:
DISTRICT OF COLUMBIA, DISTRICT OF



S STREET, N.W.
EXISTING SITE PLAN



LOT DATA


DEVELOPED AREA: 800 SQ. FT.
VOLUME OF CUT: 3,100 SQ. FT.
VOLUME OF FILL: 0 SQ. FT.

CODE ANALYSIS

USE GROUP: R3
CONSTRUCTION TYPE: S-B
NUMBER OF STORIES: 3
LOT AREA: 844 SQ. FT.

LEGEND

EXISTING CONTOURS
PROPOSED CONTOURS
EXISTING CHAIN LINK FENCE
LIMIT OF DISTURBANCE
SILT FENCE
STABILIZED CONSTRUCTION ENTRANCE
NEW RESIDENCE
EXISTING SPOT ELEVATION

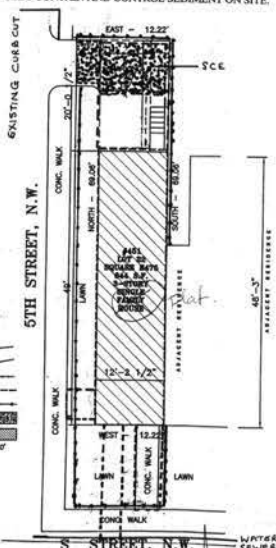

SOIL & EROSION
CONTROL PLAN

LOT DATA


DEVELOPED AREA: 800 SQ. FT.
VOLUME OF CUT: 3,100 SQ. FT.
VOLUME OF FILL: 0 SQ. FT.

CODE ANALYSIS

USE GROUP: R3
CONSTRUCTION TYPE: S-B
NUMBER OF STORIES: 3
LOT AREA: 844 SQ. FT.

LEGEND

EXISTING CONTOURS
PROPOSED CONTOURS
EXISTING CHAIN LINK FENCE
LIMIT OF DISTURBANCE
SILT FENCE
STABILIZED CONSTRUCTION ENTRANCE
NEW RESIDENCE
EXISTING SPOT ELEVATION

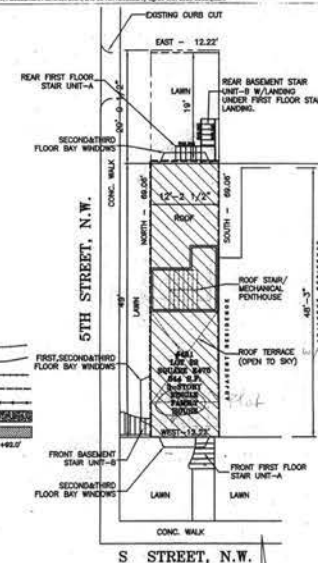

PROPOSED SITE PLAN



SR-11-00562(2011)

GENERAL NOTES

1. DO NOT SCALE FROM DRAWING.
 2. DIMENSIONS ARE FROM FACE OF STUD TO FACE OF STUD UNLESS NOTED.
 3. PROVIDE ORIGINAL BRACING AND CONCEALED WOOD BRACING AT ALL PARTITION WALLS, SUPPORT WALLS, LIGHT FIXTURES, PLUMBING FIXTURES, OR OTHER WALL MOUNTED ACCESSORIES.
 4. AT GLAZES PROVIDE 1" DEEP, 1/2" THICK WOOD SILL WITH METAL COAT NAIL.
 5. USE WOODS RESISTANT ONE WALL BRACING AND MEASUREMENT TO DIMS.
- PARTITION LEGEND**
- 1-HR. FIRE-RATED PARTITION
1-HR. SOUND-RESISTANT PARTITION
1-HR. SOUND-RESISTANT PARTITION

ARCHITECTS
RACER, LINDSEY, AIA
ARCHITECTS, LLC
1001 W. 10TH STREET
BETHESDA, MARYLAND 20814
Tel: (301) 940-1100
Email: racerl@racerl.com



RECEIVED
D.C. OFFICE OF ZONING
2012 MAY 16 PM 2:35





Rev.	Date	Revisions
1	10/21/11	DONA REVIEW COMMENTS
2	11/21/11	DONA REVIEW COMMENTS

NEW RESIDENCE
1001 36TH AVENUE
UNIT 1001
WASHINGTON, D.C. 20001
W. 10TH STREET
UNIT 1001
1001 36TH AVENUE
UNIT 1001


Project Number:	Drawn By:
Designed By:	Checked By:

Sheet Title:
FLOOR PLANS


Sheet Number:
A-1

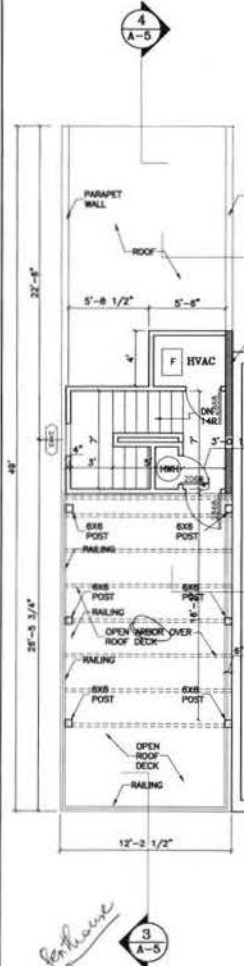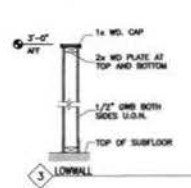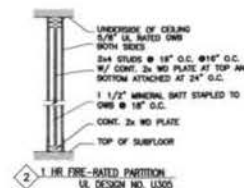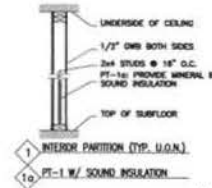


ATTIC FLOOR PLAN
SCALE: 1/4"=1'-0"
(UNIT-A)

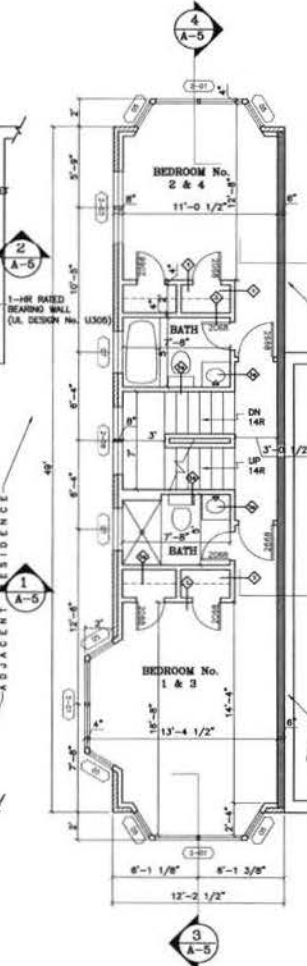


SECOND & THIRD FLOOR PLAN
SCALE: 1/4"=1'-0"
(UNIT-A)

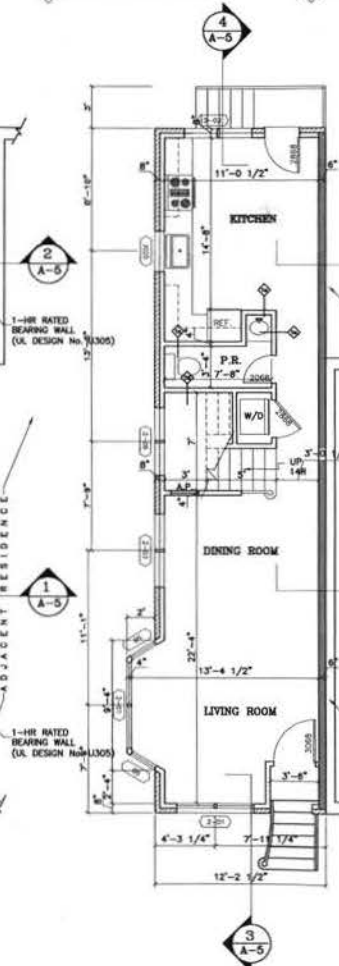

FIRST FLOOR PLAN
SCALE: 1/4"=1'-0"
(UNIT-A)

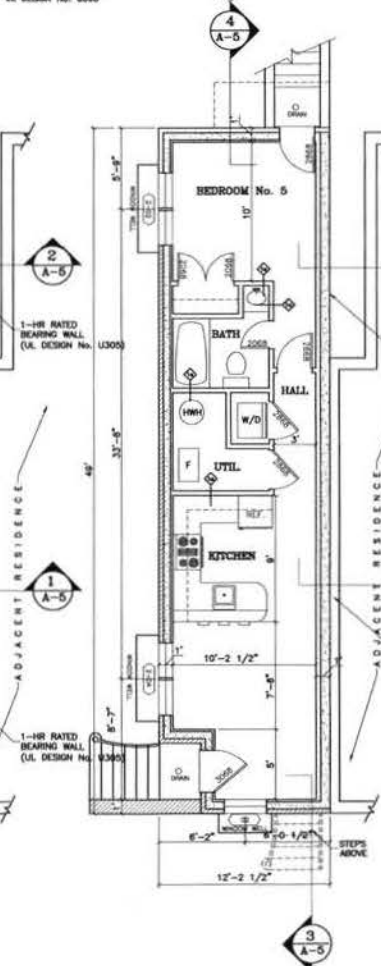

CELLAR FLOOR PLAN
SCALE: 1/4"=1'-0"
(UNIT-B)

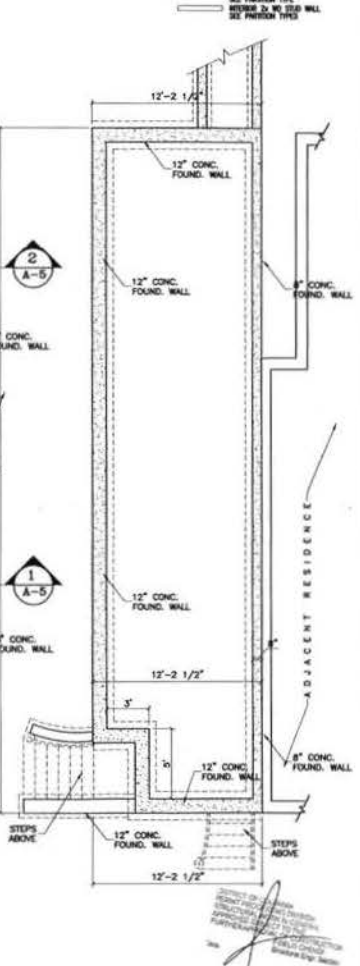

FOUNDATION PLAN
SCALE: 1/4"=1'-0"

GENERAL NOTES

1. NO NOT SCALE FROM DIMENSIONS.
2. DIMENSIONS ARE FROM FACE OF STUD TO FACE OF STUD UNLESS NOTED OTHERWISE.
3. PROVIDE SINKING, FINISHING AND CONCEALED WOOD FLOORING AT ALL PARTITION WALLS, SUPPORT WALLS, LIGHT FIXTURES, PLUMBING FIXTURES, OR OTHER WALL MOUNTED ACCESSORIES.
4. AT CLOSERS PROVIDE 1" DEEP, 1/2" PAVED WOOD SHEDS WITH 1/4" CONCRETE.
5. USE INTERIOR RESIDENCE AND WALL BATHROOMS & HALLS ADJACENT TO SHEDS.

PARTITION LEGEND

1. 1-HR. FIRE-RATED PARTITION (UL DESIGN NO. U305)
2. 1-HR. FIRE-RATED PARTITION (UL DESIGN NO. U305)
3. 1-HR. FIRE-RATED PARTITION (UL DESIGN NO. U305)

ARCHITECTS
RADOL, USSABET, A.A.
ARCHITECTS, LLC

19021 SECULEY TERRACE
CATHYBOROUGH, MARYLAND 20879
Tel: (301) 345-3137
E-Mail: radol@att.com



RECEIVED
D.C. OFFICE OF ZONING
2012 MAY 16 PM 2:35




No.	Date	Revisions
1	10/31/11	DORA REVIEW COMMENTS
2		

NEW RESIDENCE
N.W. 154
STREET AND UNIT-B
WASHINGTON, DC 20001
S 154


Project Number: Drawn By:
Designed By: Checked By:

Sheet Title: FLOOR PLANS


Sheet Number: A-1

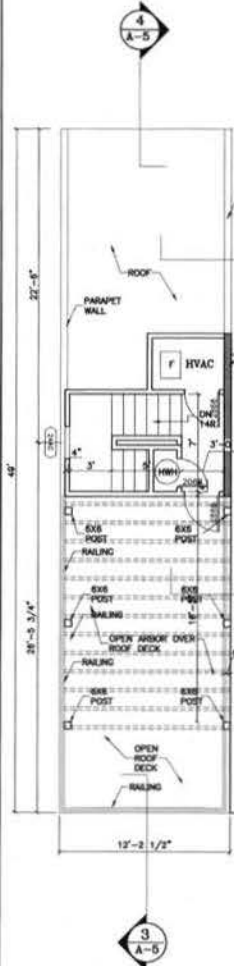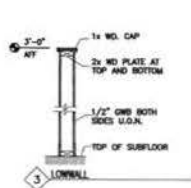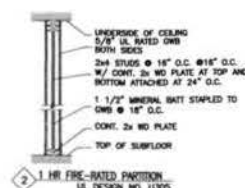


ATTIC FLOOR PLAN
SCALE: 1/4"=1'-0"
(UNIT-A)

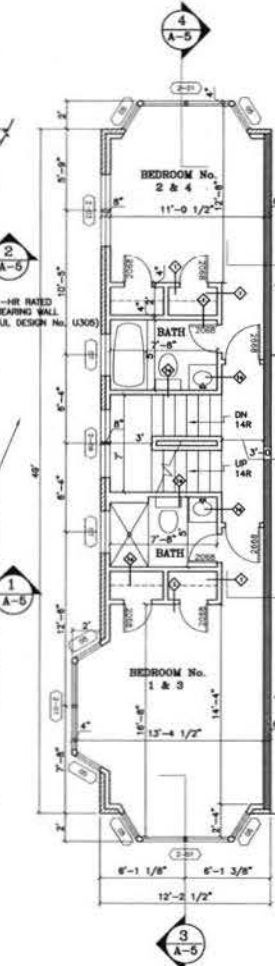


SECOND & THIRD FLOOR PLAN
SCALE: 1/4"=1'-0"
(UNIT-A)

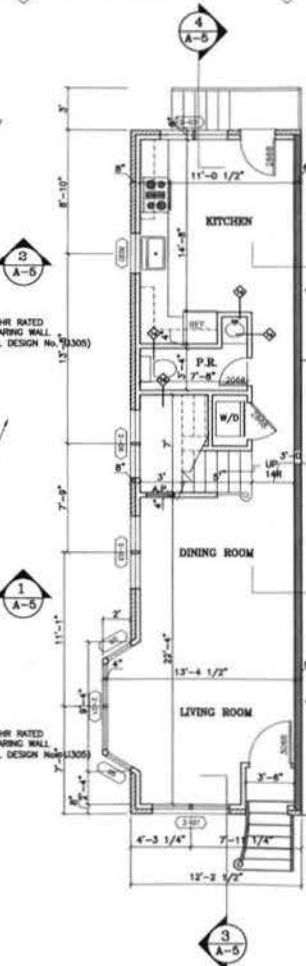



FIRST FLOOR PLAN
SCALE: 1/4"=1'-0"
(UNIT-A)

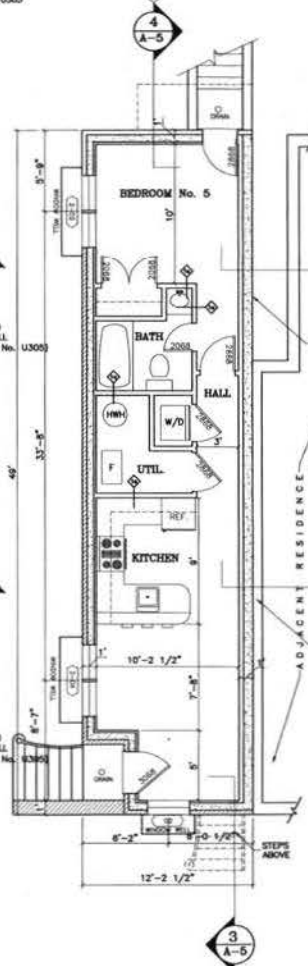

CELLAR FLOOR PLAN
SCALE: 1/4"=1'-0"
(UNIT-B)

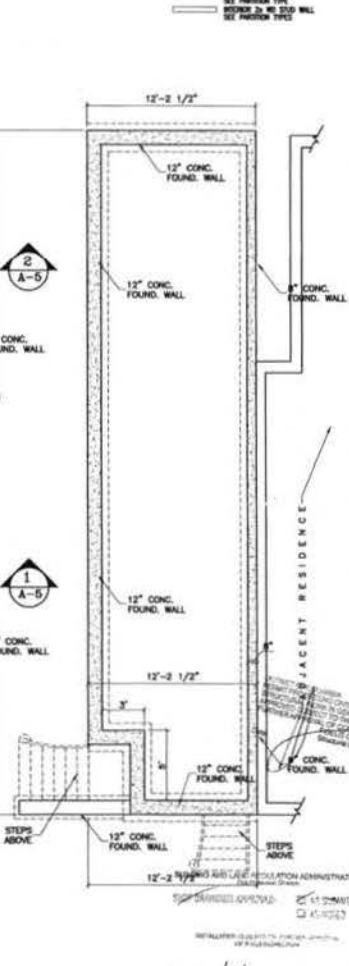

FOUNDATION PLAN
SCALE: 1/4"=1'-0"

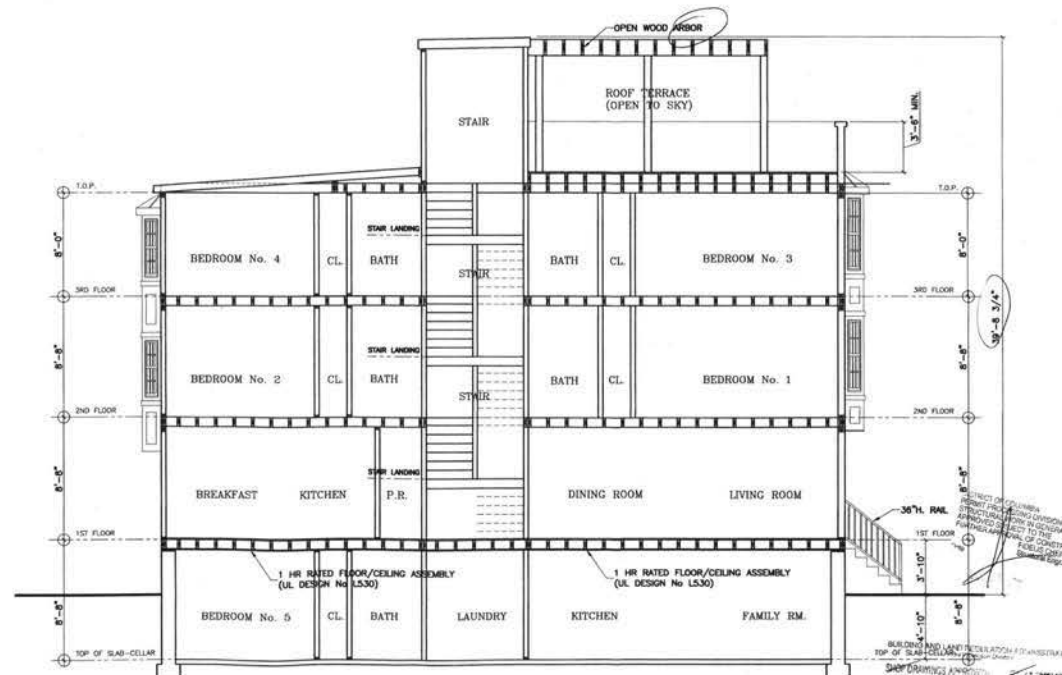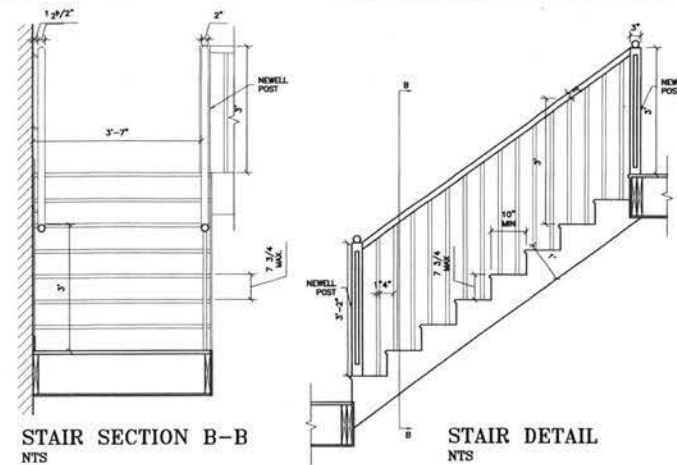

SECTION "A"
SCALE: 1/4"=1'-0"

ARCHITECTS
RAUL LISSABET, AIA
ARCHITECTS, LLC
19021 SEDLEY TERRACE
GAITHERSBURG, MARYLAND 20879
Tel: (301) 948-3197
E-Mail: rlissabet@comcast.net


RECEIVED
D.C. OFFICE OF ZONING
2012 MAY 16 PM 2:35

Issue Date: 10/31/11
Revisions:
1 10/31/11 DORA REVIEW COMMENTS
2

NEW RESIDENCE
3001 N.W. STREET
UNIT-B
WASHINGTON, DC 20001
S 154

Project Number: Drawn By:
Designed By: Checked By:
Sheet Title: SECTION DETAILS
Sheet Number: A-2a

LOT 22
E 475
SQUARE

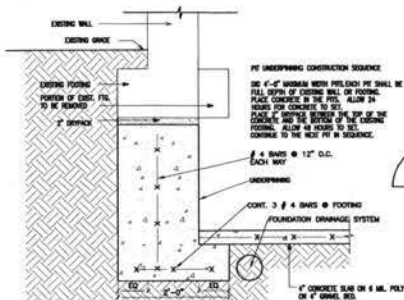


TYPICAL UNDERPINNING WALL DETAIL

SCALE: 3/8"


TYPICAL UNDERPINNING DETAIL

NOTES

1. ALL NEW DETAIL IS TYPICAL AND IS SUBJECT TO MODIFICATION AS NECESSARILY REQUIRED BY ACCORDANCE WITH THE CONSTRUCTION OF THE BUILDING. THE CONTRACTOR SHALL BE RESPONSIBLE FOR OBTAINING ALL NECESSARY PERMITS AND APPROVALS FROM THE DISTRICT OF COLUMBIA DEPARTMENT OF CONSTRUCTION PRIOR TO CONSTRUCTION FOR CONFORMANCE AS REQUIRED.

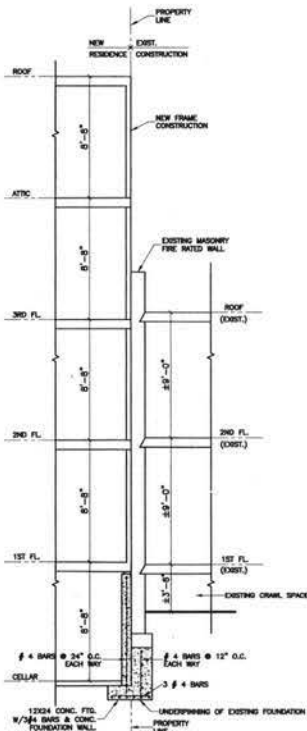

SECTION - A

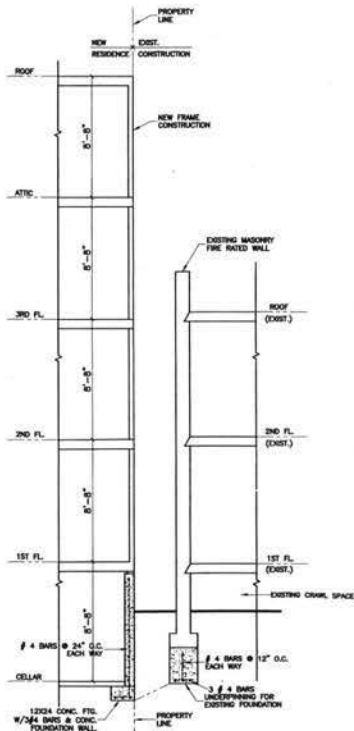

SECTION - B

UNDERPINNING NOTES

FLOOR LOADS 40 PSF

PRESUMPTIVE BEARING PRESSURE: 3,000 PSF
ACTIVE SOIL PRESSURE: 80 PSF

CONCRETE 28-DAY STRENGTH 3,500 PSI
REINFORCING STEEL: A603 GR 60

PROVIDE TEMPORARY BRACING FOR ALL FRAMING ON WALL FOOTING SEGMENTS TO BE UNDERPINNED. SHORES SHALL REMAIN IN PLACE UNTIL THE UNDERPINNING SEGMENT IS COMPLETED.

ALL SOIL EXCAVATED SEGMENTS IDENTIFIED AS UNSTABLE SHALL IMMEDIATELY BE SHORED. EXCAVATED SOIL SHALL BE REMOVED FROM THE SITE UNLESS STORED IN A MANNER NOT OBSTRUCTING THE FREE DRAINAGE OF STORM WATER FROM THE SITE.

ALL UNDERPINNING SHALL PROCEED IN THE FOLLOWING SEQUENCE: 1. EXIST. ALL SECTIONS ON WALLS AS SHOWN ON THE DRAWING. 2. COMPLETE ALL SECTIONS MARKED "1" AND PROCEED IN NUMERICAL ORDER TO THE COMPLETION OF SECTION MARKED "4".


DETERMINATION OF SECTIONS SHALL NOT PROCEED WITHIN 24 HOURS OF THE CONCRETE POUR.

FLOOR EXCAVATIONS SHALL NOT PROCEED UNTIL COMPLETION OF UNDERPINNING UNLESS PERMITTED BY THE DISTRICT OF COLUMBIA DEPARTMENT OF CONSTRUCTION. UNDERPINNING SECTIONS ARE AT A MINIMUM OF 1:1 SLOPE OR SHORDED AND SHORED.

PROVIDE VERTICAL CONTINUOUS WATER STOPS AT THE INTERFACE OF BOTH FACES OF SECTIONS.

HORIZONTAL BARS SHALL BE DONKEYED INTO ADJACENT SECTIONS. DONKEYS PROTRUDING INTO THE EXIST. WALL SHALL BE PROTECTED WITH A WRAP, AND SHALL BE REMOVED PRIOR TO THE CONCRETE POUR.

GRADES AT THE BUILDING WALLS SHALL BE GRADED TO PROVIDE POSITIVE DRAINAGE OF STORM WATER AWAY FROM THE BUILDING.

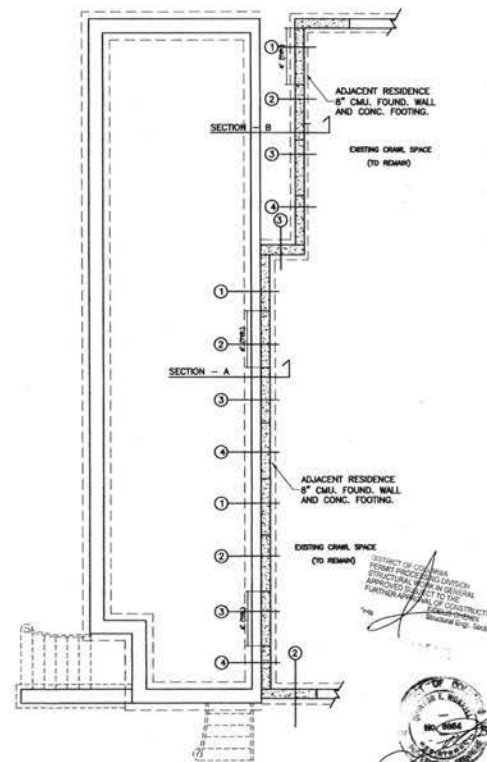

PROPOSED UNDERPINNING PLAN
SCALE: 1/4"=1'-0"

ARCHITECTS
RAOUL LISSABET, AIA
ARCHITECTS, LLC

19021 SEDLEY TERRACE
CAYTHESSBURG, MARY AND 20879
Tel: (301) 948-3197
E-Mail: rlissabet@comcast.net



RECEIVED
D.C. OFFICE OF ZONING
2012 MAY 16 PM 2:35

Issue Date	
No.	Description
1	10/21/11 DORA REVIEW COMMENTS
2	

NEW RESIDENCE
1514 S STREET N.W.
UNIT-B
WASHINGTON, DC 20001

Project Number: Drawn By:
Designed By: Checked By:
Sheet Title: UNDERPINNING PLAN
DETAILS-NOTES
Sheet Number: A-3





 DISTRICT OF COLUMBIA
 PUBLIC SAFETY
 No. 25672177
 RECEIVED
 11/11/2011

RECEIVED
D.C. OFFICE OF ZONING
2012 MAY 16 PM 2:36

Issue Date:		
Revisions		
No.	Date	Description
1		
2		

NEW RESIDENCE
451 S STREET N.W.
UNIT-A AND UNIT-B
WASHINGTON,DC 20001
SQUARE E475 LOT 22

Project Number:	Drawn By:
Designed By:	Checked By:
Sheet Title:	
FRAMING PLANS	
Sheet Number:	
A-4	

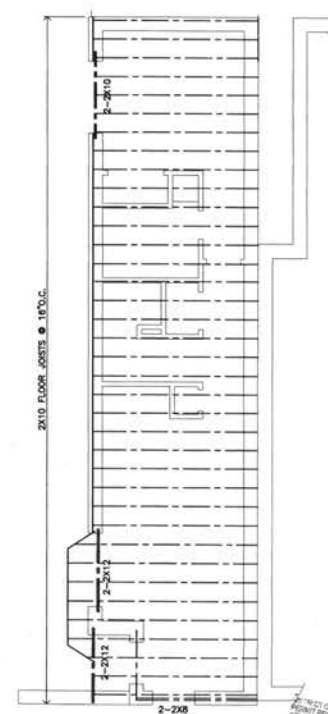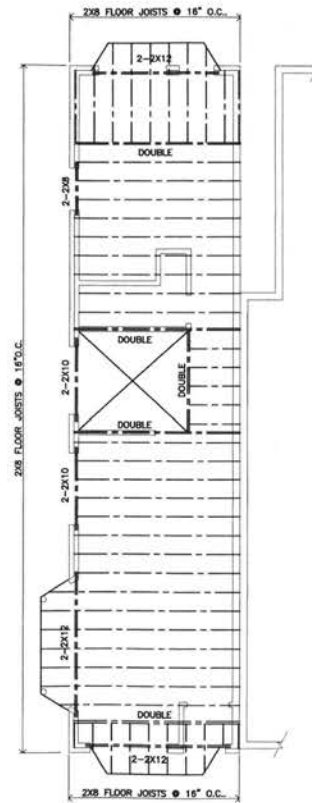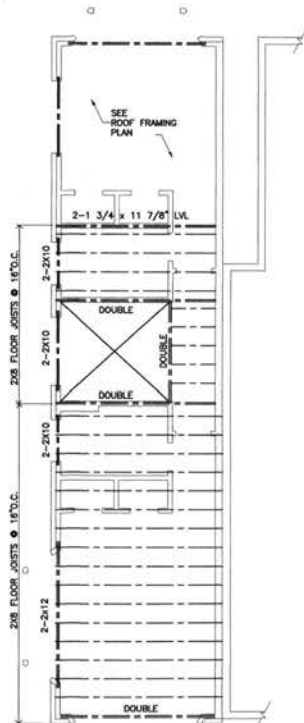

FIRST FLOOR FRAMING PLAN
SCALE: 1/4"=1'-0"

DISTRICT OF COLUMBIA
PERMIT PROCESSING DIVISION
STRUCTURAL MARK IN GENERAL
APPROVED SUBJECT TO THE
FURTHER APPROVAL OF CONSTRUCTION
PROJECTS CHIEF
Structural Engr. Section






RECEIVED
D.C. OFFICE OF ZONING
2012 MAY 16 PM 2:36


Issue Date	Revisions
10/31/11	1
	2

NEW RESIDENCE
451 S STREET N.W.
UNIT-A AND UNIT-B
WASHINGTON, DC 20001

Project Number:	Drawn By:
Sheet Title:	Checked By:
Sheet Number:	


A-5

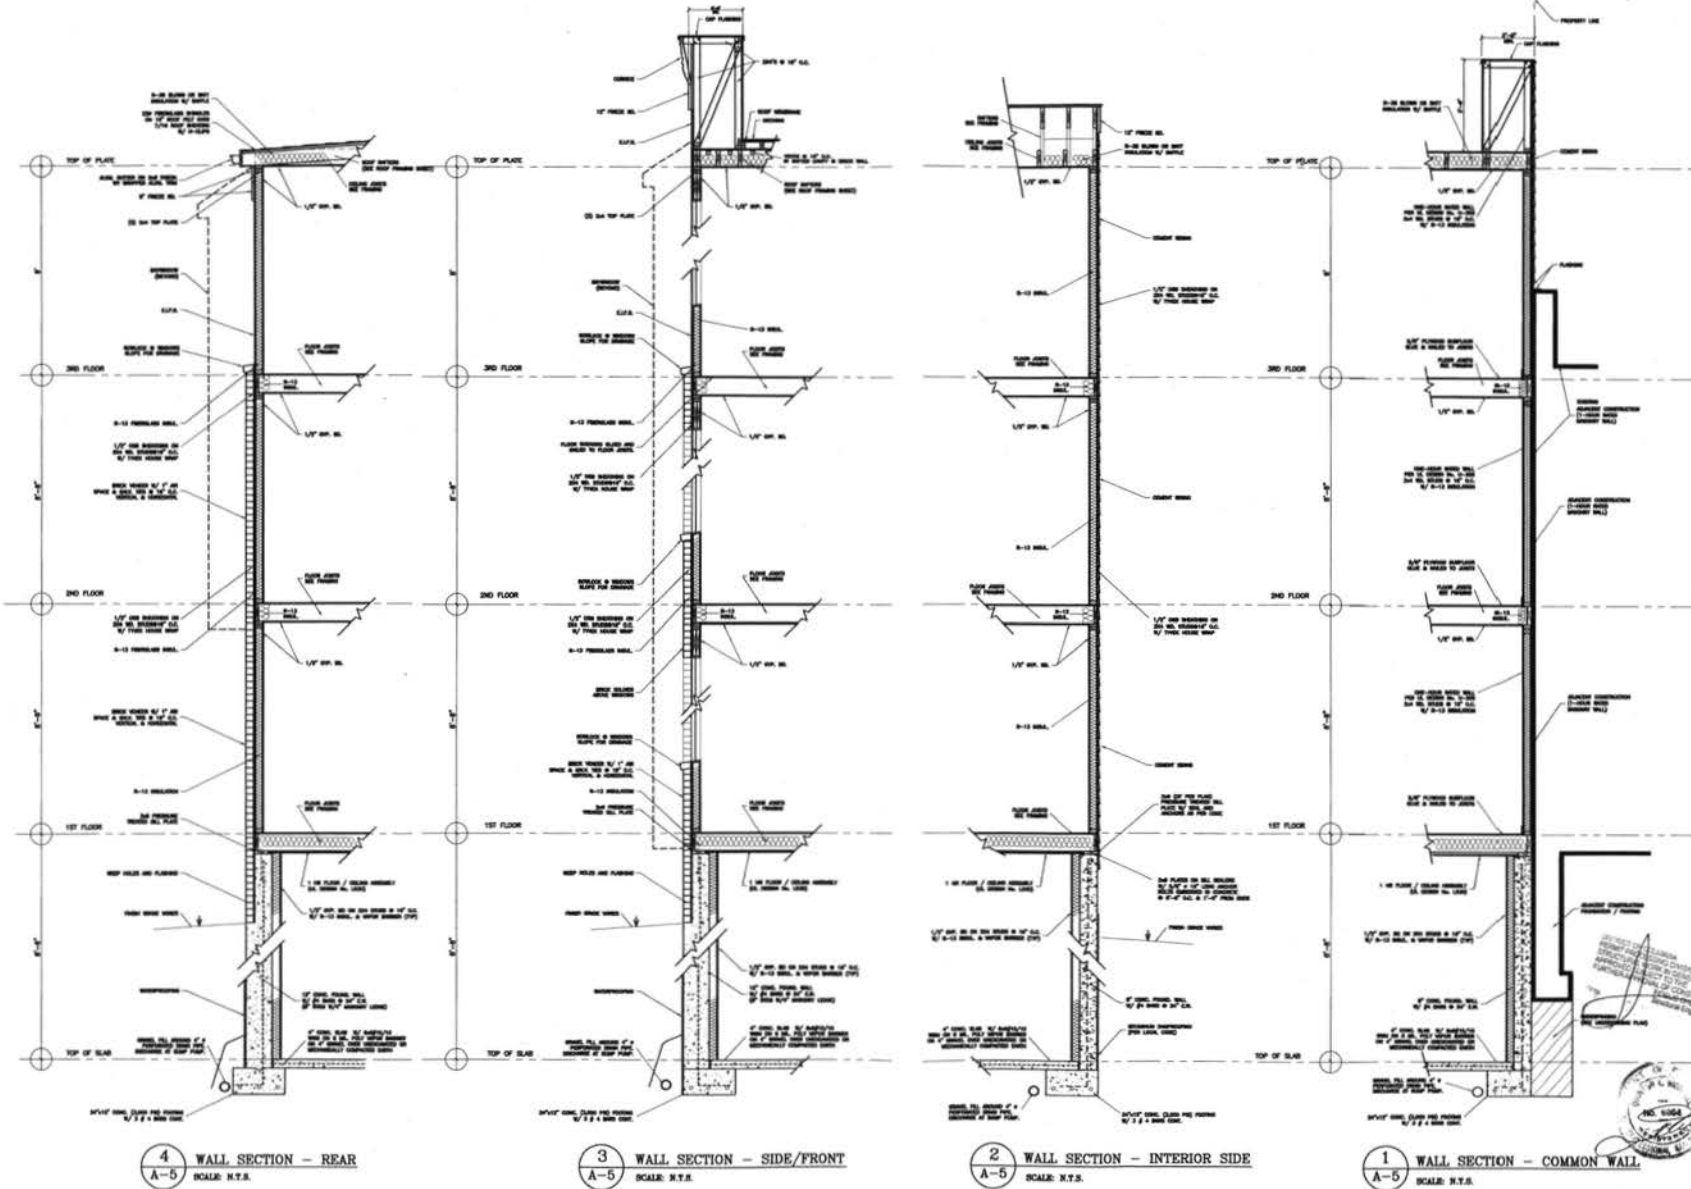

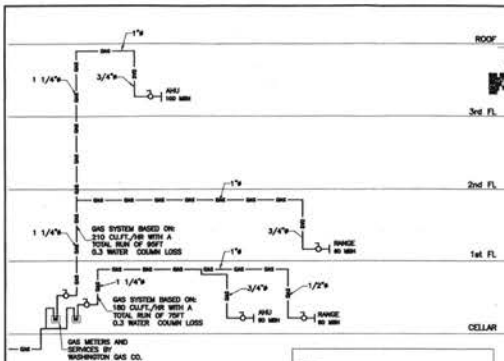

GAS RISER DIAGRAM
N.T.S.

NOTES:
1. SIDE GAS PIPING PER UTILITY REQUIREMENTS.
2. PROVIDE ALL PIPING, VALVES AND ASSEMBLIES AT EACH OUTLET AS REQUIRED BY THE MANUFACTURER AND AS REQUIRED FOR A SAFE INSTALLATION.

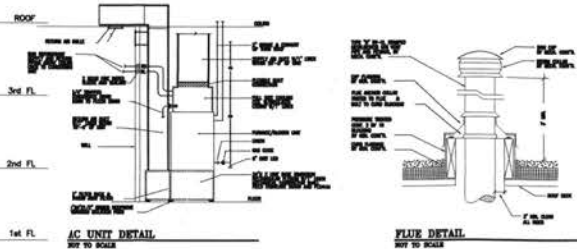

EQUIPMENT LIST

REGISTER & GRILLE SCHEDULE

TYPE	TOTAL	FIN LL.	OPT.
SUPPLY			
12"x4" SIDE WALL			
10"x4" FLOOR			
12"x4" FLOOR	24		
12"x4" C.B. CLG. 1-WAY	8		
10"x4" C.B. CLG. 1-WAY			
RETURN			
12"x12" SIDE WALL	1		
14"x14" CEILING	1		
14"x14" SIDE WALL	2		
24"x20" SIDE WALL			

* C.B. DENOTES CURVED BLADE REGISTER
* 1-WAY DENOTES DIRECTION OF AIR FLOW



WALL REGISTER LEGEND

BRANCH SIZE	RISER SIZE OR OVAL EQUIV.
4" ROUND	3 1/4"x8"
5" ROUND	3 1/4"x10"
6" ROUND	3 1/4"x12"
7" ROUND	3 1/4"x12"

AIR VOLUME SUMMARY

ROOM	HTG CFM	CLG CFM
BASEMENT	69	60
LV/DIN RM	60	33
KITCHEN	102	175
P.R.	52	39
BEDRM. #2	90	97
BEDRM. #3	85	94
BATH	52	39
HALL	52	39
M. BEDRM	157	135
M. BATHRM	45	45
W.C.	32	39
HALL	52	39
LOFT	85	94

HVAC SYMBOLS

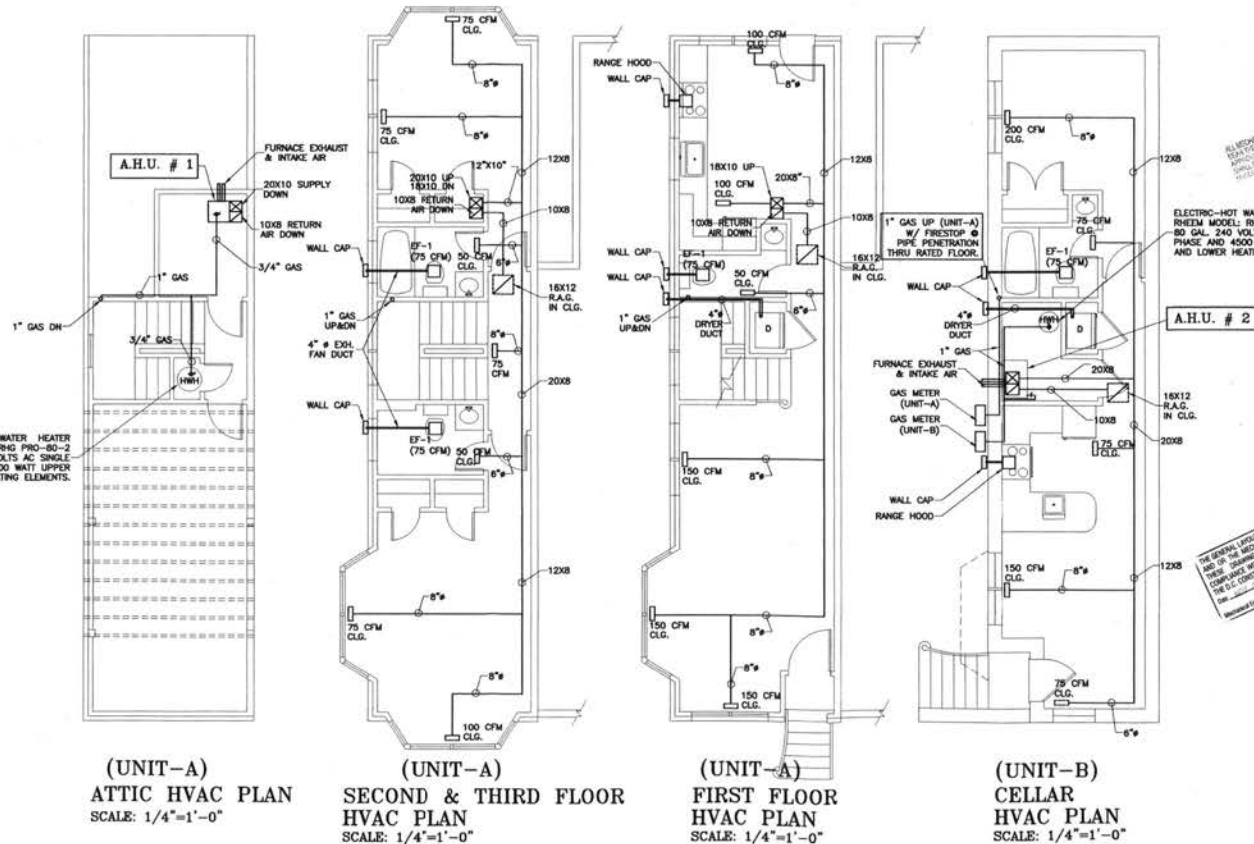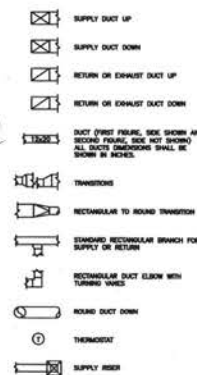

(UNIT-A)
ATTIC HVAC PLAN
SCALE: 1/4"=1'-0"

(UNIT-A)
SECOND & THIRD FLOOR
HVAC PLAN
SCALE: 1/4"=1'-0"

(UNIT-A)
FIRST FLOOR
HVAC PLAN
SCALE: 1/4"=1'-0"

(UNIT-B)
CELLAR
HVAC PLAN
SCALE: 1/4"=1'-0"

ARCHITECTS
RADUL USSABET, AIA
ARCHITECTS, LLC
19021 SEDLEY TERRACE
GATHERSBURG, MARYLAND 20879
Tel: (301) 548-3157
E-Mail: r19021@comcast.net

RECEIVED
D.C. OFFICE OF ZONING
2012 MAY 16 PM 2:36

Issue Date: 10/31/11
Revision: 1
Description: DORA REVIEW COMMENTS

NEW RESIDENCE
N.W. 154
STREET AND
UNION
AVENUE
WASHINGTON, D.C. 20001





Project Number: Drawn By:
Designed By: Checked By:
Sheet Title: HVAC & GAS PLANS
Sheet Number: M-1

SCHOOL'S LIST	
SYMBOL	DESCRIPTION
ABR	EXISTING PIPE TO REMAIN
SAN, W.	SANITARY OR WASTE PIPING
V	VENT PIPING
UG	UNDER GROUND STEAM DRUM PIPING
ST	ABOVE GROUND STEAM DRUM
C.W.	COLD WATER PIPING
N.W.	HEAT WATER PIPING
G	GAS PIPING
SP	AUTOMATIC FIRE SPROKELER PIPING
	INSPECTION TEST AND BALANCE VALVE
SH	SHUT OFF VALVE
WH	WALL HYDRANT
	GAS COOK
BP	BACK FLOW PREVENTOR
	PIPE UP, PIPE DOWN
FD	FLOOR DRAIN
	CLEAN OUT
DSAY	OUTSIDE SCREW AND YOLK VALVE
	CHECK VALVE WITH AUTOMATIC BALL DROP
TS	TAMPER SWITCH
	FIRE ALARM CHECK VALVE
VTR	VENT THROUGH ROOF
	EXHAUST DUCT UP

Issue Date:		
Revisions		
No.	Date	Description
1	10/31/11	DORA REVIEW COMMENTS
2		

NEW RESIDENCE
451 S STREET N.W.
UNIT-A AND UNIT-B
WASHINGTON,DC 20001
SQUARE E475 LOT 22

Project Number:	Drawn By:
Designed By:	Checked By:
Sheet Title:	
ELECTRICAL PLANS	
Sheet Number:	

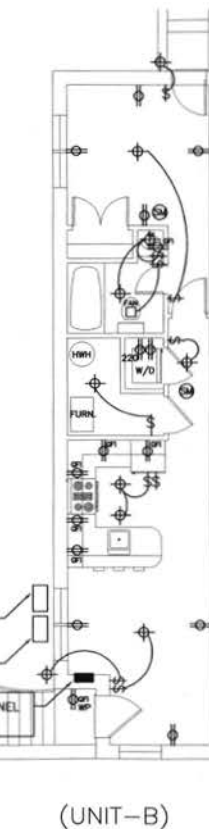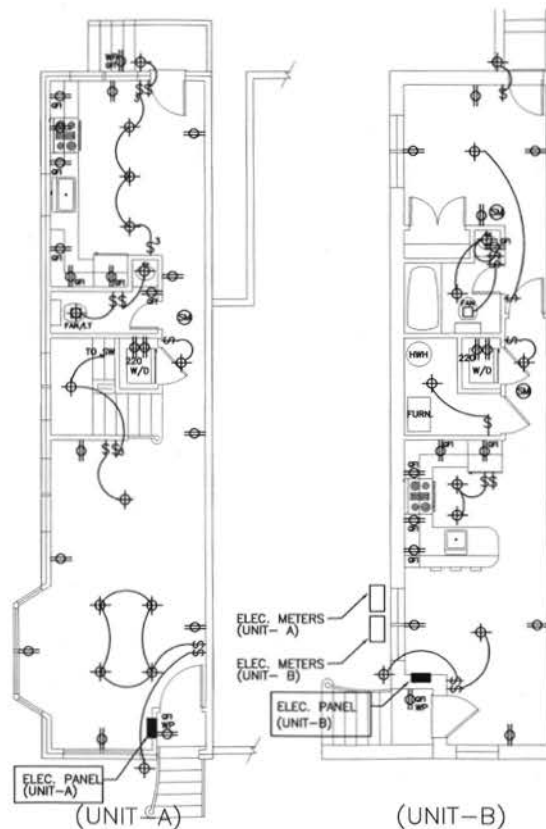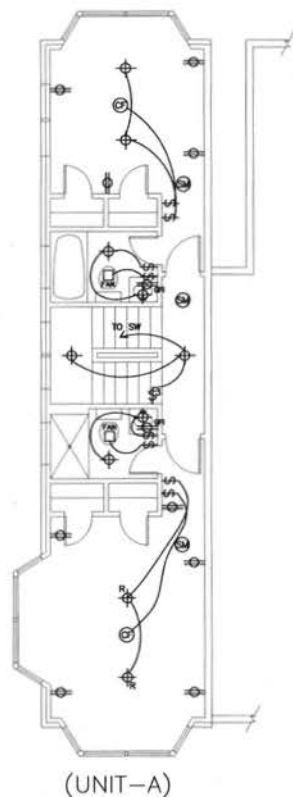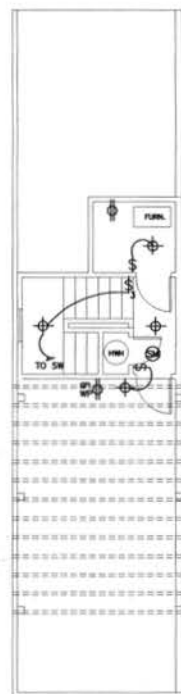

- ### ELECTRICAL/LIGHTING LEGEND
- | | |
|---|-------------------------------|
|  | SURFACE MOUNTED LIGHT FIXTURE |
|  | RECESSED LIGHT FIXTURE |
|  | WALL MOUNTED LIGHT FIXTURE |
|  | WEATHERPROOF LIGHT FIXTURE |
|  | DOOR BELL |
|  | FAN |
|  | FAN & LIGHT FIXTURE |
|  | SINGLE POLE SWITCH |
|  | THREE WAY SWITCH |
|  | DIMMER SWITCH |
|  | DUPLEX RECEPTICLE |
|  | SPECIAL OUTLET 220 VOLTS |
|  | DUPLEX RECEPTICLE - GFI |
|  | WEATHERPROOF RECEPTICLE |
|  | SMOKE DETECTOR |
|  | CEILING FAN |
|  | ELECTRICAL PANEL |

BUILDING AND LIVESTOCK INSPECTION ADMINISTRATION
The University of Idaho
~~THIS DOCUMENT APPROVED~~ ☒ AS SUBMITTED ☒ AS NOTED
INSTALLER SUBJECT TO FURTHER REVIEW
OF FIELD INSPECTION
Inspector luc Date 11-4-0



PANEL TYPE	300/250 VOLTS	1	PHASE	3	WIRE	300 AMPS
	SOLID NEUTRAL	3	NEUA TYPE	1	300	400 AMPS/M.O.
	GROUND BUS	YES	A.I.C. 5/8 IN.	YES	ENR FRAME	YES
LOCATION	LABOR ROOM		MOUNTING	RECESSED		

DESCRIPTION	C-B-AMPS		A B		C-B-AMPS		DESCRIPTION			
	2	100/150	1	2	2	100/150				
LIGHTING	1	20	1	1.5	1.4	2	30	1	REDFPANELS	
LIGHTING	1	20	3			1	20	1	REDFPANELS	
REFRIGERATOR	1	20	5	1.4	1.5	1.4	6	20	1	REDFPANELS
DESHOWER	1	20	7				8	20	1	REDFPANELS
WASTE DISPOSAL	1	20	9				8	10	1	REDFPANELS
WAXE - GAS	1	20	11				12	20	1	WATER HEATER-ELEC.
MICROWAVE	1	20	13	1.4	1.8	1.8	14	20	1	WASHER
DI-1	1	20	15				16	20	2	DIV
AC UNIT	2	40	17	8.0	1.0	1.0	18			
			19				20			
SPRINK	1	20	21	---	6.0	---	22	30	1	SPRINK
SPRINK	1	20	23	---	---	---	24	30	1	BATHROOM RECEPT.
SPRINK	1	20	25	---	---	---	26	30	1	SPRINK
SPRINK	1	20	27	---	---	---	28	30	1	SPRINK
SPRINK	1	20	29	---	---	---	30	30	1	SPRINK

*NOTE: AC BACKS WITH LEADY

TOTAL KW = 28.86
 CORRECTED LOAD= 116.00 AMPS
 REFER TO CALCULATIONS BELOW

PROVIDE CIRCUIT BREAKERS FOR NEG 21-12
 (ARC-FAULT DET.-INTERDPTED)

LOAD CALCULATIONS (TYPICAL OF EACH UNIT)			
	CORRECTED	DIVERSITY	DEMAND
LIGHTING AND RECEPTILES (SECTION 220-3(b))	8.8 kVA	1ST 30% @ 100% REMAINING @ 75%	3.0 kVA 1.3 kVA
FIXED APPLIANCES (SECTION 220-11)			
OVENS	1.0 kVA	100%	1.0 kVA
REFRIGERATOR	.3 kVA	100%	.3 kVA
WASHER/DRYER	2.8 kVA	100%	2.8 kVA
OTHER			
HVAC	8.4 kVA	100%	8.4 kVA
WATER HEATER	1.0 kVA	100%	1.0 kVA
SUBTOTAL	16.40 kVA		16.10 kVA
TOTAL LOAD AFTER DIVERSITY			= 47.25 AMPS
PLUS 25% OF LOAD			= 16.8 AMPS
TOTAL LOAD AFTER CALCULATIONS			= 64.13 AMPS
SIZE OF PANELBOARD			= 100 AMPS

POWER RISER DIAGRAM

- 1 PROVIDE A SLOPE 240/120N, 1A, 1N PAVEMENT.
- 2 UTILITY C/T CABINET - COORDINATE EXACT REQUIREMENTS WITH UTILITY
- 3 ELECTRICAL UTILITY METER, COORDINATE EXACT REQUIREMENTS WITH THE UTILITY 100N, 1A/3N, 120/240V
- 4 WIDE THROUGHT SIZED PER NEC AND COORDINATE W/ UTILITY.
- 5 NEW INCOMING ELECTRICAL SERVICE BY PERIOD, COORDINATE OVERHEAD OR UNDERGROUND ROUTING OF THE FEEDER WITH THE UTILITY.
- 6 $3\frac{1}{2} \times 8$ IN 1-1/2" CONDUIT
- 7 PROVIDE A $3/4 \times 8$ CU AND PER NEC AND LOCAL CODE REQUIREMENTS.
- 8 #4 AND TO DRAINER DRAIN RIG (4" OF LONG) AND TO STREET SIDE OF COLD WATER MAIN AS PER NEC AND LOCAL CODE REQUIREMENTS

BRANCHED CIRCUIT WIRING CONCEALED IN CEILING OR WALL
BRANCHED CIRCUIT WIRING OR DUCTWORK CONCEALED IN FLOOR/
CEILING CHASE

WIRE/CONDUCTOR TO BE INSULATED NOTED. AWG/MSD INDICATED NO. OF
CONDUCTORS OF CIRCUIT. BRANCH BOXES NO. OF WIRE WHEN MORE
THAN THREE (ONE, NEUTRAL, AND GROUND CONDUCTORS)

UNDERGROUND DUCTWORK, SIZE AS NOTED

WIRE OR CONDUCTOR TO BE TERMINATED AS NOTED
CONDUIT TURNED UP
CONDUIT TURNED DOWN
REFERENCE NOTE NUMBER

TELEPHONE PANELS/BOXES

 DUPLEX RECEPTACLE - NON-S-BOX

 DUPLEX RECEPTACLE - NON-S-BOX

 DUPLEX RECEPTACLE - NON-S-BOX LETTERS "01" INDICATE
ONLINE FINAL ORDER INTERRUPTER

 DUPLEX RECEPTACLE - NON-S-BOX LETTERS "01" INDICATE
REORDERPROOF DISCLOSURE

 SPECIAL RECEPTACLE - NON-REARRANGEMENT AS INDICATED

 TELEPHONE OUTLET WITH 3/4" CONDUIT

 COMMON TELEPHONE/VIDEO/CABLE OUTLET WITH 3/4" CONDUIT

 CABLE OUTLET WITH 3/4" CONDUIT

 JUNCTION BOX - WALL OR CEILING MOUNTED

 PULLBOX

 SWITCH SWITCH - SIZE AS INDICATED

 SWITCH SWITCH - SIZE AS INDICATED. (PUSH/ON/OFF/STOP/PAUSE SIZE)

 SWITCH - RANGER INDICATES HANGEROVER

 COMBINATION MOTOR SWITCH & DISCONNECT SWITCH -
SIZE AS INDICATED

 GROUNDING CONDUCTOR

4, 5 & 6 FLUORESCENT STAY LIGHTING FEATURE.

7 WALL MOUNTED LIGHTING FEATURE.

8 FLUORESCENT LIGHTING FEATURE.

9 SURFACE MOUNTED F.L.S. FEATURE.

10 PENDANT OR SURFACE MOUNTED DOWNLIGHT.
(STINKBARS ARE NOT SHOWN AS SCALED ON PLANS)

11 RECESSED MOUNTED DOWNLIGHT.

12 SINGLE POLE SWITCH, 20A, 120V.

13 THREE WAY SWITCH.

14 DIMMER SWITCH.

(S) REMEDIAL, RESIDENTIAL, HARD WIRE SMOKE DETECTORS DETECTOR W/ BATTERY BACK-UP

NOTE: THE LIST OF SYMBOLS IS A TYPICAL LIST AND MAY NOT APPLY TO ALL PROJECTS.

A. THE ENTIRE ELECTRICAL INSTALLATION SHALL CONFORM TO THE LATEST APPLICATION EDITION OF THE NATIONAL ELECTRICAL CODE AND ALL JURISDICTION REQUIREMENTS.

- ALL LISTED, EQUIPMENT, DEVICES, ETC., SHALL BE NEW, AND AS ORIENTED. PROVIDE ALL MATERIALS, BRACING, HANGERS AND EQUIPMENT AS REQUIRED TO SUPPORT THE WEIGHT OF THE ELECTRICAL SYSTEM. MINOR ITEMS SUCH AS COUPLINGS, FITTINGS, BRACINGS, HANGERS, ETC. NOT NECESSARILY SHOWN OR SPECIFIED BUT REQUIRED FOR THE PROPER INSTALLATION OF THE ELECTRICAL SYSTEM SHALL BE INCLUDED IN THE WORK AS IF KEENEN SHOWN OR SPECIFIED.
- C. LIGHTING FIXTURES
- COORDINATE EXISTING LIGHTING FIXTURES WITH SPRINKLER, MECHANICAL, EQUIPMENT AND ARCHITECTURAL, CEILING PLANS. GIRD LAYOUT ON PLANS IS PRELIMINARY. ADJUST AND COORDINATE LIGHTING FIXTURES IN FIELD FOR ARCHITECT'S REFLECTED CEILING PLAN.
 - PROVIDE FINISHED FRAMES FOR ALL NEW EXISTING LIGHTING FIXTURES. TYPE SHALL BE CONFORMABLE WITH CEILING. COORDINATE ALL FIXTURE TYPES WITH CEILING SYSTEM BEFORE ORDERING FIXTURES. CONFIRM THAT ALL LIGHT FIXTURES WILL BE IN LOCATIONS AND ORIENTATIONS AND COORDINATED AND ADJUSTED PRIOR TO PLACING ORDER IF CONFLICTS ARE DISCOVERED. PROVIDE ALL MOUNTING ATTACHMENTS FOR A COMPLETE INSTALLATION. LIGHTING FIXTURES SHALL BE SUPPORTED BY THE MINIMUM HANGERS AND EQUIPMENT INDEPENDENTLY FROM CEILING SYSTEM. FOR STEEL MOUNTED FIXTURES CONTRACTOR SHALL PROVIDE TWO STRIPS FOR FIXTURE.
- D. BRANCH CIRCUITRY
- ALL CONDUCTORS SHALL BE COPPER.
 - ALL BRANCH CIRCUITRY SHALL BE INSTALLED IN UNWEATHERED EXISTING 2" AND MINIMUM COPPER CONDUITS.
 - ALL CIRCUITRY SHALL BE RUN CONCEALED IN FINISHED AREAS.
 - MINIMUM SIZE CONDUIT SHALL BE 3/4" INCH (21 CM).
 - ALL RECPROCAL, LIGHTING FIXTURES, MOTORS, ETC., SHALL BE GROUNDED FOR N.E.C. REQUIREMENTS. ALL CIRCUITS SHALL CONTAIN A #12 INSULATED GROUND CONDUCTOR.
 - FINAL CONNECTION TO ALL MOTORS OR WIRING EQUIPMENT SHALL BE WITH FLEXIBLE CONDUIT.
 - EXPOSED AND CONCEALED CIRCUITRY SHALL BE RUN TIGHT TO CEILING SLAB IN NEAT WORKMANLIKE MANNER. ALL RUNS SHALL BE PROTECTED OR PROPERLY SECURED TO BUILDING WALLS AND SECURED TO BUILDING STRUCTURE AND WALL, ETC.
 - ALL HANGERS WHICH ARE OVER 180 INCH FEET SHALL BE A MINIMUM OF #10 CONDUCTORS OR AS SHOWN ON PLANS.
- E. FREE WIRE WORK
- CONTRACTOR SHALL HAVE WIRE AND ALL WIRE HANGERS TO A 3/8" OR GREATER HANGER LOCATED IN THE NEAR FLOORWAYS.
- F. EXISTENCE

1. ALL EQUIPMENT SHALL BE INSTALLED IN ACCORDANCE WITH THE MANUFACTURERS RECOMMENDATIONS. ANY CONFLICT BETWEEN MANUFACTURERS RECOMMENDATIONS AND THE CONTRACT DRAWINGS AND SPECIFICATIONS SHALL PROMPTLY BE BROUGHT TO THE ATTENTION OF THE PROJECT ENGINEER.
2. CONTRACTOR SHALL SUBMITTAL ALL LADDER AND MATERIALS FOR A PERIOD OF ONE YEAR FROM DATE OF FINAL ACCEPTANCE OF WORK IN THE PROJECT OFFICE.
3. AT THE COMPLETION OF INSTALLATION, ALL EQUIPMENT SHALL BE TESTED AND ADJUSTED AS NECESSARY. ANY DEFECTS, MALFUNCTIONS AND ABNORMAL EQUIPMENT VARIATIONS SHALL BE REPAIRED AT CONTRACTORS COST TO THE SATISFACTION OF THE PROJECT ENGINEER.
4. CONTRACTOR SHALL FURNISH TO THE OWNER TWO COMPLETE BOUND SETS OF TYPEWRITTEN OR SHADOWGRAPHED INSTRUCTIONS FOR OPERATING AND MAINTAINING ALL SYSTEMS AND EQUIPMENT INCLUDED IN THIS CONTRACT.
5. CONTRACTOR SHALL SUBMIT FOR APPROVAL, DETAILED SHOP DRAWINGS OF ALL ELECTRICAL EQUIPMENT AND MATERIAL. SHOP DRAWINGS SHALL INCLUDE EQUIPMENT CAPACITIES AND ANY RELATED INFORMATION. THE ENGINEER SHALL REQUIRE TO INSURE COMPLIANCE WITH SPECIFICATIONS AND DRAWINGS. NO MATERIAL OR EQUIPMENT MAY BE ORDERED OR DELIVERED TO THE JOB SITE UNTIL THE CONTRACTOR HAS IN HIS POSSESSION THE APPROVED SHOP DRAWINGS FOR THE PARTICULAR MATERIAL OR EQUIPMENT.

IN THE EVENT OF CONFLICT BETWEEN VARIOUS PARTS OF THE CONTRACT DOCUMENT (INCLUDING BUT NOT LIMITED TO DRAWINGS, SPECS AND GENERAL CONDITIONS) THE MORE STRINGENT (MORE COSTLY) OF THE CONDITIONS SHALL APPLY FOR BIDDING PURPOSES. CONTRACTOR SHALL REQUEST CLARIFICATION OF ALL CONFLICTS PRIOR TO CONSTRUCTION.



Issue Date: 3/2/2011

No.	Date	Description
1	10/31/11	DCRA REVIEW COMMENTS
2		

NEW RESIDENCE
451 S STREET, N.W.
UNIT-A AND UNIT-B2
WASHINGTON, DC 20004

Project Number:	Drawn by:
-----------------	-----------

Designed By	Checked By
-------------	------------

Sheet Title: 1ELECTRICAL NOTES
SCHEDULES

Sheet Number: 1

□ $\rightarrow$ □