

CDCl₃, INC.

868 HUBBARD DR.
ROCKVILLE, MD 20852
PHONE: 301.984.4221
FAX: 301.984.4335

627 ALLENTOWN RD.
SUITE 105
SUITLAND, MD 20746
PHONE: 899.0028
FAX: 301.984.4335

PROFESSIONAL CERTIFICATION. I
HEREBY CERTIFY THAT THESE
DOCUMENTS WERE PREPARED OR
APPROVED BY ME, AND THAT I AM A
DULY LICENSED PROFESSIONAL
ENGINEER UNDER THE LAWS OF THE
DISTRICT OF COLUMBIA, LICENSE NO.
8652, EXPIRATION DATE: AUGUST 31,
2016.

SEAL:

PROJECT NAME:

**24 RHODE ISLAND AVENUE N.E.
WASHINGTON, DC 20002**

MARK		DATE	DESCRIPTION

DATE: 9.24.14

PROJECT: 000-00

SCALE: 3/16"=1'-0"

 
SHEET TITLE:

BASEMENT, FIRST,
SECOND AND
THIRD FLOOR
Finishing Adjustment
DEMOLITION PLANS

SHEET NO.: 5

A-101

LEGEND

DOOR TO BE
DEMOLISHED

DOOR EXISTING
TO REMAIN



WALL TO BE
DEMOLISHED



EXISTING WALL
TO REMAIN

EXISTING WIND
TO REMAIN



EXISTING WINDOW
TO REMAIN

1

KEYED NOTES

DEMO NOTES

1 REMOVE AND DISPOSE OF EXISTING DOOR, FRAME AND HARDWARE.

2 REMOVE EXISTING WOOD STUD AND DRYWALL PARTITION.

3 REMOVE EXISTING WOOD STUD AND DRYWALL PARTITION FOR OPENING NEW DOOR.

4 REMOVE AND DISPOSE OF EXISTING STAIRS, HANDRAIL AND POST.

5 REMOVE AND DISPOSE OF EXISTING HAND SINK, TOILET, AND BATHTUB. CAP ALL PLUMBING PIPES UPON REMOVAL OF ALL PLUMBING FIXTURES.

BASEMENT DEMOLITION PLAN


SCALE: 3/16" = 1'-0"

SECOND FLOOR DEMOLITION PLAN

SCALE: 3/16" = 1'-0"

THIRD FLOOR DEMOLITION PLAN

SCALE: 3/16" = 1'-0"

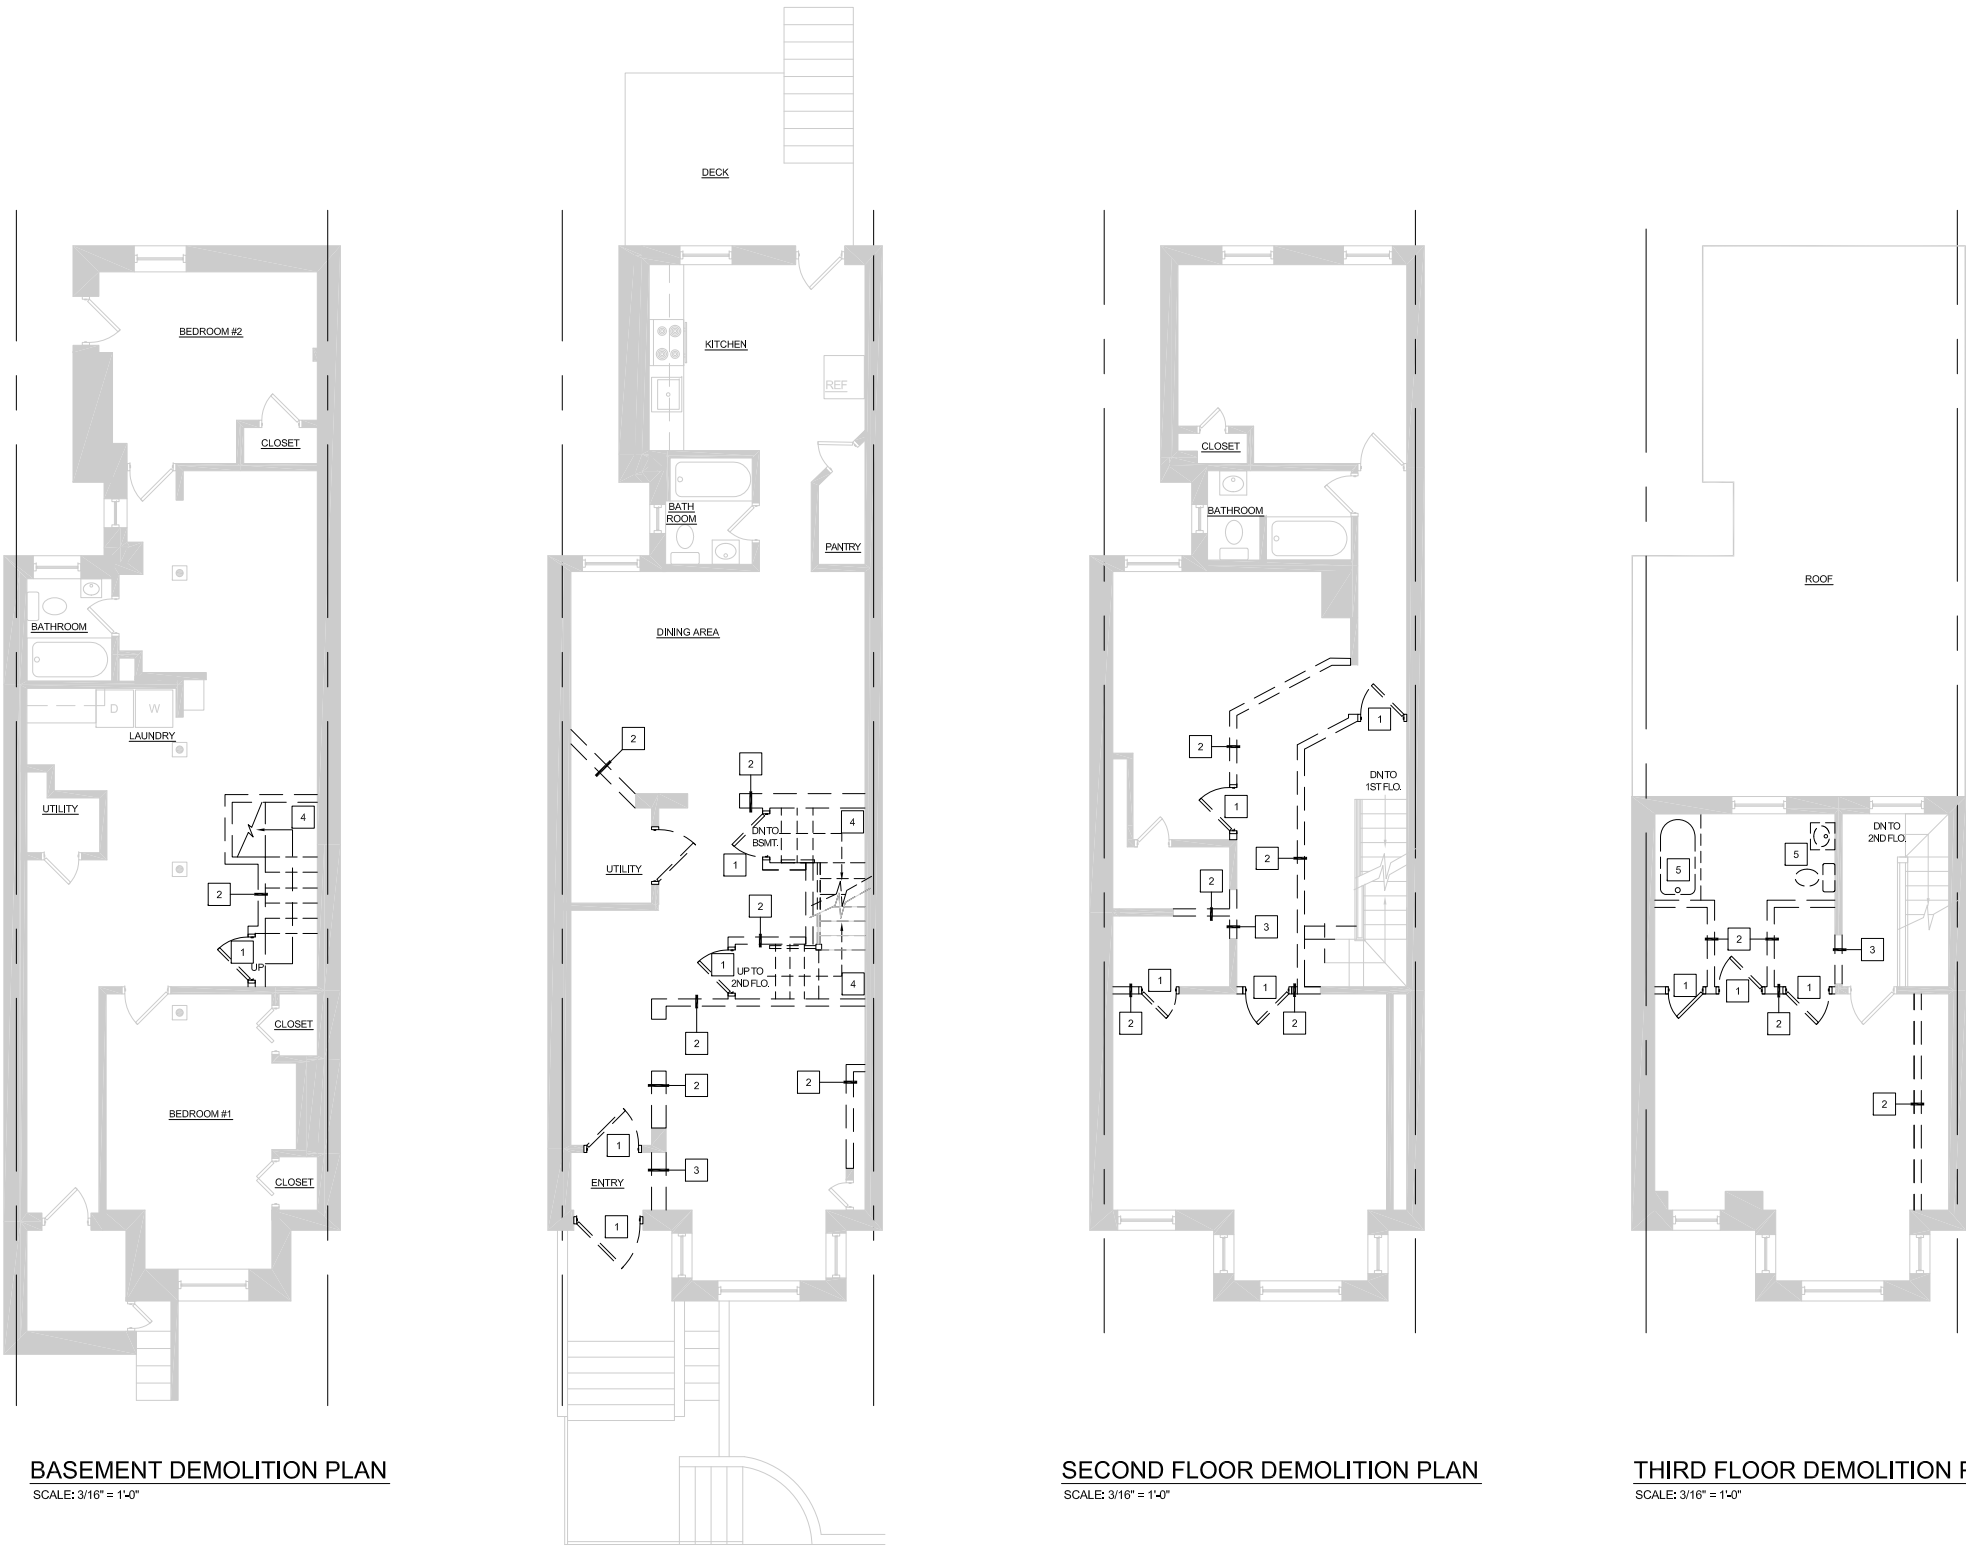

Board of Zoning Adjustment
District of Columbia
CASE NO.18889
EXHIBIT NO.: