


- Ⓢ SMOKE DETECTOR
- ◻ RETURN GRILLE*
- ⊠ SUPPLY DIFFUSER*
- ⊠ WALL MOUNTED EXIT SIGN
- ⊠ CEILING MOUNTED EXIT SIGN
- ⊠ EMERGENCY LIGHTS
- ⊙ SPRINKLER HEAD
- ⊙ WALL MOUNTED SPRINKLER HEAD
- ⊙ ELEC. OUTLET
- ⊙ DATA OUTLET
- ▬ RECESSED PANEL BOARD
- COVER PLATE
- ⊙ JUNCTION BOX
- ⊙ RECESSED LIGHT FIXTURE
- ⊙ SURFACE MOUNTED LIGHT FIXTURE
- ⊙ WALL MOUNTED LIGHT FIXTURE
- ⊙ SERVICE LIGHT WITH PULL SWITCH
- ⊙ SWITCH
- ⊙ DOOR BELL
- ⊙ THERMOSTAT
- ⊙ ALARM PANEL
- ⊙ WALL REGISTER*
- ⊙ AIR HANDLING UNIT
- ⊙ WATER HEATER
- ⊙ WATER CONNECTION (WASHER)
- ⊙ DRINKING FOUNTAIN
- ⊙ EXHAUST FAN
- DW DISH WASHER
- MW MICROWAVE
- ⊙ FIRE ANNUNCIATOR PANEL
- ⊙ FIRE EXTINGUISHER

*TYPICAL 400 CFM
⊙ EACH S/R

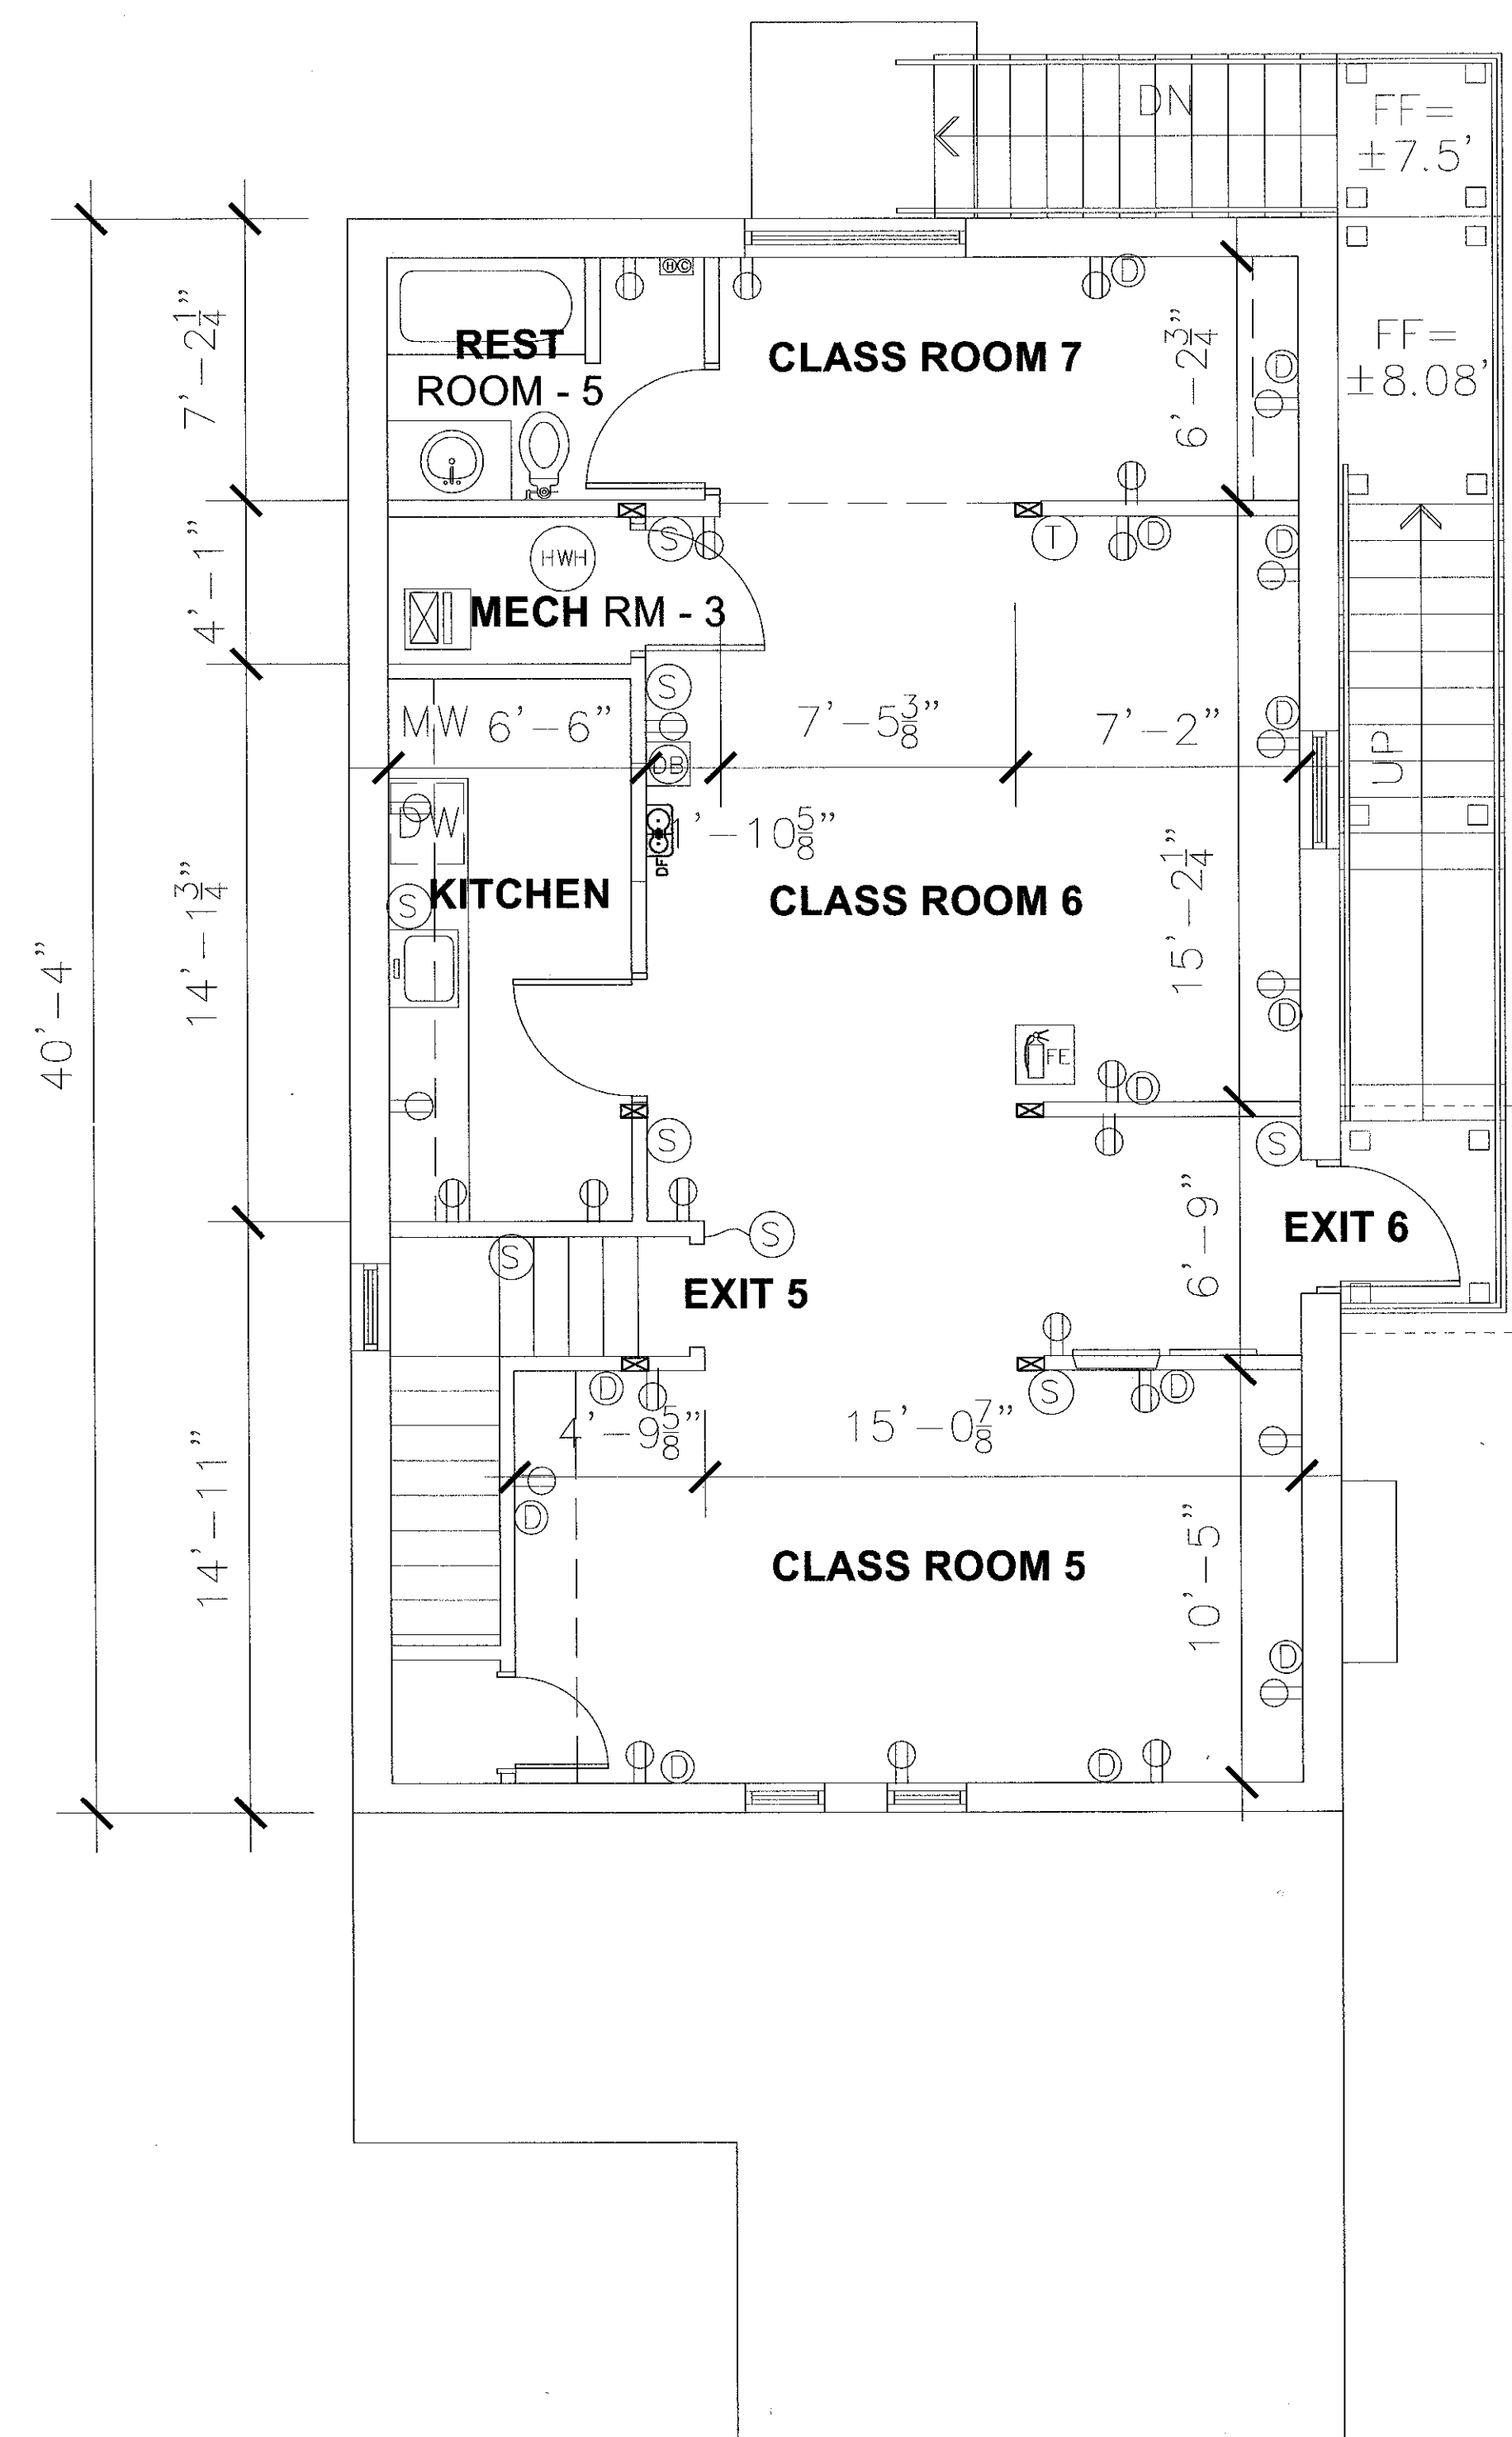


CAPACITY OF STUDENTS Building full Sprinkle
ON THIS FLOOR = 17
AGE GROUP = OVER 2 1/2 Y.O. Occupancy Group E

PLAN - SECOND FLOOR

Scale: 1/4" = 1'

THESE PLANS ARE MADE TO BE COMPLIANT WITH THE
FOLLOWING CODES:
IBC 2012
DCMR 2013

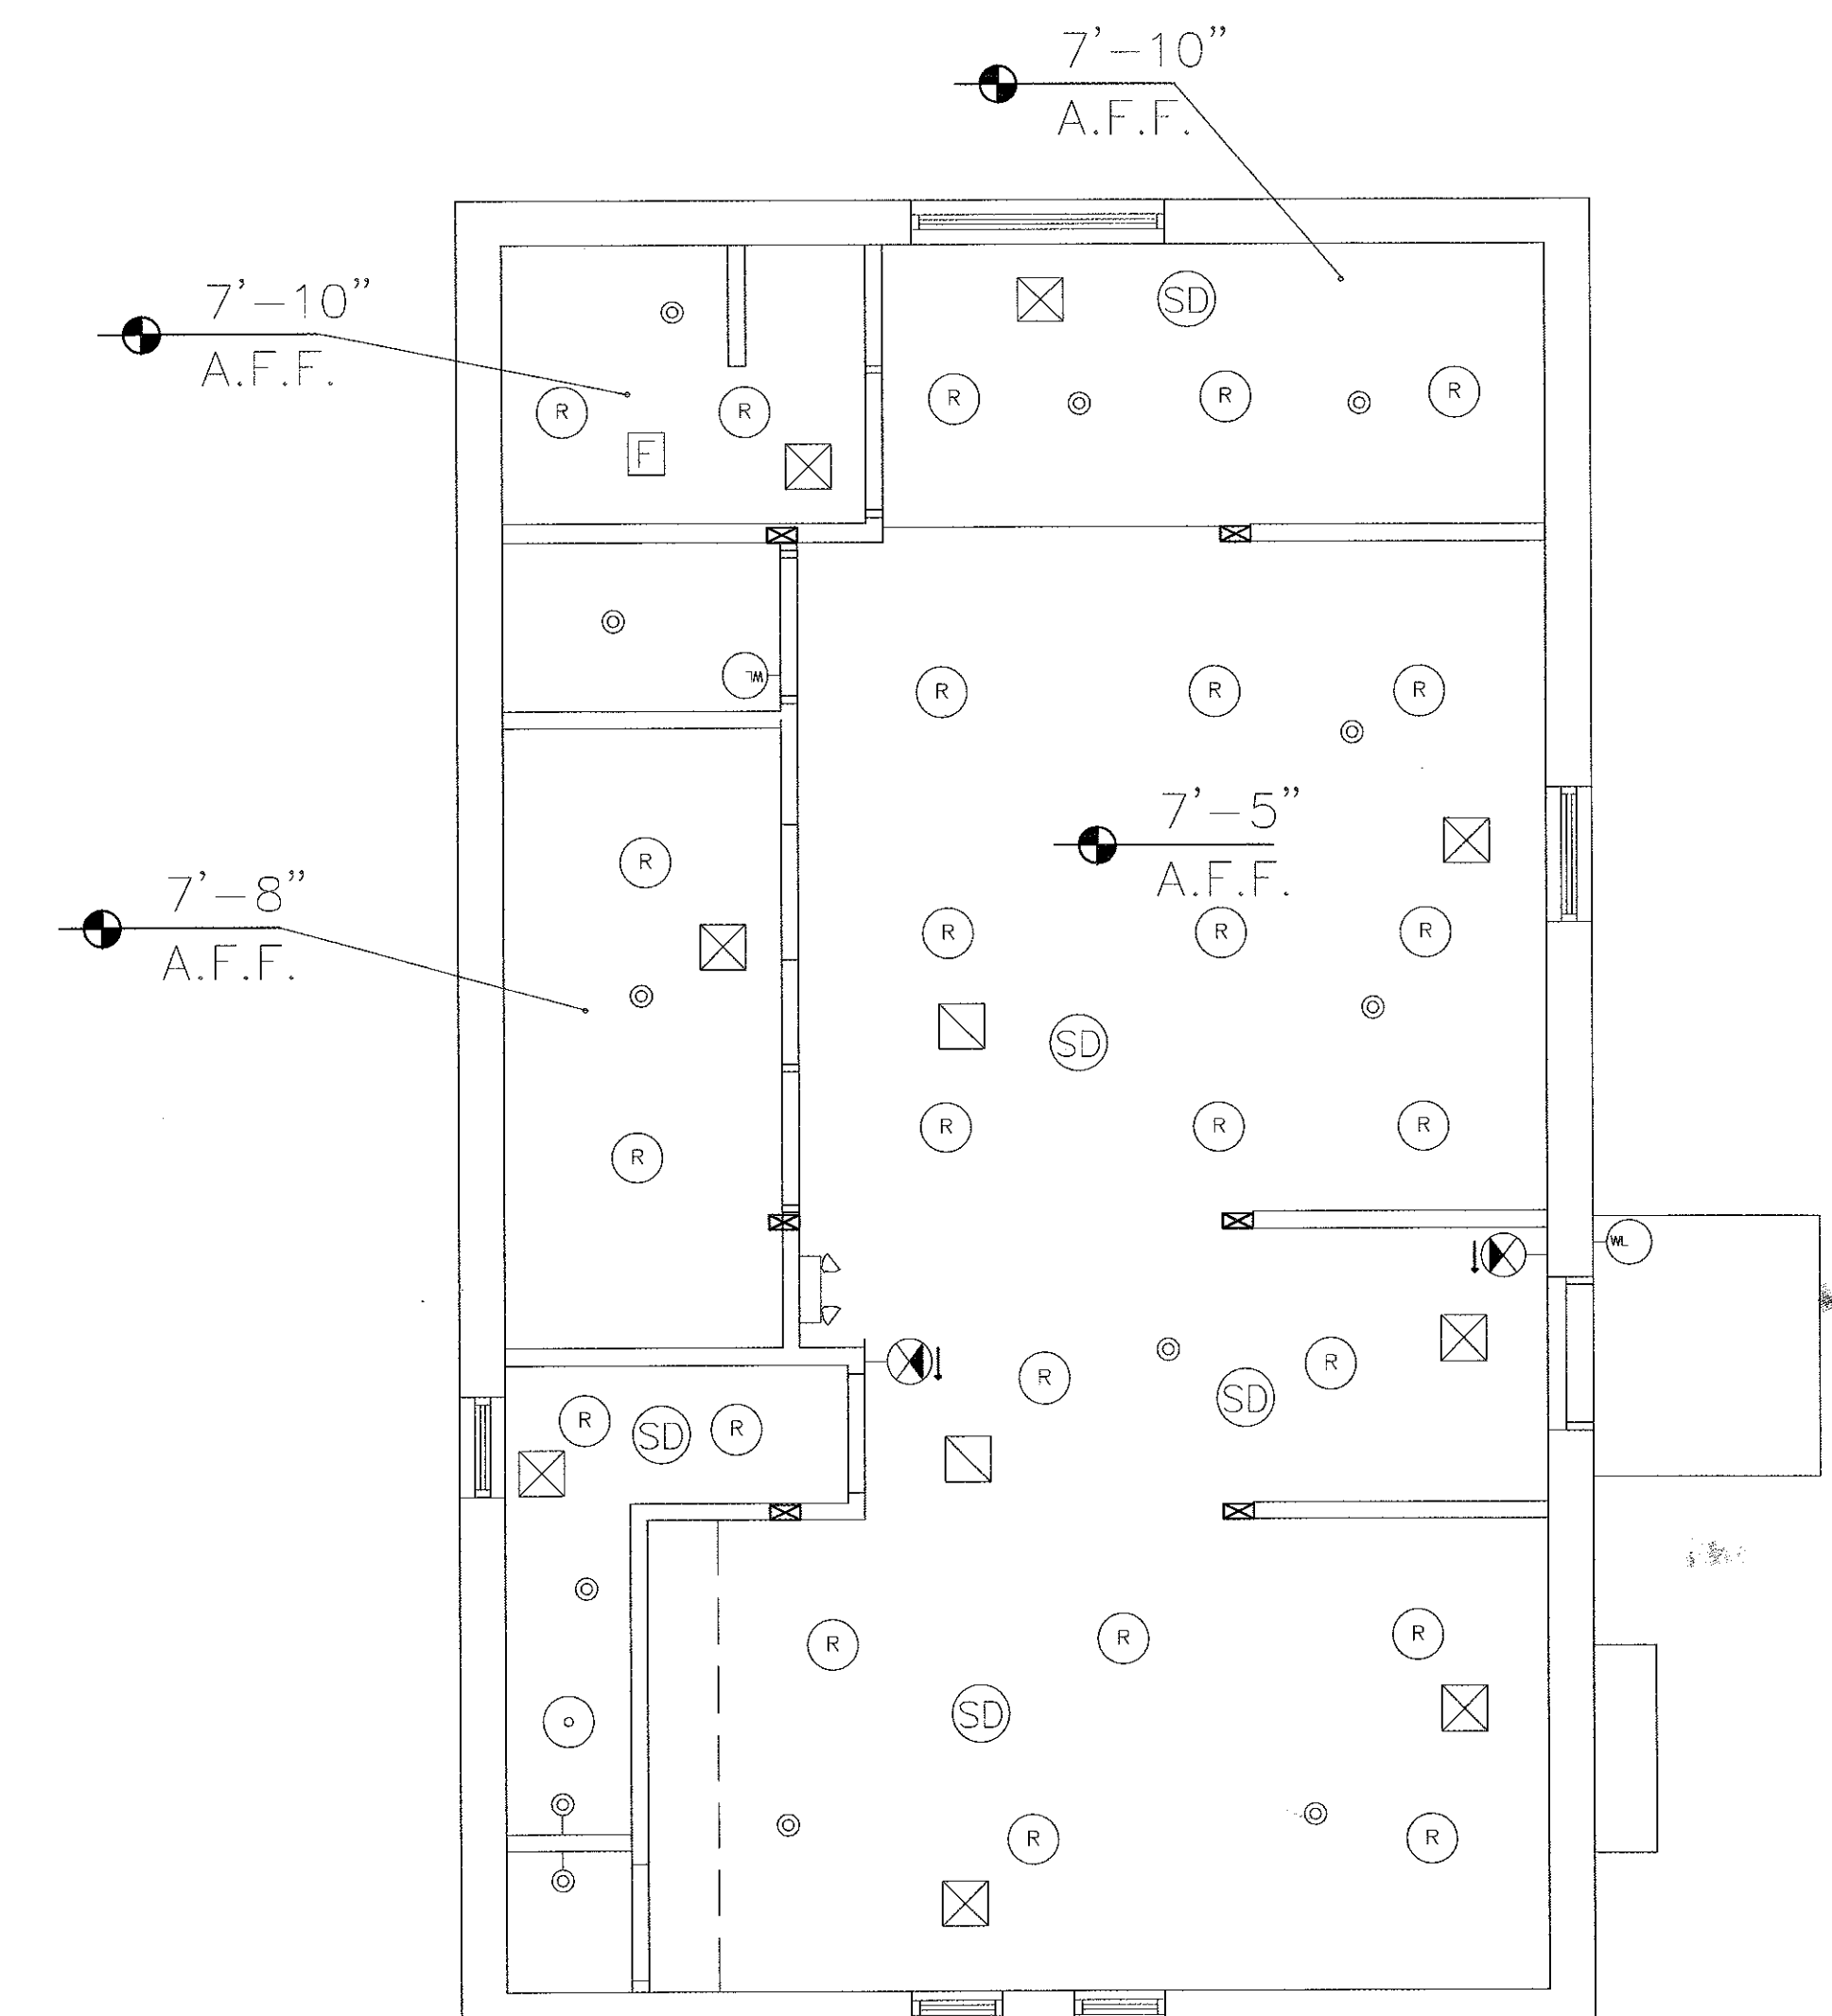


REFLECTED CEILING PLAN - SECOND FLOOR

Scale: 1/4" = 1'



BRIGHT FUTURE EARLY LEARNING CENTER LLC
2535 BLADENSBURG ROAD NE
WASHINGTON DC 20018 0000 000


- Ⓢ SMOKE DETECTOR
 - ◻ RETURN GRILLE*
 - ⊠ SUPPLY DIFFUSER*
 - ⊠ WALL MOUNTED EXIT SIGN
 - ⊠ CEILING MOUNTED EXIT SIGN
 - ⊠ EMERGENCY LIGHTS
 - ⊙ SPRINKLER HEAD
 - ⊙ WALL MOUNTED SPRINKLER HEAD
 - ⊙ ELEC. OUTLET
 - ⊙ DATA OUTLET
 - ▬ RECESSED PANEL BOARD
 - COVER PLATE
 - Ⓜ JUNCTION BOX
 - Ⓡ RECESSED LIGHT FIXTURE
 - Ⓢ SURFACE MOUNTED LIGHT FIXTURE
 - Ⓢ WALL MOUNTED LIGHT FIXTURE
 - Ⓢ SERVICE LIGHT WITH PULL SWITCH
 - Ⓢ SWITCH
 - Ⓢ DOOR BELL
 - Ⓢ THERMOSTAT
 - Ⓢ ALARM PANEL
 - Ⓢ WALL REGISTER*
 - Ⓢ AIR HANDLING UNIT
 - Ⓢ WATER HEATER
 - Ⓢ WATER CONNECTION (WASHER)
 - Ⓢ DRINKING FOUNTAIN
 - Ⓢ EXHAUST FAN
 - DW DISH WASHER
 - MW MICROWAVE
 - Ⓢ FIRE ANNUNCIATOR PANEL
 - Ⓢ FIRE EXTINGUISHER
- *TYPICAL 400 CFM
@ EACH S/R

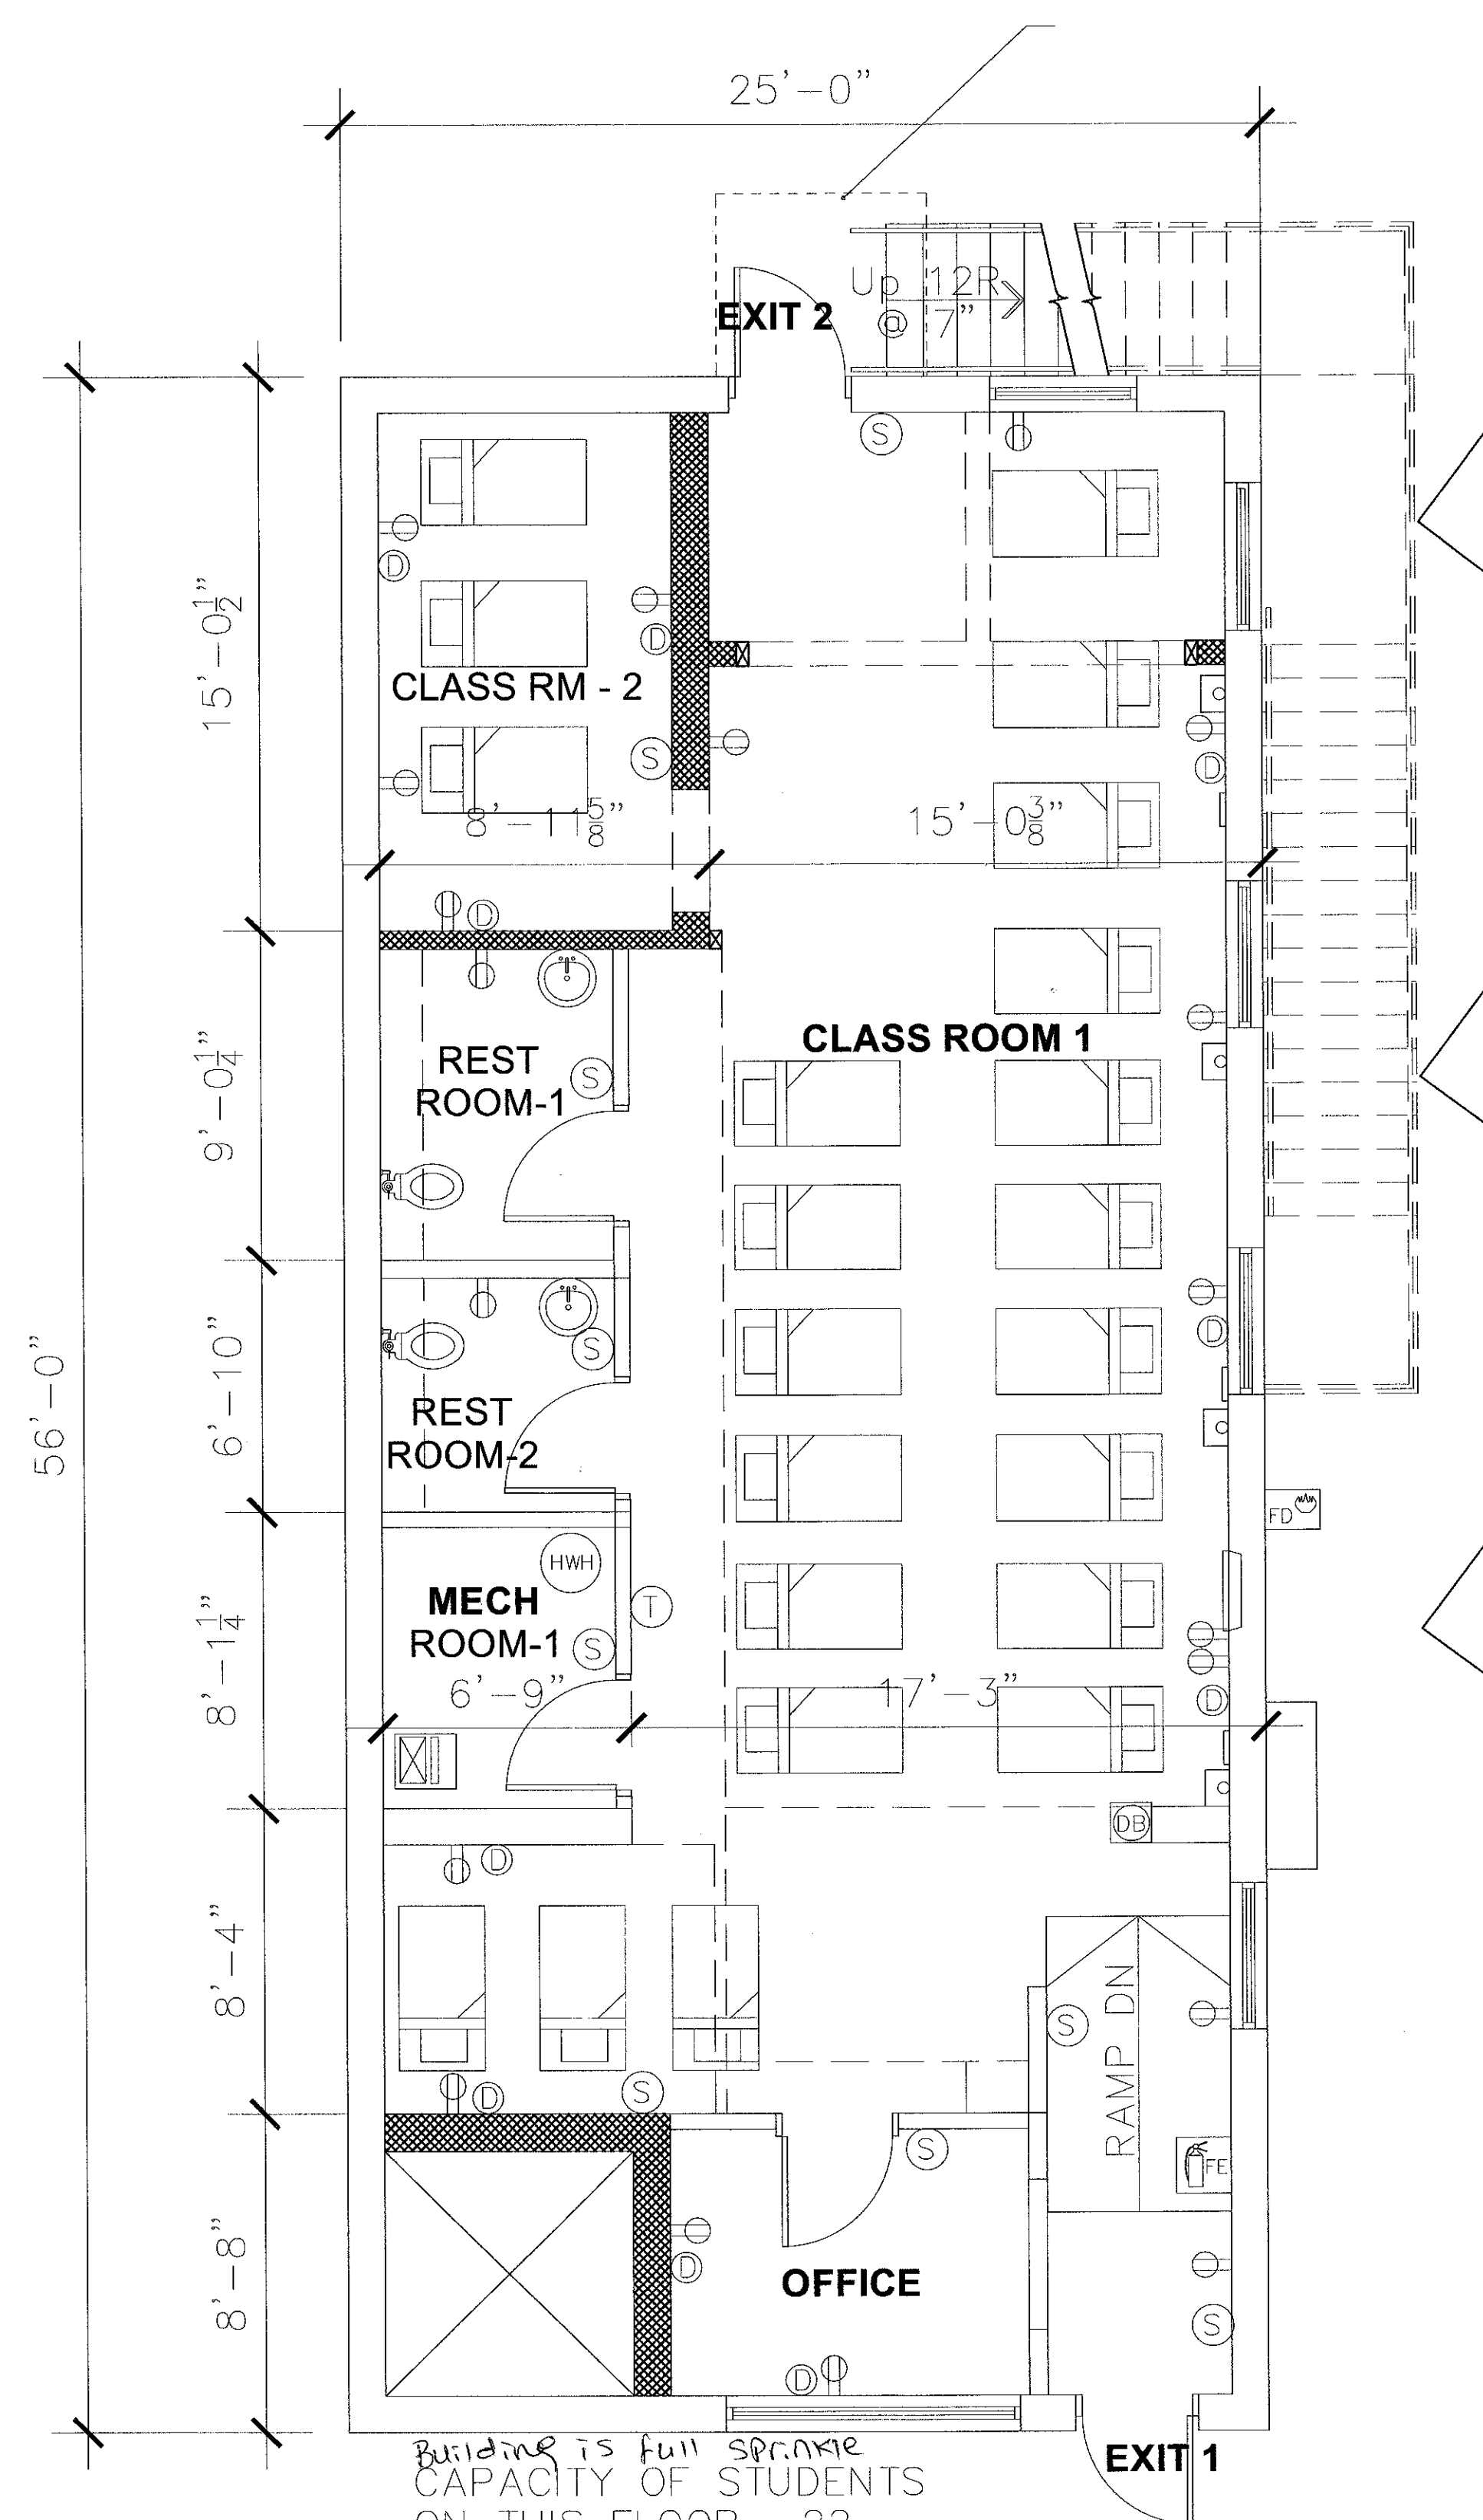

PLAN - GROUND FLOOR

Scale: 1/4" = 1'

THESE PLANS ARE MADE TO BE COMPLIANT WITH THE FOLLOWING CODES:
IBC 2012
DCMR 2013

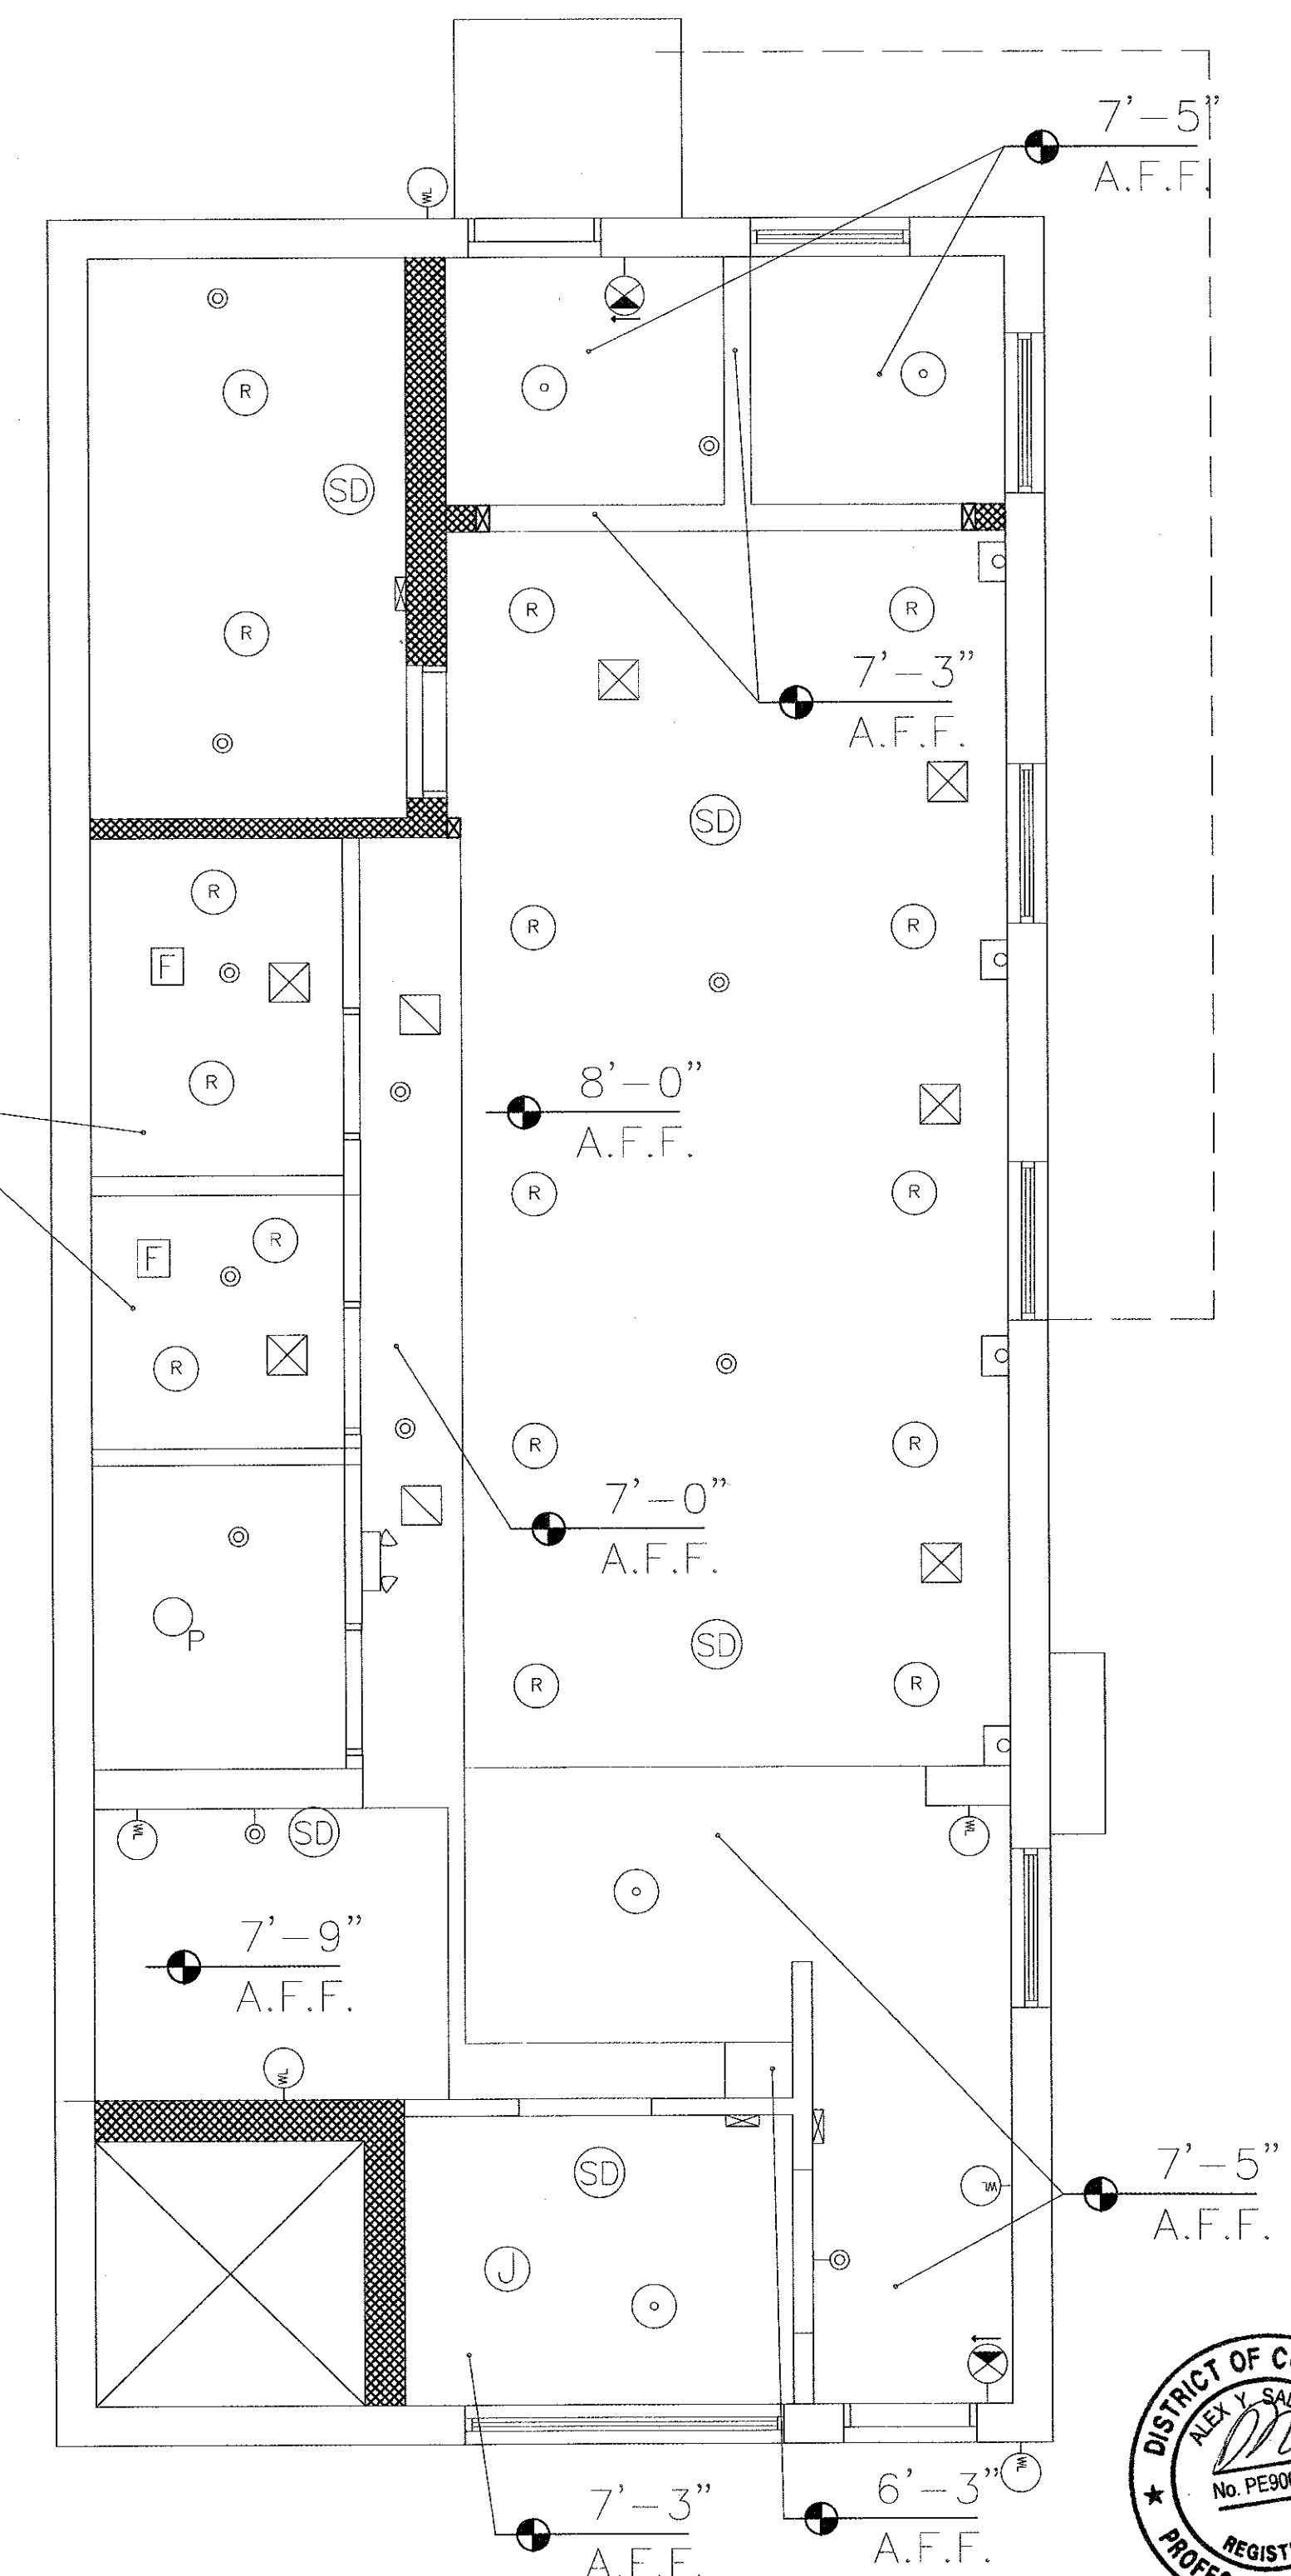


REFLECTED CEILING PLAN -GROUND FLOOR

Scale: 1/4" = 1'

BRIGHT FUTURE EARLY LEARNING CENTER LLC
2535 BLADENSBURG ROAD NE
WASHINGTON DC 20018 0000 000



- *TYPICAL 400 CFM
@ EACH S/R

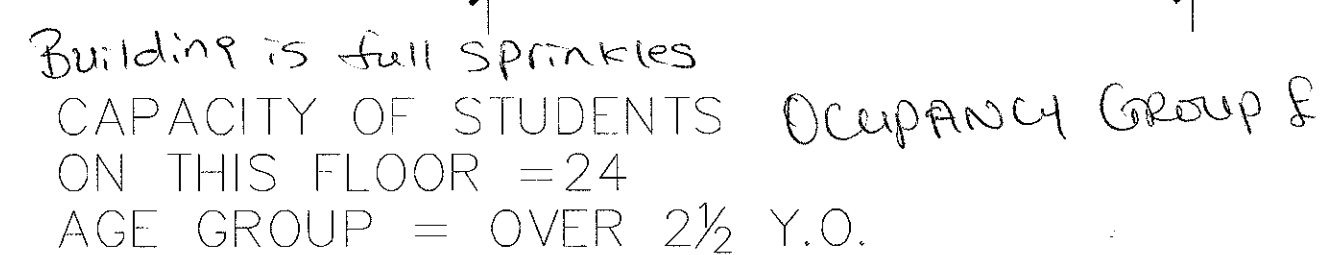

Scale: 1/4" = 1'


[illegible]

Scale: 1/4" = 1'

BRIGHT FUTURE EARLY LEARNING CENTER LLC
2535 BLADENSBURG ROAD NE
WASHINGTON DC 20018 0000 000

- ⊙ SMOKE DETECTOR
- RETURN GRILLE*
- ⊗ SUPPLY DIFFUSER*
- ⊠ WALL MOUNTED EXIT SIGN
- ⊡ CEILING MOUNTED EXIT SIGN
- ⊢ EMERGENCY LIGHTS
- ⊙ SPRINKLER HEAD
- ⊠ WALL MOUNTED SPRINKLER HEAD
- ⊙ ELEC. OUTLET
- ⊙ DATA OUTLET
- ▬ RECESSED PANEL BOARD
- COVER PLATE
- ⊙ JUNCTION BOX
- ⊙ RECESSED LIGHT FIXTURE
- ⊙ SURFACE MOUNTED LIGHT FIXTURE
- ⊠ WALL MOUNTED LIGHT FIXTURE
- ⊙ SERVICE LIGHT WITH PULL SWITCH
- ⊙ SWITCH
- ⊠ DOOR BELL
- ⊠ THERMOSTAT
- ⊠ ALARM PANEL
- ⊠ WALL REGISTER*
- ⊠ AIR HANDLING UNIT
- ⊠ WATER HEATER
- ⊠ WATER CONNECTION (WASHER)
- ⊠ DRINKING FOUNTAIN
- ⊠ EXHAUST FAN
- DW DISH WASHER
- MW MICROWAVE
- ⊠ FIRE ANNUNCIATOR PANEL
- ⊠ FIRE EXTINGUISHER

*TYPICAL 400 CFM
⊙ EACH S/R

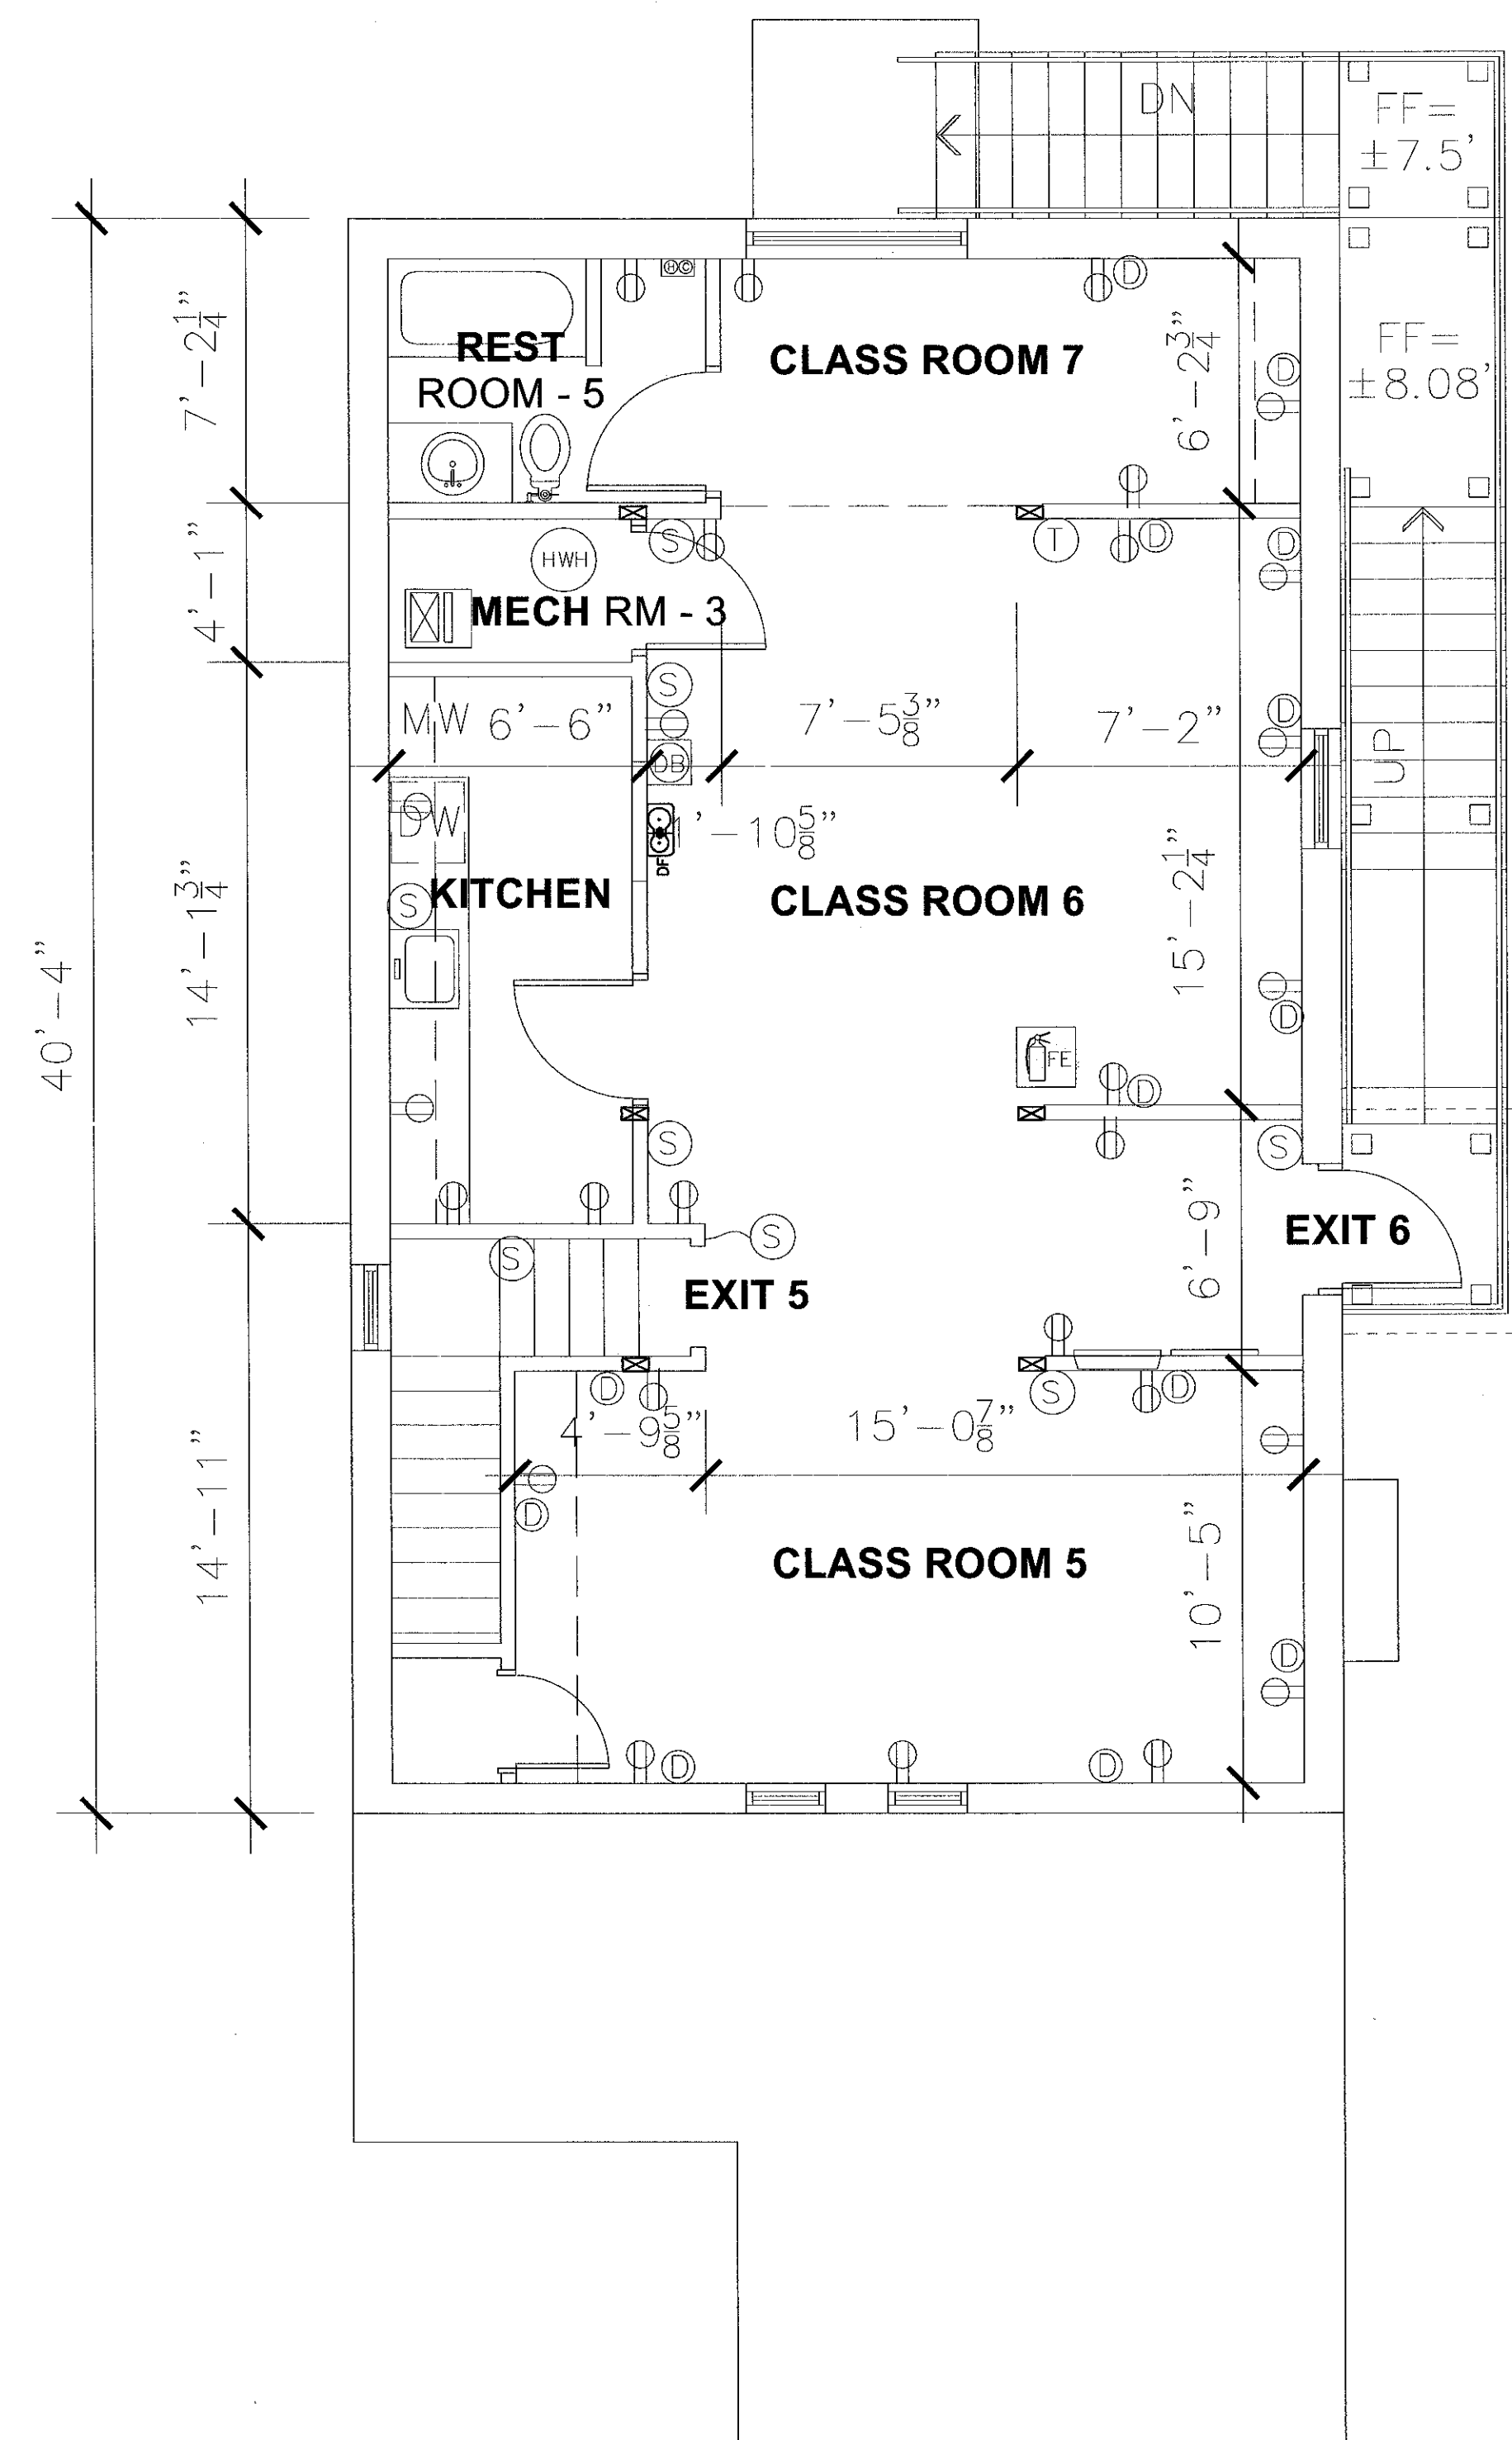


CAPACITY OF STUDENTS Occupancy Group E
ON THIS FLOOR = 17
AGE GROUP = OVER 2 1/2 Y.O.
Building is Full Sprinkler

PLAN - SECOND FLOOR


Scale: 1/4" = 1'

THESE PLANS ARE MADE TO BE COMPLIANT WITH THE
FOLLOWING CODES:
IBC 2012
DCMR 2013

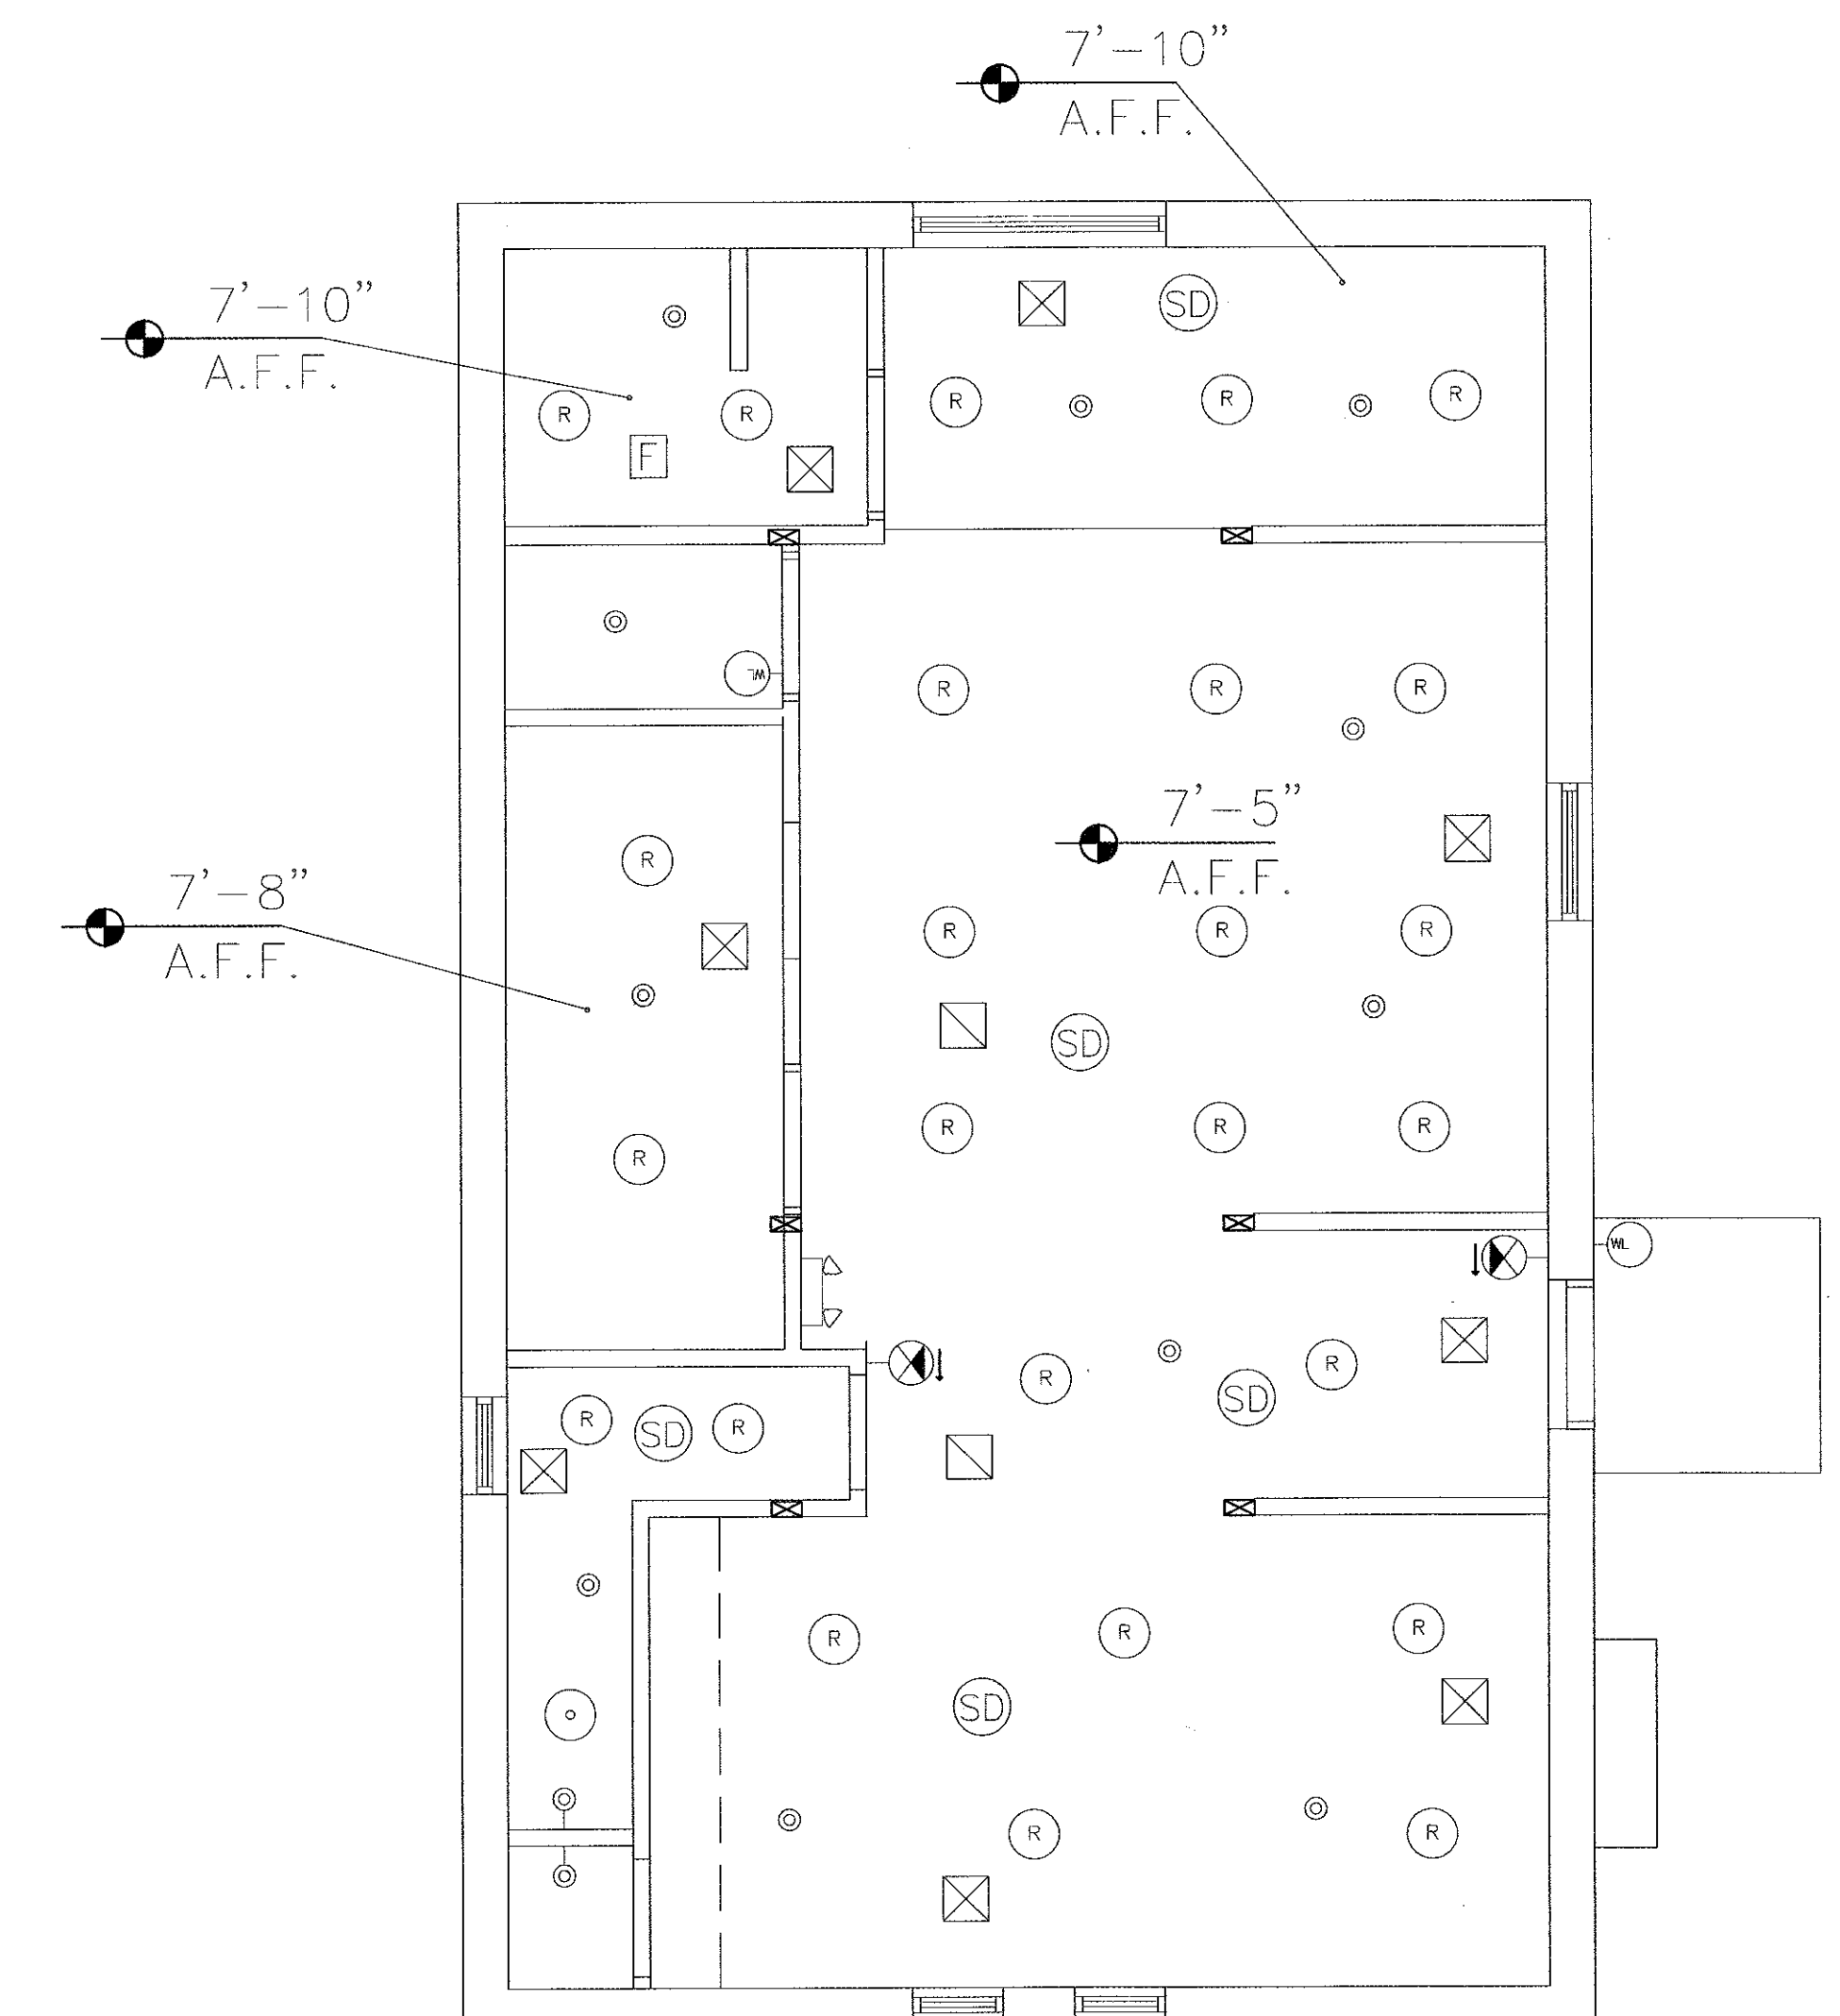


REFLECTED CEILING PLAN - SECOND FLOOR

Scale: 1/4" = 1'

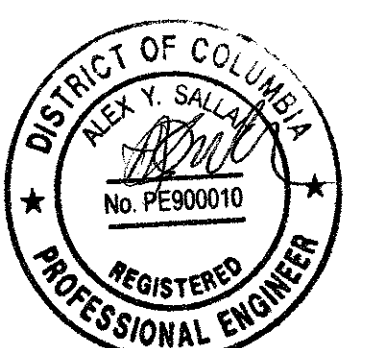

BRIGHT FUTURE EARLY LEARNING CENTER LLC
2535 BLADENSBURG ROAD NE
WASHINGTON DC 20018 0000 000


- (SD) SMOKE DETECTOR
 - RETURN GRILLE*
 - ⊗ SUPPLY DIFFUSER*
 - ⊗ WALL MOUNTED EXIT SIGN
 - ⊗ CEILING MOUNTED EXIT SIGN
 - ⊗ EMERGENCY LIGHTS
 - ⊗ SPRINKLER HEAD
 - ⊗ WALL MOUNTED SPRINKLER HEAD
 - ⊗ ELEC. OUTLET
 - ⊗ DATA OUTLET
 - ▬ RECESSED PANEL BOARD
 - COVER PLATE
 - ⊗ JUNCTION BOX
 - ⊗ RECESSED LIGHT FIXTURE
 - ⊗ SURFACE MOUNTED LIGHT FIXTURE
 - ⊗ WALL MOUNTED LIGHT FIXTURE
 - ⊗ SERVICE LIGHT WITH PULL SWITCH
 - ⊗ SWITCH
 - ⊗ DOOR BELL
 - ⊗ THERMOSTAT
 - ⊗ ALARM PANEL
 - ⊗ WALL REGISTER*
 - ⊗ AIR HANDLING UNIT
 - ⊗ WATER HEATER
 - ⊗ WATER CONNECTION (WASHER)
 - ⊗ DRINKING FOUNTAIN
 - ⊗ EXHAUST FAN
 - DW DISH WASHER
 - MW MICROWAVE
 - ⊗ FIRE ANNUNCIATOR PANEL
 - ⊗ FIRE EXTINGUISHER
- *TYPICAL 400 CFM
@ EACH S/R

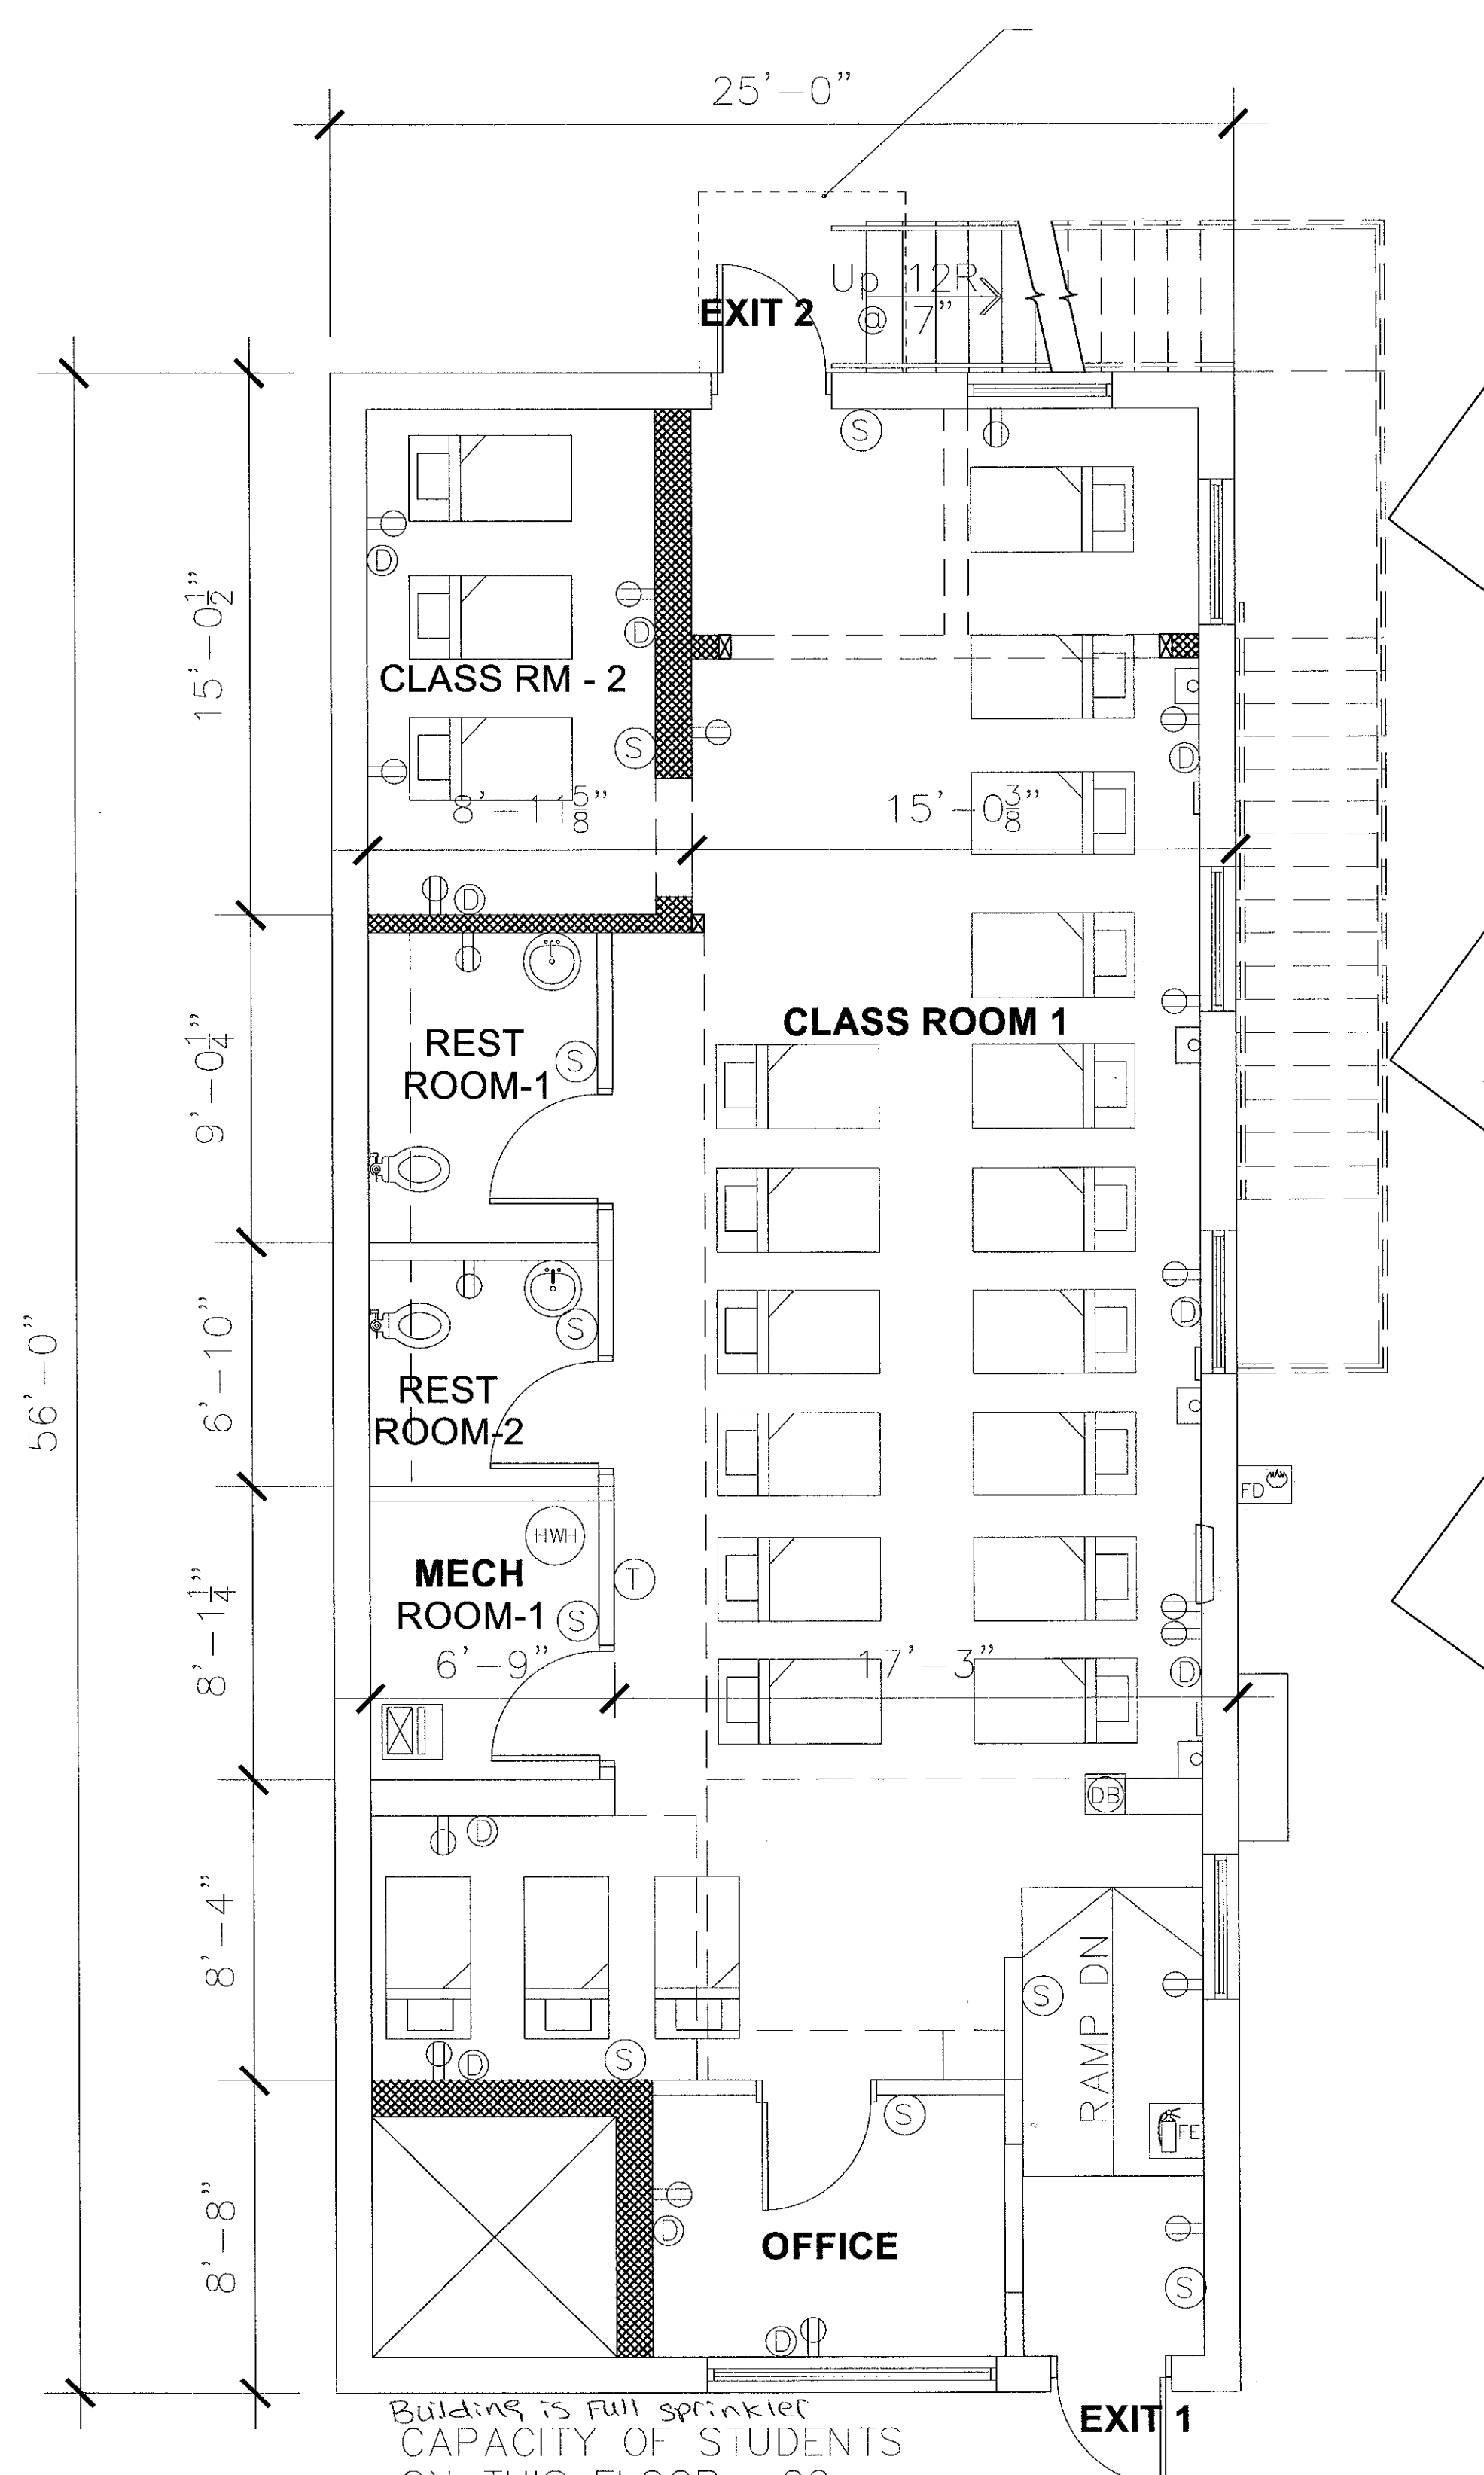

Building is full sprinkler
CAPACITY OF STUDENTS
ON THIS FLOOR = 22
AGE GROUP = UNDER 2½ Y.O. OCCUPANCY Group I

PLAN - GROUND FLOOR
Scale: 1/4" = 1'

THESE PLANS ARE MADE TO BE COMPLIANT WITH THE
FOLLOWING CODES:
IBC 2012
DCMR 2013

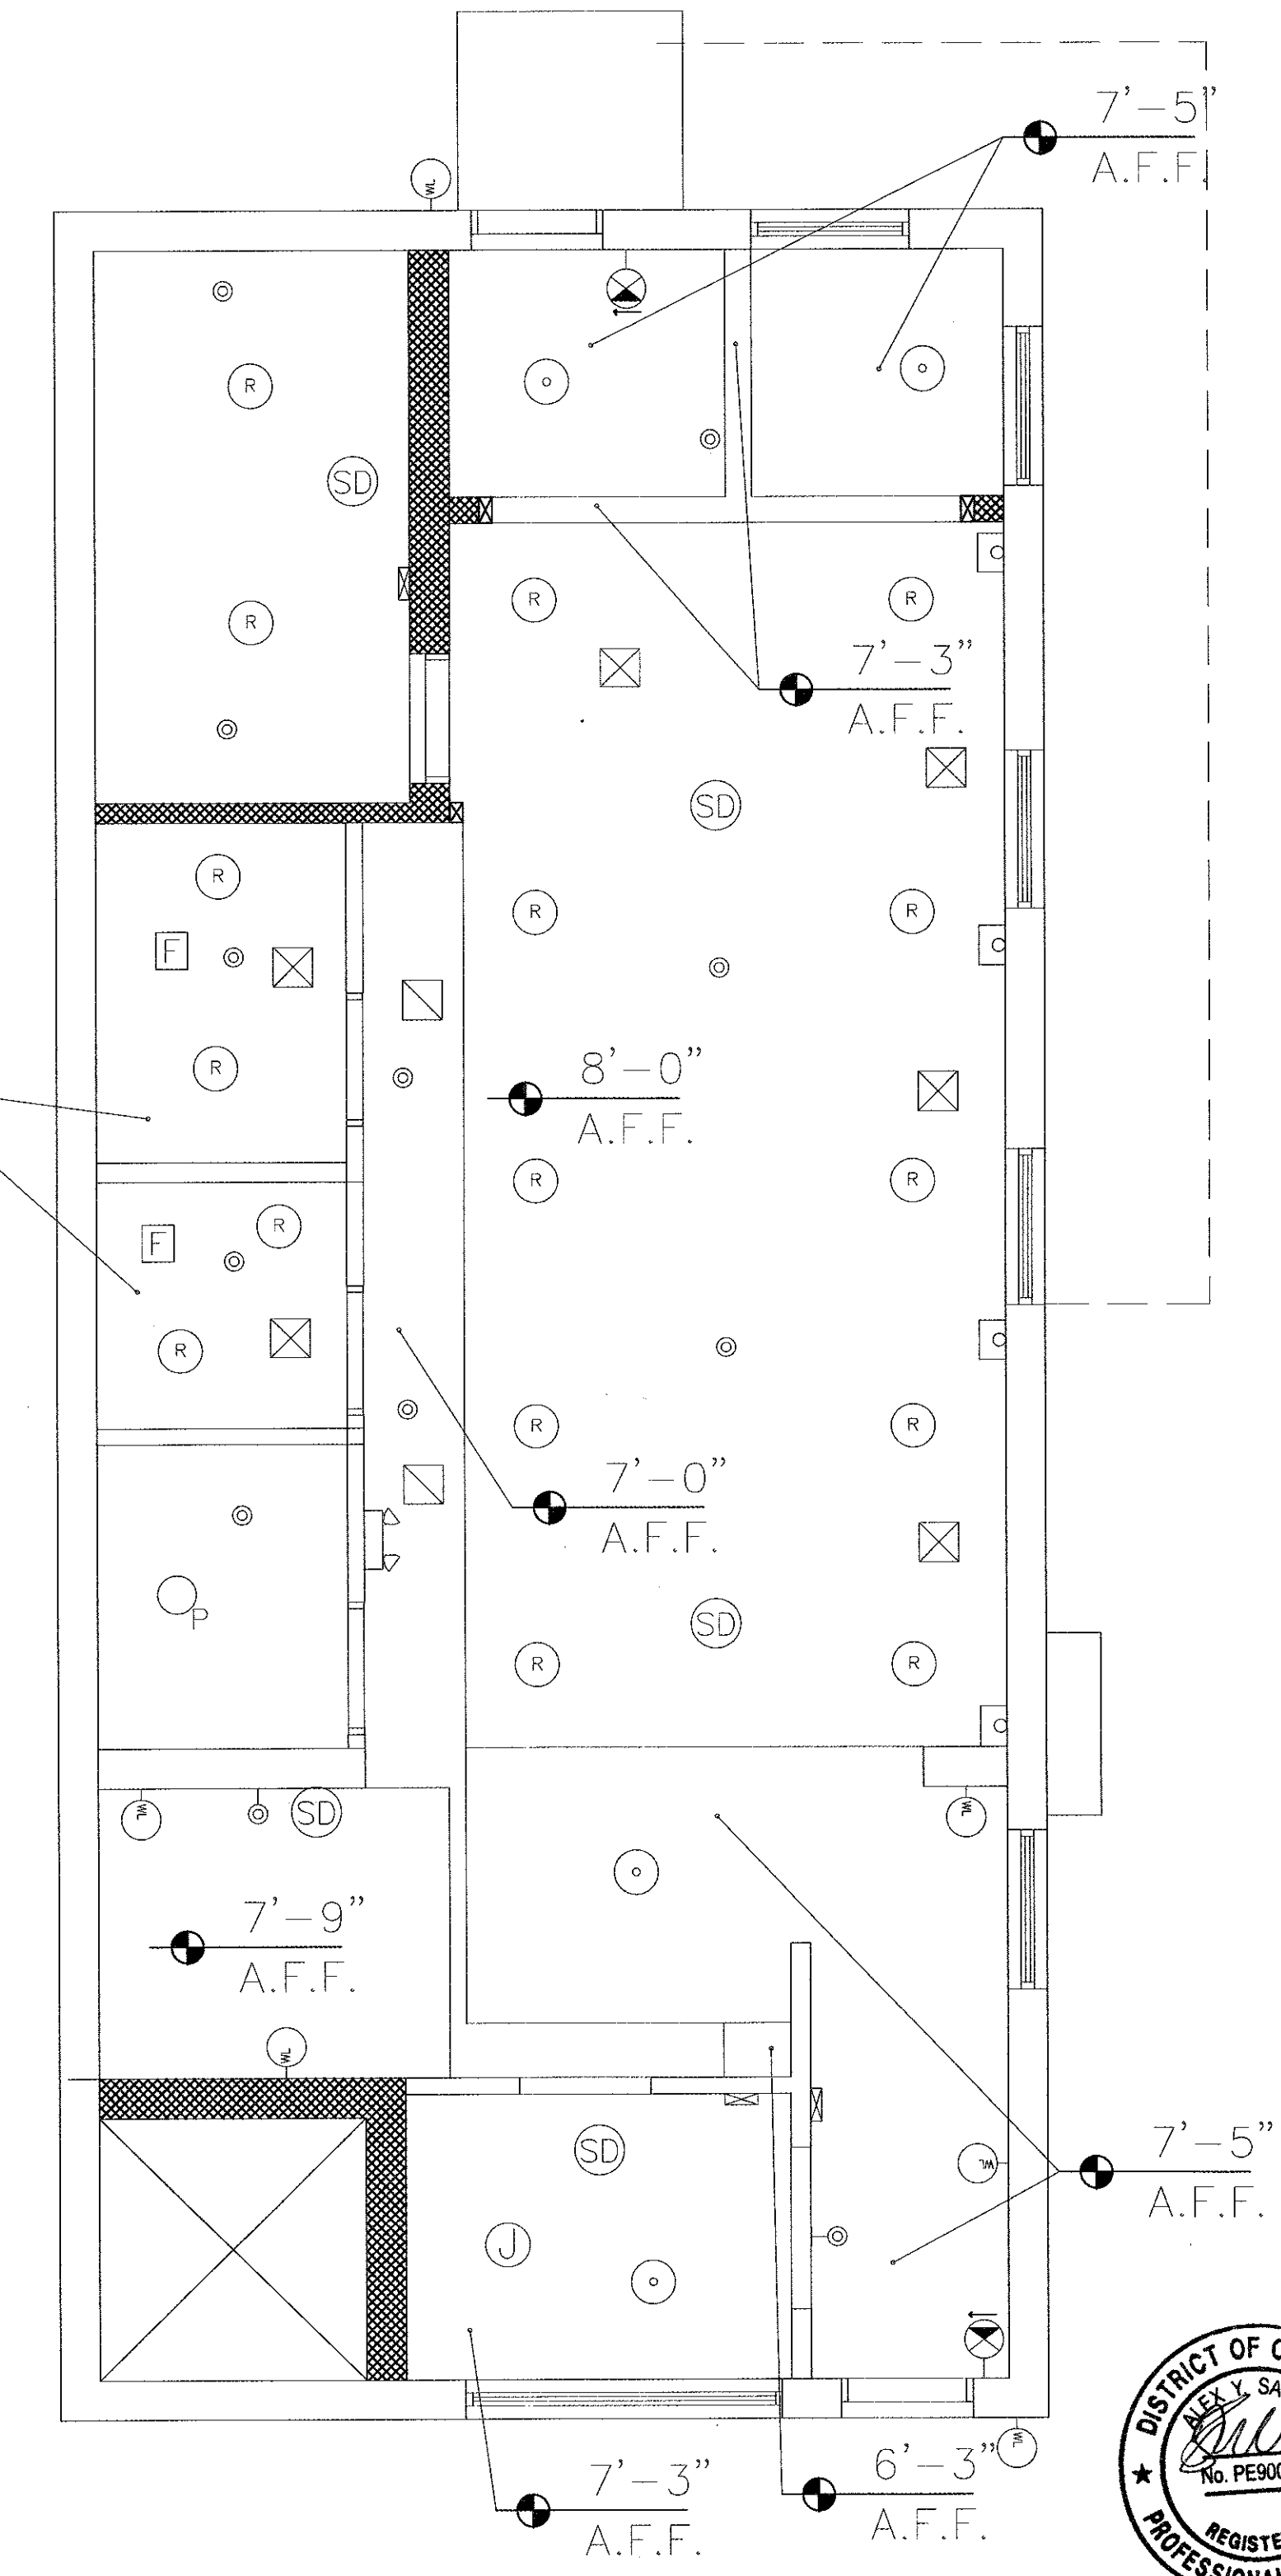


REFLECTED CEILING PLAN -GROUND FLOOR
Scale: 1/4" = 1'



BRIGHT FUTURE EARLY LEARNING CENTER LLC
2535 BLADENSBURG ROAD NE
WASHINGTON DC 20018 0000 000


- ⊙ SMOKE DETECTOR
 - RETURN GRILLE*
 - ⊗ SUPPLY DIFFUSER*
 - ⊕ WALL MOUNTED EXIT SIGN
 - ⊕ CEILING MOUNTED EXIT SIGN
 - ⊕ EMERGENCY LIGHTS
 - ⊙ SPRINKLER HEAD
 - ⊕ WALL MOUNTED SPRINKLER HEAD
 - ⊕ ELEC. OUTLET
 - ⊕ DATA OUTLET
 - ⊕ RECESSED PANEL BOARD
 - ⊕ COVER PLATE
 - ⊕ JUNCTION BOX
 - ⊕ RECESSED LIGHT FIXTURE
 - ⊕ SURFACE MOUNTED LIGHT FIXTURE
 - ⊕ WALL MOUNTED LIGHT FIXTURE
 - ⊕ SERVICE LIGHT WITH PULL SWITCH
 - ⊕ SWITCH
 - ⊕ DOOR BELL
 - ⊕ THERMOSTAT
 - ⊕ ALARM PANEL
 - ⊕ WALL REGISTER*
 - ⊕ AIR HANDLING UNIT
 - ⊕ WATER HEATER
 - ⊕ WATER CONNECTION (WASHER)
 - ⊕ DRINKING FOUNTAIN
 - ⊕ EXHAUST FAN
 - DW DISH WASHER
 - MW MICROWAVE
 - ⊕ FIRE ANNUNCIATOR PANEL
 - ⊕ FIRE EXTINGUISHER
- *TYPICAL 400 CFM
@ EACH S/R

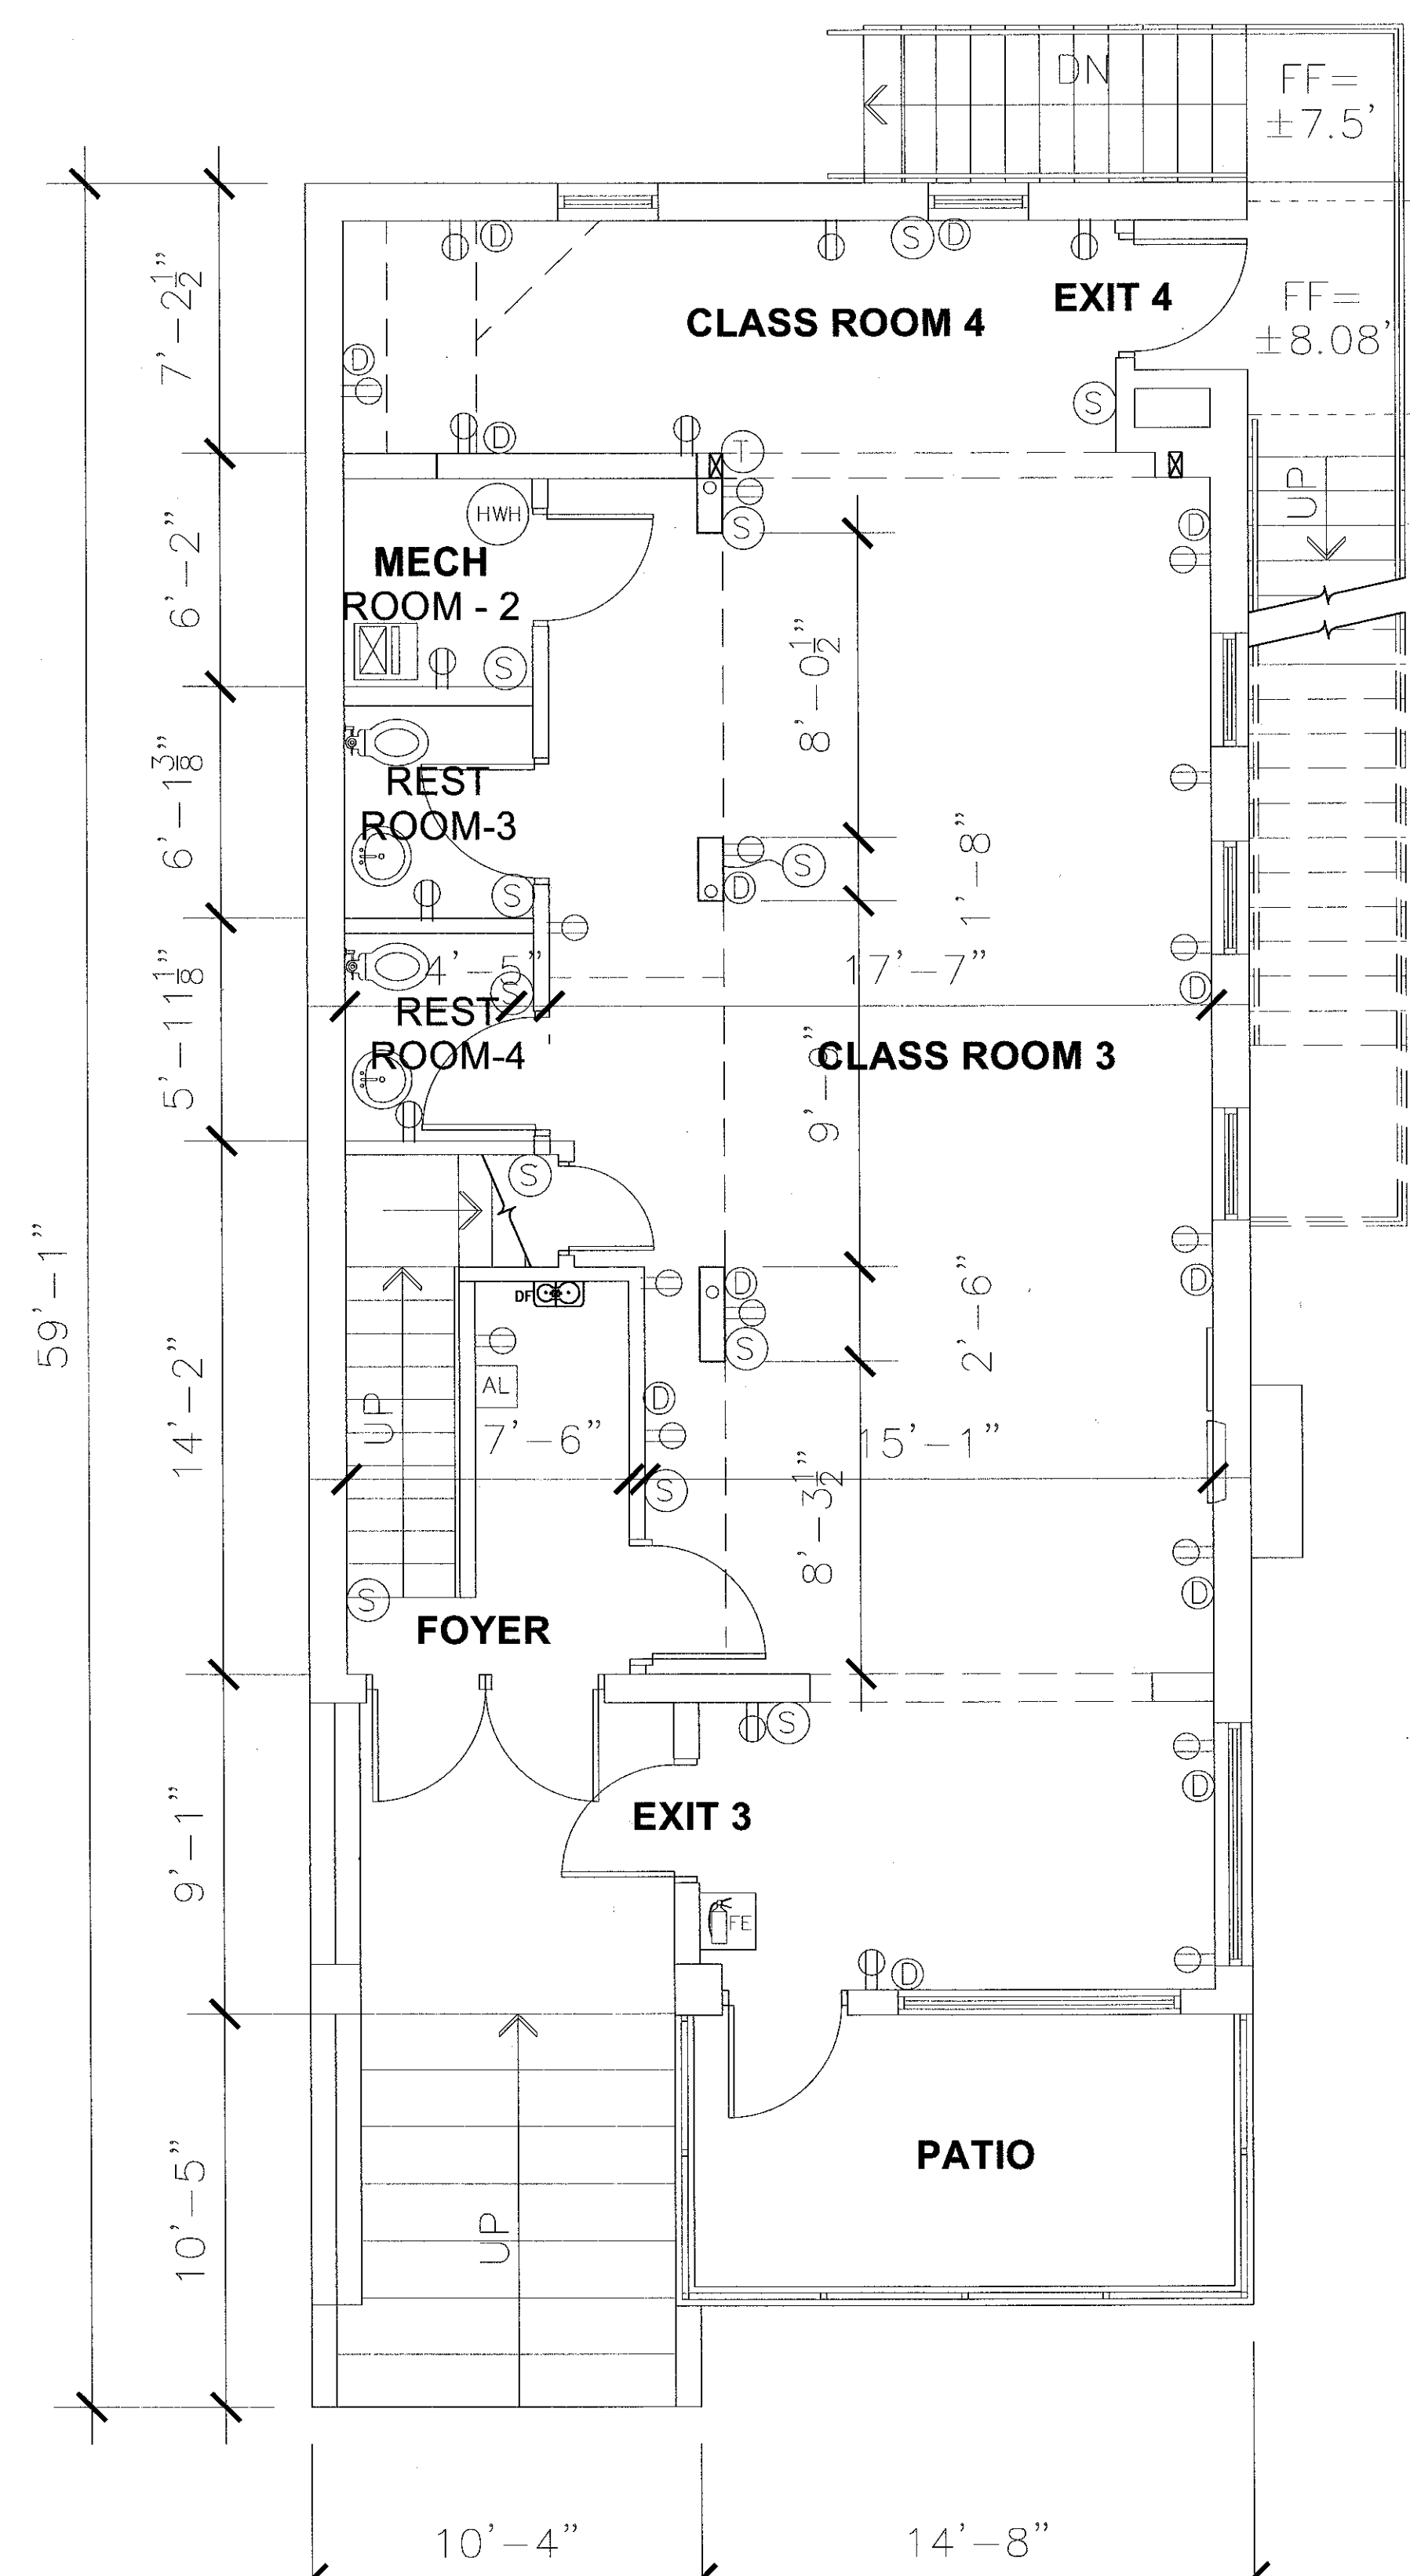


Building is FULL SPRINKLER
CAPACITY OF STUDENTS OCCUPANCY GROUP F
ON THIS FLOOR = 24
AGE GROUP = OVER 2½ Y.O.

PLAN - FIRST FLOOR
Scale: 1/4" = 1'

THESE PLANS ARE MADE TO BE COMPLIANT WITH THE
FOLLOWING CODES:
IBC 2012 F
DCMR 2013

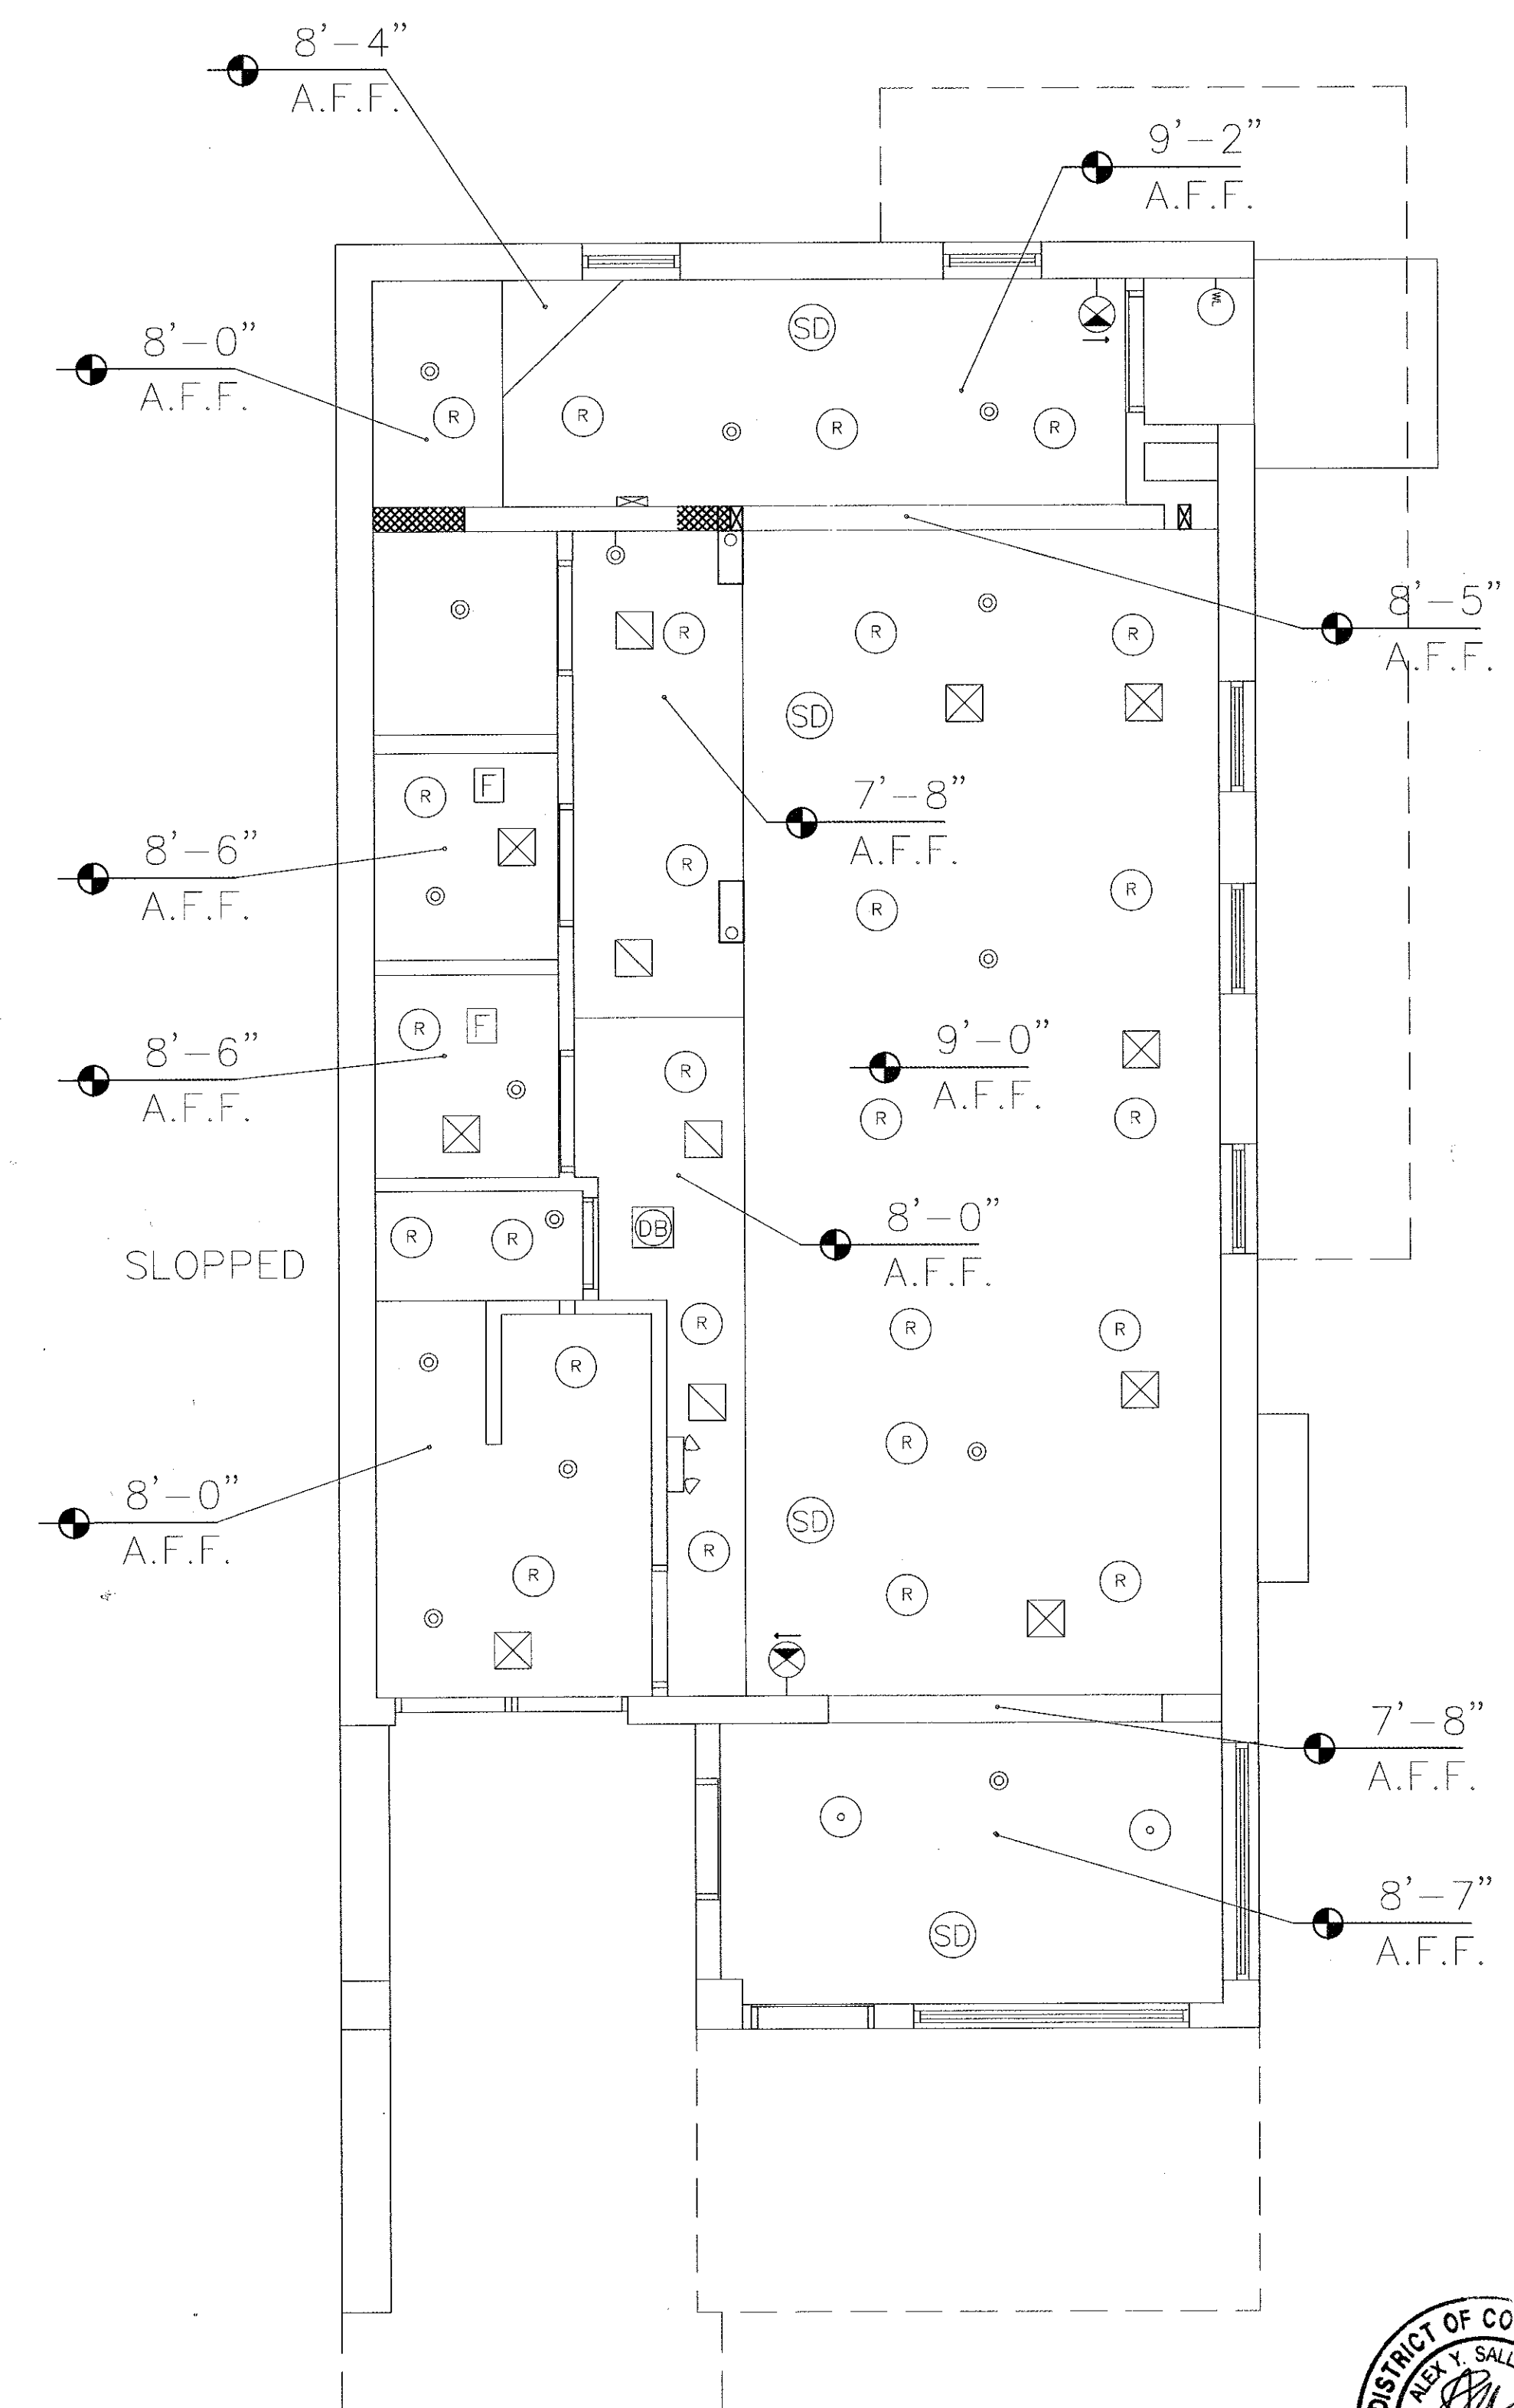

REFLECTED CEILING PLAN - FIRST FLOOR
Scale: 1/4" = 1'

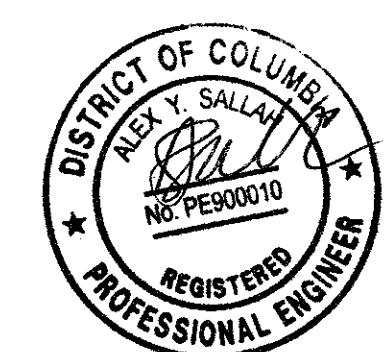

BRIGHT FUTURE EARLY LEARNING CENTER LLC
2535 BLADENSBURG ROAD NE
WASHINGTON DC 20018 0000 000