


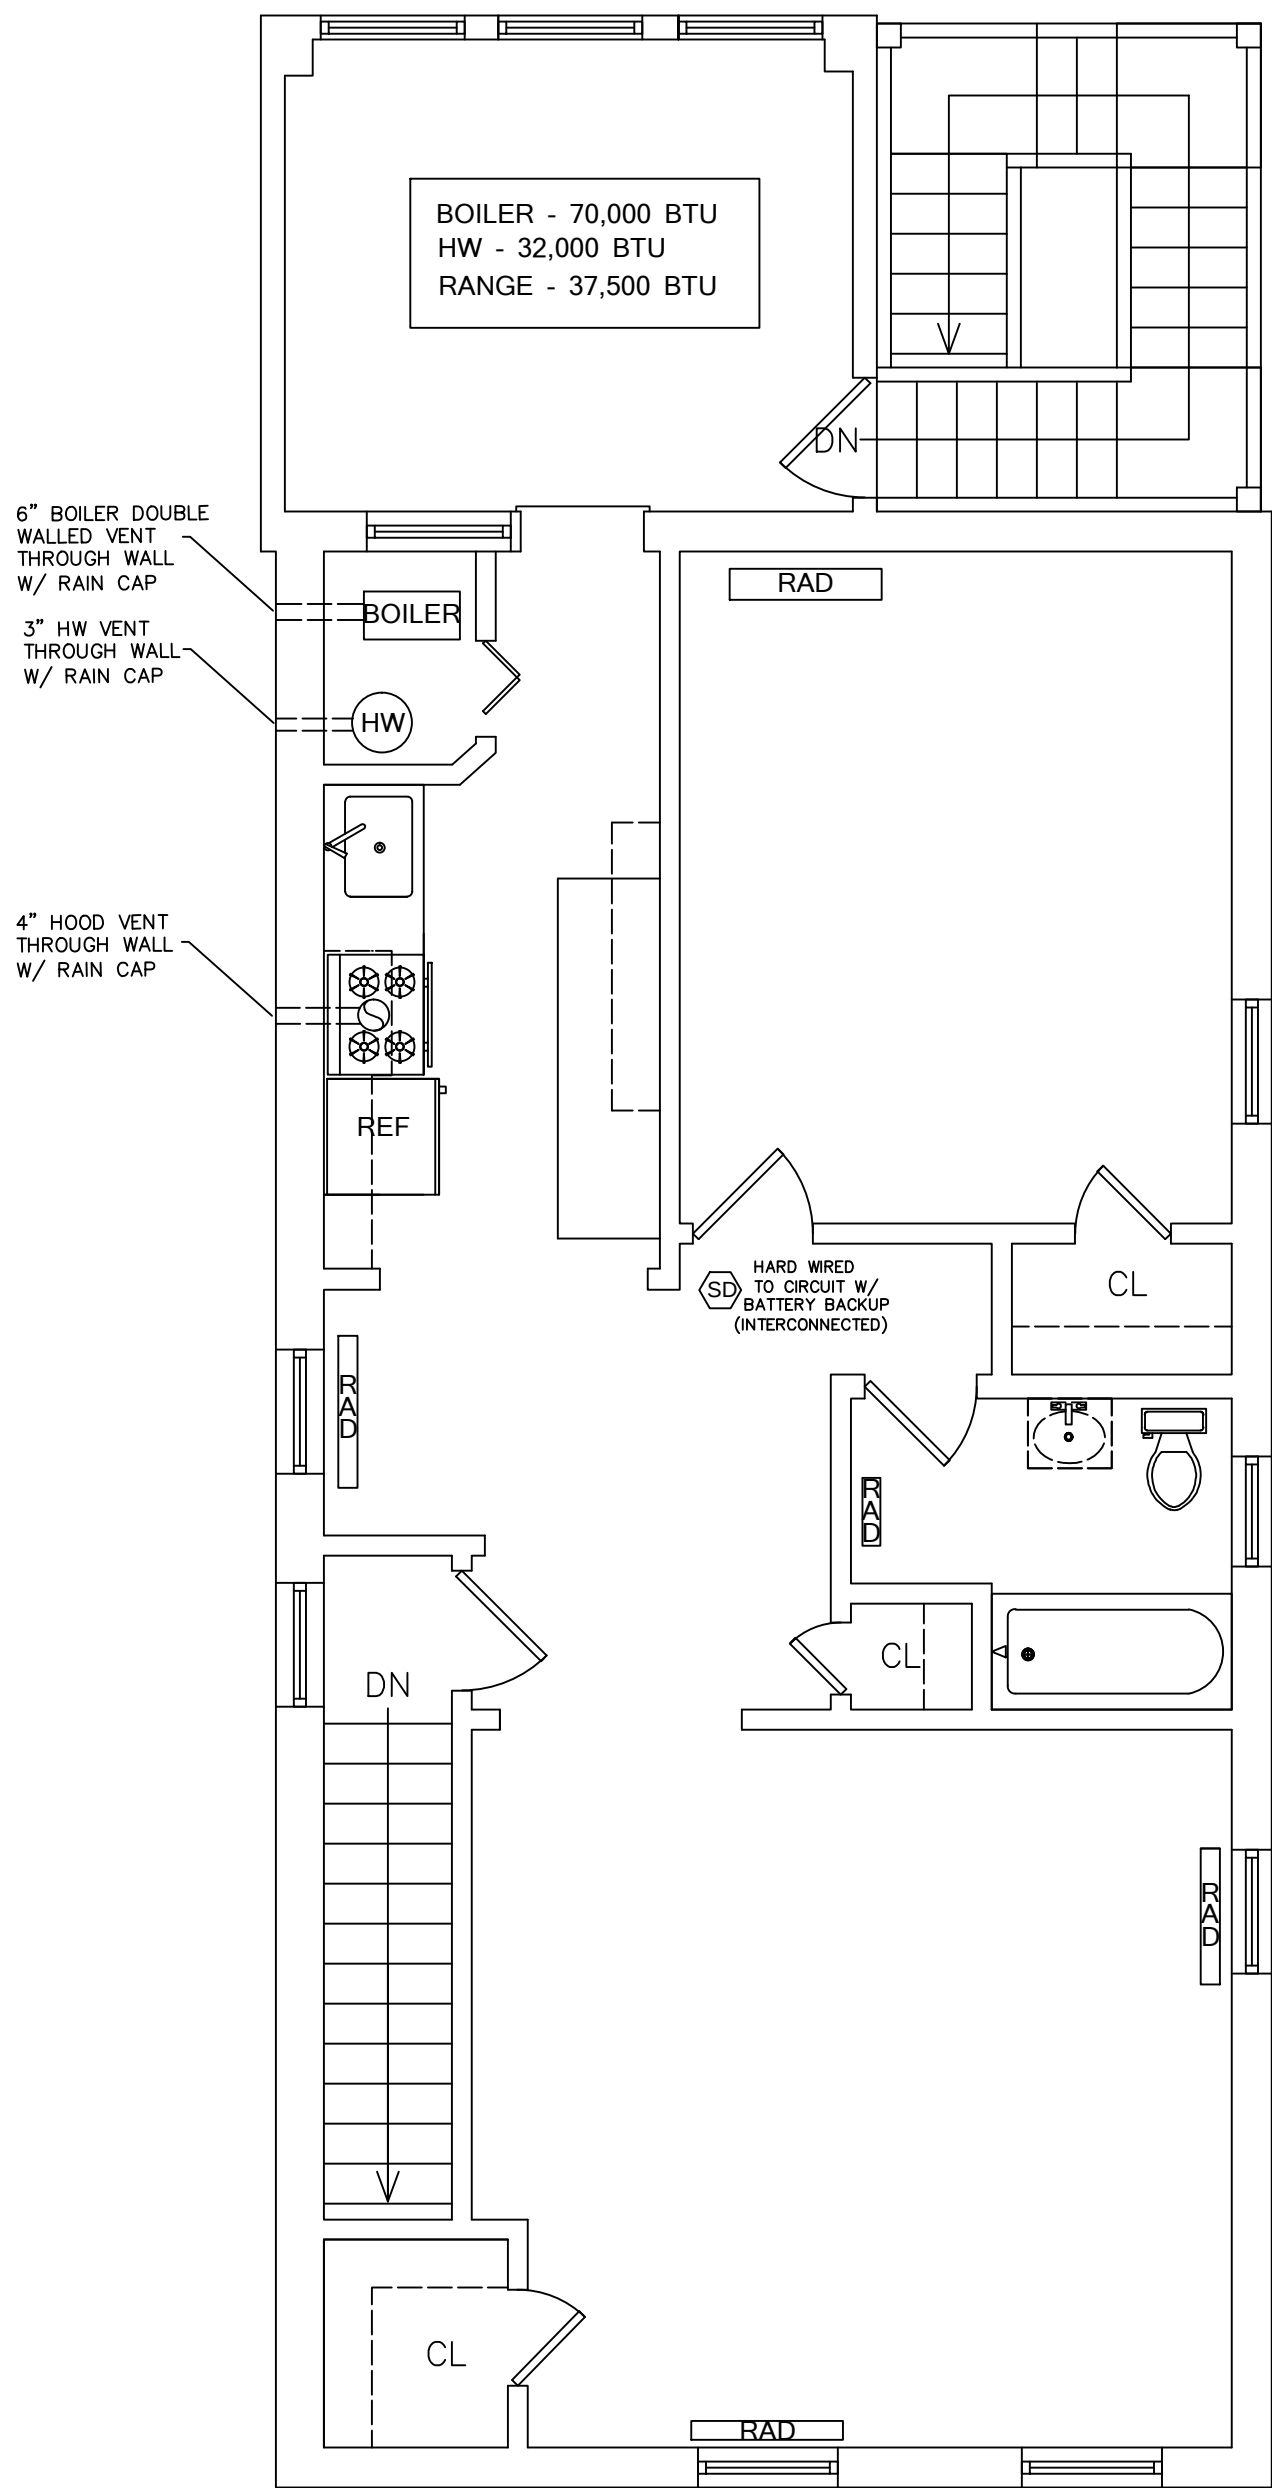


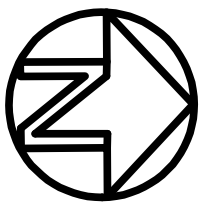


2ND FLOOR - MECHANICAL
SCALE: 1/4" = 1'-0"

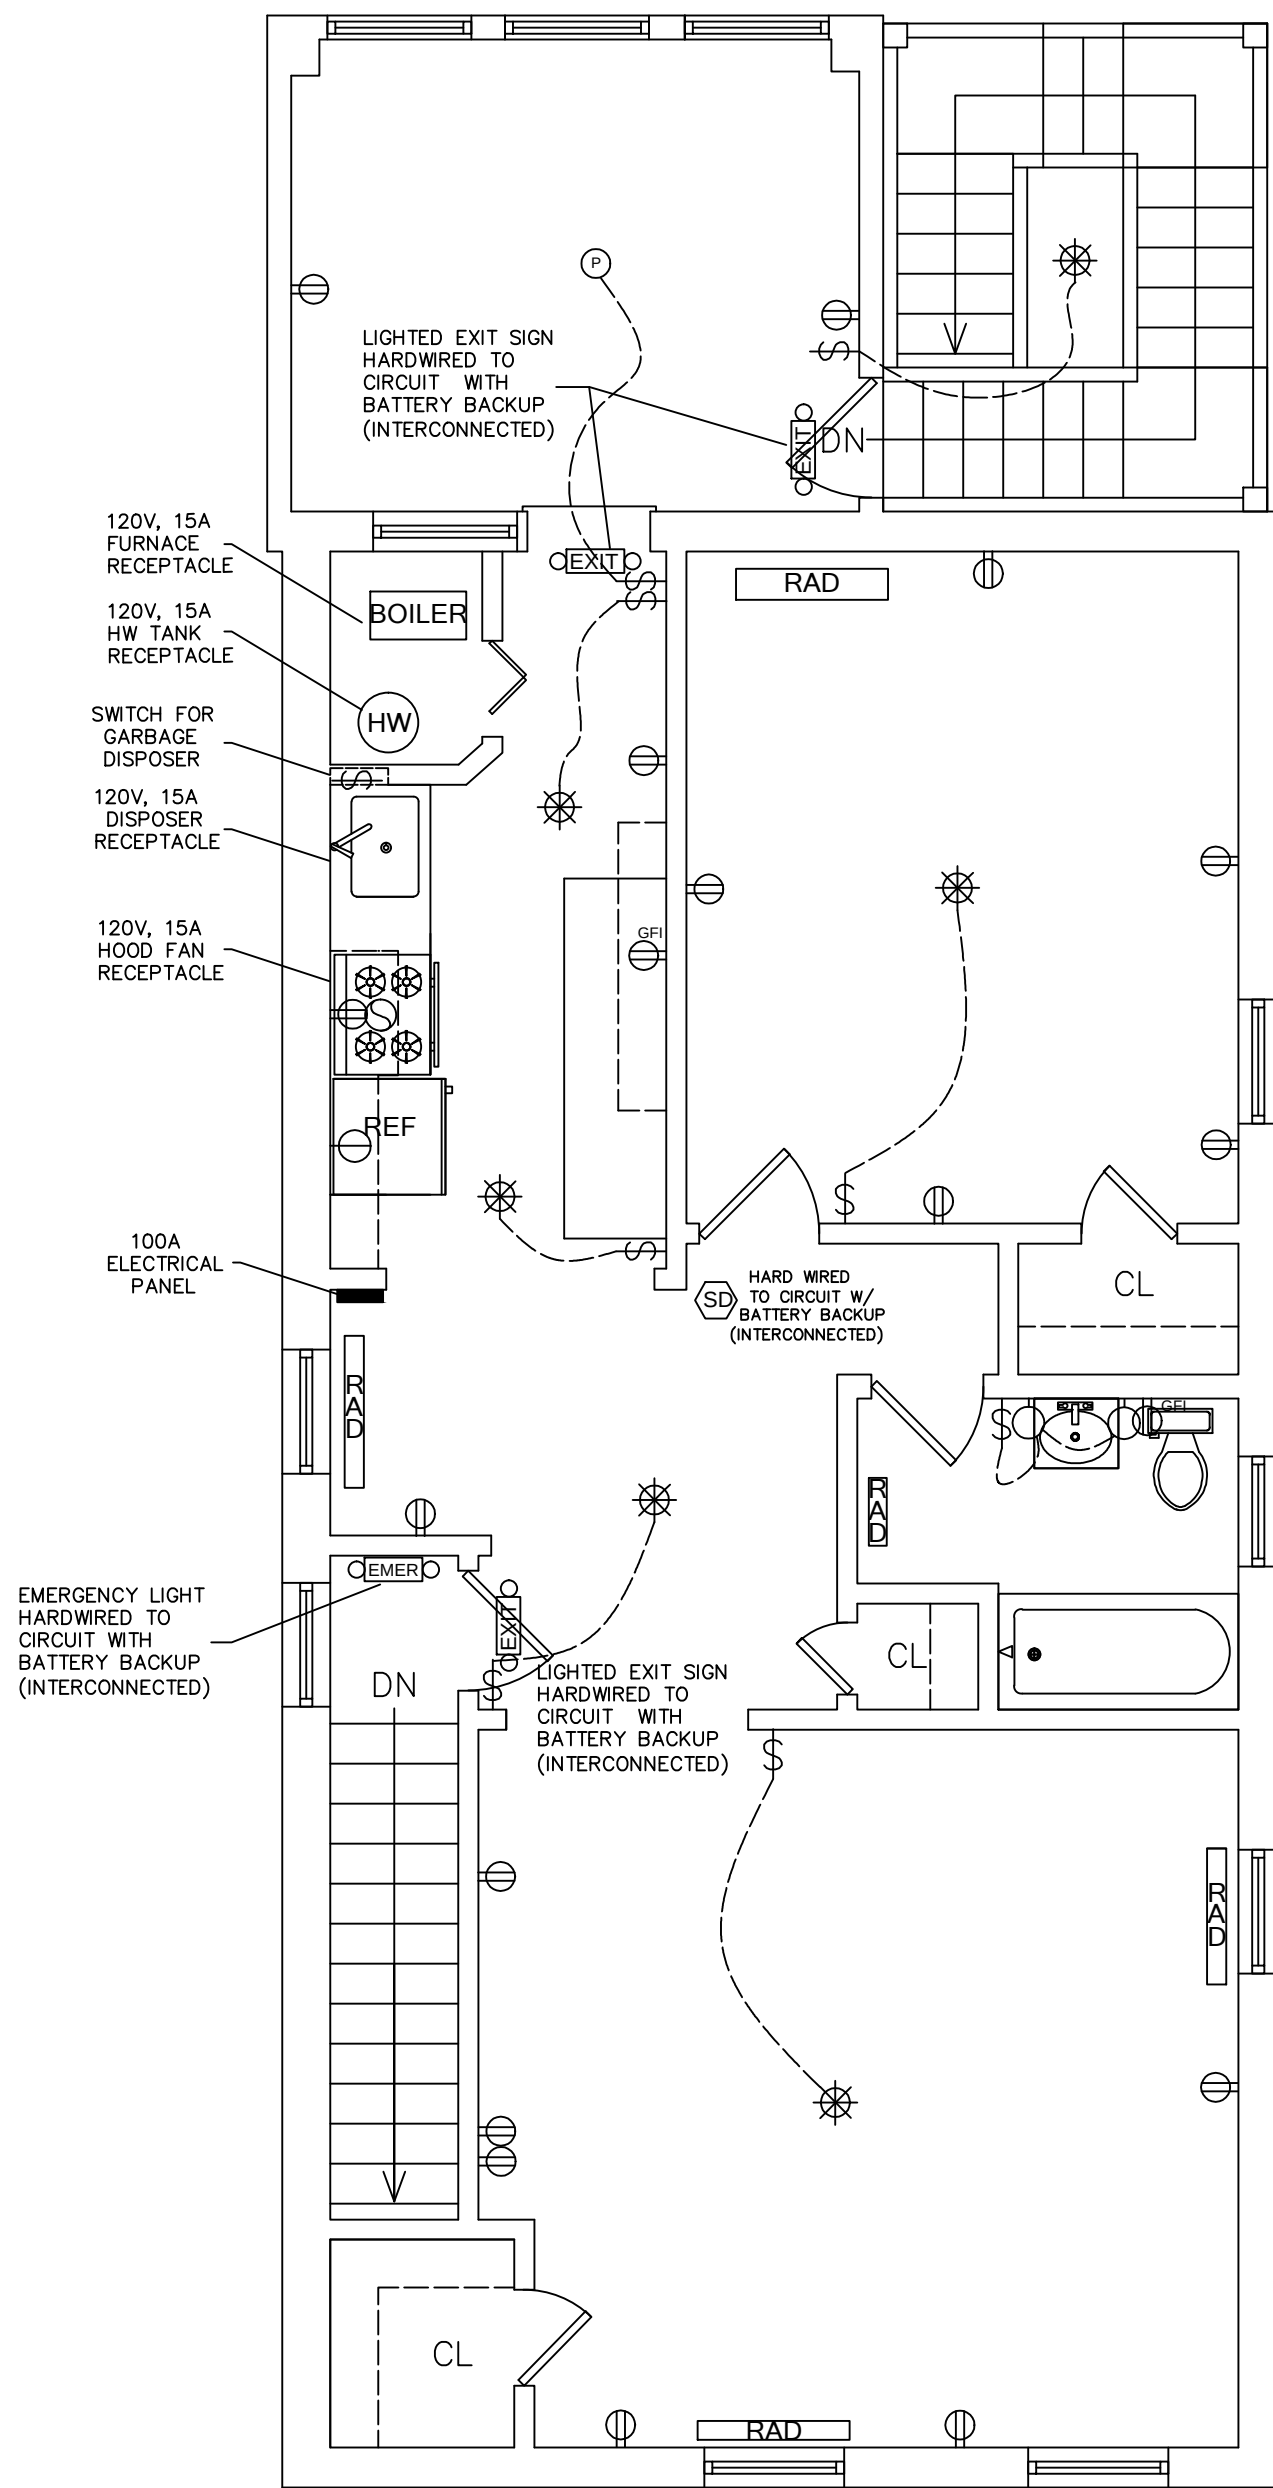


2ND FLOOR - ELECTRICAL
SCALE: 1/4" = 1'-0"

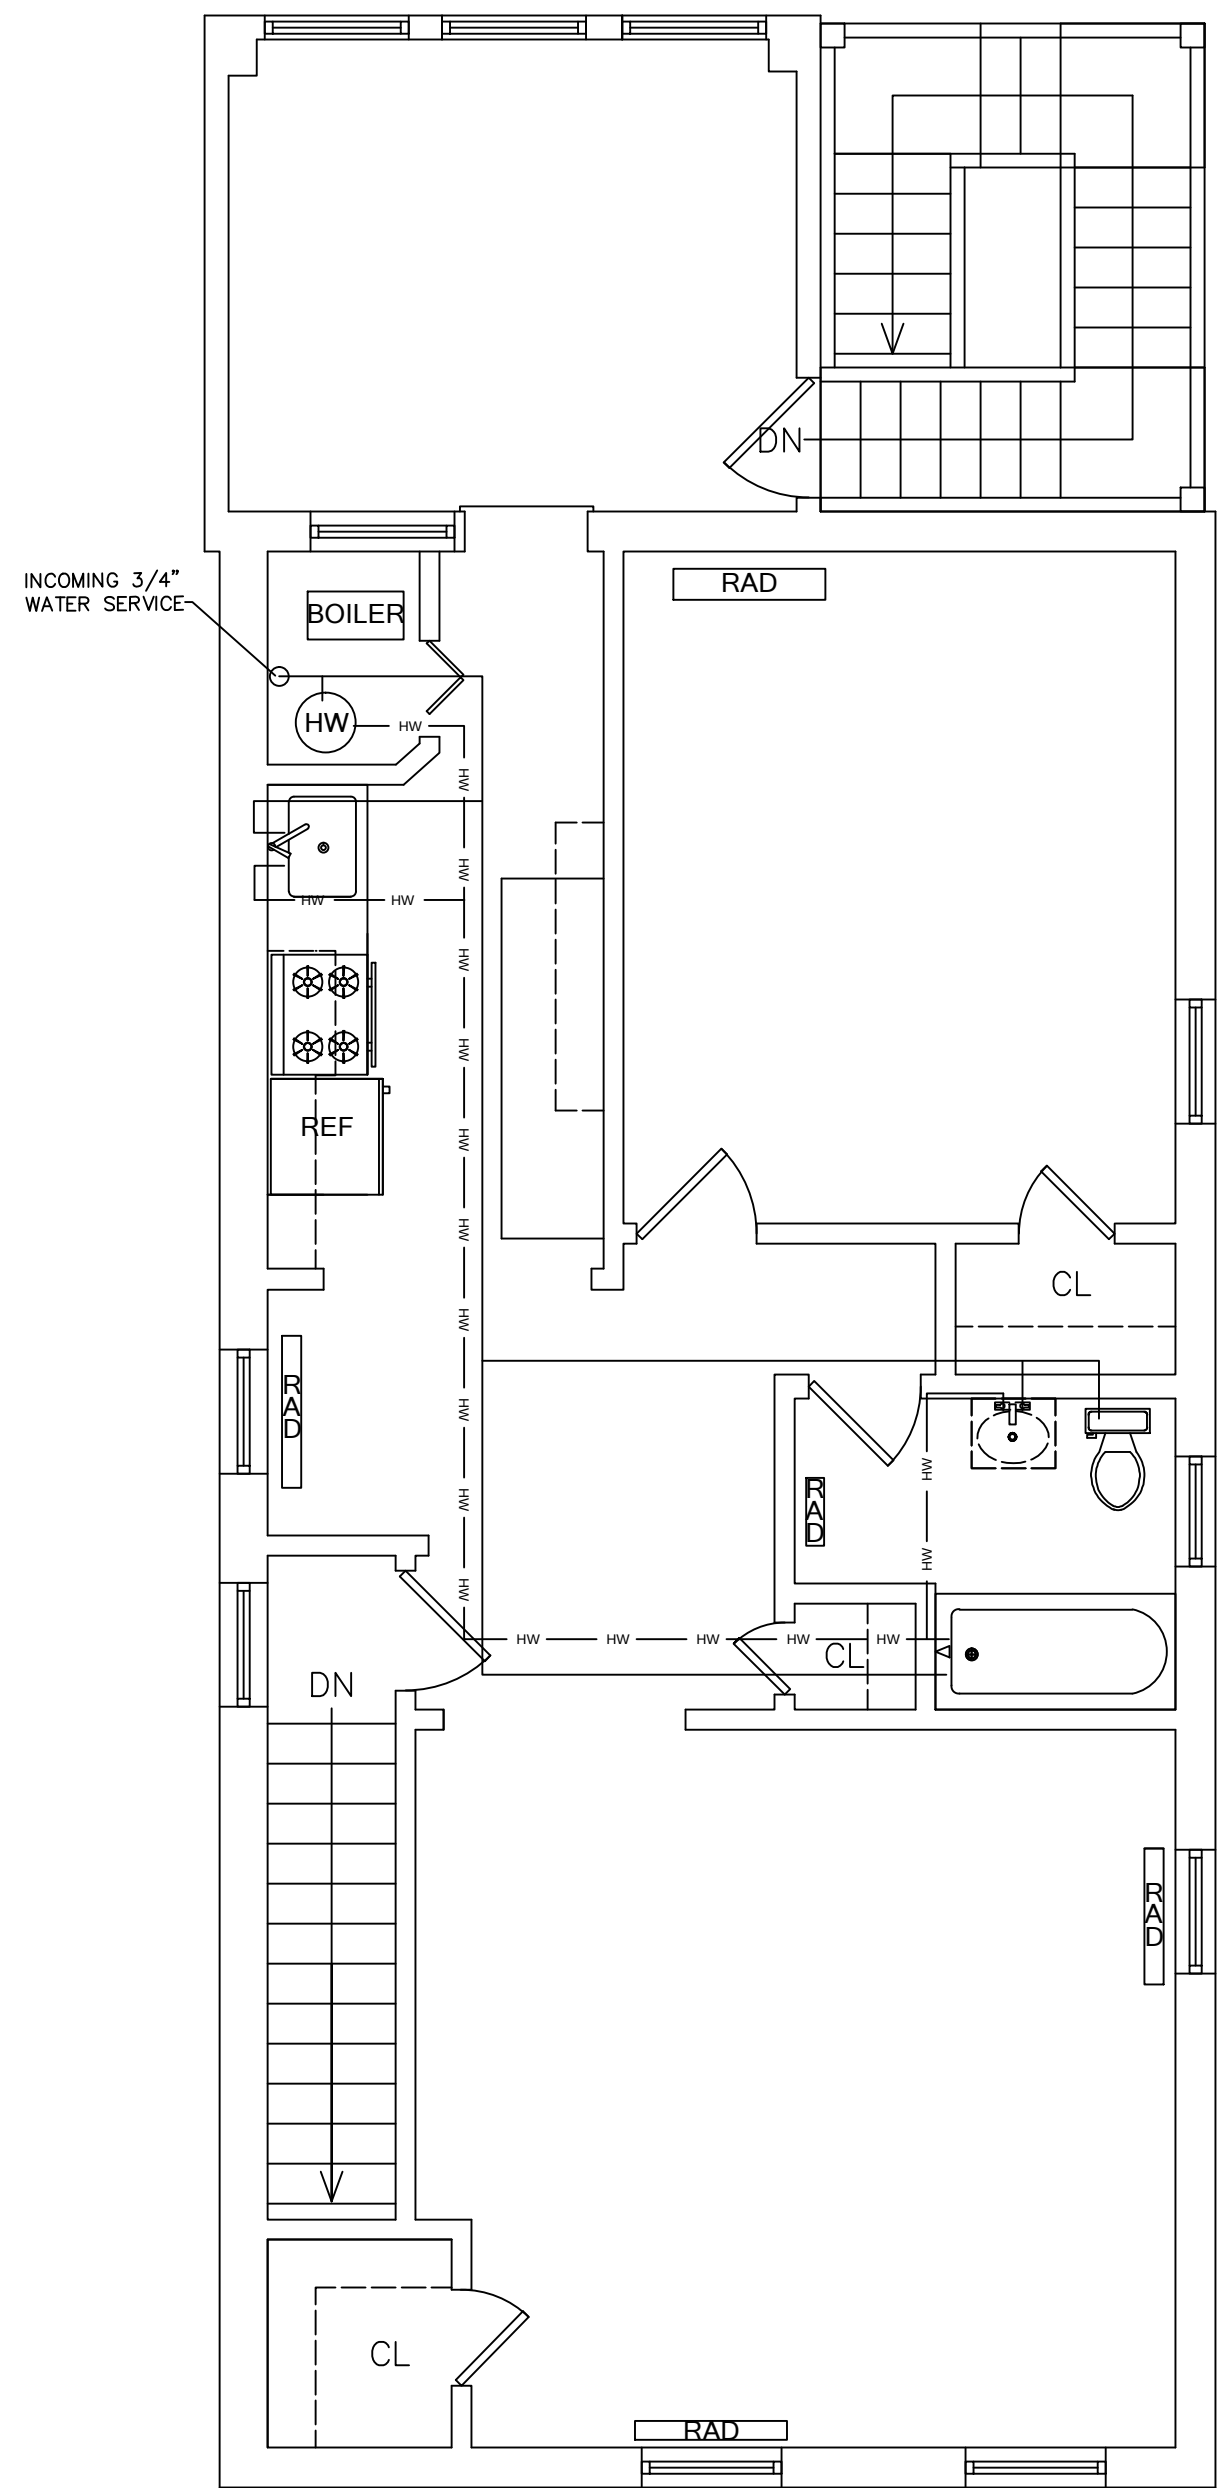


2ND FLOOR - PLUMBING
SCALE: 1/4" = 1'-0"

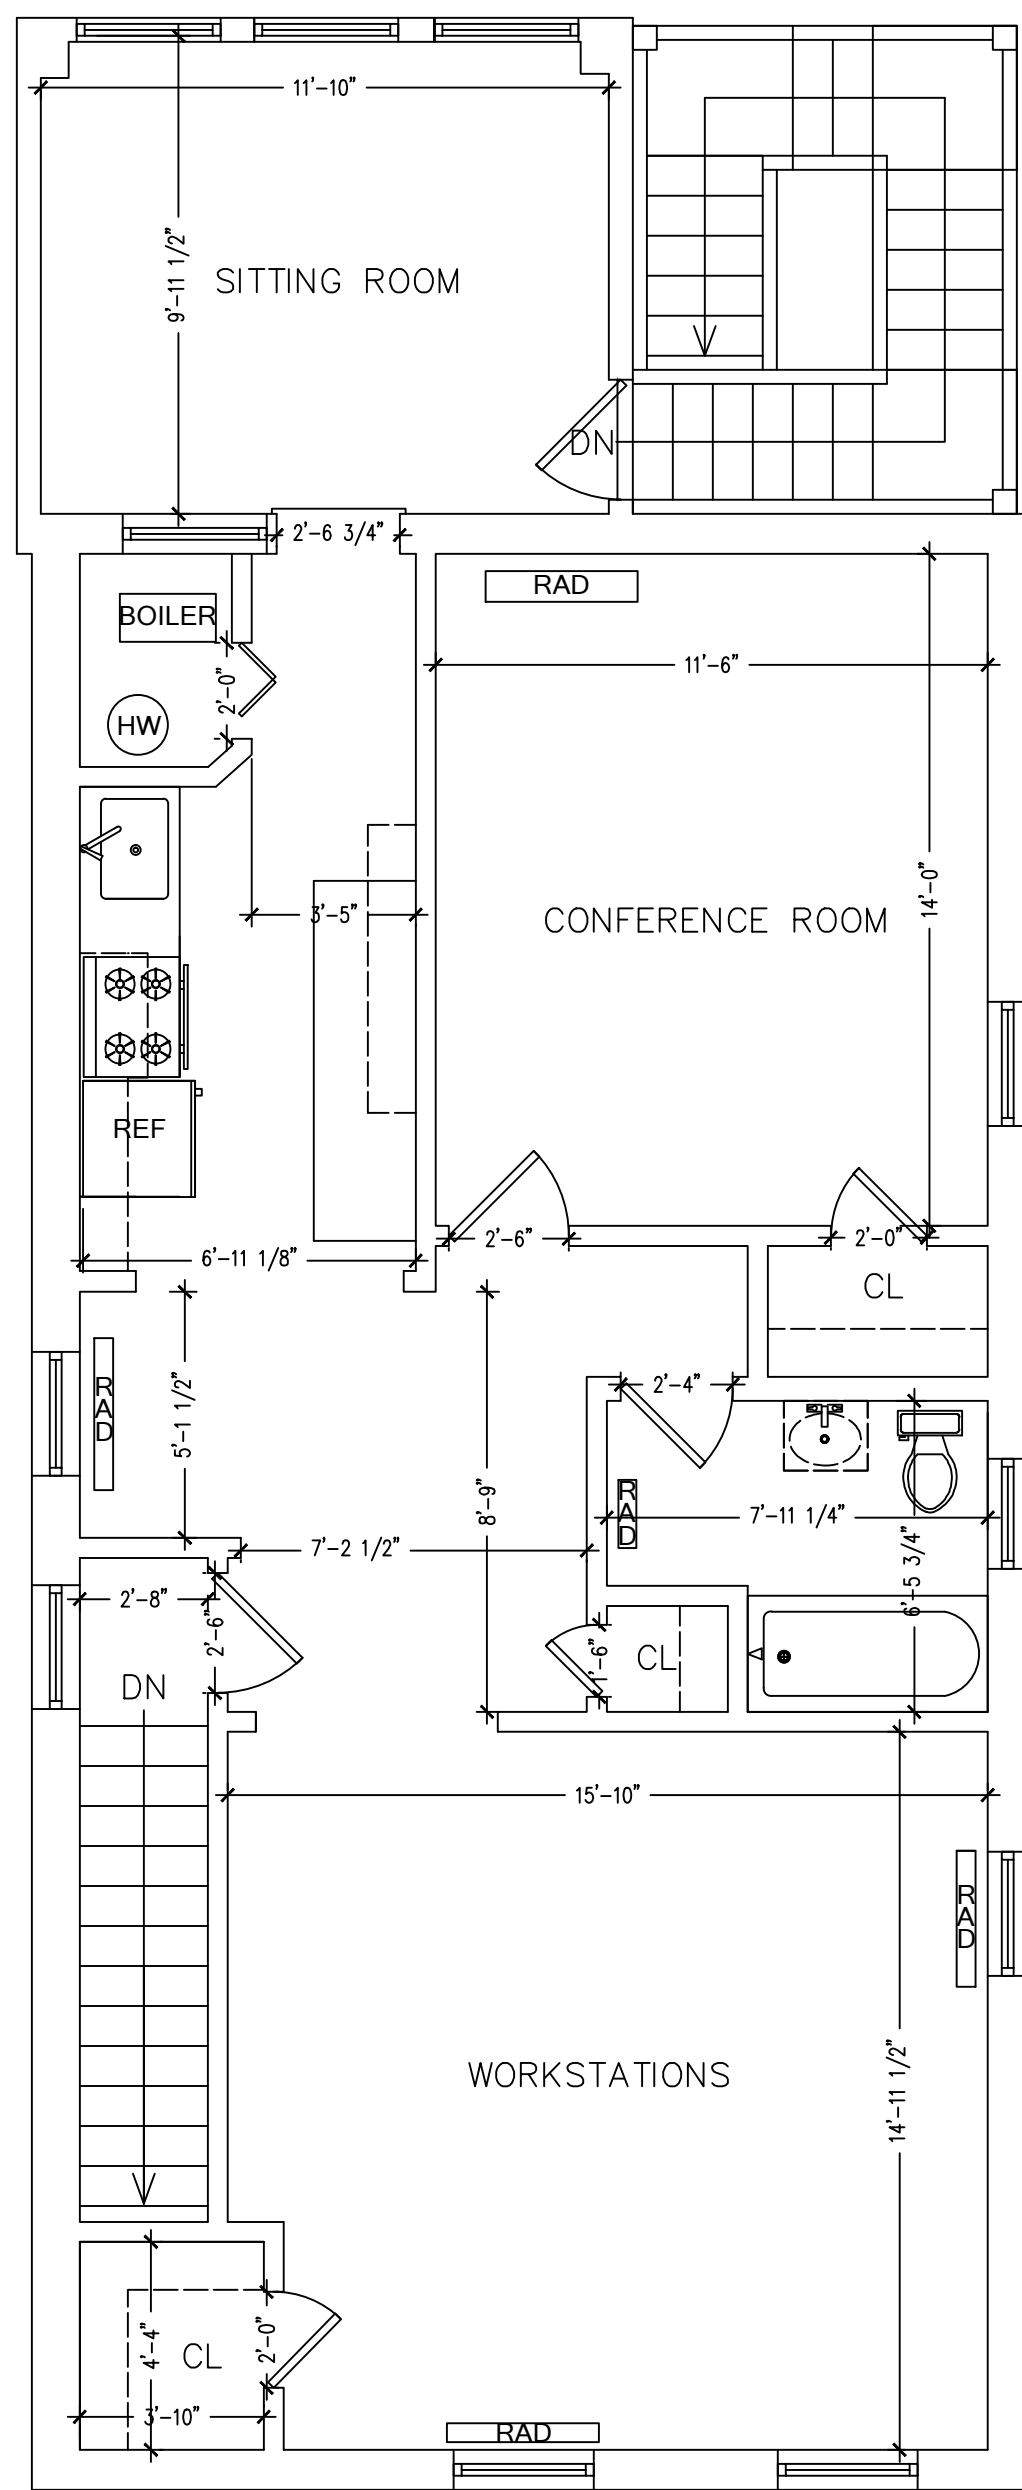

2ND FLOOR PLAN
SCALE: 1/4" = 1'-0"

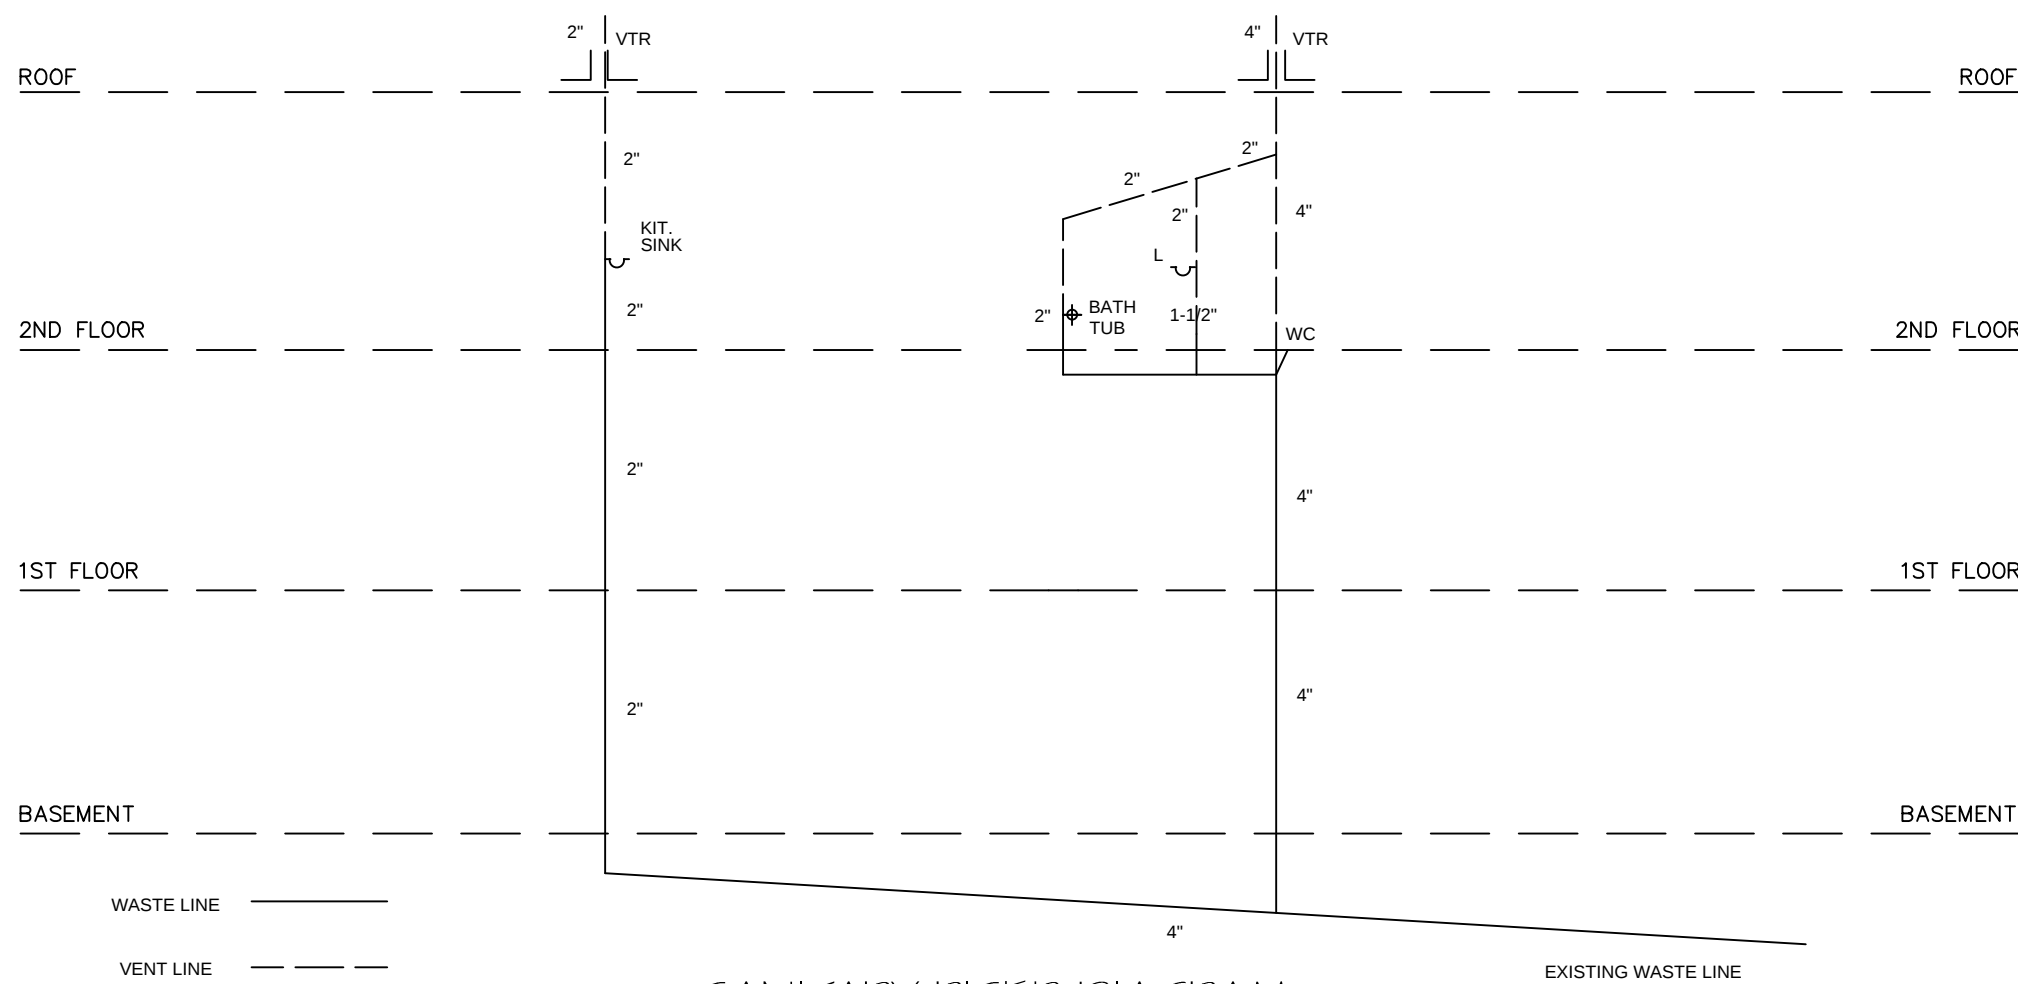

SANITARY RISER DIAGRAM
SCALE: NO SCALE

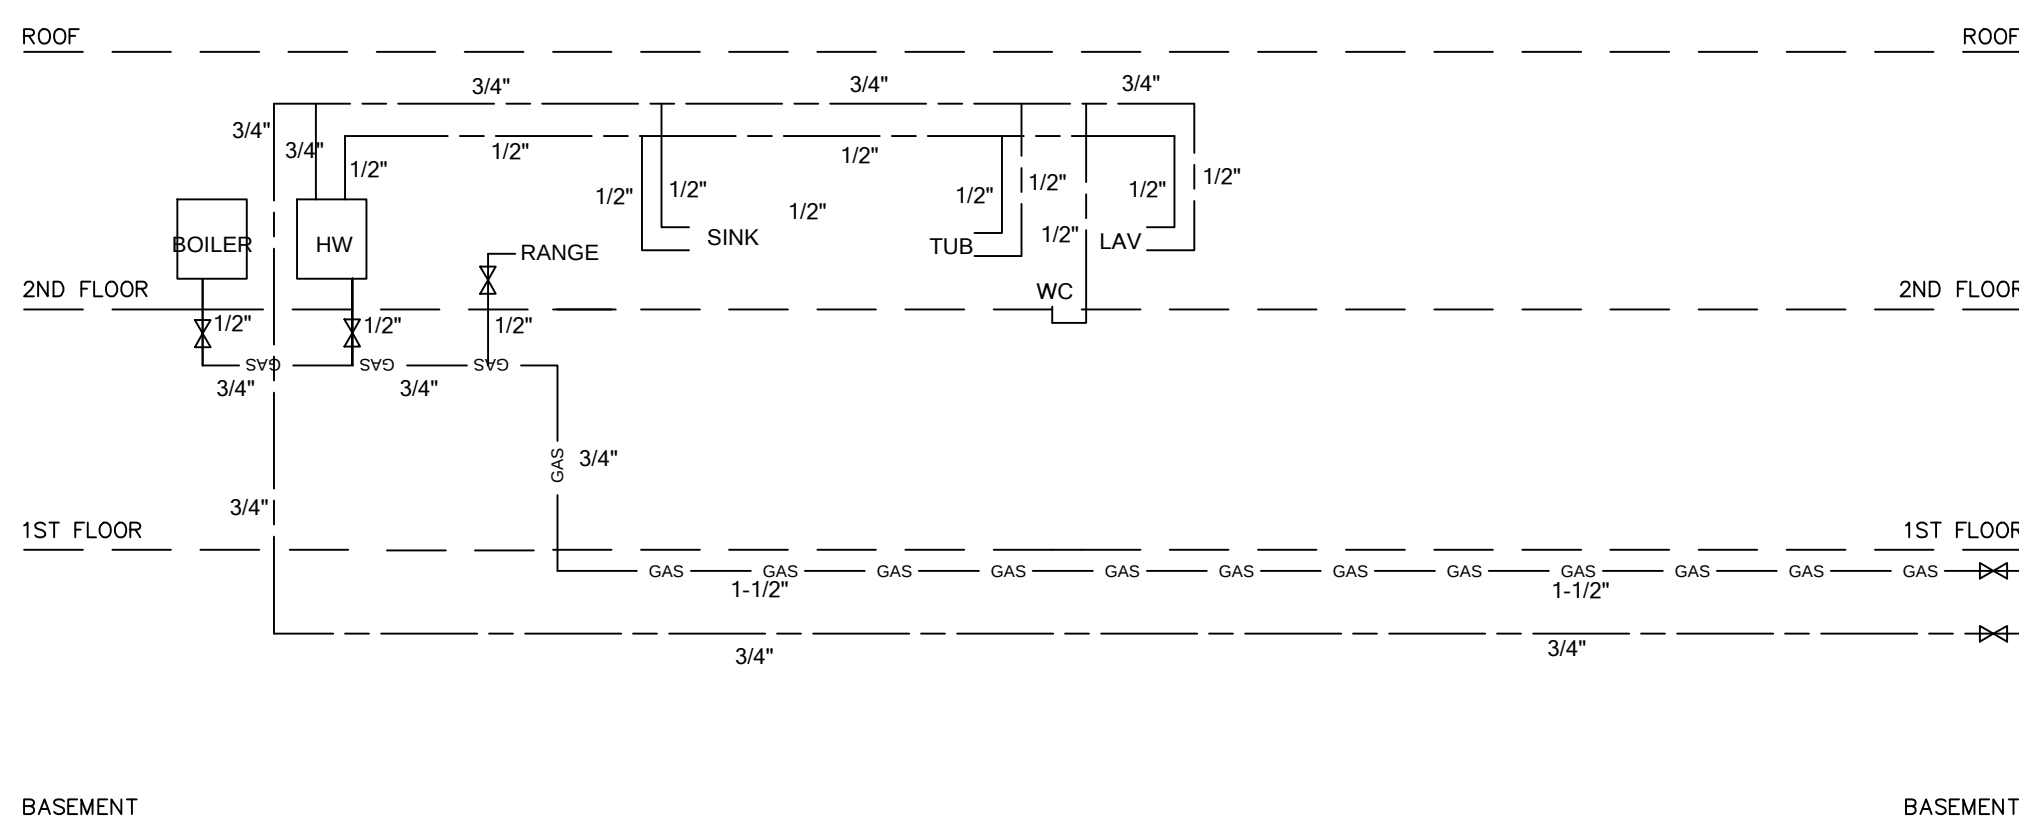

DOMESTIC RISER DIAGRAM
SCALE: NO SCALE

100 AMP - 2ND FLOOR - SERVICE PANEL

NO.	SERVICE	C/B			C/B			SERVICE	NO.
		TRIP	POLES	VOLT	TRIP	POLES	VOLT		
1	HOT WATER TANK	15	1	120	15	1	120	DISPOSER	2
3	REFRIGERATOR	15	1	120	15	1	120	BOILER	4
5	RANGE	15	1	120	15	1	120	WATER HEATER	6
7	OUTLETS - FRONT ROOM	15	1	120	15	1	120	OUTLETS - REAR, KIT, CONF	8
9	LIGHTS - REAR, KIT, CONF.	15	1	120	15	1	120	LIGHTS - FRONT ROOM	10
11	SMOKE DETECTORS	15	1	120	15	1	120	EXIT SIGNS & EMER LIGHTS	12
13									14
15									16
17									18
19									20
21									22
23									24

NOTES:

Project Name and Address

2ND FLOOR
3536 MINNESOTA AVE SE
WASHINGTON, DC 20019

Project

Date
12 / 7 / 2014

Scale
1/4" = 1'-0"

Sheet

A1