

SITE SCHEDULE - "Y"				
DESIGN ID	COUNT	DESCRIPTION	RESP.	COMMENTS
X0071	1	ALUMINUM SUPPORT FOR WORDMARK	GC	FINISH: MATTE BLACK.
UMBRELLA				
10065	2	UMBRELLA - 6FT 183CM - GREEN CANVAS WITH STARBUCKS WORDMARK F0056	WH	
10071	2	UMBRELLA - BASE FOR 6FT 183CM	WH	

ARCHITECTURAL
SITE PLAN NOTES

A. REFER TO EXTERIOR ELEVATIONS FOR BUILDING SIGNAGE LOCATION AND DESIGN ID. REFER TO ELECTRICAL PLANS FOR ELECTRICAL REQUIREMENTS.

B. GENERAL CONTRACTOR TO APPLY CONCRETE SEALER TO ALL EXTERIOR CONCRETE PATIO AND WALKWAY SURFACES.



STARBUCKS COFFEE
COMPANY
2401 UTAH AVENUE SOUTH
SEATTLE, WASHINGTON 98134
(206) 318-1575

THESE DRAWINGS AND SPECIFICATIONS ARE CONFIDENTIAL AND SHALL REMAIN THE SOLE PROPERTY OF STARBUCKS CORPORATION, WHICH IS THE OWNER OF THE COPYRIGHT IN THIS WORK. THEY SHALL NOT BE REPRODUCED IN WHOLE OR IN PART, SHARED WITH THIRD PARTIES OR USED IN ANY MANNER ON OTHER PROJECTS OR EXTENSIONS TO THIS PROJECT WITHOUT THE PRIOR WRITTEN CONSENT OF STARBUCKS CORPORATION. THESE DRAWINGS AND SPECIFICATIONS ARE INTENDED TO EXPRESS DESIGN INTENT FOR A PROTOTYPICAL STARBUCKS STORE WHICH IS SUBJECT TO CHANGE AT ANYTIME AND DO NOT REFLECT ACTUAL SITE CONDITIONS. NEITHER PARTY SHALL HAVE ANY OBLIGATION NOR LIABILITY TO THE OTHER (EXCEPT STATED ABOVE) UNTIL A WRITTEN AGREEMENT IS FULLY EXECUTED BY BOTH PARTIES.

ARCHITECT OF RECORD

NORR

ARCHITECTS PLANNERS
325 N. LaSalle St. Suite 700 Chicago, IL 60654
t 312.424.2400 | f 312.424.2424 | www.norr.com

ENGINEER OF RECORD



William J. Alkemeyer, P.E.
353 Marshall Avenue
St. Louis, Missouri 63119
Phone (314) 772-1792
Fax (314) 772-0108

Engineering Consultant

Revision Schedule

Rev	Date	By	Description
1	5.2.2014		LL REVIEW

PROJECT NAME:
CATHEDRAL COMMONS

PROJECT ADDRESS:
**WISCONSIN AVE. & IDAHO AVE.
SUITE N8
WASHINGTON, DC 20016**

STORE #: 21159
PROJECT #: 53367-001
CONCEPT: CLASSIC
PALETTE: NCS
ISSUE DATE: 2014 04 01
DESIGN MANAGER: M. CLAROS
LEED® AP: E. FLEMING
PRODUCTION DESIGNER: K. LEE
CHECKED BY: NORR


SHEET TITLE:

**ARCHITECTURAL SITE
PLAN**

SCALE: As indicated


SHEET NUMBER:


Board of Zoning Adjustment
A-1001 District of Columbia
CASE NO. 19056
EXHIBIT A-1001-001

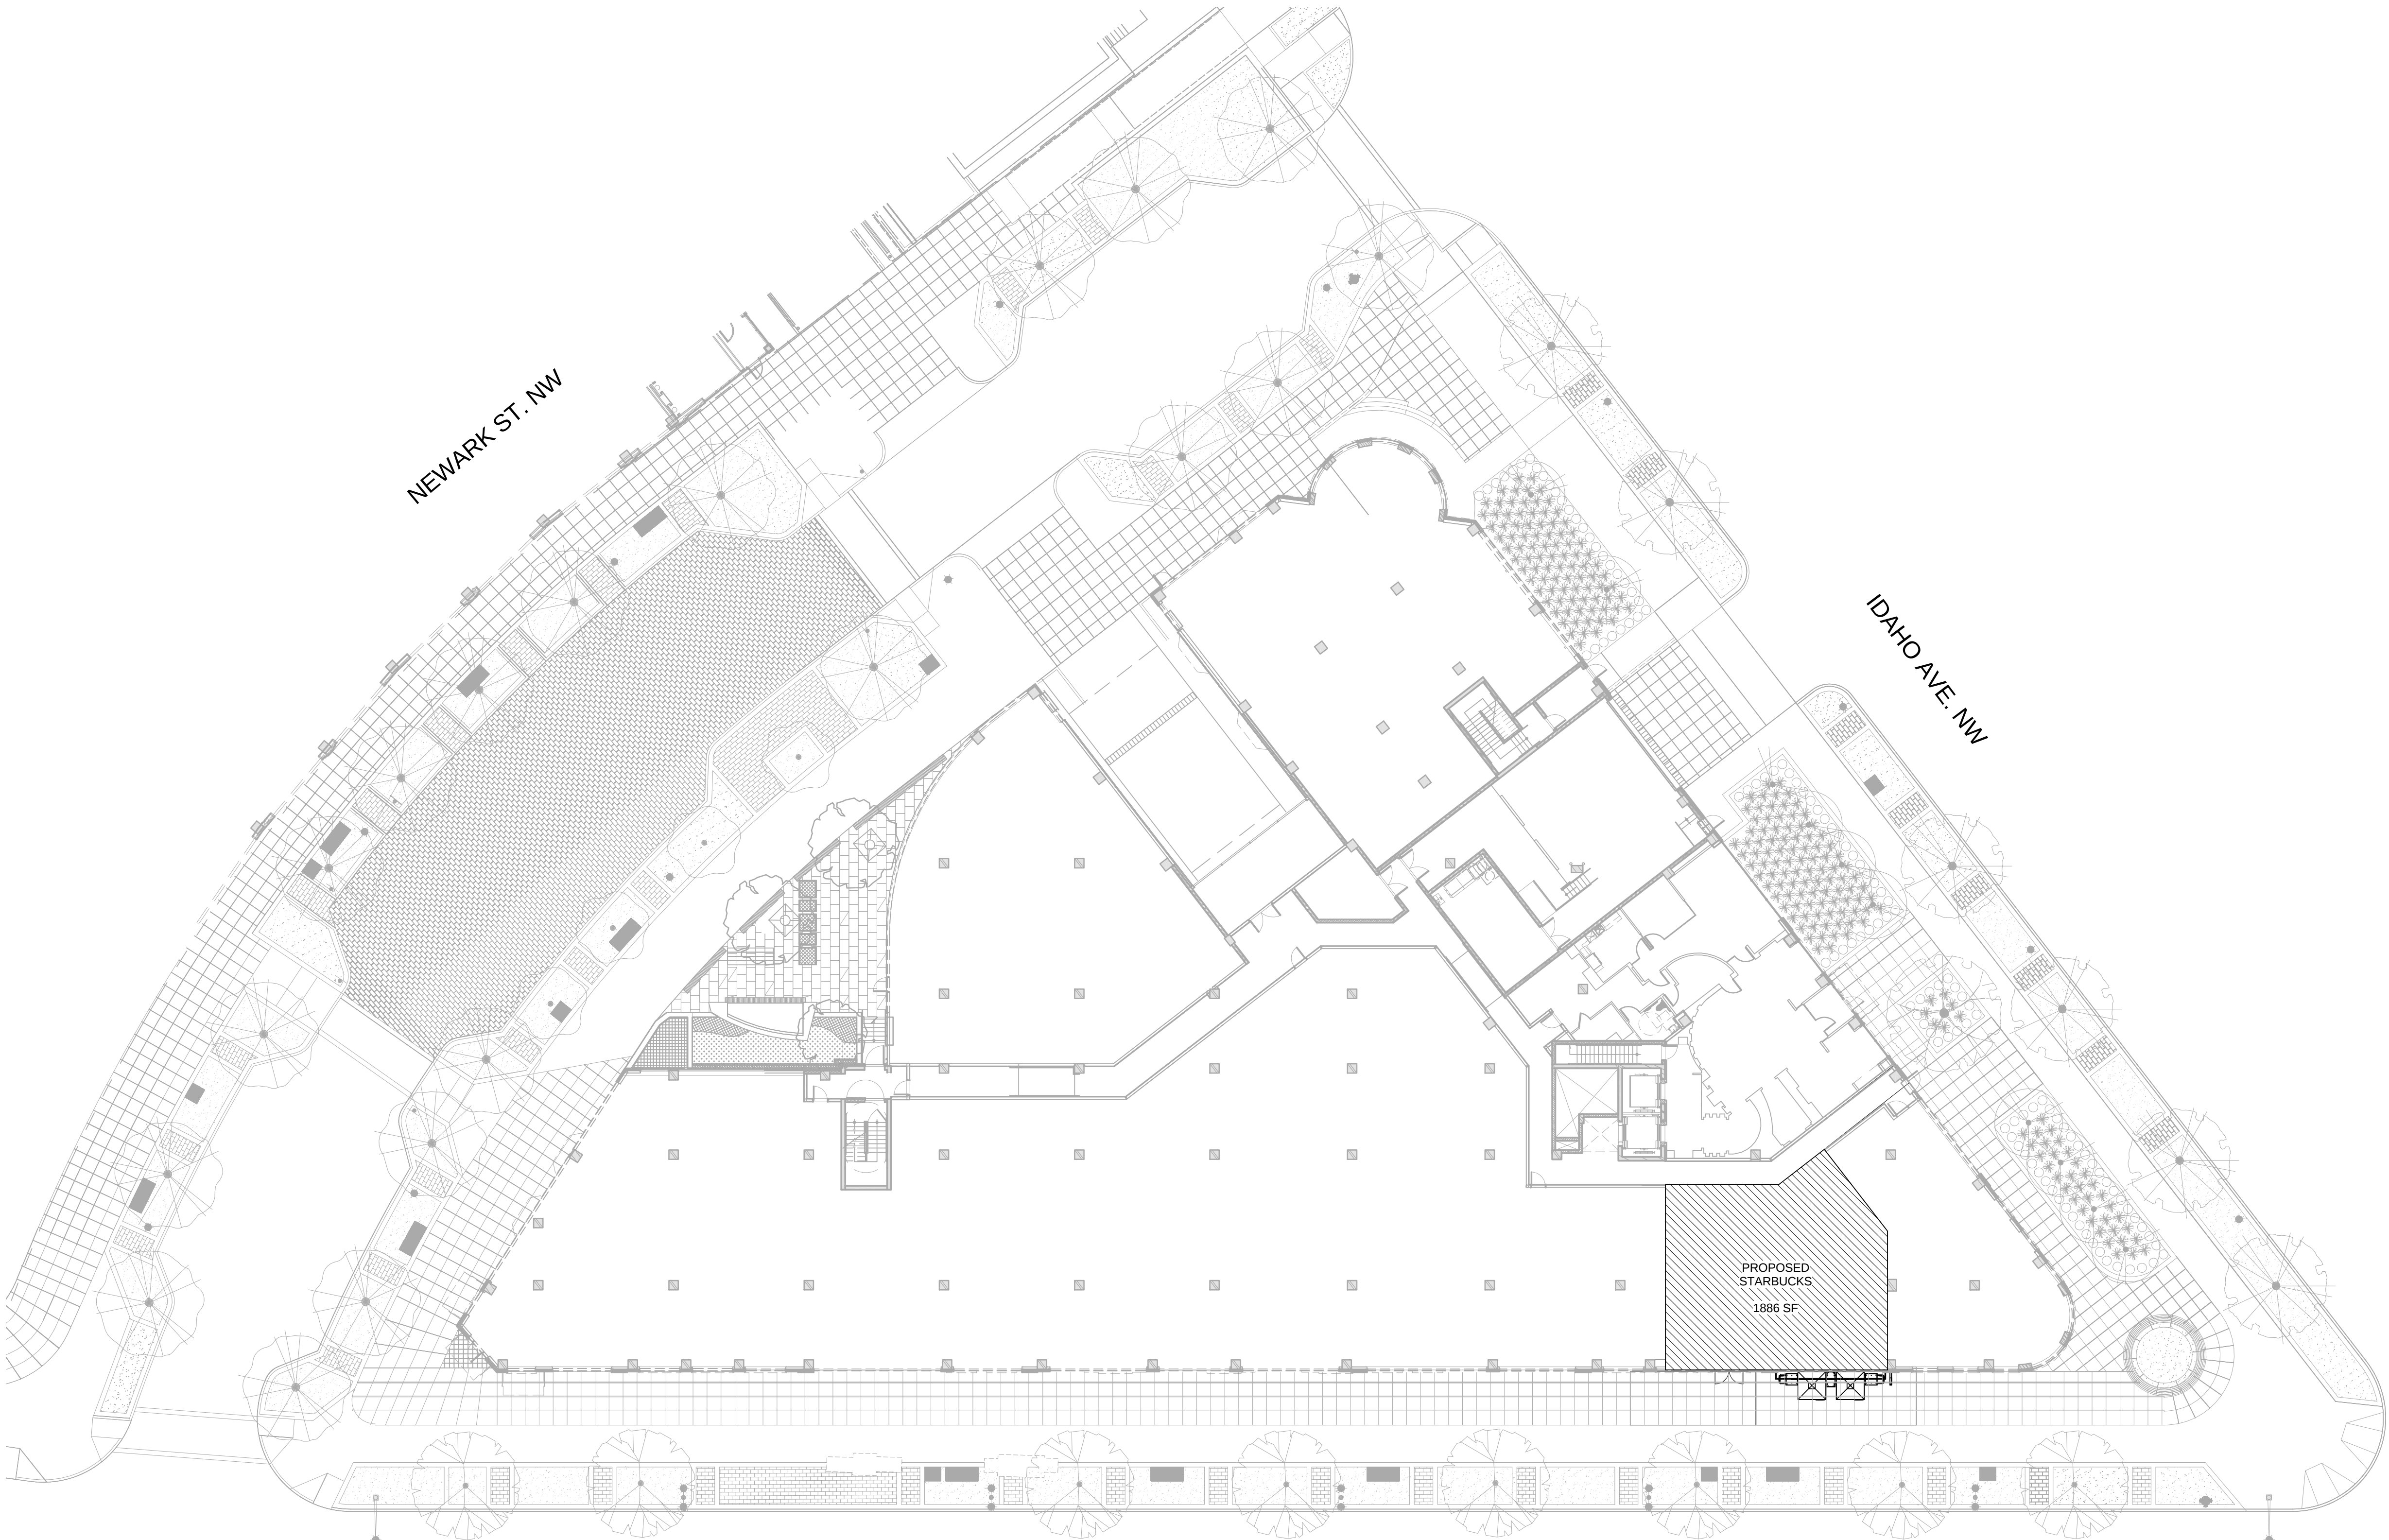

1 SITE PLAN - FOR REFERENCE ONLY

  Scale: 1" = 20'-0"





I-1105

