

SITE SCHEDULE - "Y"				
DESIGN ID	COUNT	DESCRIPTION	RESP.	COMMENTS
X0071	1	ALUMINUM SUPPORT FOR WORDMARK	GC	FINISH: MATTE BLACK.
UMBRELLA				
10065	2	UMBRELLA - 6FT 183CM - GREEN CANVAS WITH STARBUCKS WORDMARK F0056	WH	
10071	2	UMBRELLA - BASE FOR 6FT 183CM	WH	

ARCHITECTURAL
SITE PLAN NOTES

A. REFER TO EXTERIOR ELEVATIONS FOR BUILDING SIGNAGE LOCATION AND DESIGN ID. REFER TO ELECTRICAL PLANS FOR ELECTRICAL REQUIREMENTS.

B. GENERAL CONTRACTOR TO APPLY CONCRETE SEALER TO ALL EXTERIOR CONCRETE PATIO AND WALKWAY SURFACES.



STARBUCKS COFFEE
COMPANY
2401 UTAH AVENUE SOUTH
SEATTLE, WASHINGTON 98134
(206) 318-1575

THESE DRAWINGS AND SPECIFICATIONS ARE CONFIDENTIAL AND SHALL REMAIN THE SOLE PROPERTY OF STARBUCKS CORPORATION, WHICH IS THE OWNER OF THE COPYRIGHT IN THIS WORK. THEY SHALL NOT BE REPRODUCED IN WHOLE OR IN PART, SHARED WITH THIRD PARTIES OR USED IN ANY MANNER ON OTHER PROJECTS OR EXTENSIONS TO THIS PROJECT WITHOUT THE PRIOR WRITTEN CONSENT OF STARBUCKS CORPORATION. THESE DRAWINGS AND SPECIFICATIONS ARE INTENDED TO EXPRESS DESIGN INTENT FOR A PROTOTYPICAL STARBUCKS STORE WHICH IS SUBJECT TO CHANGE AT ANYTIME AND DO NOT REFLECT ACTUAL SITE CONDITIONS. NEITHER PARTY SHALL HAVE ANY OBLIGATION NOR LIABILITY TO THE OTHER (EXCEPT STATED ABOVE) UNTIL A WRITTEN AGREEMENT IS FULLY EXECUTED BY BOTH PARTIES.

ARCHITECT OF RECORD

NORR

ARCHITECTS PLANNERS
325 N. LaSalle St. Suite 700 Chicago, IL 60654
t 312.424.2400 | f 312.424.2424 | www.norr.com

ENGINEER OF RECORD



William J. Alkemeyer, P.E.
353 Marshall Avenue
St. Louis, Missouri 63119
Phone (314) 772-1792
Fax (314) 772-0108

Engineering Consultant

Revision Schedule

Rev	Date	By	Description
1	5.2.2014		LL REVIEW

PROJECT NAME:
CATHEDRAL COMMONS

PROJECT ADDRESS:
**WISCONSIN AVE. & IDAHO AVE.
SUITE N8
WASHINGTON, DC 20016**

STORE #: 21159
PROJECT #: 53367-001
CONCEPT: CLASSIC
PALETTE: NCS
ISSUE DATE: 2014 04 01
DESIGN MANAGER: M. CLAROS
LEED® AP: E. FLEMING
PRODUCTION DESIGNER: K. LEE
CHECKED BY: NORR


SHEET TITLE:

**ARCHITECTURAL SITE
PLAN**

SCALE: As indicated


SHEET NUMBER:


Board of Zoning Adjustment
District of Columbia
A-1001
CASE NO. 13058
COUNT NO. 4

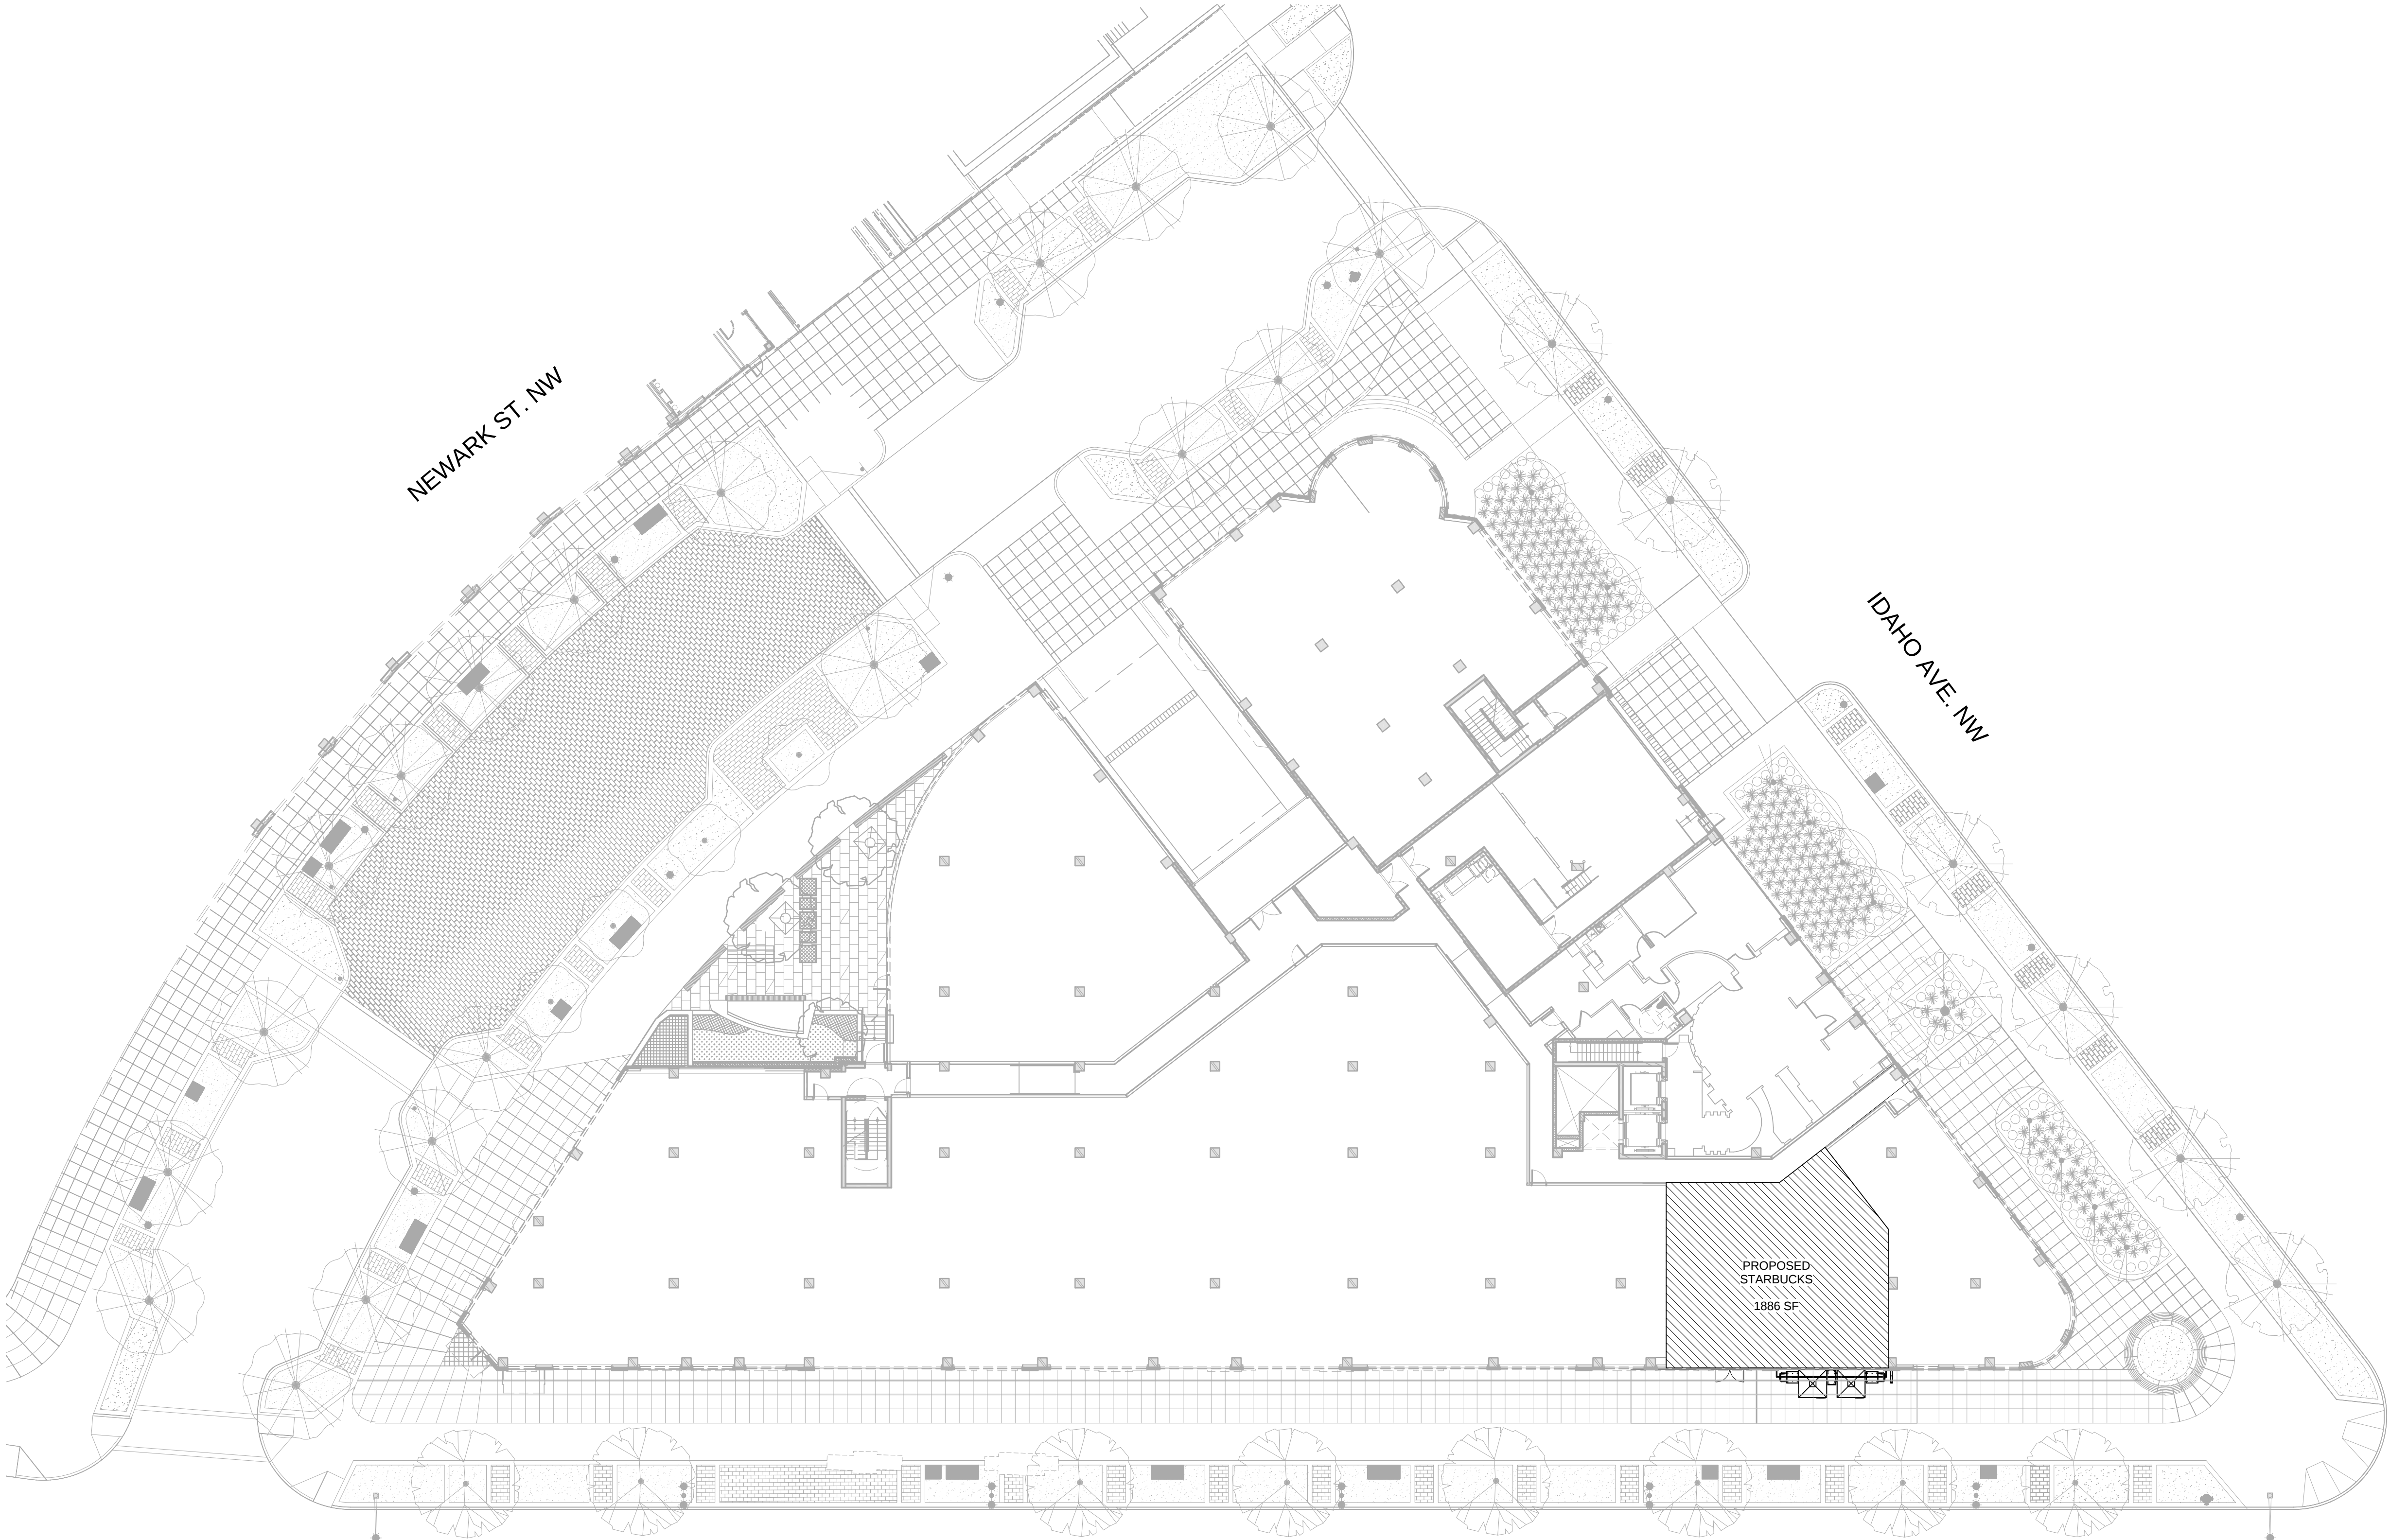

1 SITE PLAN - FOR REFERENCE ONLY

 Scale: 1" = 20'-0"



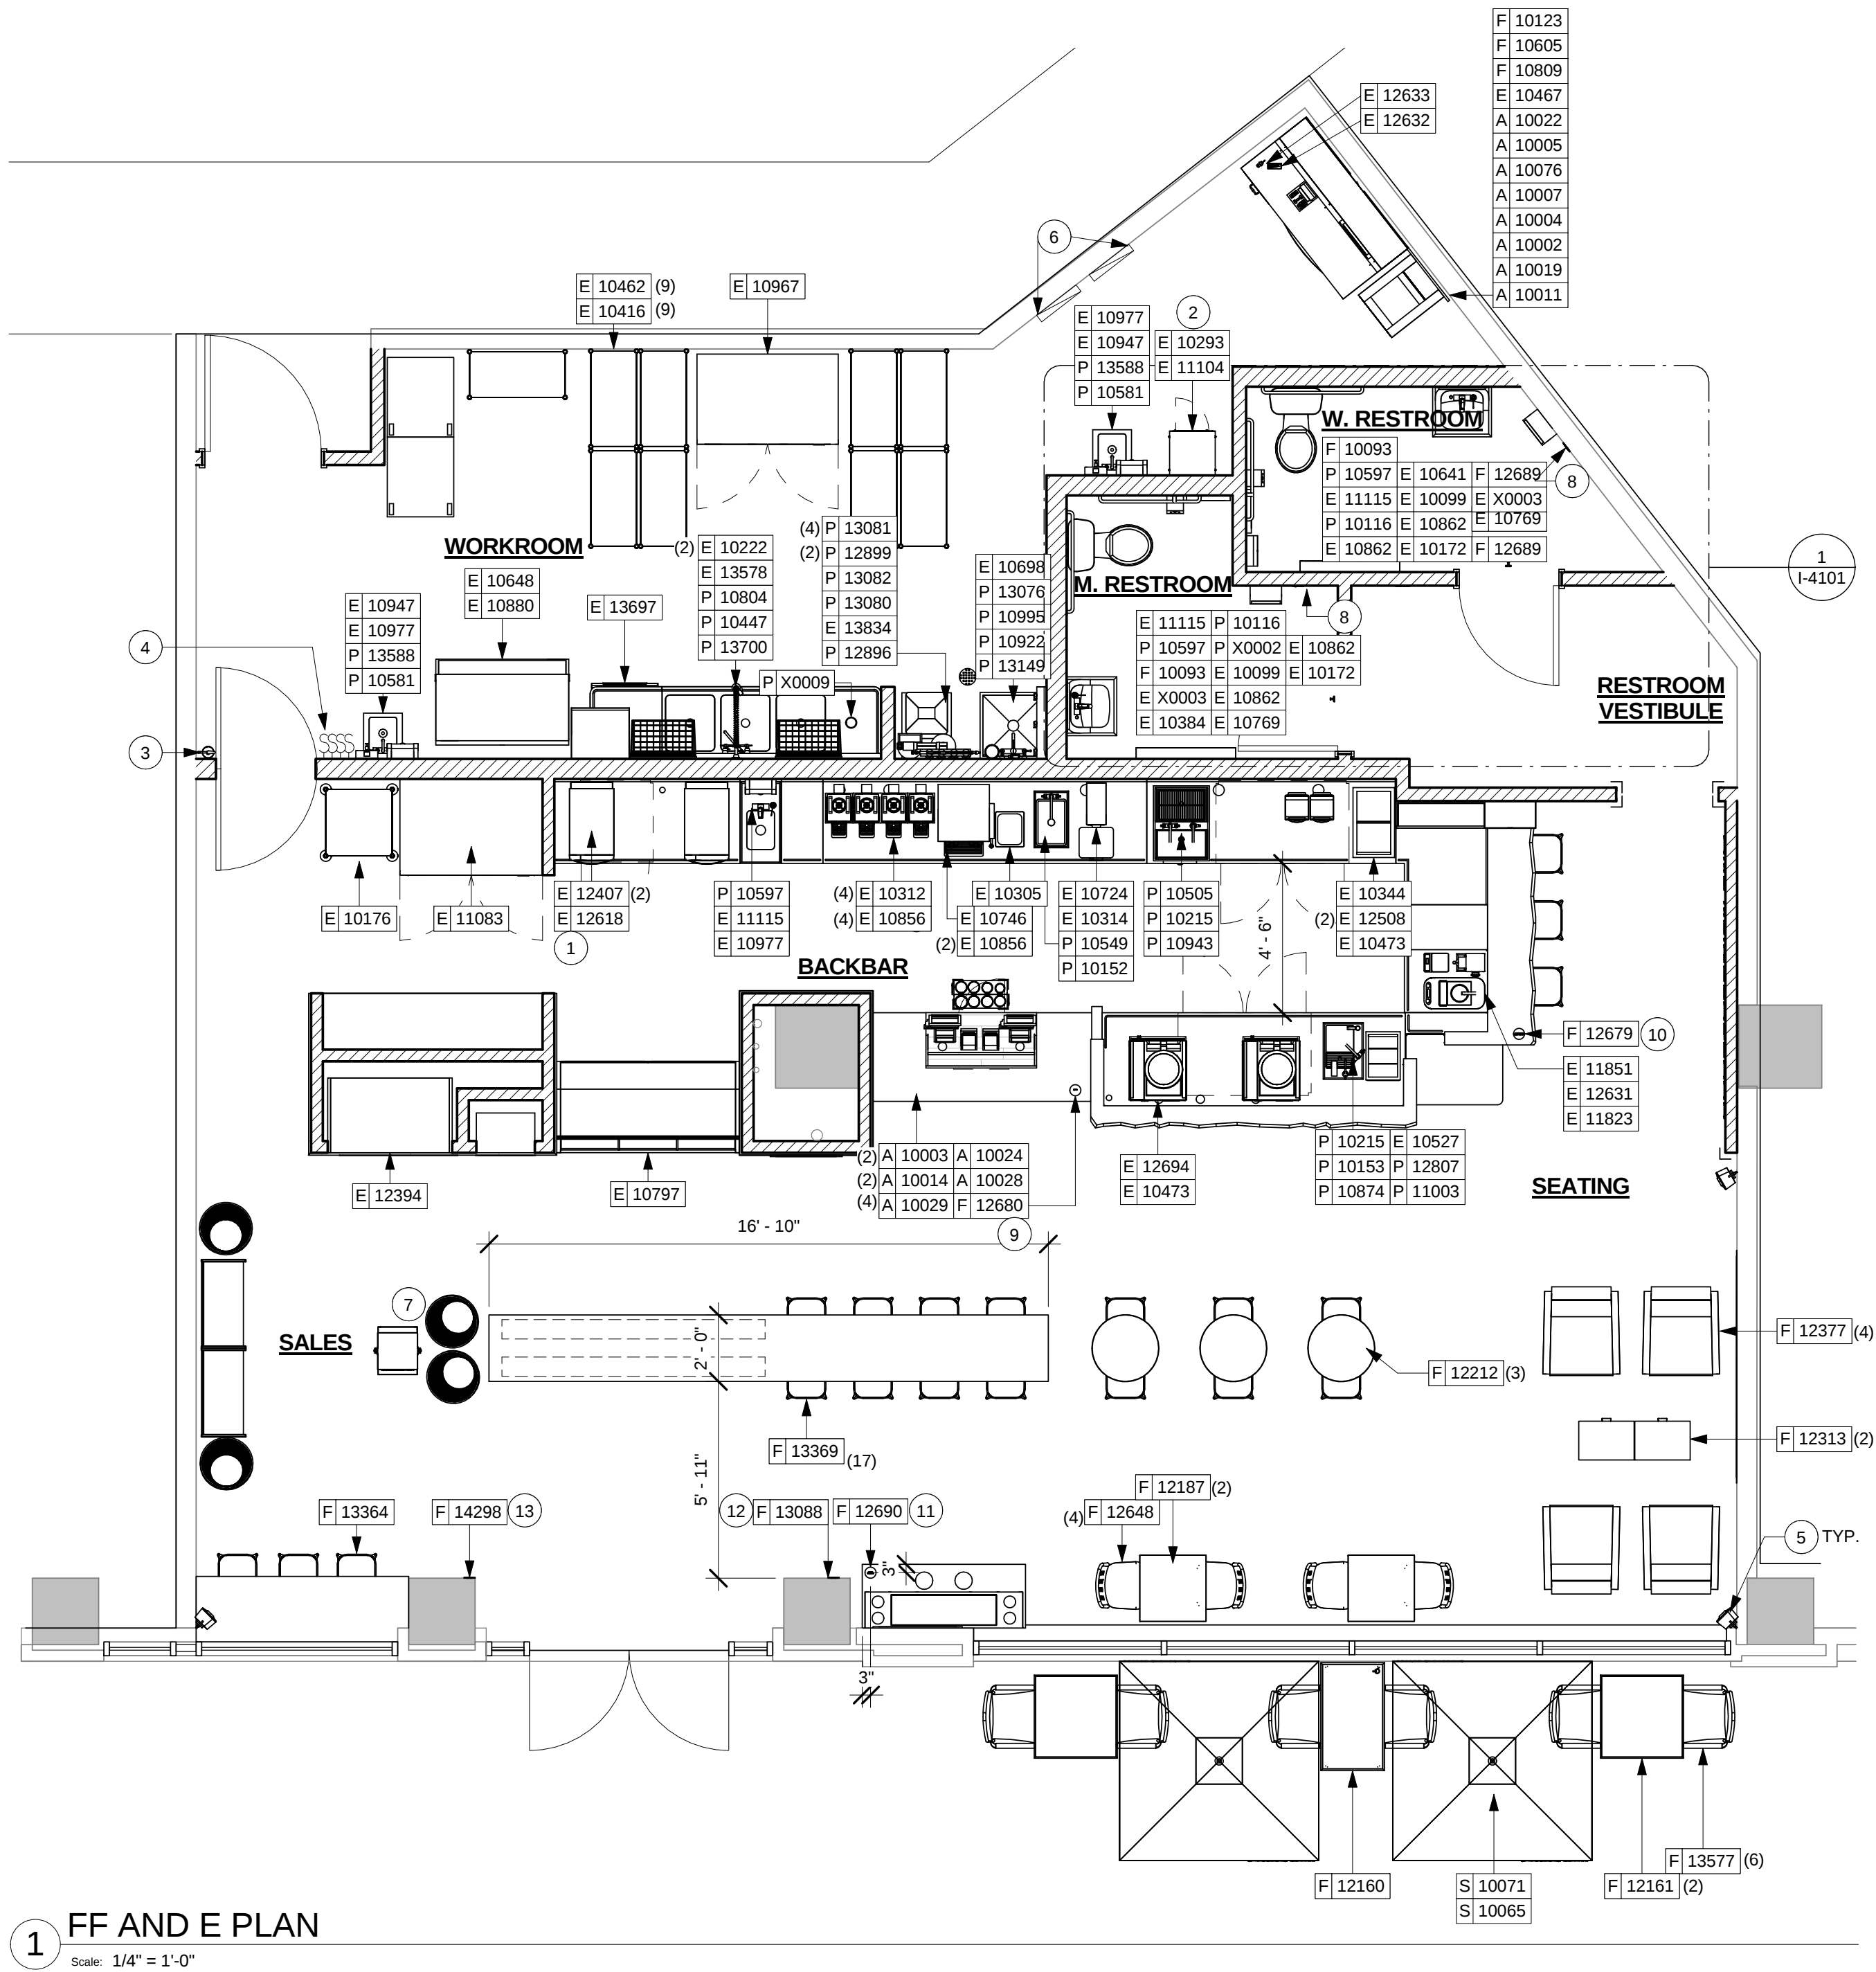

FF AND E PLAN NOTES

- A. GENERAL CONTRACTOR TO SCHEDULE WITH LOCAL REFRIGERATION CONTRACTOR TO CONDUCT INITIAL FOOD CASE START-UP AND TESTING. FOR APPROVED CONTRACTOR, CONTACT VENDOR.
- B. THE SPACE IS SERVED BY THE MUNICIPAL WATER AND SEWER SYSTEM UNLESS OTHERWISE NOTED.
- C. ALL EQUIPMENT AND INSTALLATION WILL MEET NATIONAL SANITATION FOUNDATION STANDARDS OR EQUIVALENT.
- D. EQUIPMENT UNITS SHALL CONTAIN NO EXPOSED THREADS, EMBELLISHMENTS OR OVERHANGING EDGES THAT SERVE AS PLACES FOR ACCUMULATION OF DUST, DIRT AND DEBRIS.
- E. EACH HAND WASHING SINK WILL HAVE A SINGLE SERVICE TOWEL AND SOAP DISPENSER, AND ALL HAND SINKS TO HAVE A COMBINATION FAUCET OR PREMIXING FAUCET.
- F. FOR PLUMBING FIXTURES, REFER TO THE PLUMBING DESIGN PLAN. FOR DATA DEVICE SCHEDULE, REFER TO THE ELECTRICAL DESIGN PLAN
- G. SEE SHEET I-601 FOR SCHEDULES.

SHEET NOTES

1. GENERAL CONTRACTOR TO REVERSE DOOR HINGE ON UNDER COUNTER REFRIGERATOR TO LEFT-HAND SWING, AS SHOWN.
2. SECURE LOCKERS TO WALL.
3. PLACE FIRE EXTINGUISHER IN WORKROOM PER FIRE INSPECTOR.
4. LOCATION OF ALL SWITCHING.
5. SPEAKERS TO BE MOUNTED AT MAXIMUM HEIGHT PER CUTSHEET.
6. LOCATION OF ELECTRICAL PANELS. SEE SHEET E-1102 FOR ELECTRICAL PANEL INFORMATION.
7. INSTALL MERCH SMALLWARE ITEMS AS INDICATED.
8. HAND DRYER EDUCATION LEED DISK. REFER TO INTERIOR ELEVATIONS FOR MOUNTING HEIGHTS.
9. MUGS EDUCATION LEED DISK. MOUNT ON POS COUNTERTOP AS INDICATED. REFER TO SHEET I-4102 FOR PLACEMENT DETAIL.
10. ALTERNATIVE TRANSPORTATION LEED DISK. REFER TO SHEET I-4102 FOR PLACEMENT DETAIL.
11. WASTE DIVERSION LEED DISK. MOUNT AS INDICATED.
12. LEED PRE-CERTIFICATION DISK. REFER TO INTERIOR ELEVATIONS FOR MOUNTING HEIGHTS.
13. GROUNDS FOR GARDENS LEED DISK. REFER TO INTERIOR ELEVATIONS FOR MOUNTING HEIGHTS.



STARBUCKS COFFEE COMPANY
2401 UTAH AVENUE SOUTH
SEATTLE, WASHINGTON 98134
(206) 318-1575

THESE DRAWINGS AND SPECIFICATIONS ARE CONFIDENTIAL AND SHALL REMAIN THE SOLE PROPERTY OF STARBUCKS CORPORATION, WHICH IS THE OWNER OF THE COPYRIGHT IN THIS WORK. THEY SHALL NOT BE REPRODUCED IN WHOLE OR IN PART, SHARED WITH THIRD PARTIES OR USED IN ANY MANNER ON OTHER PROJECTS OR EXTENSIONS TO THIS PROJECT WITHOUT THE PRIOR WRITTEN CONSENT OF STARBUCKS CORPORATION. THESE DRAWINGS AND SPECIFICATIONS ARE INTENDED TO EXPRESS DESIGN INTENT FOR A PROTOTYPICAL STARBUCKS STORE WHICH IS SUBJECT TO CHANGE AT ANYTIME AND DO NOT REFLECT ACTUAL SITE CONDITIONS. NEITHER PARTY SHALL HAVE ANY OBLIGATION NOR LIABILITY TO THE OTHER (EXCEPT STATED ABOVE) UNTIL A WRITTEN AGREEMENT IS FULLY EXECUTED BY BOTH PARTIES.

ARCHITECT OF RECORD

NORR

ARCHITECTS PLANNERS
325 N. LaSalle St. Suite 700 Chicago, IL 60654
t 312.424.2400 f 312.424.2424 www.norr.com

ENGINEER OF RECORD

**Engineering Consultant**

William J. Akemeyer, P.E.
353 Marshall Avenue
St. Louis, Missouri 63119
Phone (314) 772-1792
Fax (314) 772-0108

Revision Schedule				
Rev	Date	By	Description	
1	5.2.2014		LL REVIEW	

PROJECT NAME: CATHEDRAL COMMONS

PROJECT ADDRESS: WISCONSIN AVE. & IDAHO AVE.
SUITE N8
WASHINGTON, DC 20016

STORE #: 21159

PROJECT #: 53367-001

CONCEPT: CLASSIC

PALETTE: NCS

ISSUE DATE: 2014 04 01

DESIGN MANAGER: M. CLAROS

LEED® AP: E. FLEMING

PRODUCTION DESIGNER: K. LEE

CHECKED BY: NORR

SHEET TITLE:

FF AND E PLAN

SCALE: 1/4" = 1'-0"

SHEET NUMBER:

I-1105