



4 NORTH ELEVATION

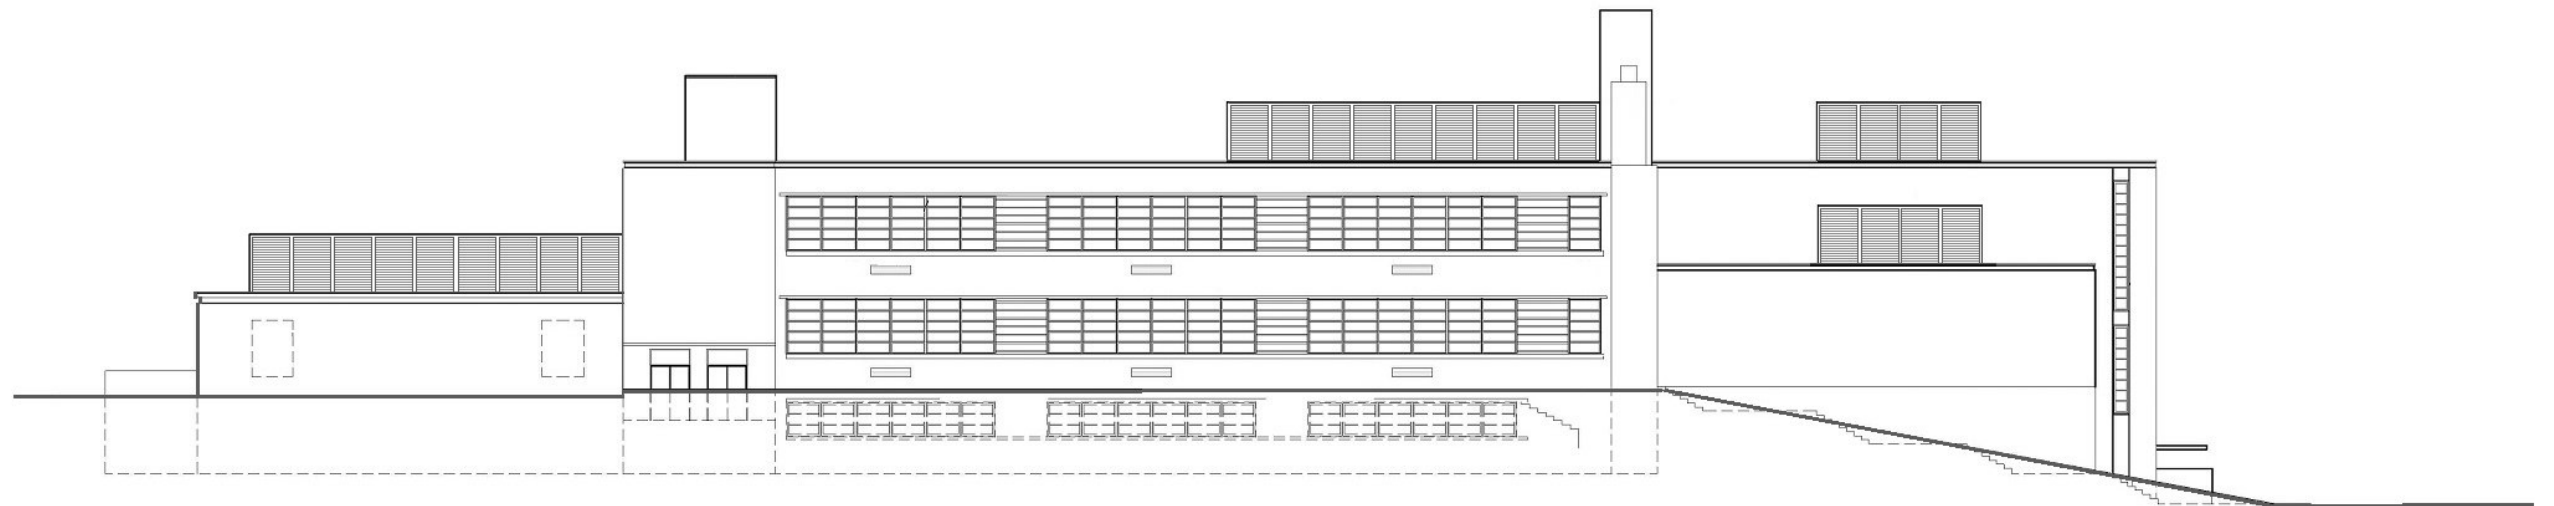


3 EAST ELEVATION

PLUMMER Elementary School

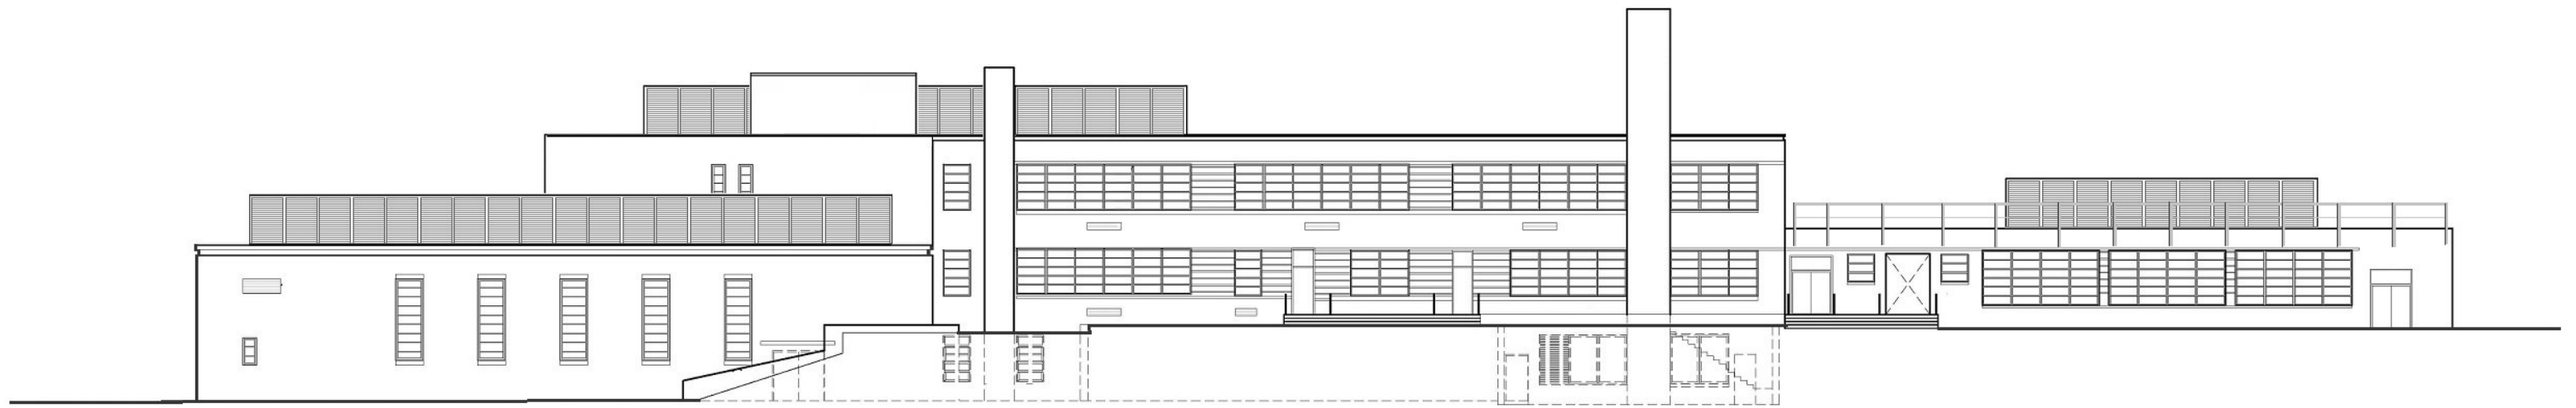


2 SOUTH ELEVATION
A2.01


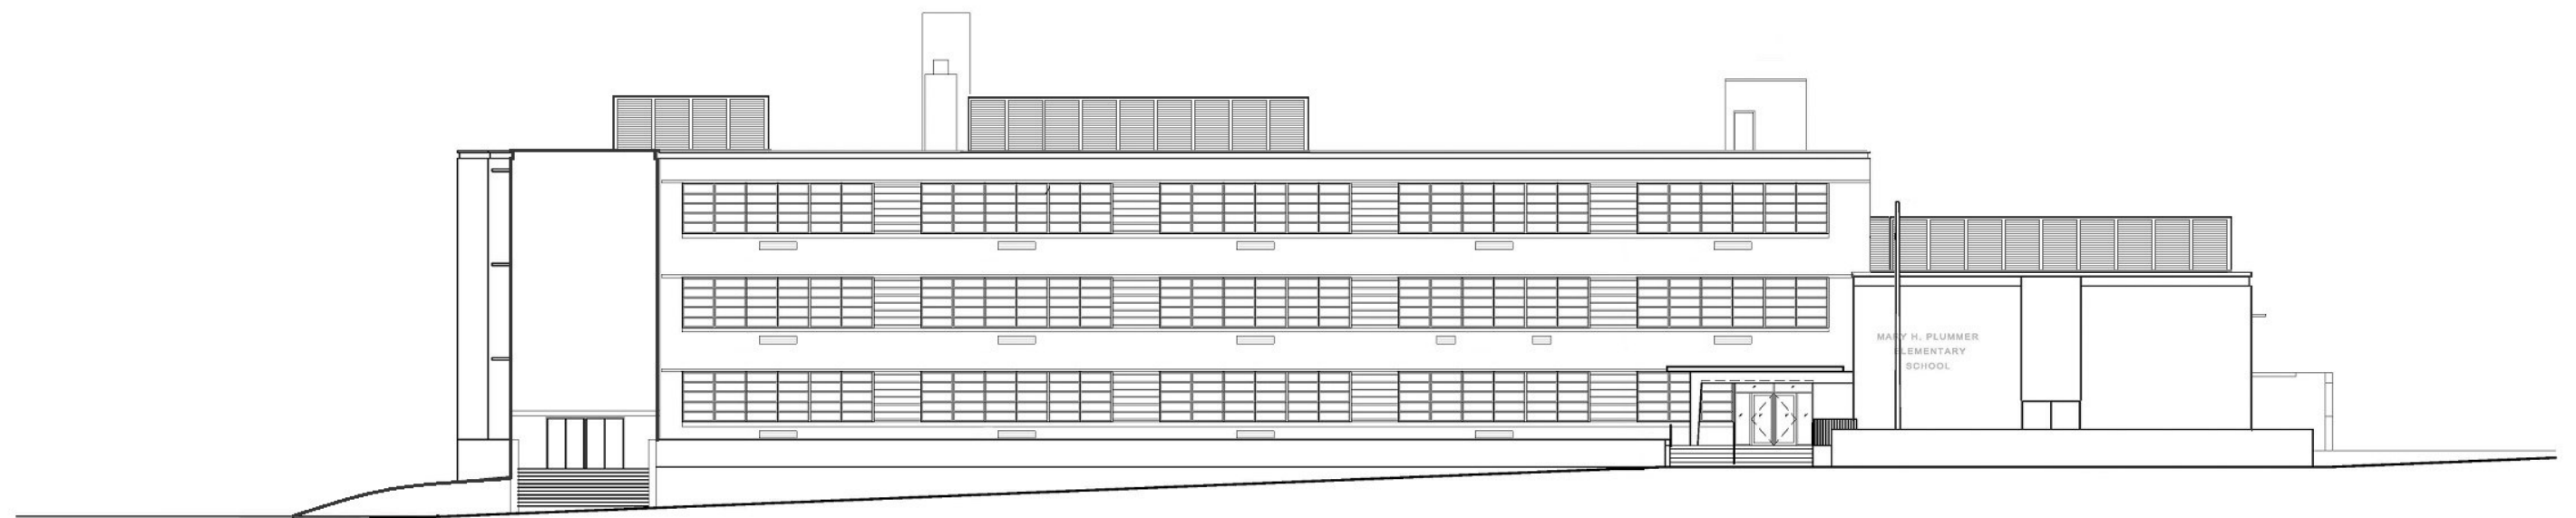


1 WEST ELEVATION
A2.01

PLUMMER Elementary School

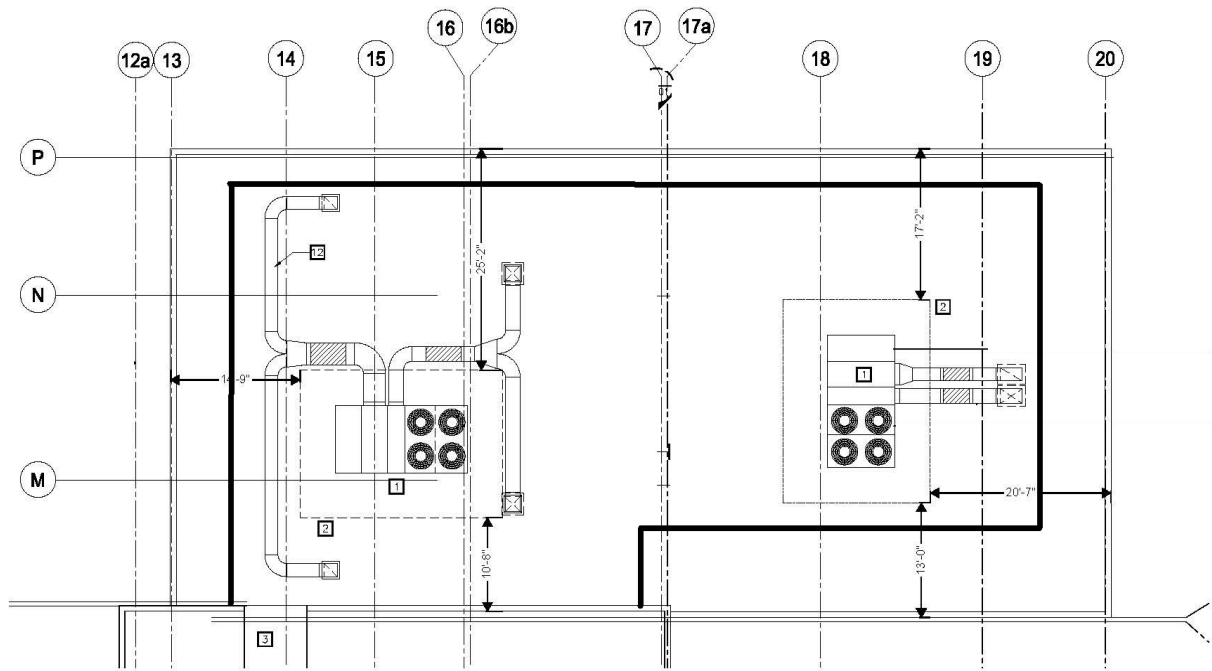

2 PART ROOF PLAN
SCALE: 1/8" = 1'-0"

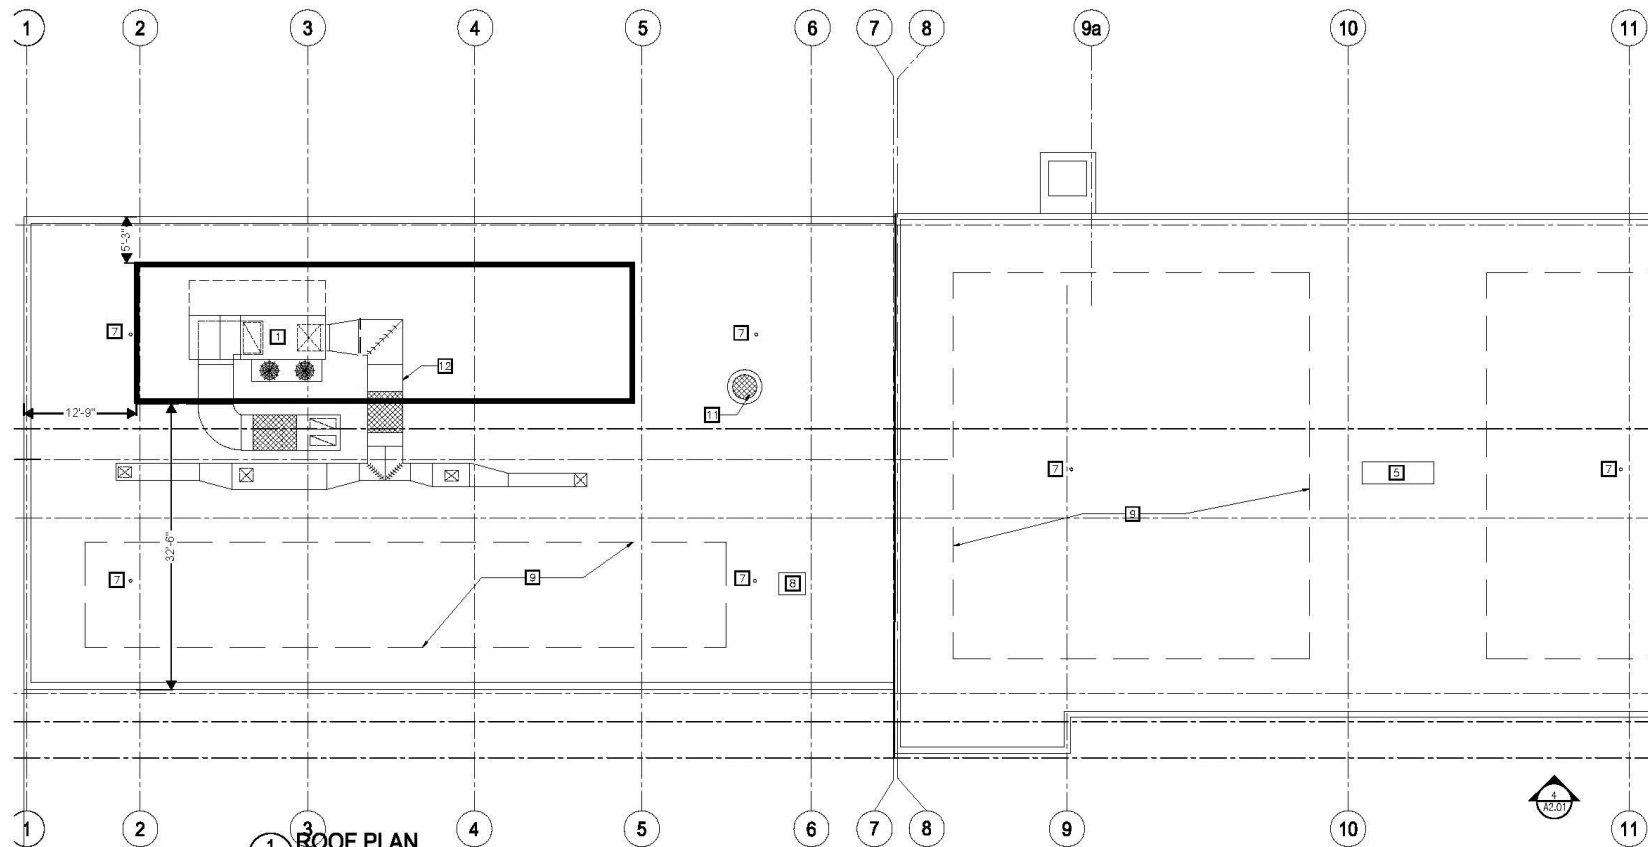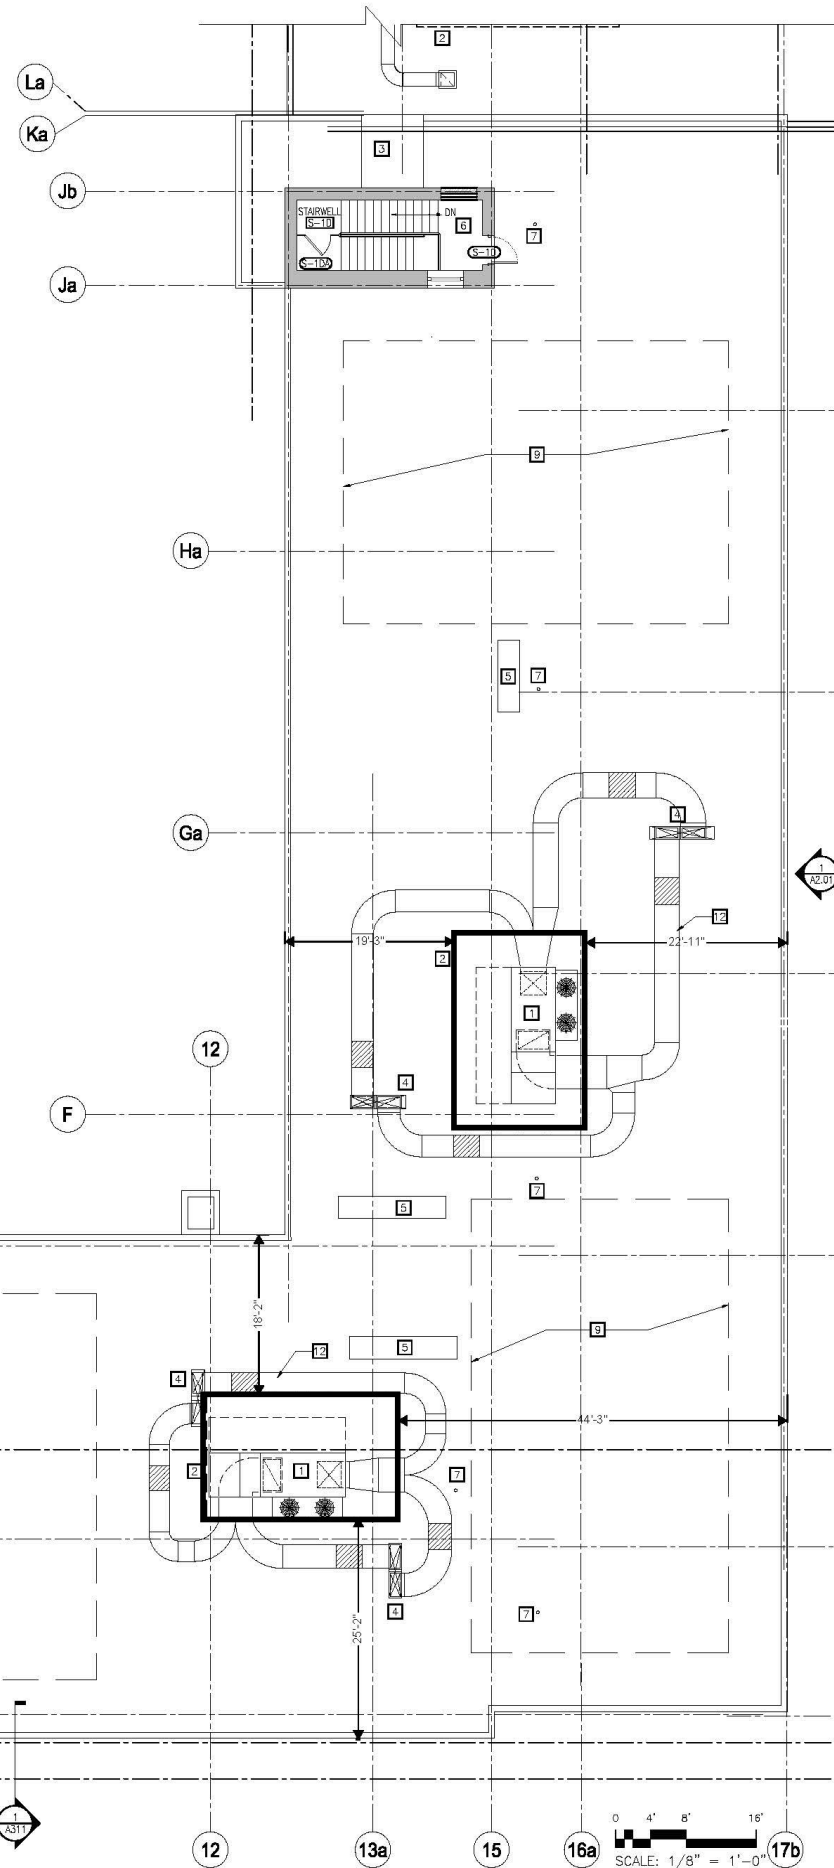


1 ROOF PLAN
SCALE: 1/8" = 1'-0"


DATE	DESCRIPTION
05.23.2014	PERMIT SUBMISSION
06.16.2014	IFC SUBMISSION

General Notes
REFERENCE MECHANICAL DRAWINGS FOR MORE INFORMATION

- ROOF PLAN KEY NOTES**
- 1 ROOF TOP UNIT- SEE HVAC DRAWINGS. PROVIDE STRUCTURAL STEEL RUNWALK TO SUPPORT MECHANICAL UNITS AS REQUIRED.
 - 2 NEW VISION PROOF LOUVERED METAL ROOFTOP SCREENING AT HEIGHT NECESSARY TO ENCLOSE ROOFTOP MECHANICAL EQUIPMENT. INCLUDE 6'-0" CLEARANCE AROUND UNITS.
 - 3 NEW ROOF EXTENSION AS REQUIRED FOR ELEVATOR OVERHULL.
 - 4 ROOF CUTOUT FOR HVAC DUCTS. ALIGN WITH HVAC SHIFTS BELOW. COORDINATE SIZE WITH MEP.
 - 5 CONDENSING UNIT- SEE HVAC DRAWINGS.
 - 6 EXISTING STAIR PENTHOUSE.
 - 7 EXISTING ROOF DRAIN.
 - 8 EXISTING ROOF HATCH.
 - 9 AVAILABLE LOCATION FOR SOLAR PV PANELS. PROVISION OF PV PANELS AND ASSOCIATED STRUCTURAL & MEP ROOF PENETRATIONS N.L.C.
 - 10 SALVAGE, MODIFY AND REINSTALL EXISTING METAL CASE ASSEMBLY FOR ROOF ACCESS CONTROL.
 - 11 NEW FAN- SEE HVAC PLAN FOR MORE INFORMATION.
 - 12 HVAC DUCTS- SHOWN FOR REFERENCE ONLY. SEE HVAC PLAN.

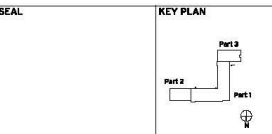

 BROUGHTON CONSTRUCTION Co., LLC
1000 17th Street, NW, Suite 400
Washington, DC 20036
T: (202) 590-0000 F: (202) 590-0001
www.broughtonconstruction.com



Sorg Architects
908 L Street NW, Washington DC 20001
T: 202.393.6445 F: 202.393.6497 sorgarchitects.com

PLUMMER ELEMENTARY SCHOOL

PHASE 1 MODERNIZATION
PREPARED FOR DISTRICT OF COLUMBIA
PUBLIC SCHOOLS DEPARTMENT OF GENERAL SERVICES

DRAWING TITLE
ROOF PLAN

DISCIPLINE	ARCH	DRAWING NUMBER
SCALE	1/8" = 1'-0"	18 June 2014
DATE	18 June 2014	VC
DRAWN BY	VC	TT
CHECKED BY	TT	1516
SORG PROJECT #	1516	