

INDEX

- 0001

COVER SHEET, INDEX, STREET VIEW PHOTO,
AND BLOCK PLAN
- A001

EXISTING SITE PLAN
- A002

PROPOSED SITE PLAN
- A003

EXISTING AND PROPOSED BASEMENT FLOOR PLANS
- A004

EXISTING AND PROPOSED FIRST FLOOR PLANS
- A005

EXISTING AND PROPOSED SECOND FLOOR PLANS
- A006

EXISTING AND PROPOSED THIRD FLOOR PLANS
- A007

EXISTING AND PROPOSED ROOF PLANS
- A008

EXISTING AND PROPOSED SOUTH-NORTH SITE SECTIONS
- A009

EXISTING AND PROPOSED NORTH-SOUTH SITE SECTIONS
- A010

EXISTING AND PROPOSED NORTH (REAR) ELEVATIONS
- A011

EXISTING AND PROPOSED EAST ELEVATIONS
- A012

EXISTING AND PROPOSED WEST ELEVATIONS
- A013

PROPOSED SECOND STORY BALCONY TRELLIS DETAIL
- A014

PROPOSED DORMER ROOF PROFILE AND SECTION DETAIL
- A015

PROPOSED INTERIOR STAIR DETAILS
- A015_A

PROPOSED INTERIOR STAIR DETAILS (REAR)
- A016

PROPOSED ADDITION WALL SECTION
- A017

PROPOSED CORNICE AND GARDEN STAIR DETAILS
- A018

ELEVATOR DETAILS
- A019

WINDOW AND DOOR SCHEDULE
- A020

WINDOW A DETAILS
- A021

DOOR B DETAILS
- A022

DOOR C DETAILS
- A023

WINDOW D DETAILS
- A024

DOOR E DETAILS
- S000

GENERAL NOTES
- S001

LOAD FACTORS, ABBREVIATIONS & SCHEDULES
- S002

FOUNDATION / BASEMENT & FIRST FLOOR FRAMING PLANS
- S003

SECOND & THIRD FLOOR FRAMING PLANS
- S004

ROOF FRAMING PLANS
- S020

UNDERPINNING SECTIONS & DETAILS



1

STREET VIEW OF 3015 P STREET, N.W.
BUILT CIRCA 1938

- M000

MECHANICAL LEGEND, SCOPE OF WORK AND NOTES
- M001

BASEMENT AND FIRST FLOOR MECHANICAL PLANS
- M002

SECOND AND THIRD FLOOR MECHANICAL PLANS

- E001

ELECTRICAL NOTES
- E002

BASEMENT AND FIRST FLOOR ELECTRICAL PLANS
- E003

SECOND AND THIRD FLOORS ELECTRICAL PLANS

- P001

PLUMBING NOTES AND GAS RISER DIAGRAM
- P002

PLUMBING RISER DIAGRAMS
- P003

BASEMENT AND FIRST FLOOR PLUMBING PLANS
- P004

SECOND AND THIRD FLOORS PLUMBING PLANS

SCOPE OF WORK

- 1) BUILD NEW ONE STORY REAR ADDITION AND BASEMENT
- 2) BUILD NEW REAR SHED DORMER
- 3) RENOVATE INTERIOR



2

BLOCK PLAN
SCALE: 1:64

CHRISTIAN ZAPATKA ARCHITECT, PLLC
1656 33rd STREET NW WASHINGTON DC 20007 202 333 2735

 
© DRAWING PROTECTED BY COPYRIGHT. THIS DRAWING
CANNOT BE DISTRIBUTED OR REPRODUCED WITHOUT WRITTEN
PERMISSION FROM CHRISTIAN ZAPATKA ARCHITECT, PLLC.

PROJECT:

MONGAN RESIDENCE
3015 "P" STREET, N.W.
WASHINGTON D.C. 20007
SQ: 1269 LOT: 801

DRAWING TITLE:

COVER
SHEET



SUBMISSION:

PERMIT


0 16' 32' 64'

DATE: JANUARY 14, 2016

SCALE: 1/64 = 1'-0"

Board of Zoning Adjustment
District of Columbia
CASE NO. 19-073
EXHIBIT NO.9

"P" STREET NW

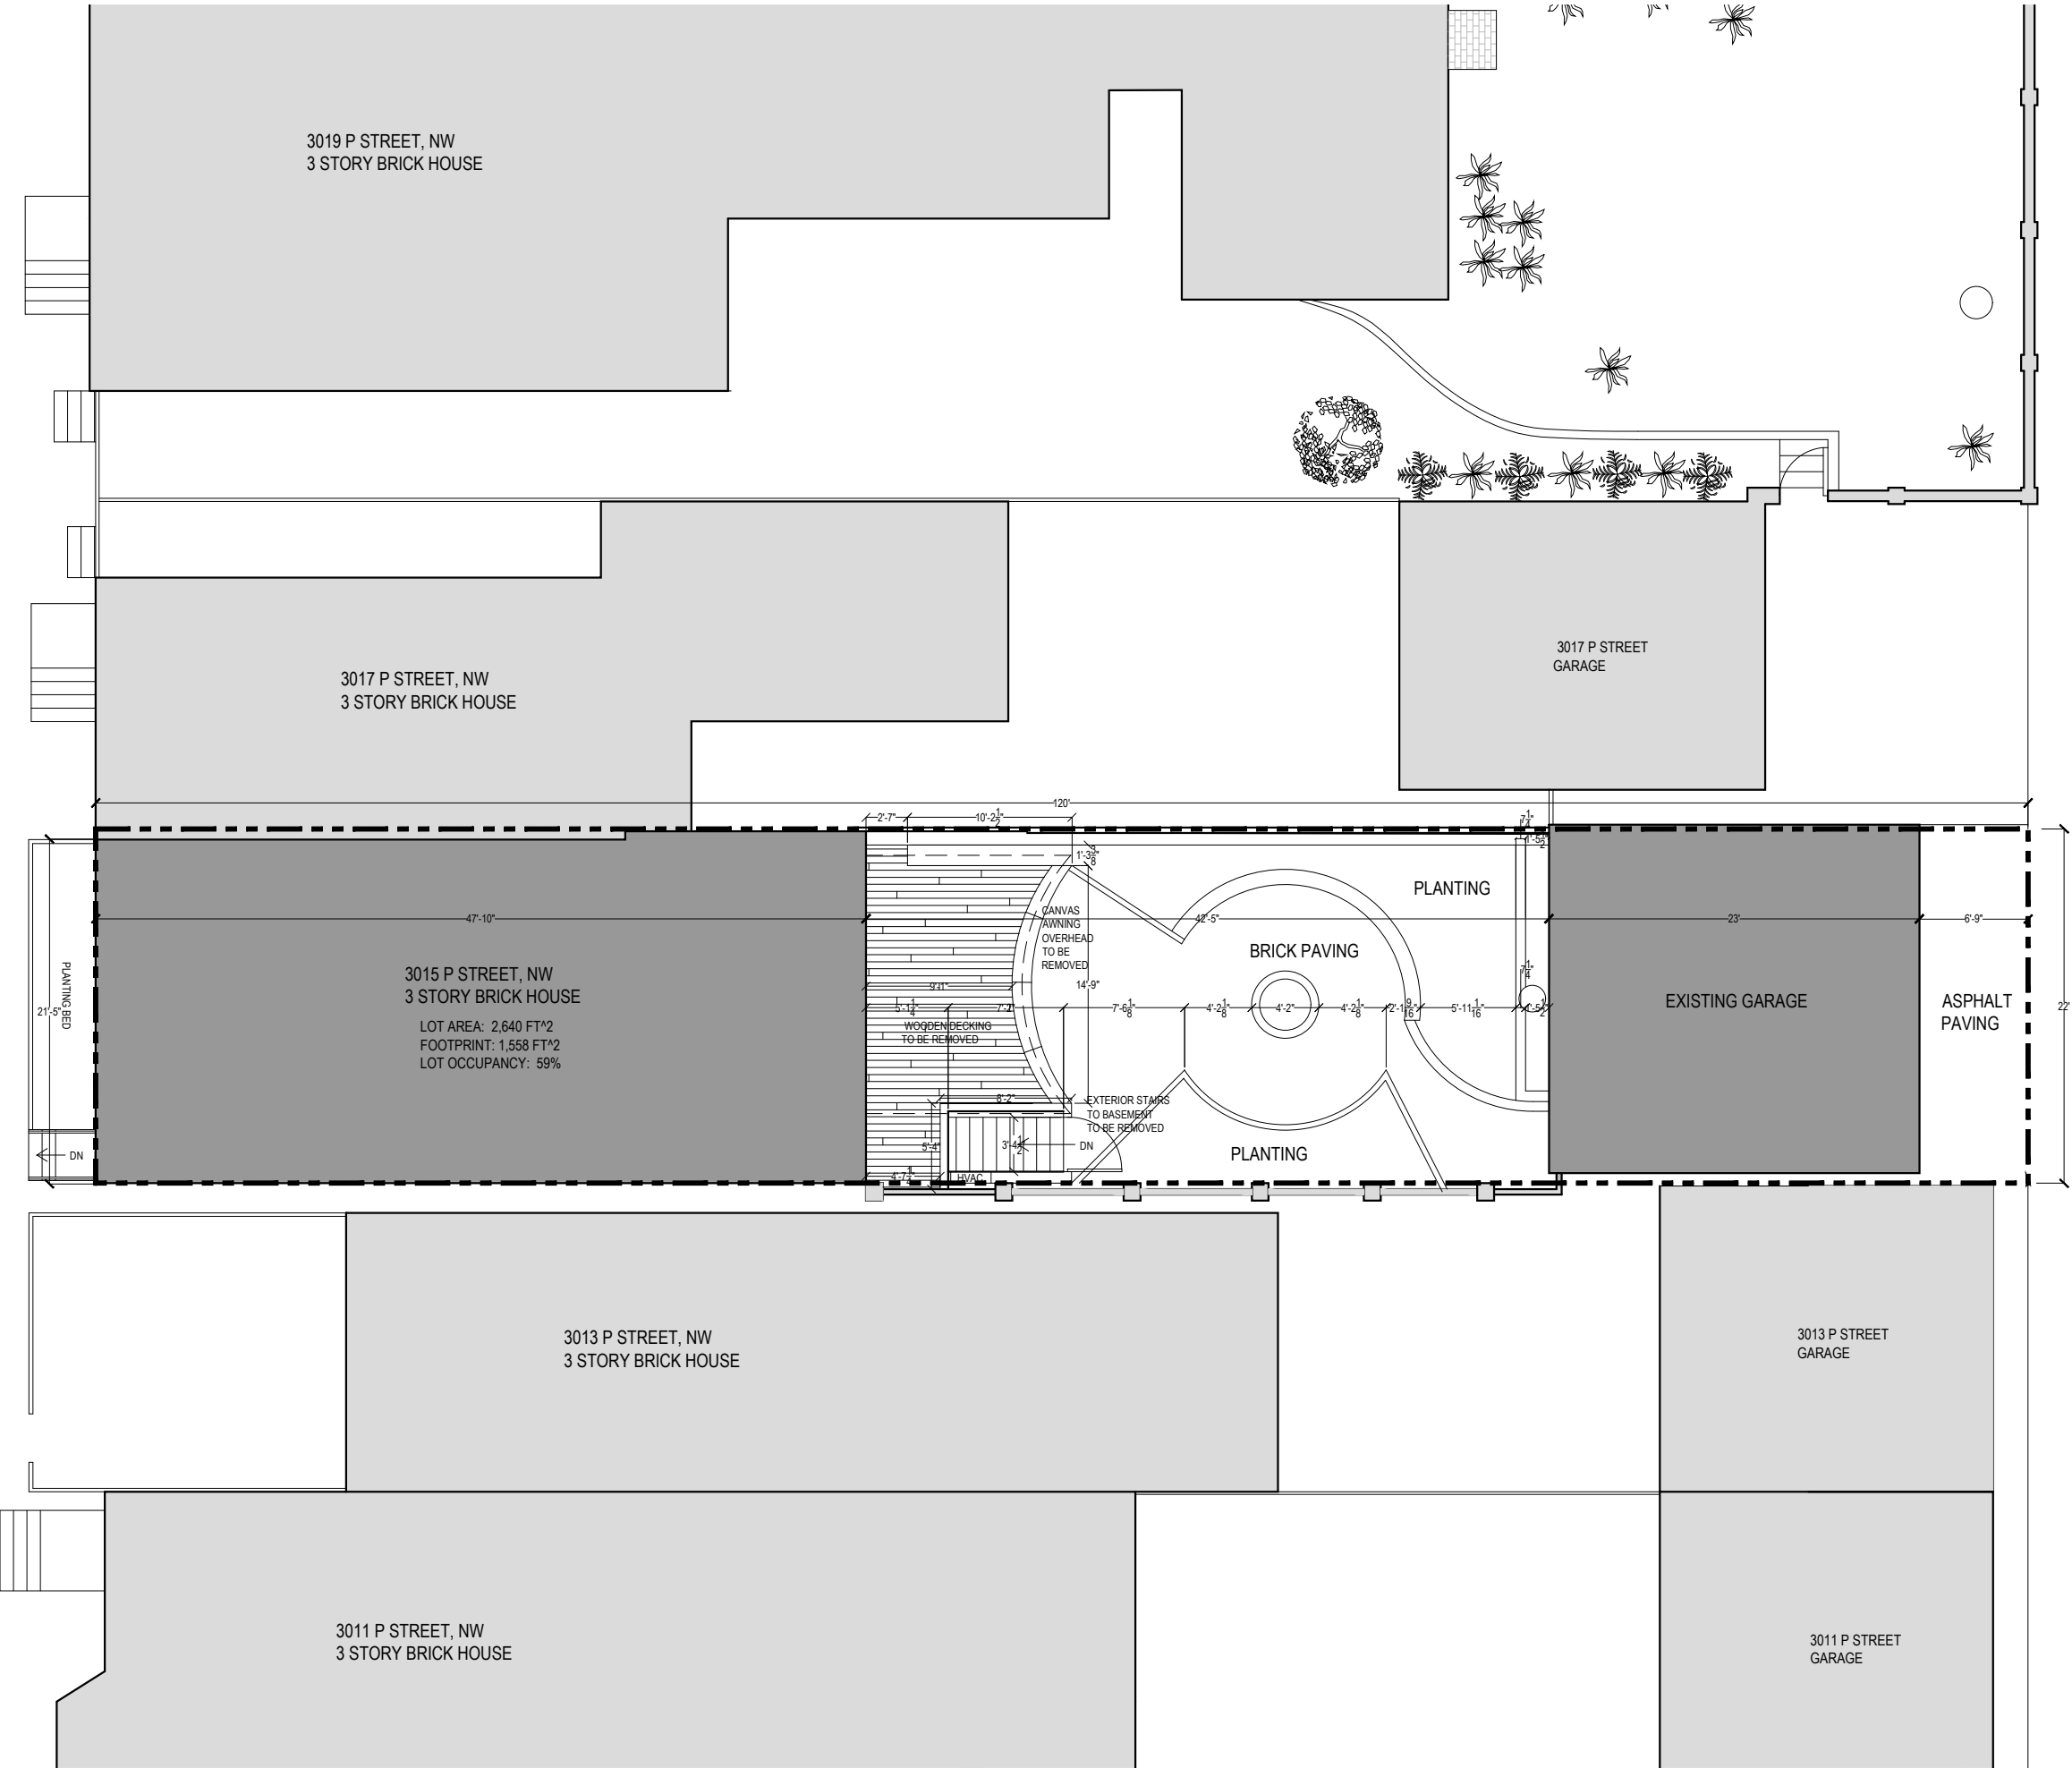


ORCHARD LANE

CHRISTIAN ZAPATKA ARCHITECT, PLLC
1656 33rd STREET NW WASHINGTON DC 20007 202 333 2735

© DRAWING PROTECTED BY COPYRIGHT. THIS DRAWING
CANNOT BE DISTRIBUTED OR REPRODUCED WITHOUT WRITTEN
PERMISSION FROM CHRISTIAN ZAPATKA ARCHITECT, PLLC.

PROJECT:

 MONGAN RESIDENCE
3015 "P" STREET, N.W.
WASHINGTON D.C. 20007
SQ: 1269 LOT: 801



DRAWING TITLE:

EXISTING
SITE PLAN

SUBMISSION:


PERMIT

DATE: JANUARY 14, 2016


SCALE: 3/32" = 1'-0"



A001

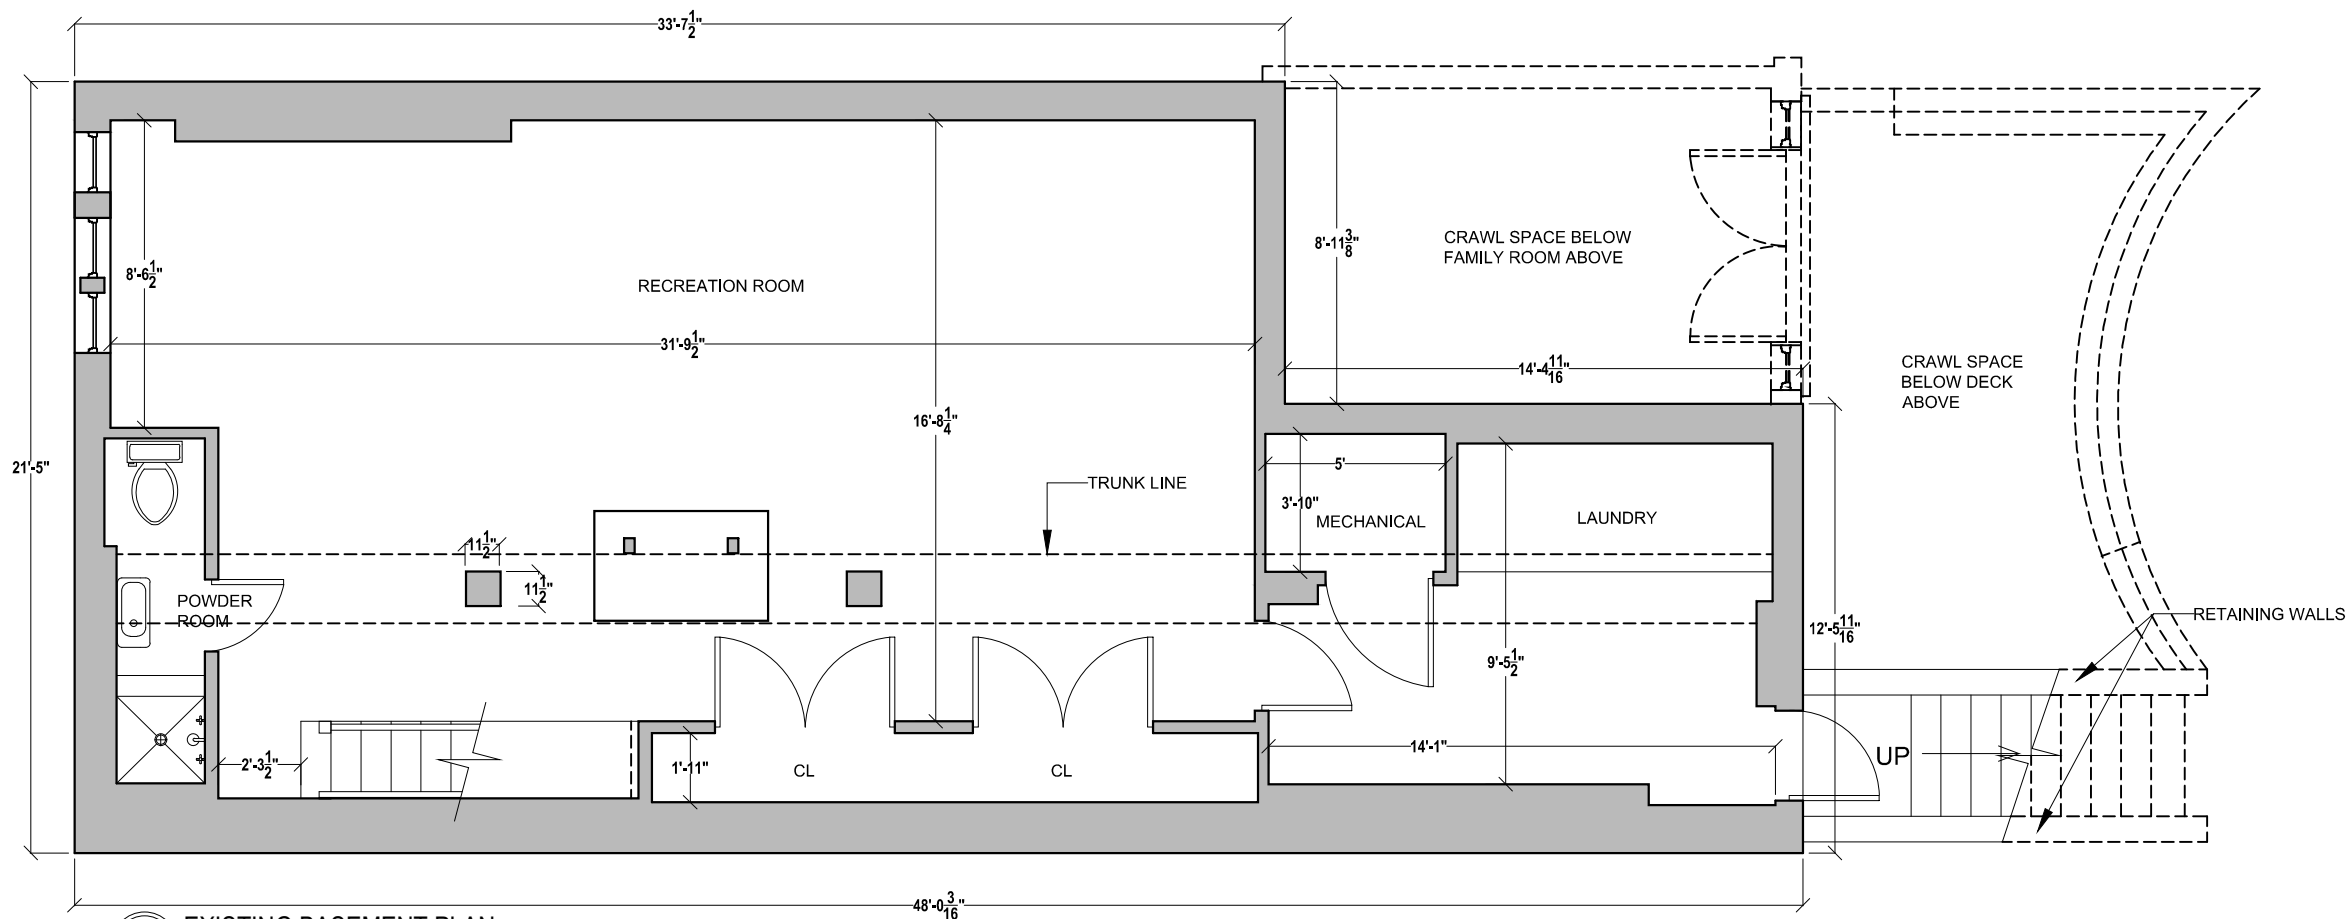

1 EXISTING BASEMENT PLAN

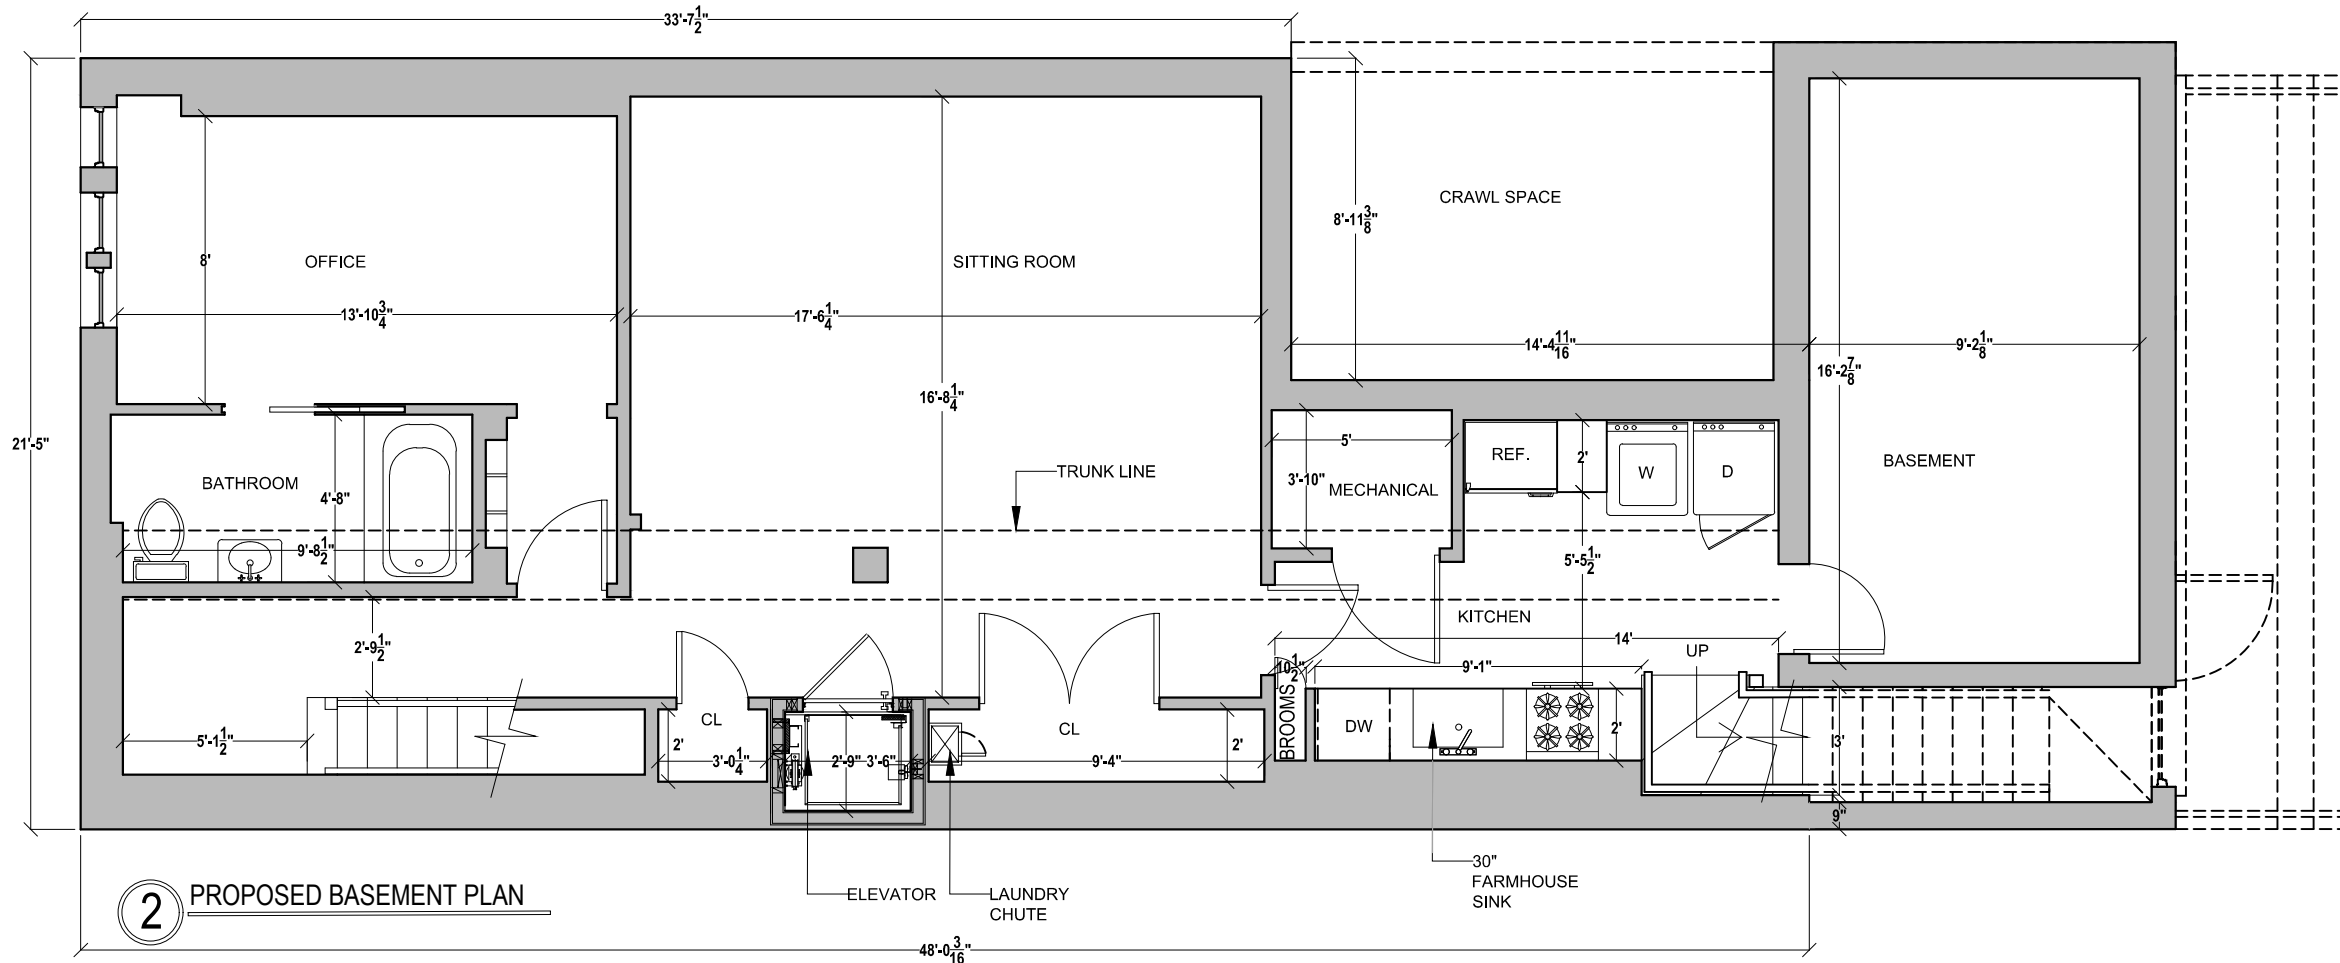


2 PROPOSED BASEMENT PLAN

CHRISTIAN ZAPATKA ARCHITECT, PLLC
1656 33rd STREET NW WASHINGTON DC 20007 202 333 2735

© DRAWING PROTECTED BY COPYRIGHT. THIS DRAWING
CANNOT BE DISTRIBUTED OR REPRODUCED WITHOUT WRITTEN
PERMISSION FROM CHRISTIAN ZAPATKA ARCHITECT, PLLC.

PROJECT:

 MONGAN RESIDENCE
3015 "P" STREET, N.W.
WASHINGTON D.C. 20007
SQ: 1269 LOT: 801



DRAWING TITLE:

**EXISTING AND
PROPOSED
BASEMENT PLANS**

SUBMISSION:



PERMIT

DATE: JANUARY 14, 2016

SCALE: 3/16" = 1'-0"



A003

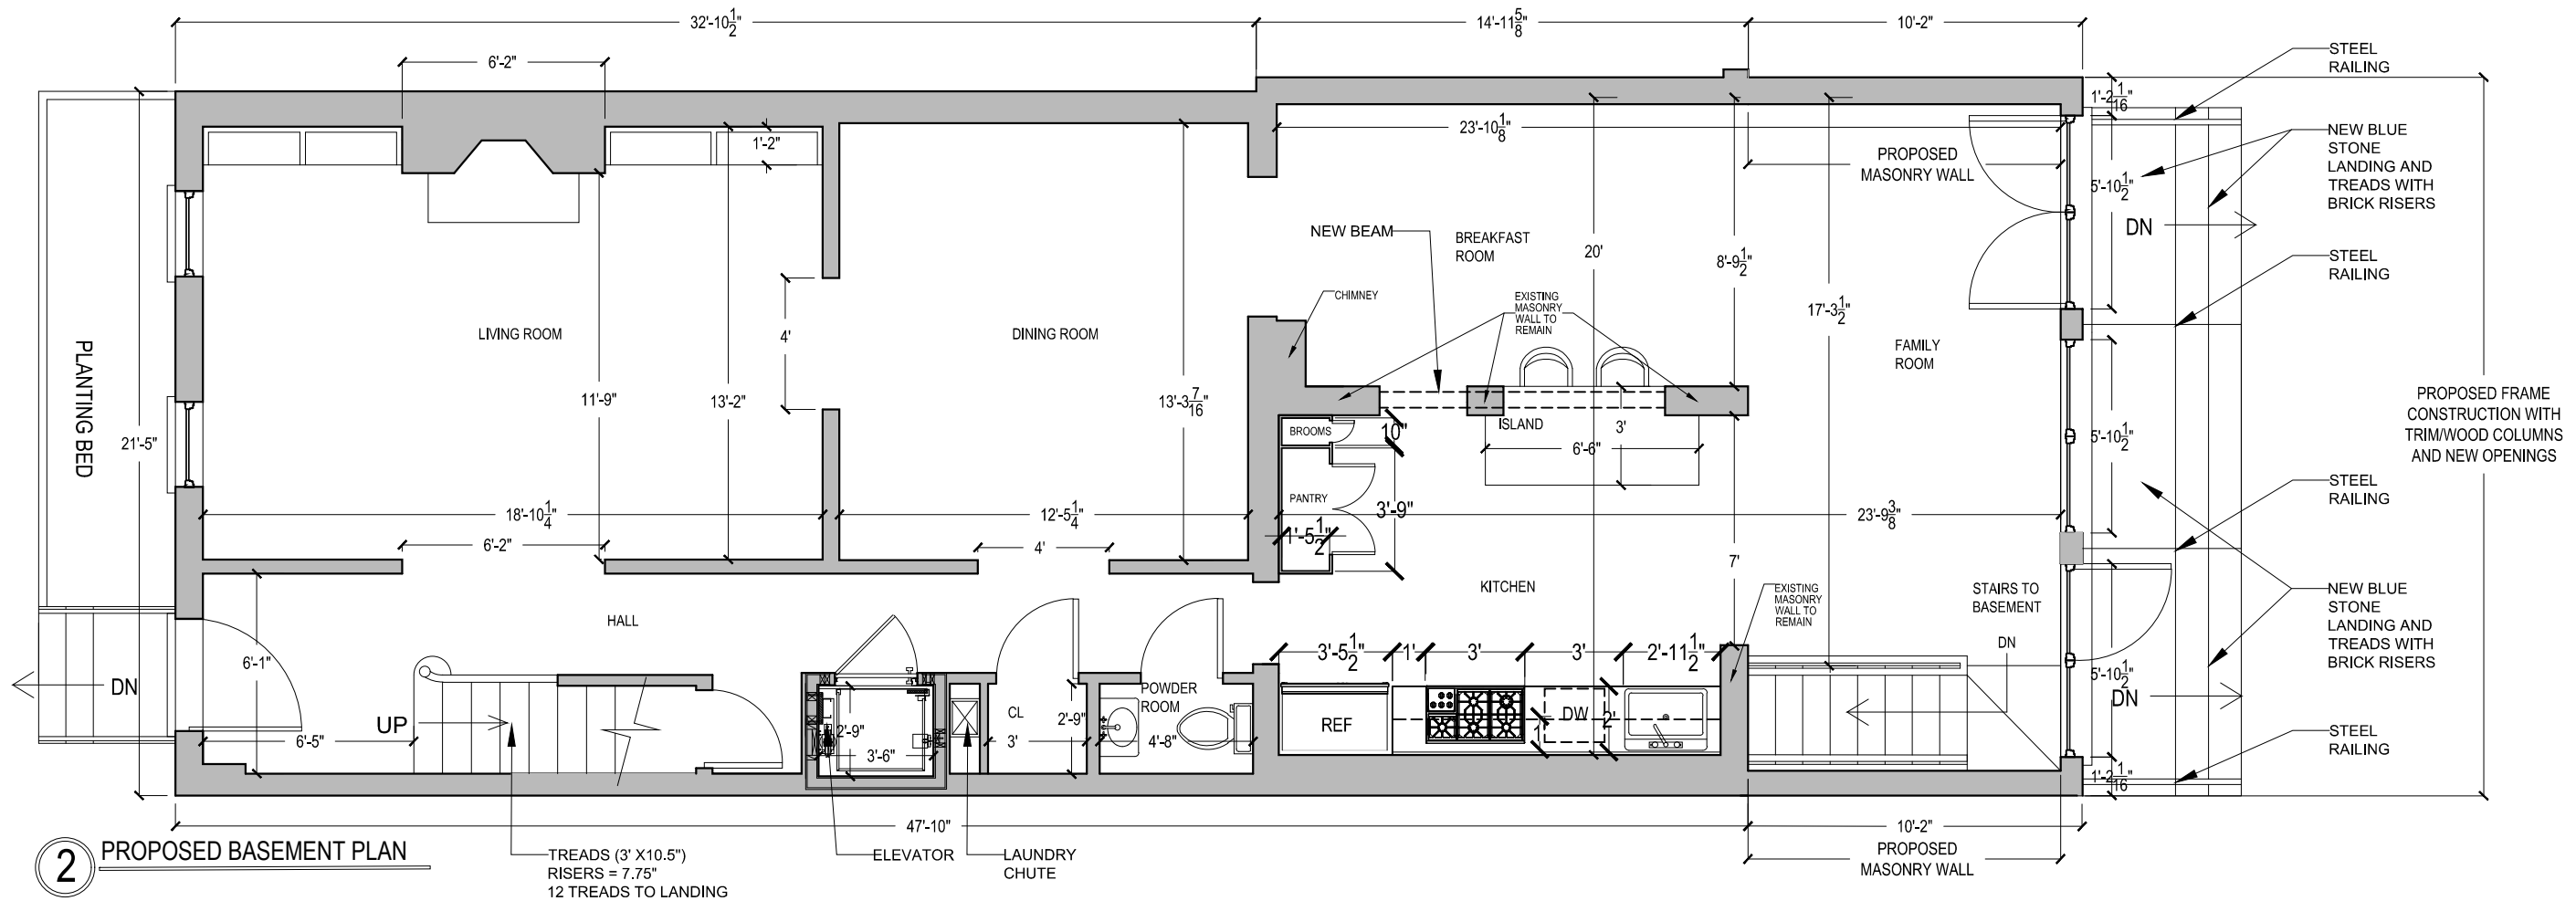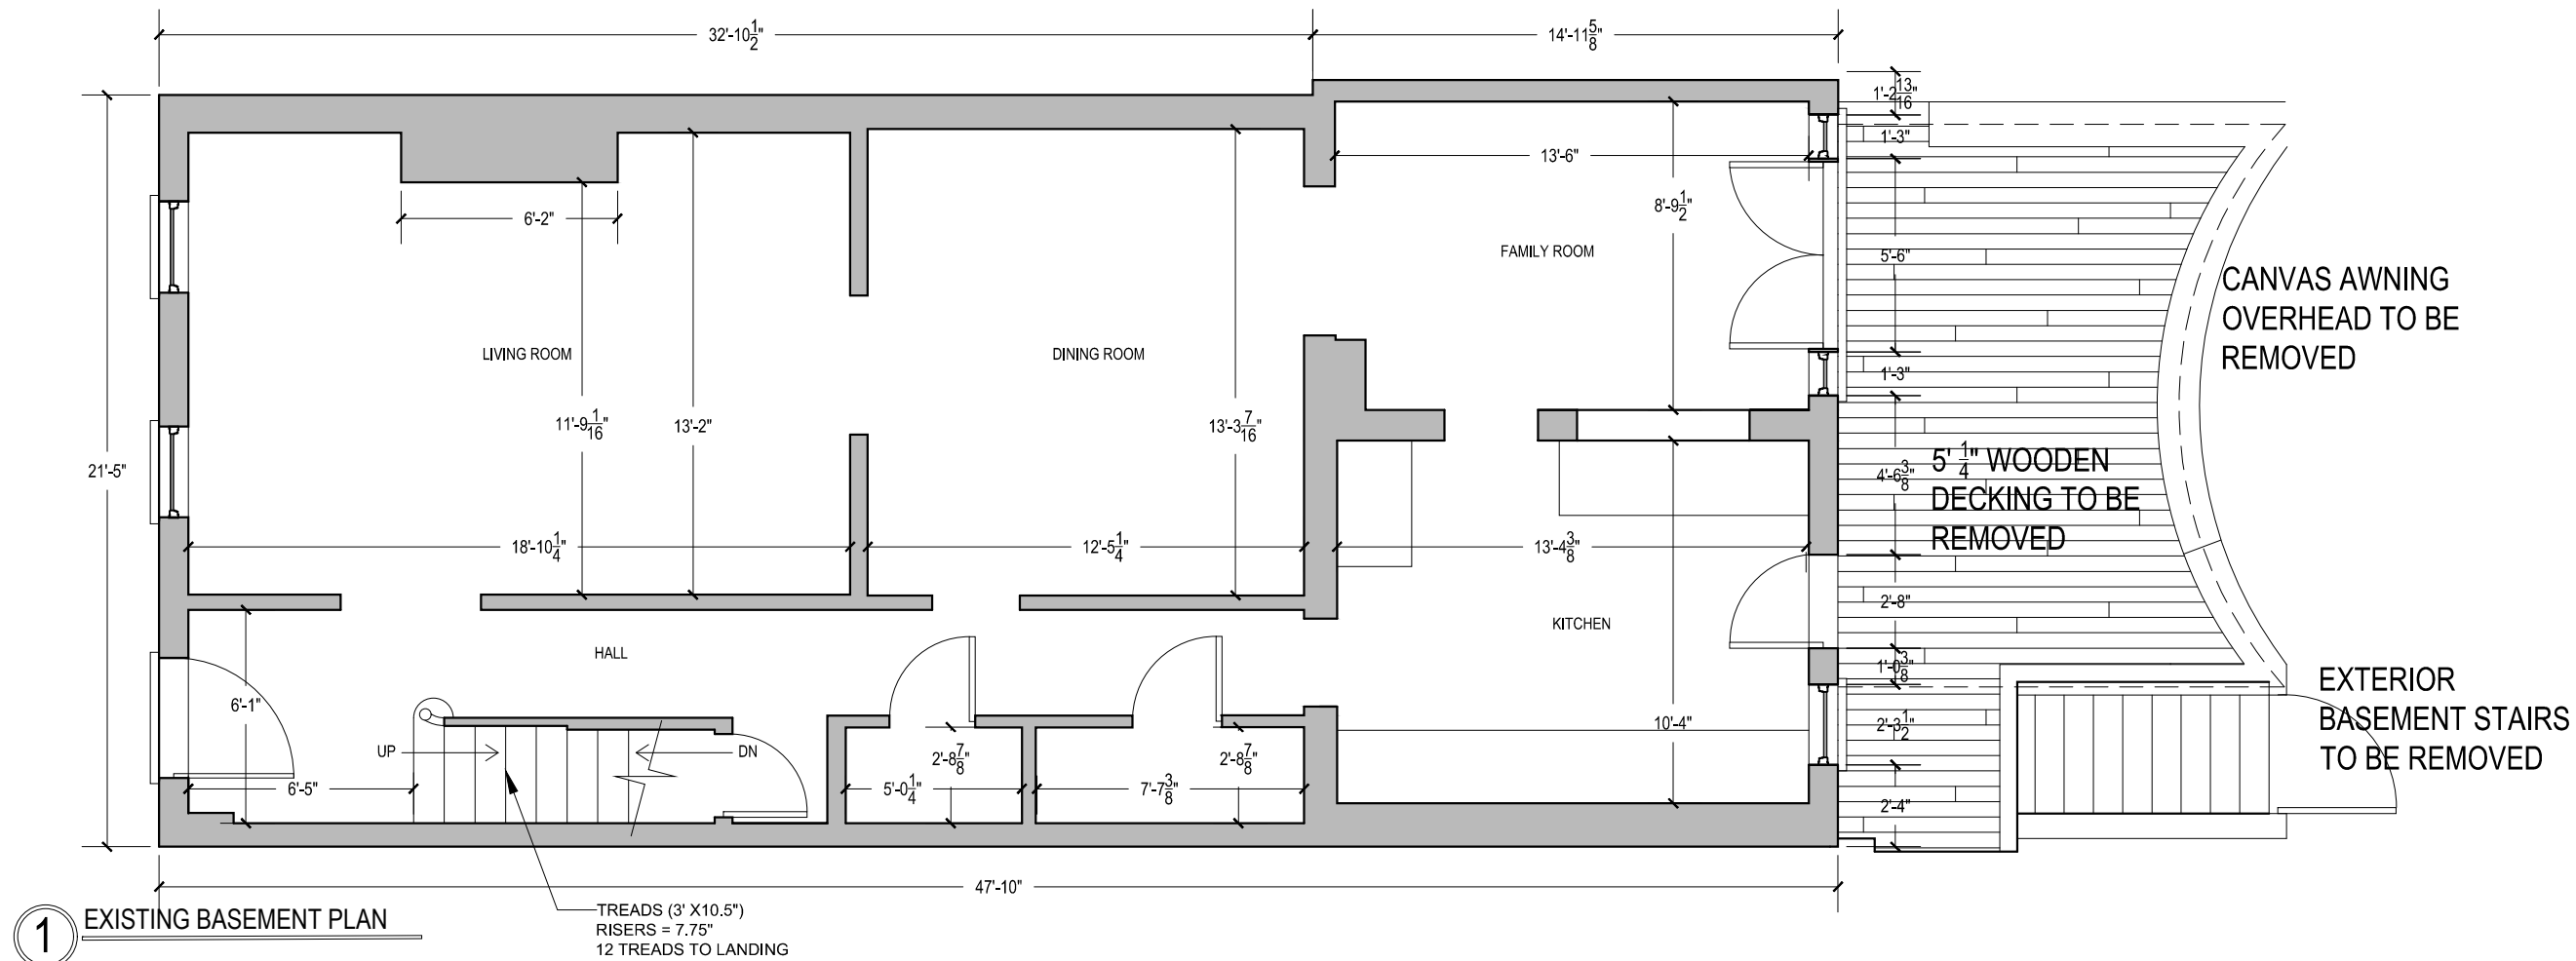


CHRISTIAN ZAPATKA ARCHITECT, PLLC
1656 33rd STREET NW WASHINGTON DC 20007 202 333 2735

© DRAWING PROTECTED BY COPYRIGHT. THIS DRAWING
CANNOT BE DISTRIBUTED OR REPRODUCED WITHOUT WRITTEN
PERMISSION FROM CHRISTIAN ZAPATKA ARCHITECT, PLLC.

PROJECT:

MONGAN RESIDENCE
3015 "P" STREET, N.W.
WASHINGTON D.C. 20007
SQ: 1269 LOT: 801

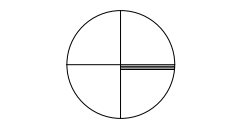

DRAWING TITLE:

**EXISTING AND
PROPOSED FIRST
FLOOR PLANS**

SUBMISSION:


PERMIT

DATE: JANUARY 14, 2016


SCALE: 3/16" = 1'-0"

0 2' 4' 6'

A004

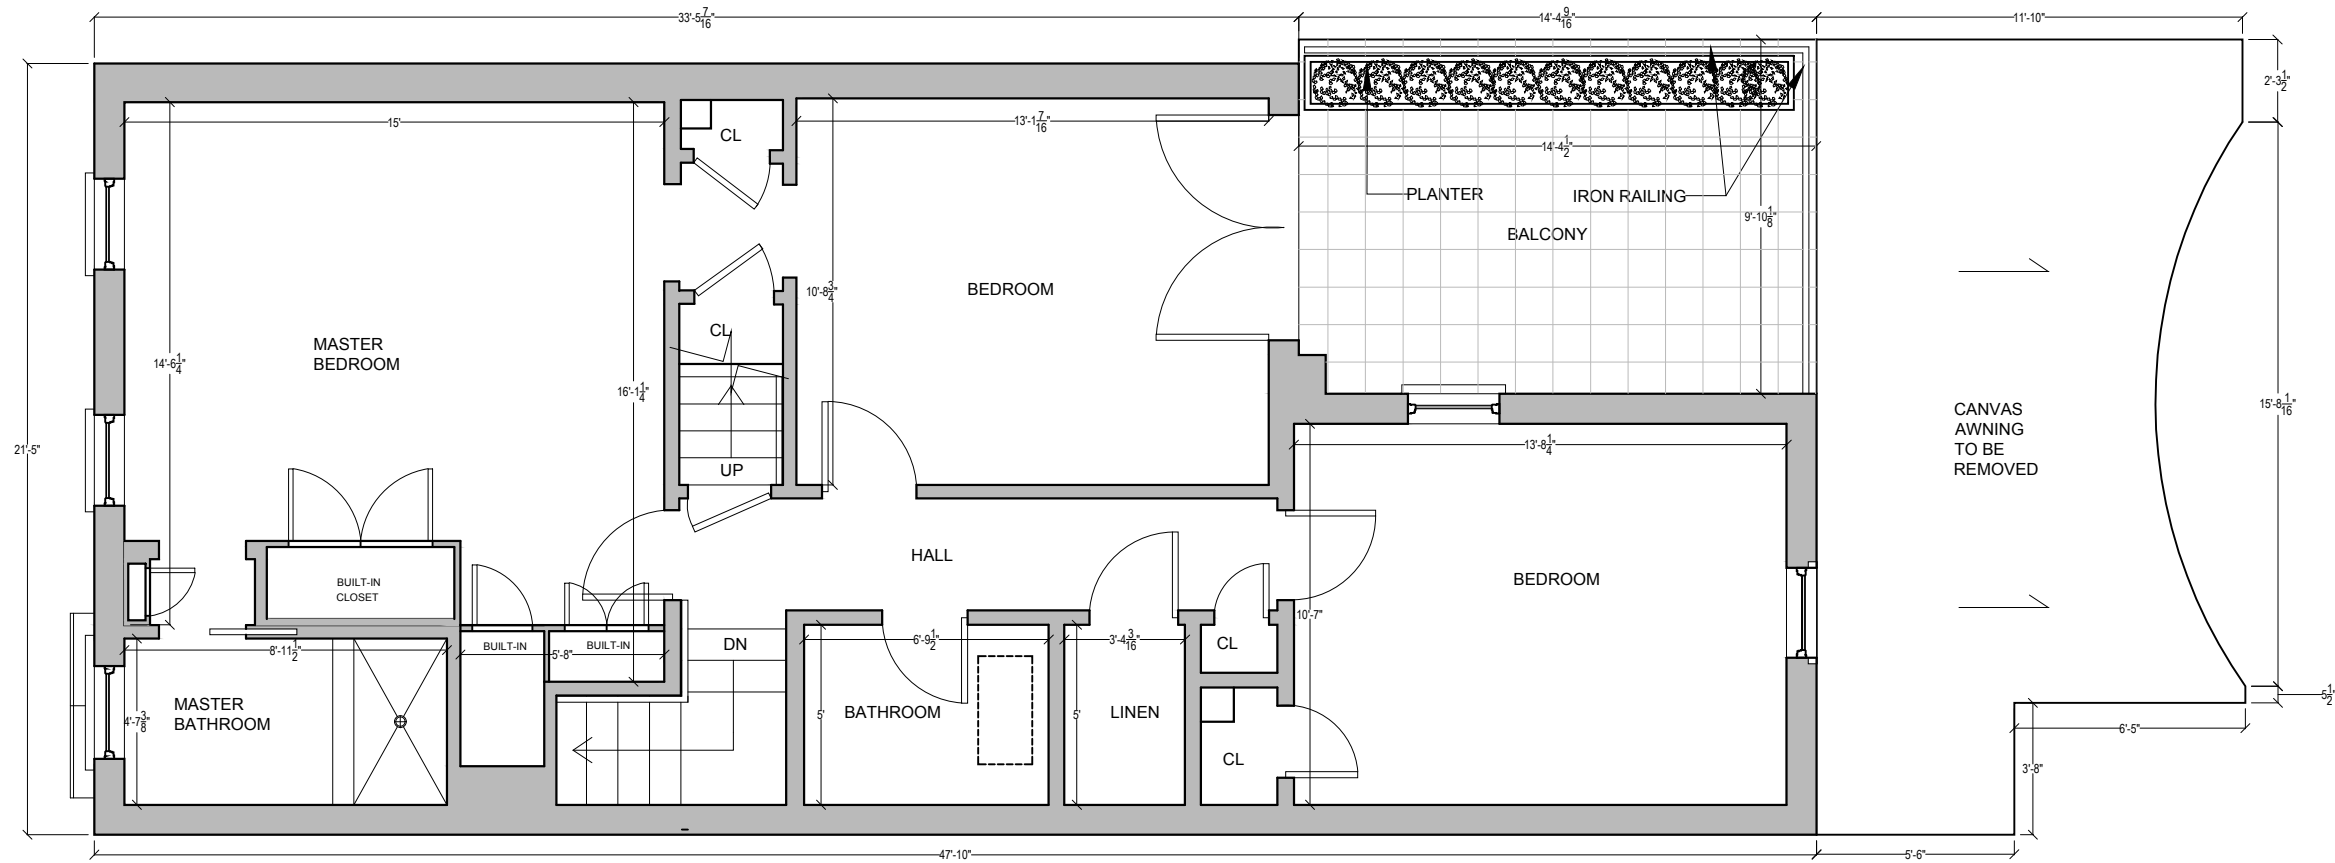

1 EXISTING SECOND FLOOR PLAN

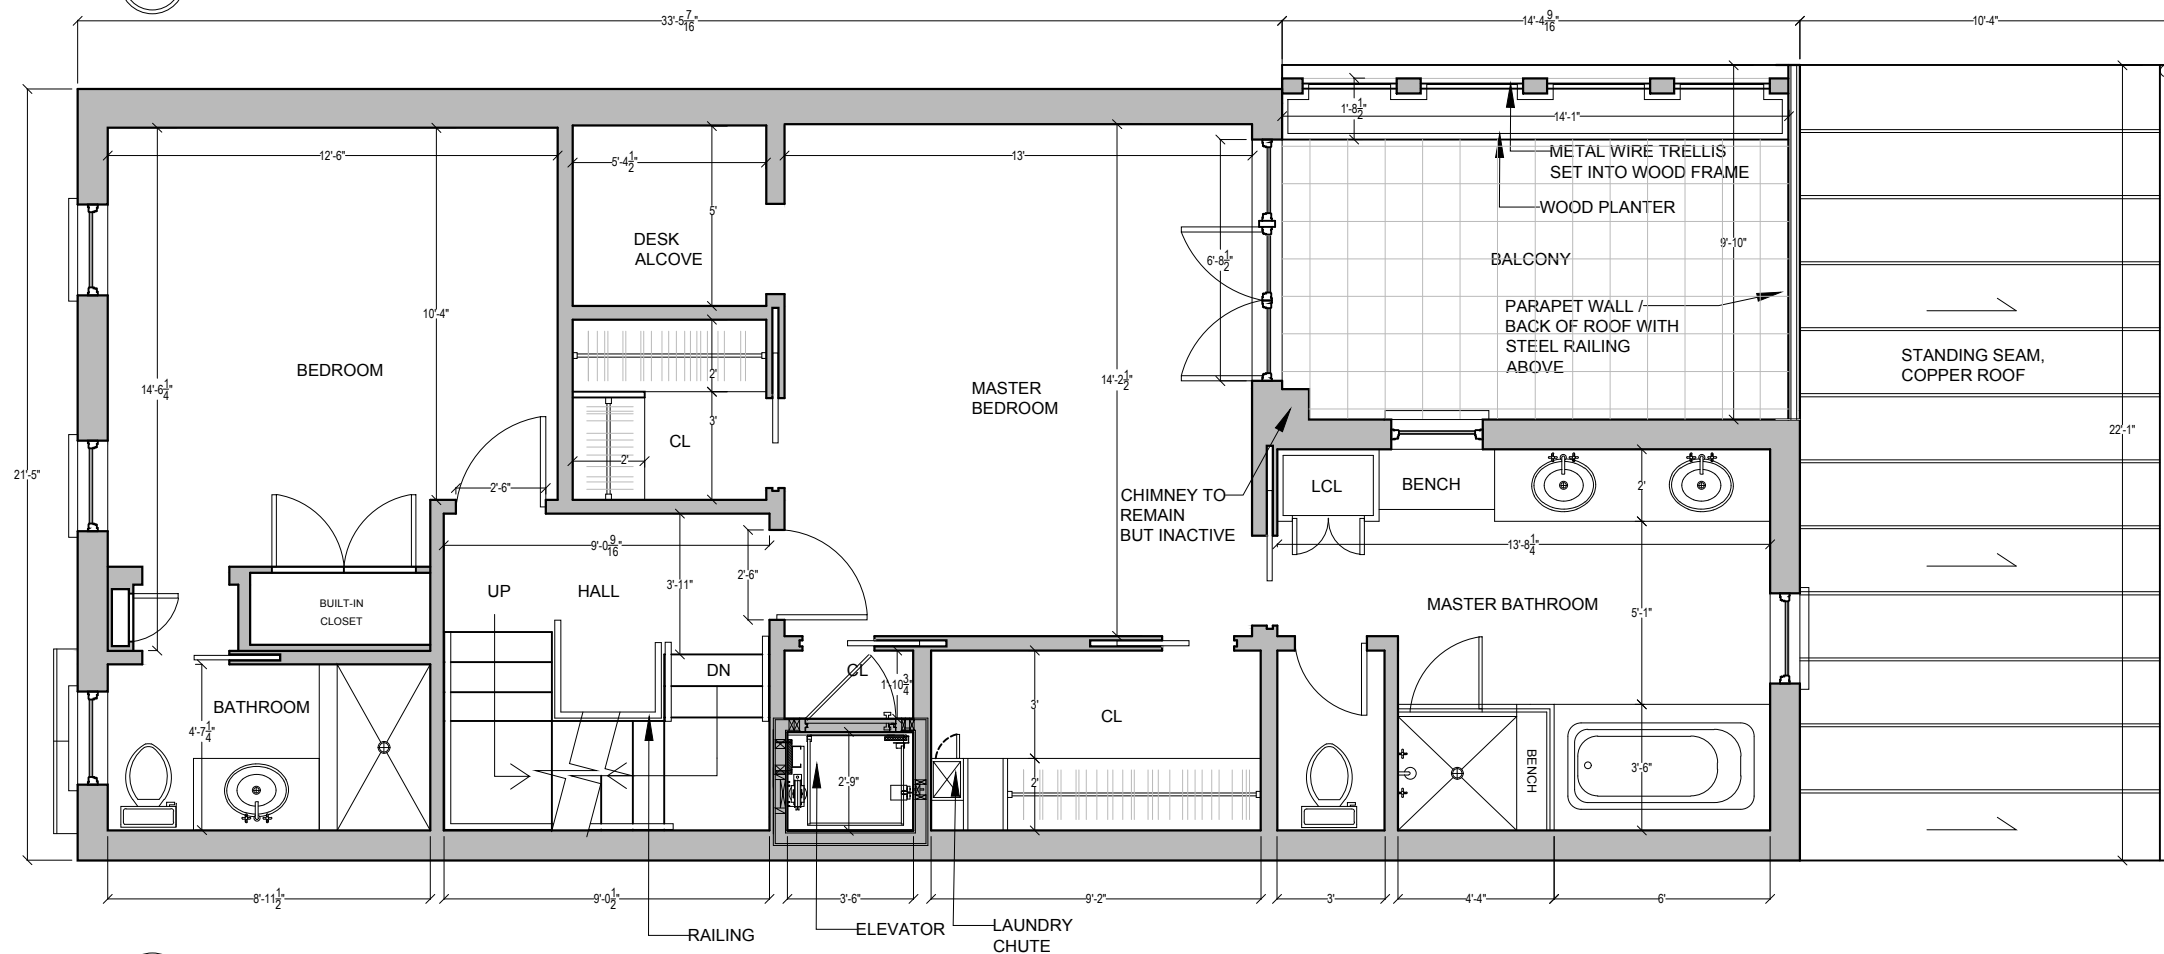


2 PROPOSED SECOND FLOOR PLAN

CHRISTIAN ZAPATKA ARCHITECT, PLLC
1656 33rd STREET NW WASHINGTON DC 20007 202 333 2735

© DRAWING PROTECTED BY COPYRIGHT. THIS DRAWING
CANNOT BE DISTRIBUTED OR REPRODUCED WITHOUT WRITTEN
PERMISSION FROM CHRISTIAN ZAPATKA ARCHITECT, PLLC.

 
PROJECT:
MONGAN RESIDENCE
3015 "P" STREET, N.W.
WASHINGTON D.C. 20007
SQ: 1269 LOT: 801




DRAWING TITLE:
EXISTING AND
PROPOSED
SECOND FLOOR
PLANS

SUBMISSION:
PERMIT
DATE: JANUARY 14, 2016
SCALE: 3/16" = 1'-0"
0 2' 4' 6'

A005

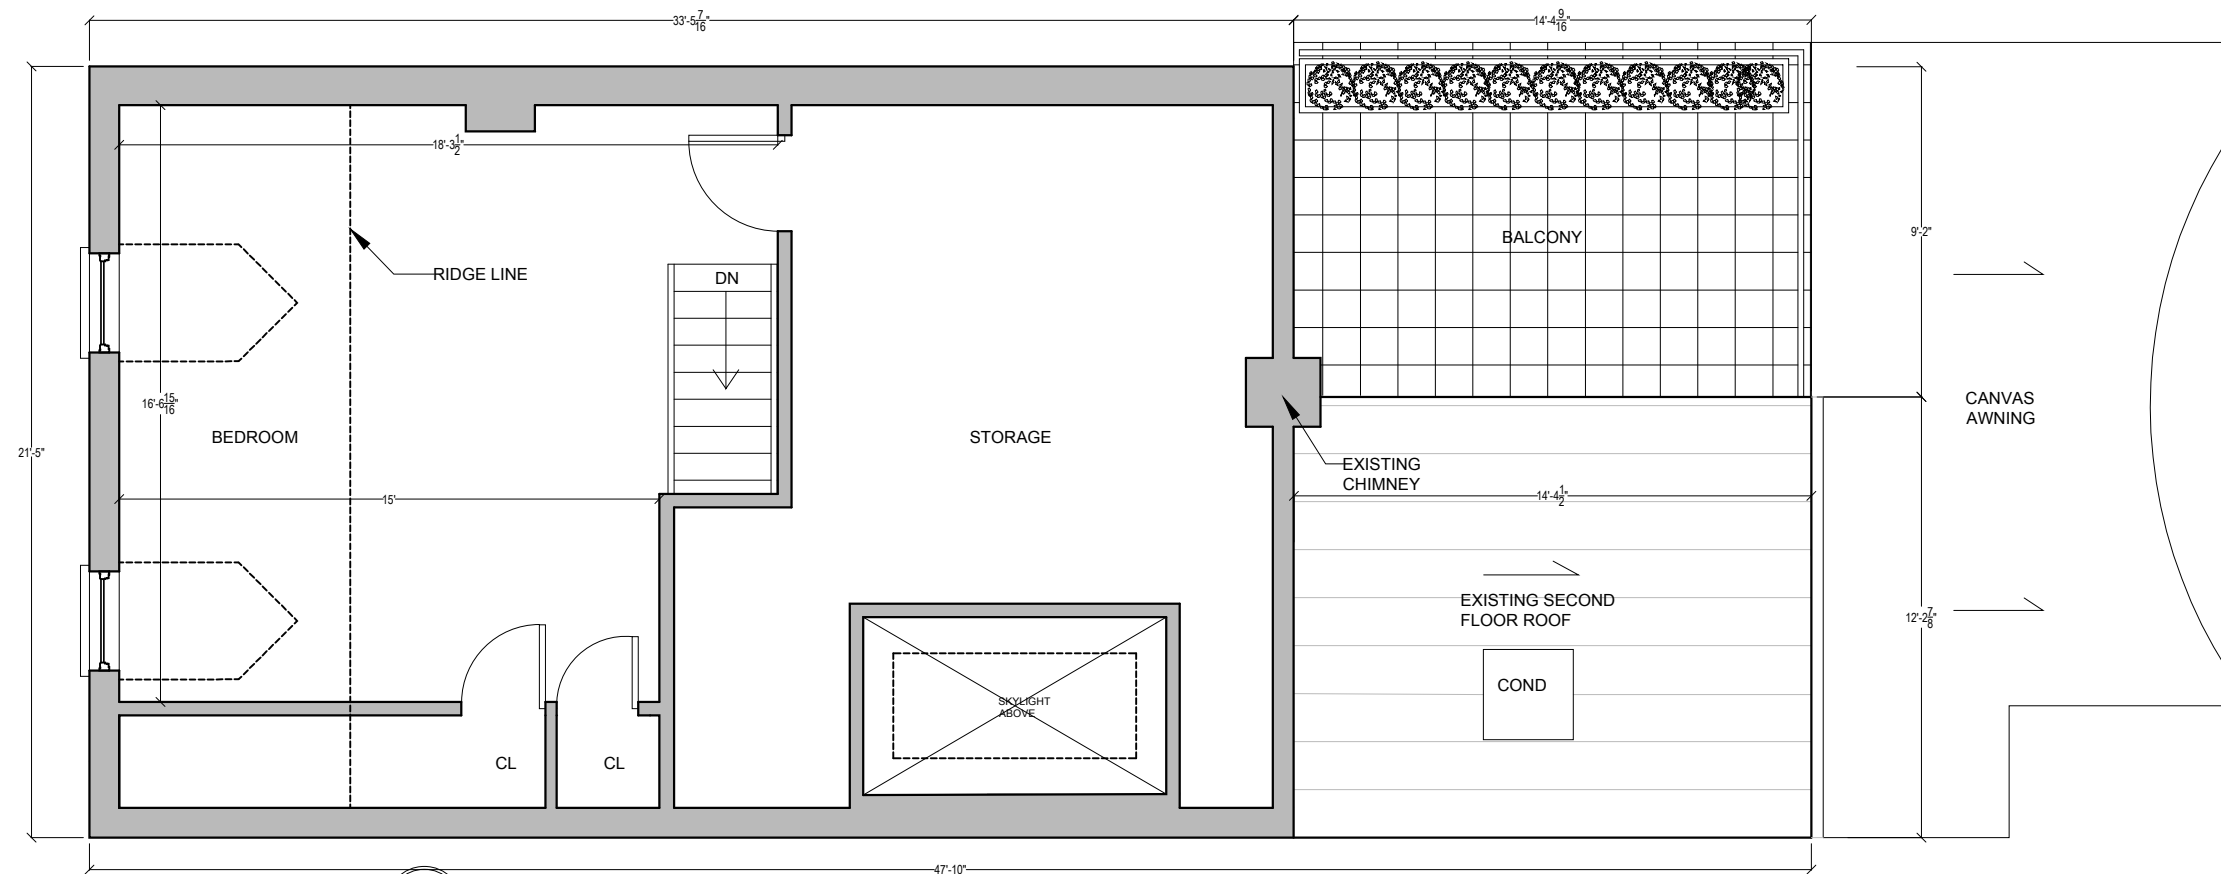

1 EXISTING THIRD FLOOR PLAN

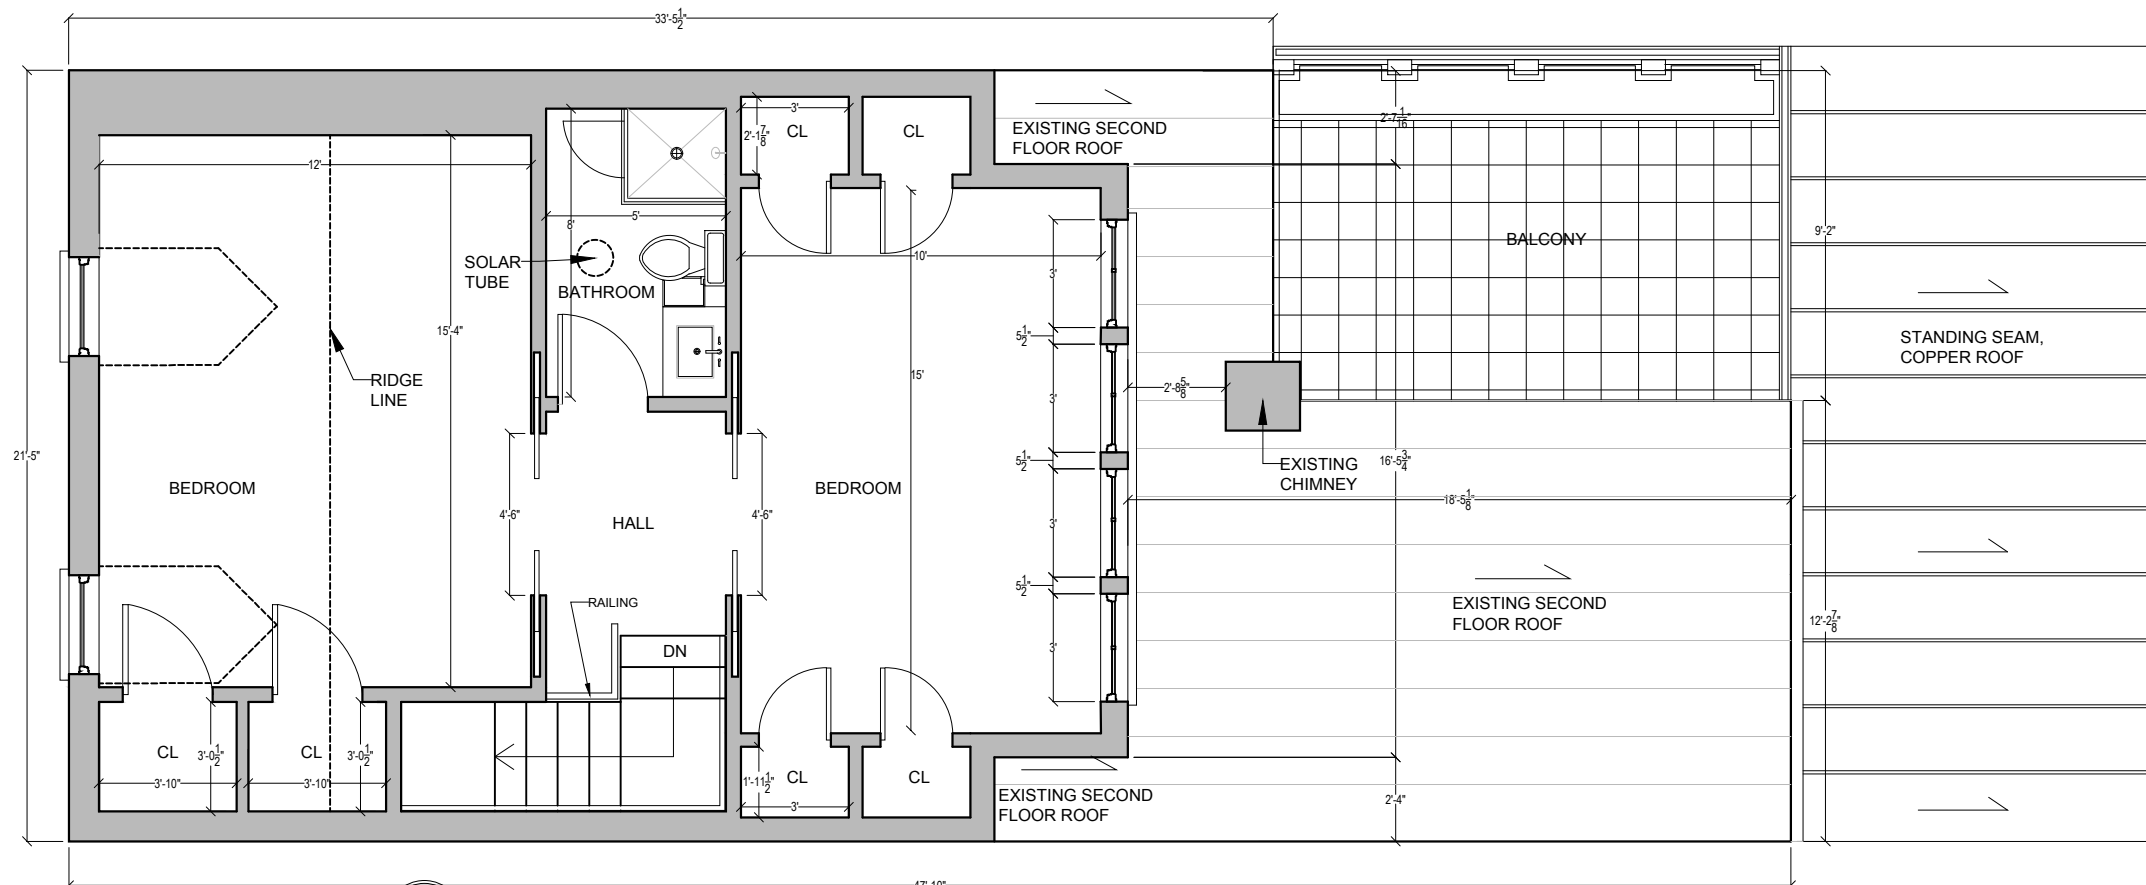


2 PROPOSED THIRD FLOOR PLAN

CHRISTIAN ZAPATKA ARCHITECT, PLLC
1656 33rd STREET NW WASHINGTON DC 20007 202 333 2735

© DRAWING PROTECTED BY COPYRIGHT. THIS DRAWING
CANNOT BE DISTRIBUTED OR REPRODUCED WITHOUT WRITTEN
PERMISSION FROM CHRISTIAN ZAPATKA ARCHITECT, PLLC.

PROJECT:

 MONGAN RESIDENCE
3015 "P" STREET, N.W.
WASHINGTON D.C. 20007
SQ: 1269 LOT: 801



DRAWING TITLE:

**EXISTING AND
PROPOSED THIRD
FLOOR PLANS**

SUBMISSION:


PERMIT

DATE: JANUARY 14, 2016


SCALE: 3/16 = 1'-0"

0 2' 4' 6'

A006

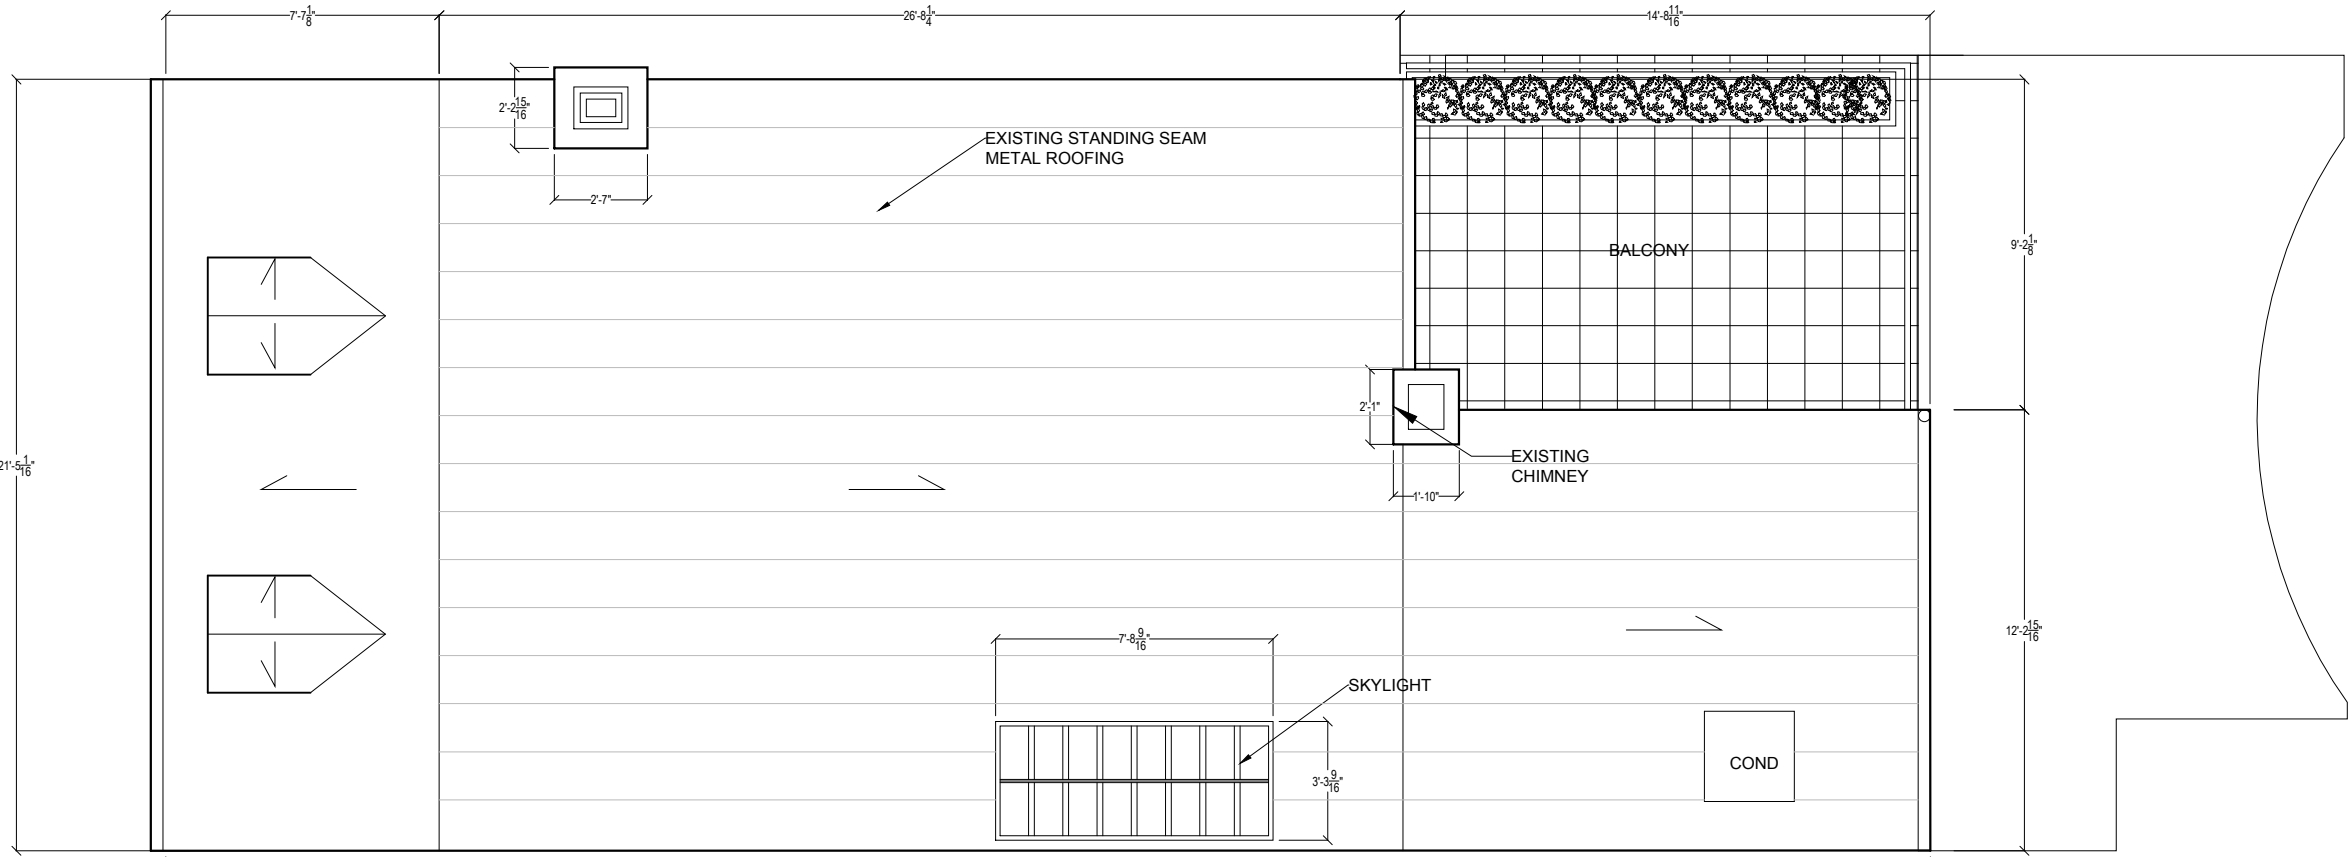

1 EXISTING ROOF PLAN

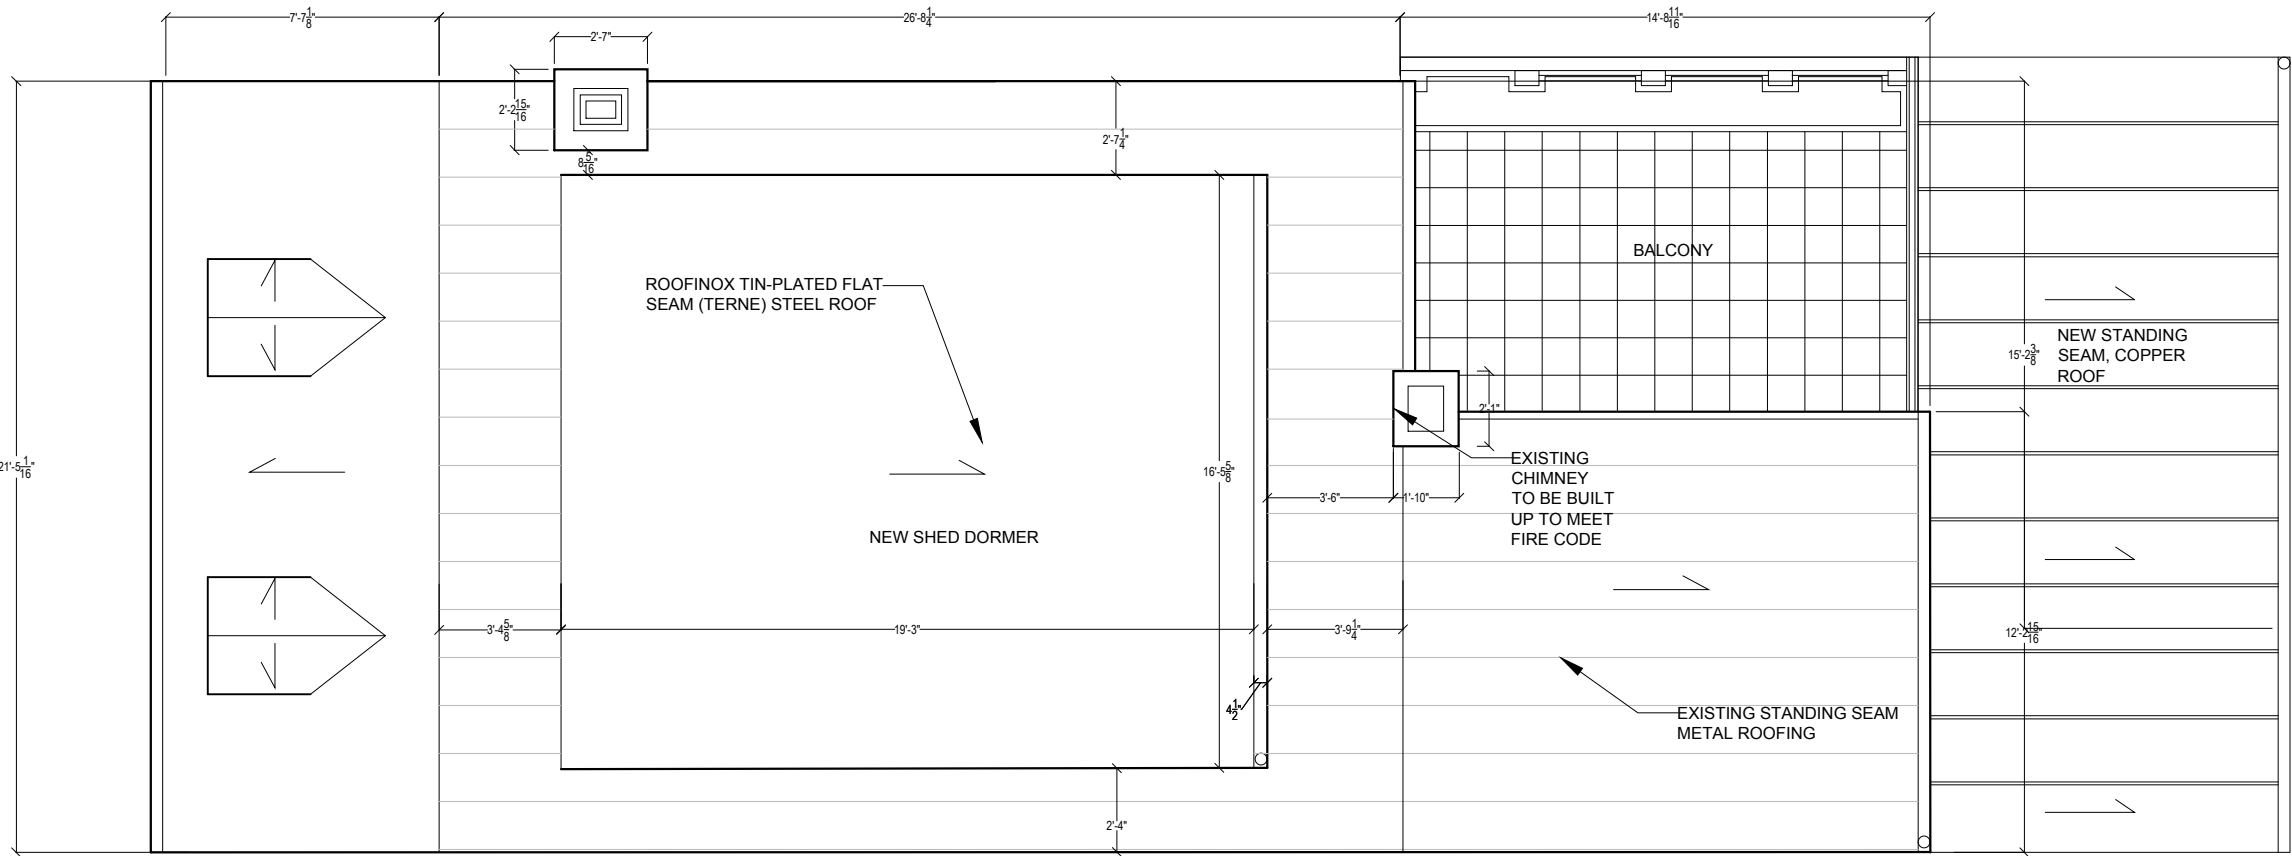


2 PROPOSED ROOF PLAN

CHRISTIAN ZAPATKA ARCHITECT, PLLC
1656 33rd STREET NW WASHINGTON DC 20007 202 333 2735

© DRAWING PROTECTED BY COPYRIGHT. THIS DRAWING
CANNOT BE DISTRIBUTED OR REPRODUCED WITHOUT WRITTEN
PERMISSION FROM CHRISTIAN ZAPATKA ARCHITECT, PLLC.

PROJECT:

 MONGAN RESIDENCE
3015 "P" STREET, N.W.
WASHINGTON D.C. 20007
SQ: 1269 LOT: 801



DRAWING TITLE:

EXISTING AND
PROPOSED ROOF
PLANS

SUBMISSION:


PERMIT

DATE: JANUARY 14, 2016


SCALE: 3/16" = 1'-0"



A007

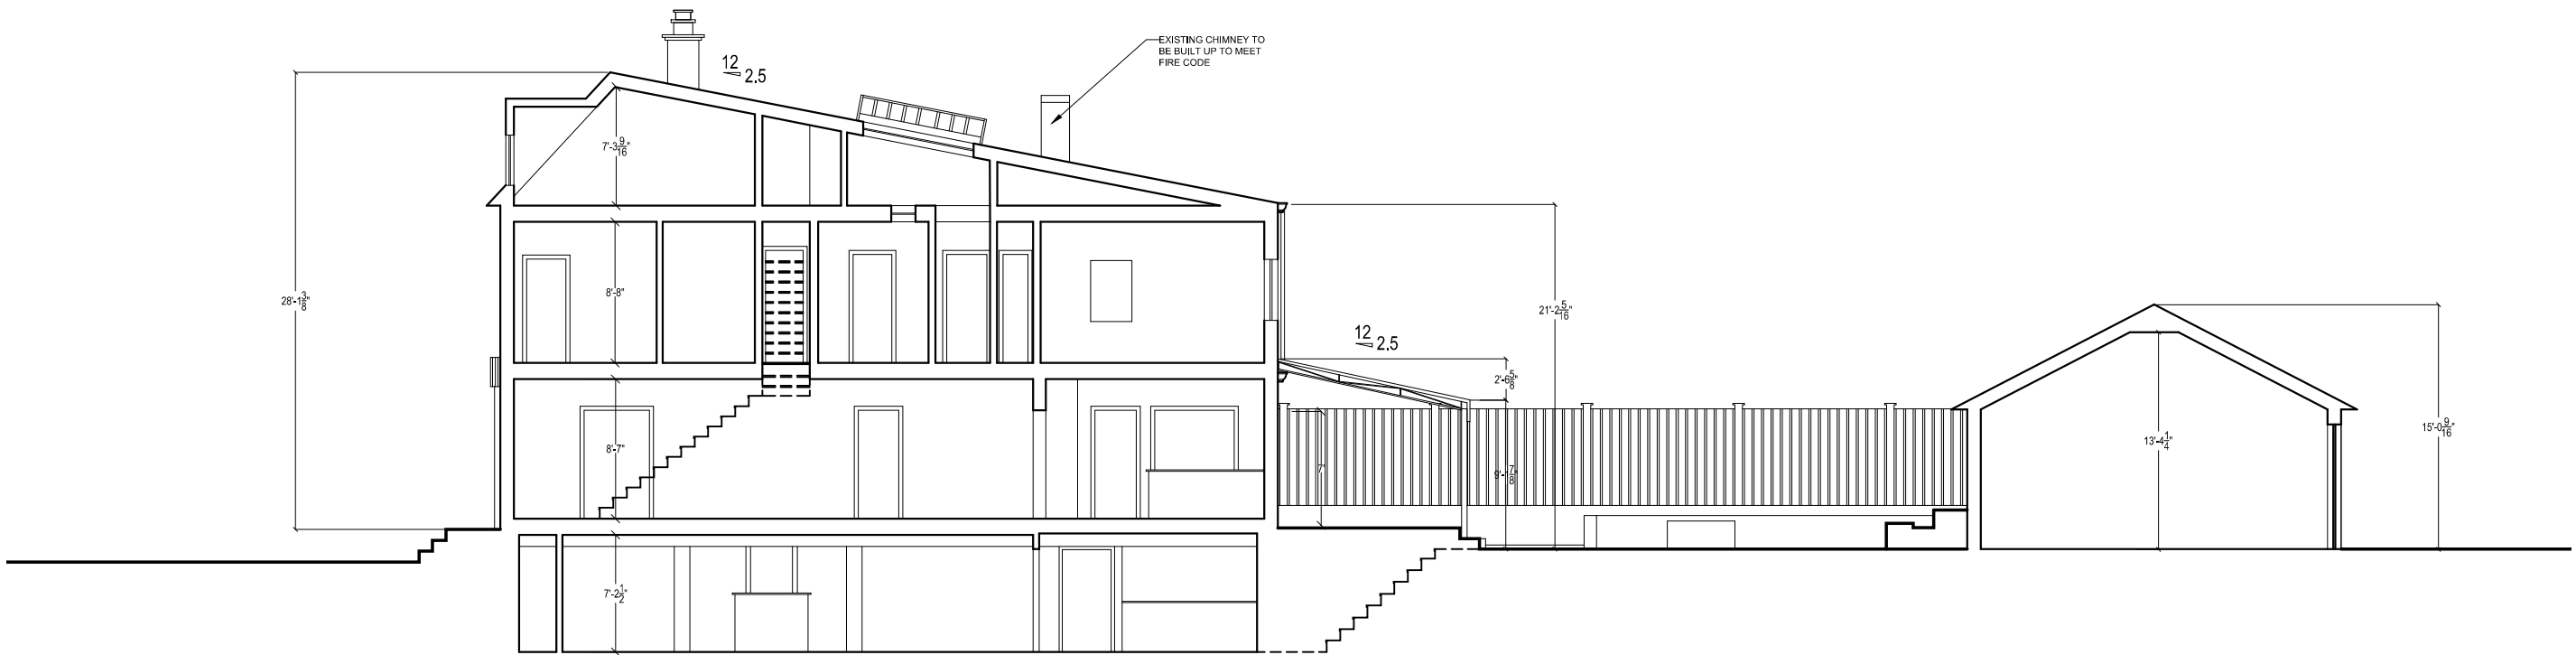

1 EXISTING SOUTH-NORTH SITE SECTION

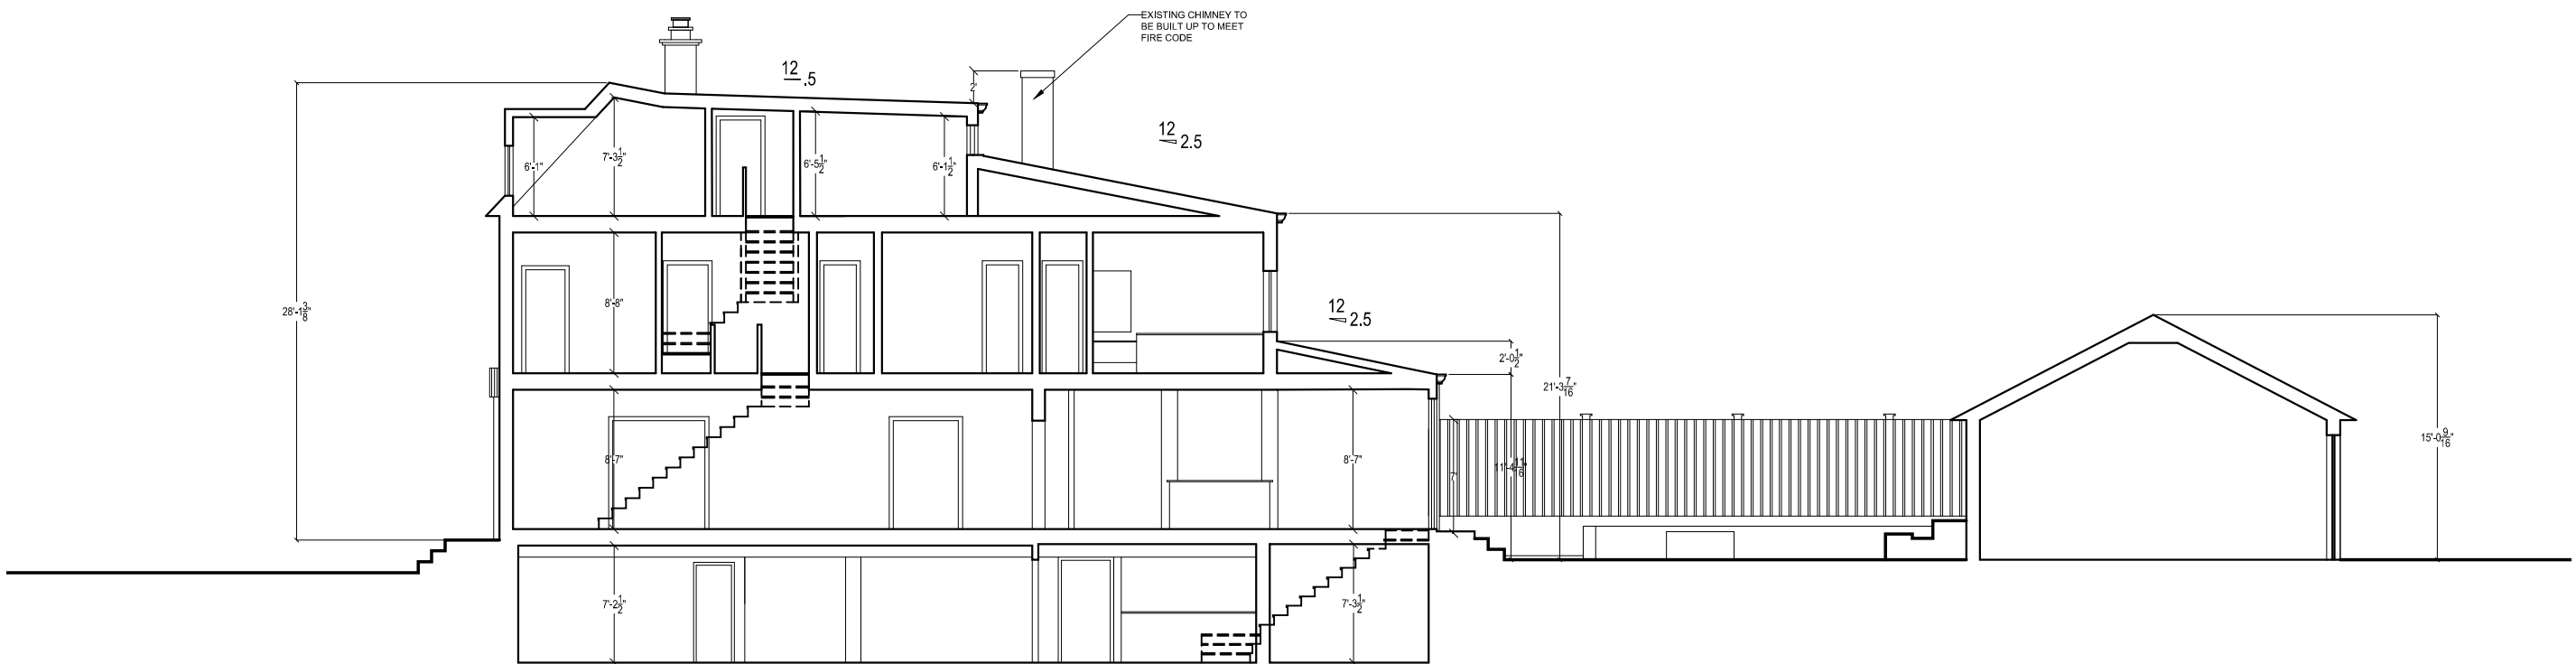

2 PROPOSED SOUTH-NORTH SITE SECTION

CHRISTIAN ZAPATKA ARCHITECT, PLLC
1656 33rd STREET NW WASHINGTON DC 20007 202 333 2735

© DRAWING PROTECTED BY COPYRIGHT. THIS DRAWING
CANNOT BE DISTRIBUTED OR REPRODUCED WITHOUT WRITTEN
PERMISSION FROM CHRISTIAN ZAPATKA ARCHITECT, PLLC.

PROJECT:

MONGAN RESIDENCE
3015 "P" STREET, N.W.
WASHINGTON D.C. 20007
SQ: 1269 LOT: 801

DRAWING TITLE:

EXISTING AND
PROPOSED
SOUTH-NORTH SITE
SECTIONS

SUBMISSION:


PERMIT

DATE: JANUARY 14, 2016


SCALE: 3/32" = 1'-0"

0 4' 8' 12'

A008

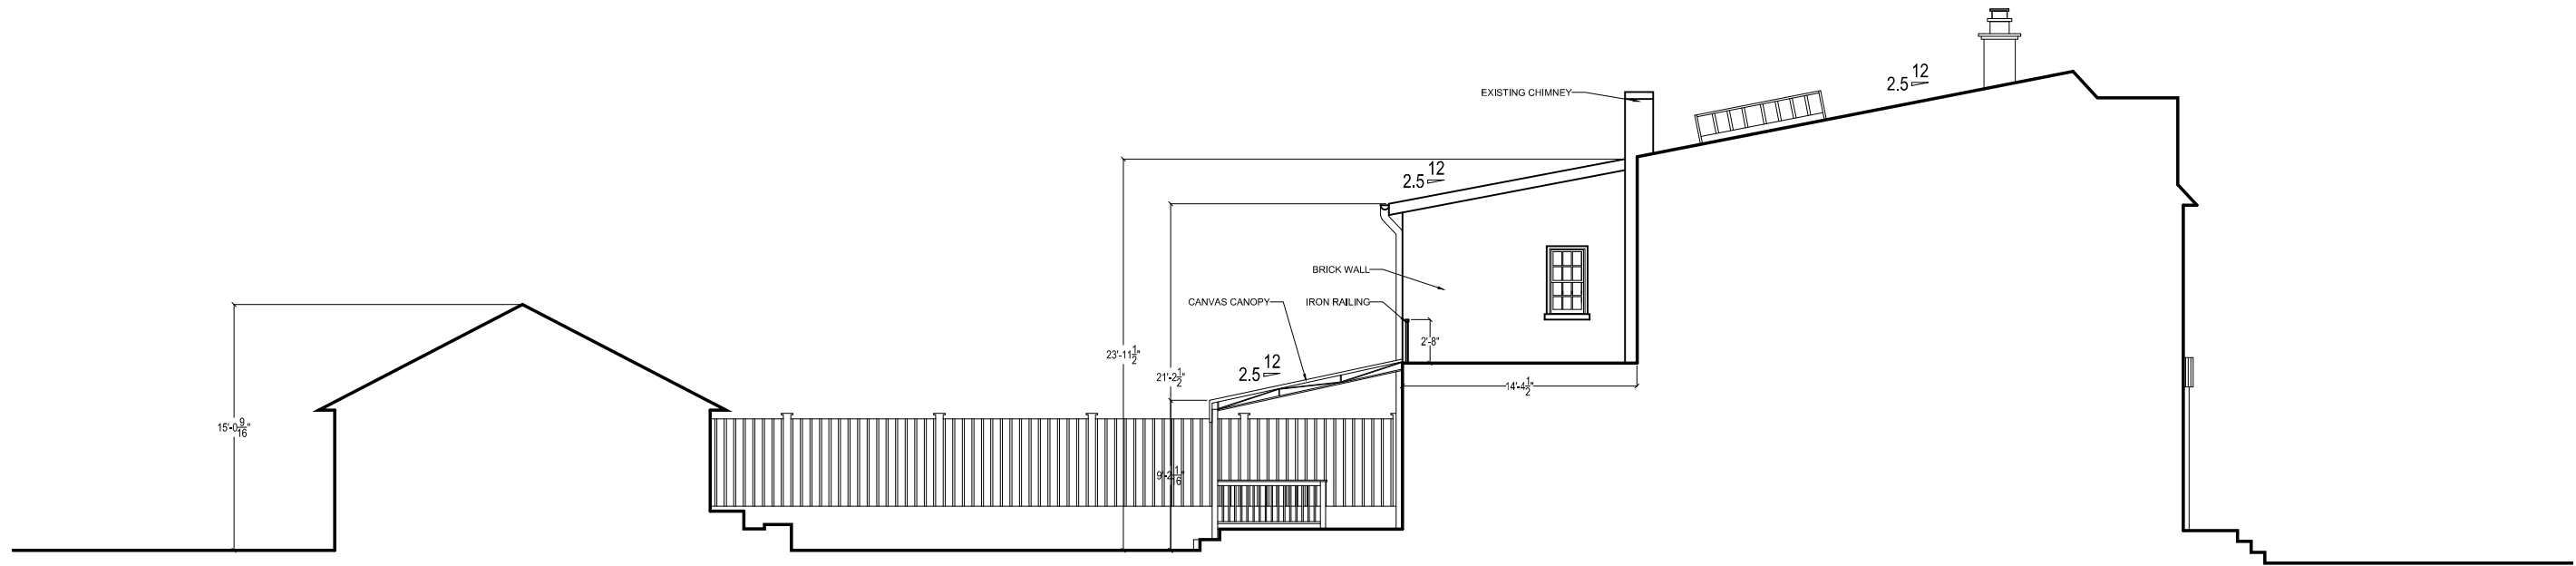

1 EXISTING NORTH- SOUTH SITE SECTION

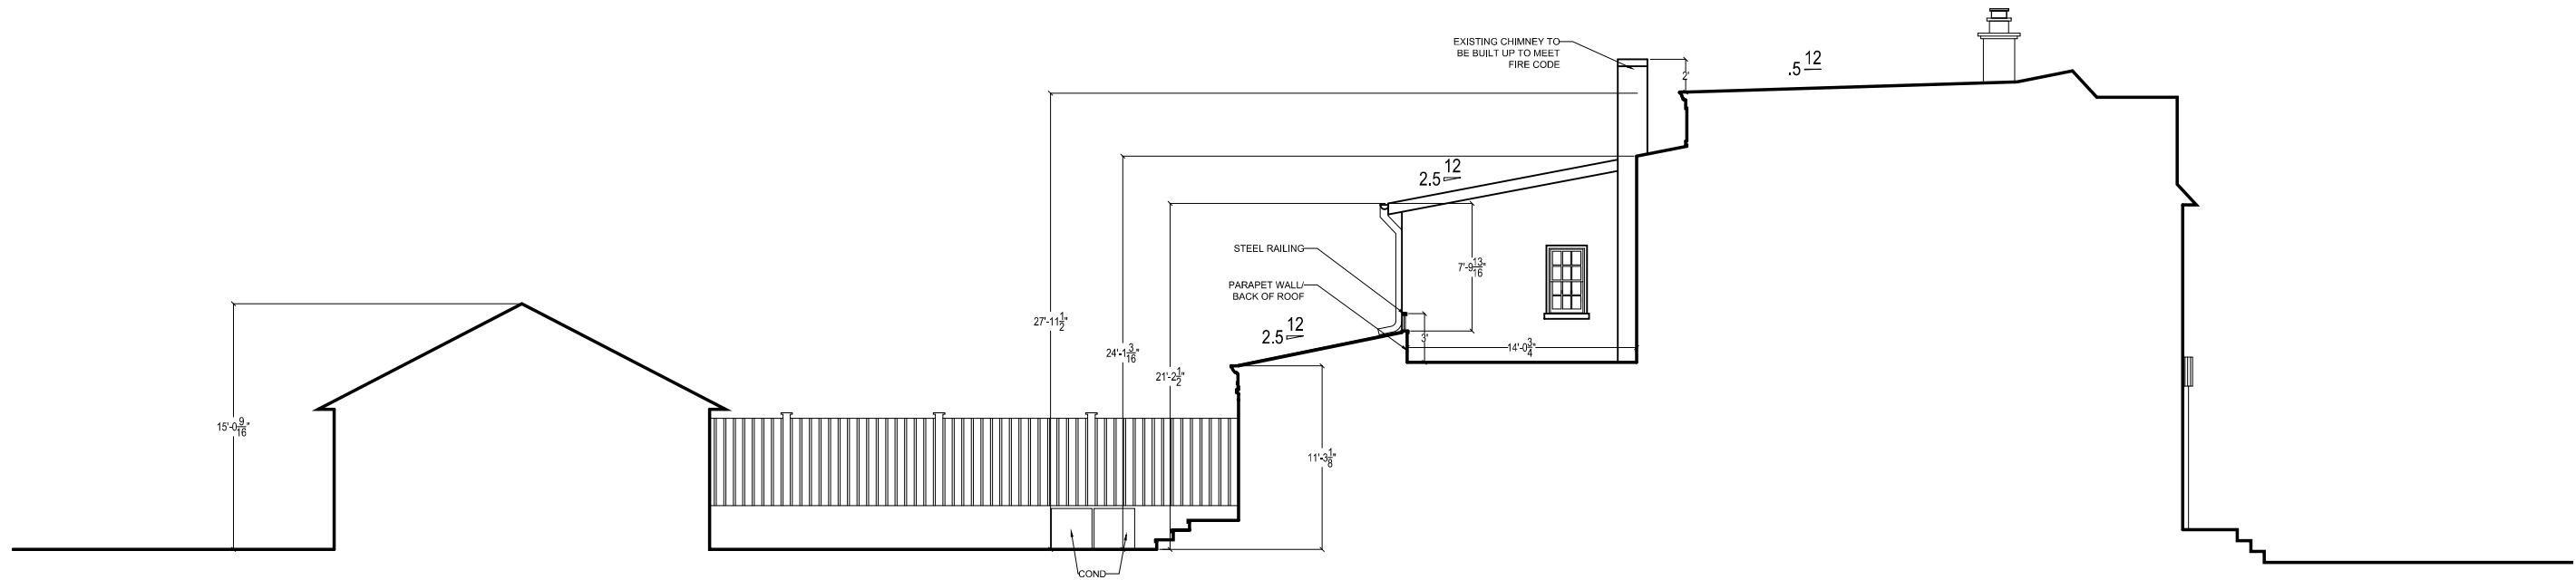

2 PROPOSED NORTH- SOUTH SITE SECTION

CHRISTIAN ZAPATKA ARCHITECT, PLLC
1666 33rd STREET NW WASHINGTON DC 20007 202 333 2735

© DRAWING PROTECTED BY COPYRIGHT. THIS DRAWING
CANNOT BE DISTRIBUTED OR REPRODUCED WITHOUT WRITTEN
PERMISSION FROM CHRISTIAN ZAPATKA ARCHITECT, PLLC.

PROJECT:

MONGAN RESIDENCE
3015 "P" STREET, N.W.
WASHINGTON D.C. 20007
SQ: 1269 LOT: 801

DRAWING TITLE:

EXISTING AND
PROPOSED NORTH-
SOUTH SITE
SECTIONS

SUBMISSION:



PERMIT

DATE: JANUARY 14, 2016

SCALE: 3/32" = 1'-0"



A009

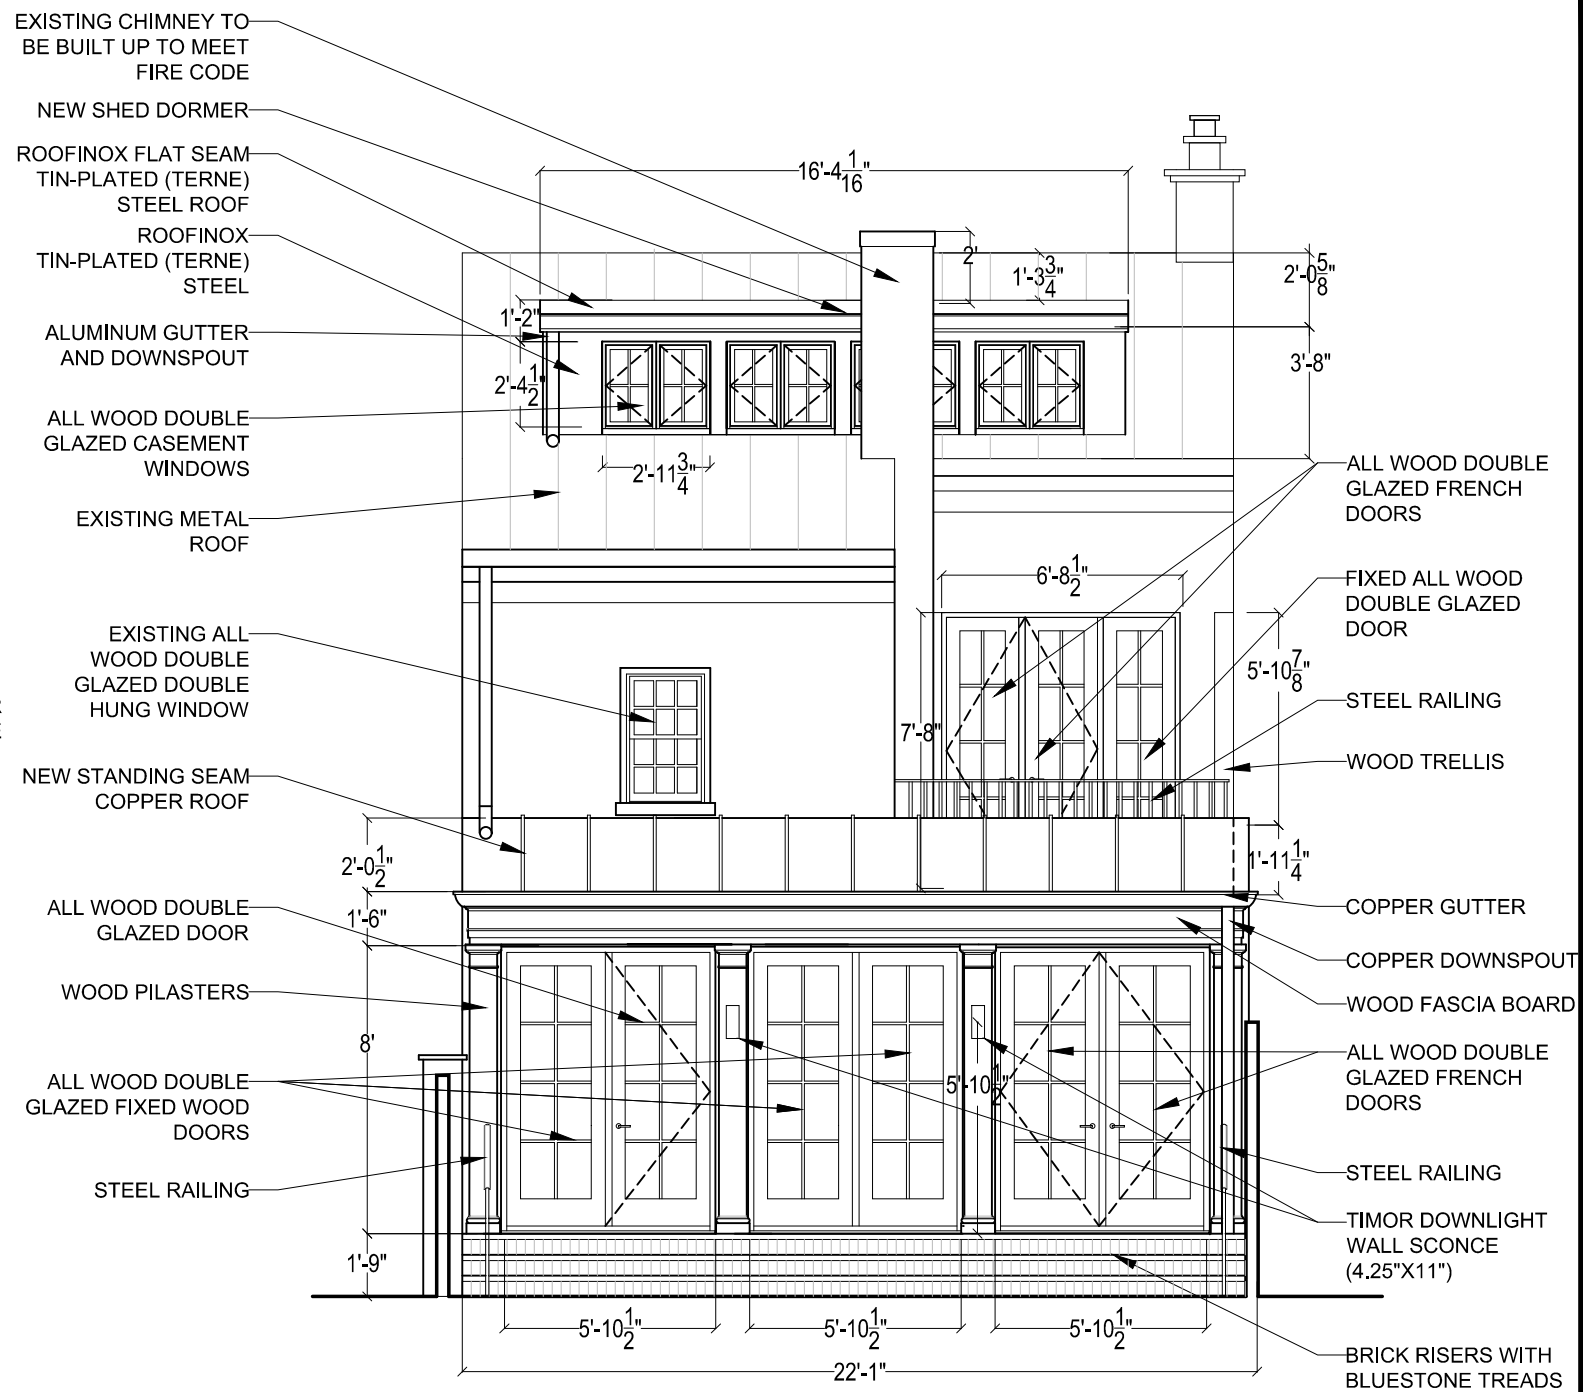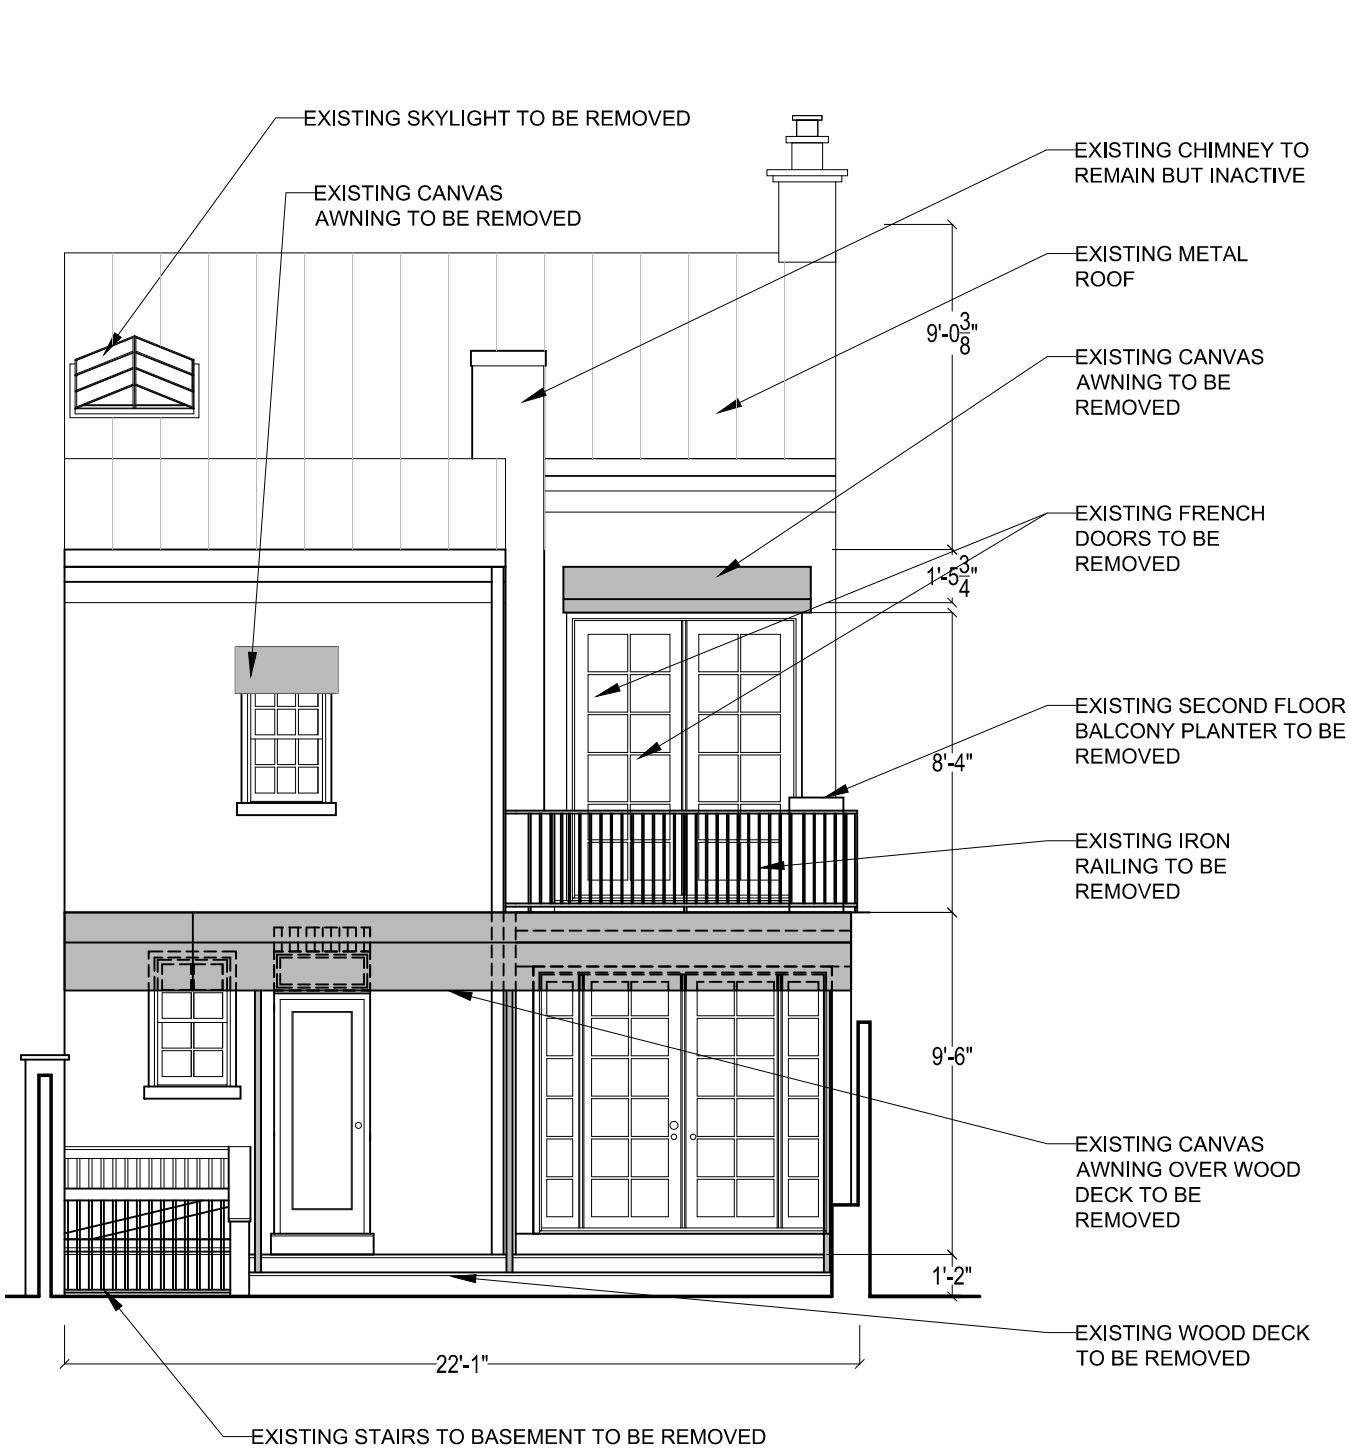

1 EXISTING NORTH (REAR) ELEVATION

2 PROPOSED NORTH (REAR) ELEVATION

CHRISTIAN ZAPATKA ARCHITECT, PLLC

1656 33rd STREET NW WASHINGTON DC 20007 202 333 2735

© DRAWING PROTECTED BY COPYRIGHT. THIS DRAWING
CANNOT BE DISTRIBUTED OR REPRODUCED WITHOUT WRITTEN
PERMISSION FROM CHRISTIAN ZAPATKA ARCHITECT, PLLC.

PROJECT:

MONGAN RESIDENCE
3015 "P" STREET, N.W.
WASHINGTON D.C. 20007
SQ: 1269 LOT: 801

DRAWING TITLE:

**EXISTING AND
PROPOSED NORTH
(REAR) ELEVATIONS**

SUBMISSION:



PERMIT

DATE: JANUARY 14, 2016

SCALE: 3/16" = 1'-0"

0 4' 8' 12'

A010

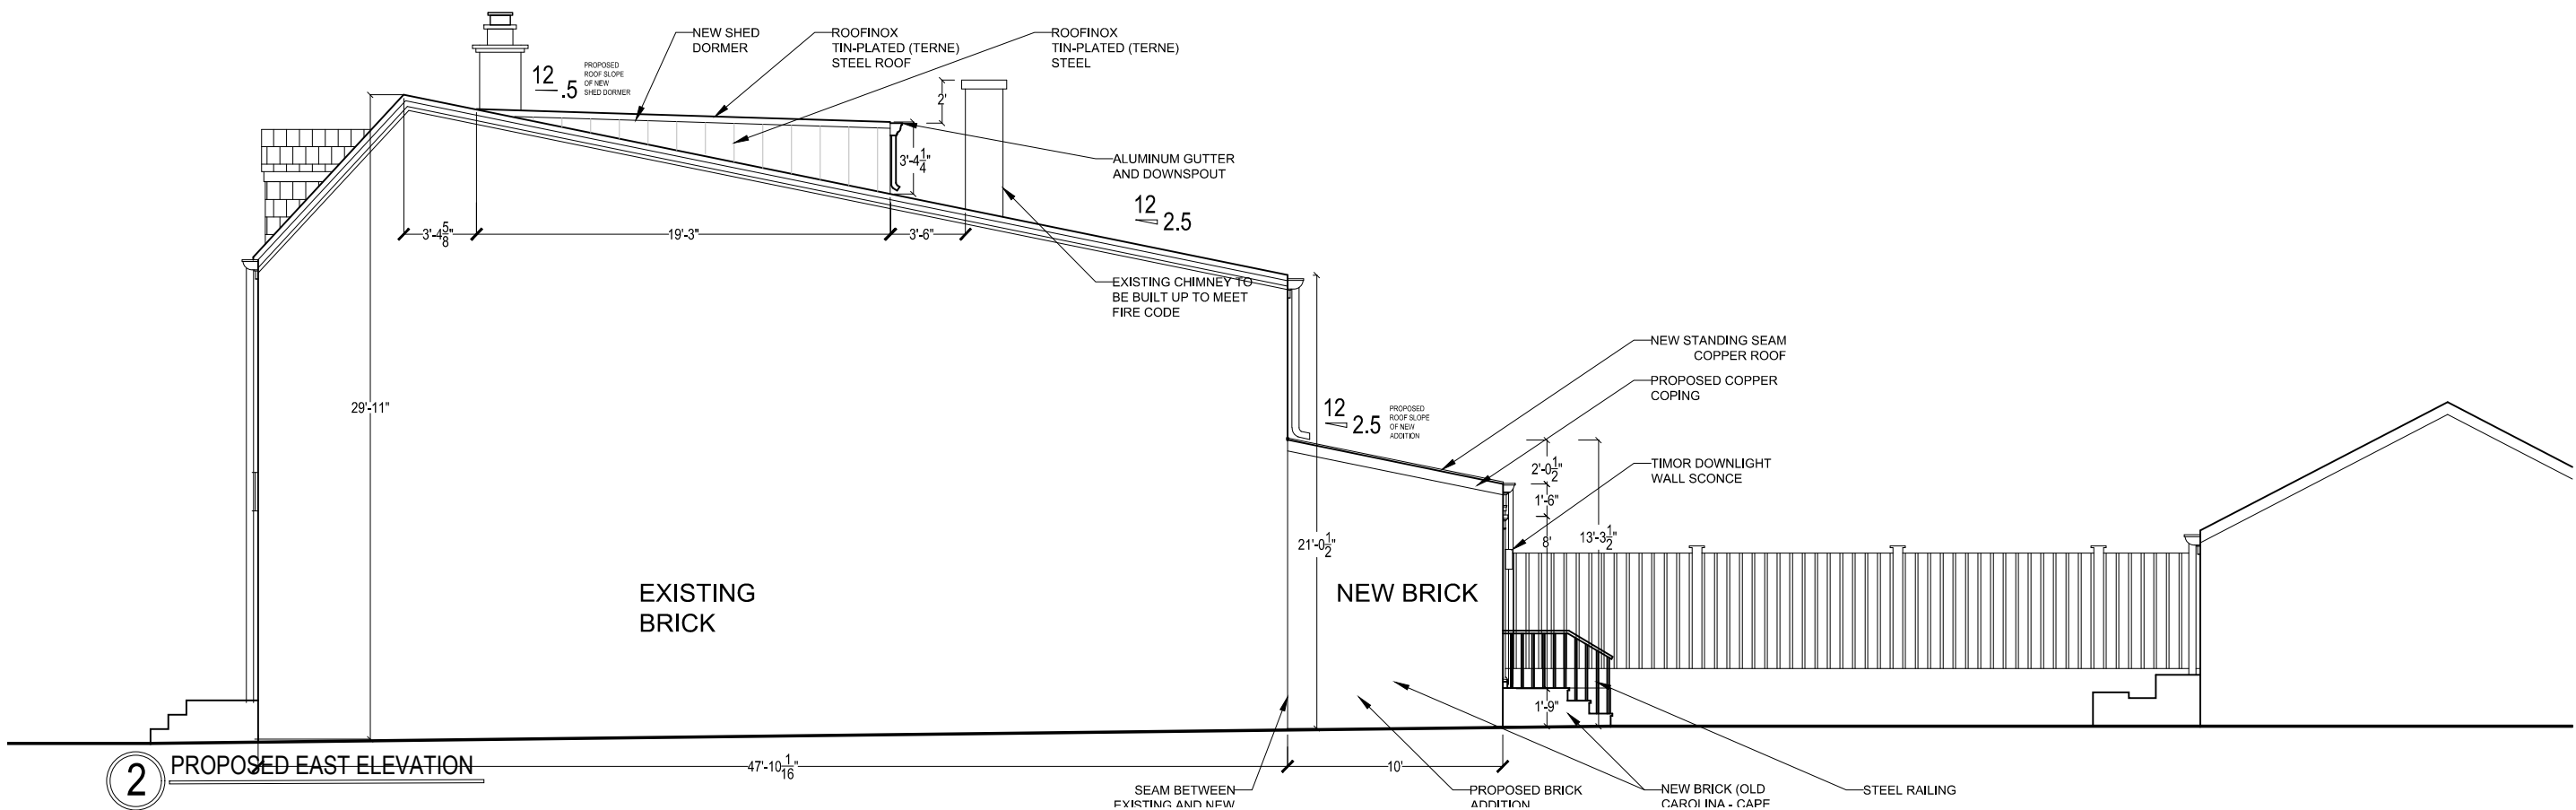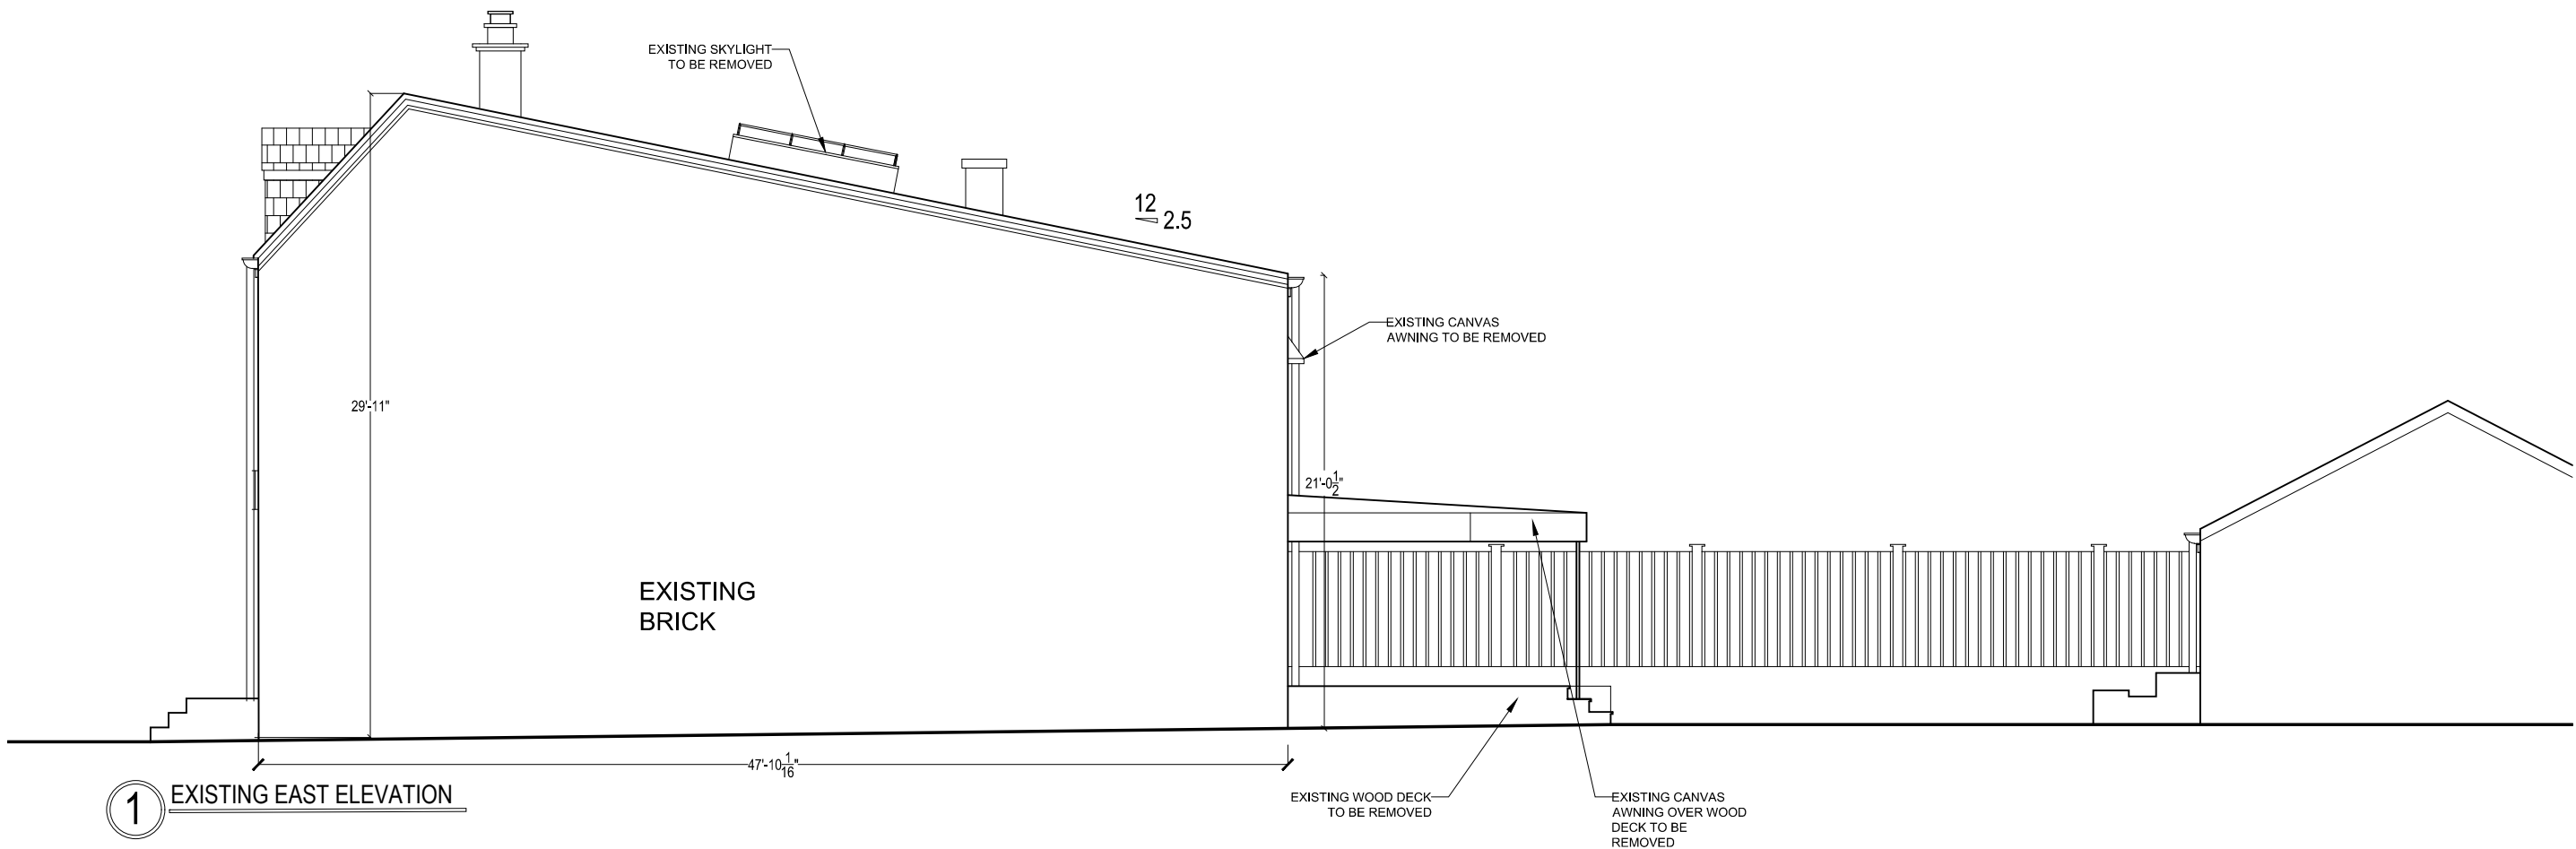

CHRISTIAN ZAPATKA ARCHITECT, PLLC
1656 33rd STREET NW WASHINGTON DC 20007 202 333 2735

© DRAWING PROTECTED BY COPYRIGHT. THIS DRAWING
CANNOT BE DISTRIBUTED OR REPRODUCED WITHOUT WRITTEN
PERMISSION FROM CHRISTIAN ZAPATKA ARCHITECT, PLLC.

PROJECT:

MONGAN RESIDENCE
3015 "P" STREET, N.W.
WASHINGTON D.C. 20007
SQ: 1269 LOT: 801

DRAWING TITLE:

EXISTING AND
PROPOSED EAST
ELEVATIONS

SUBMISSION:


PERMIT

DATE: JANUARY 14, 2016


SCALE: 1/8" = 1'-0"

0 2' 4' 8'

A011

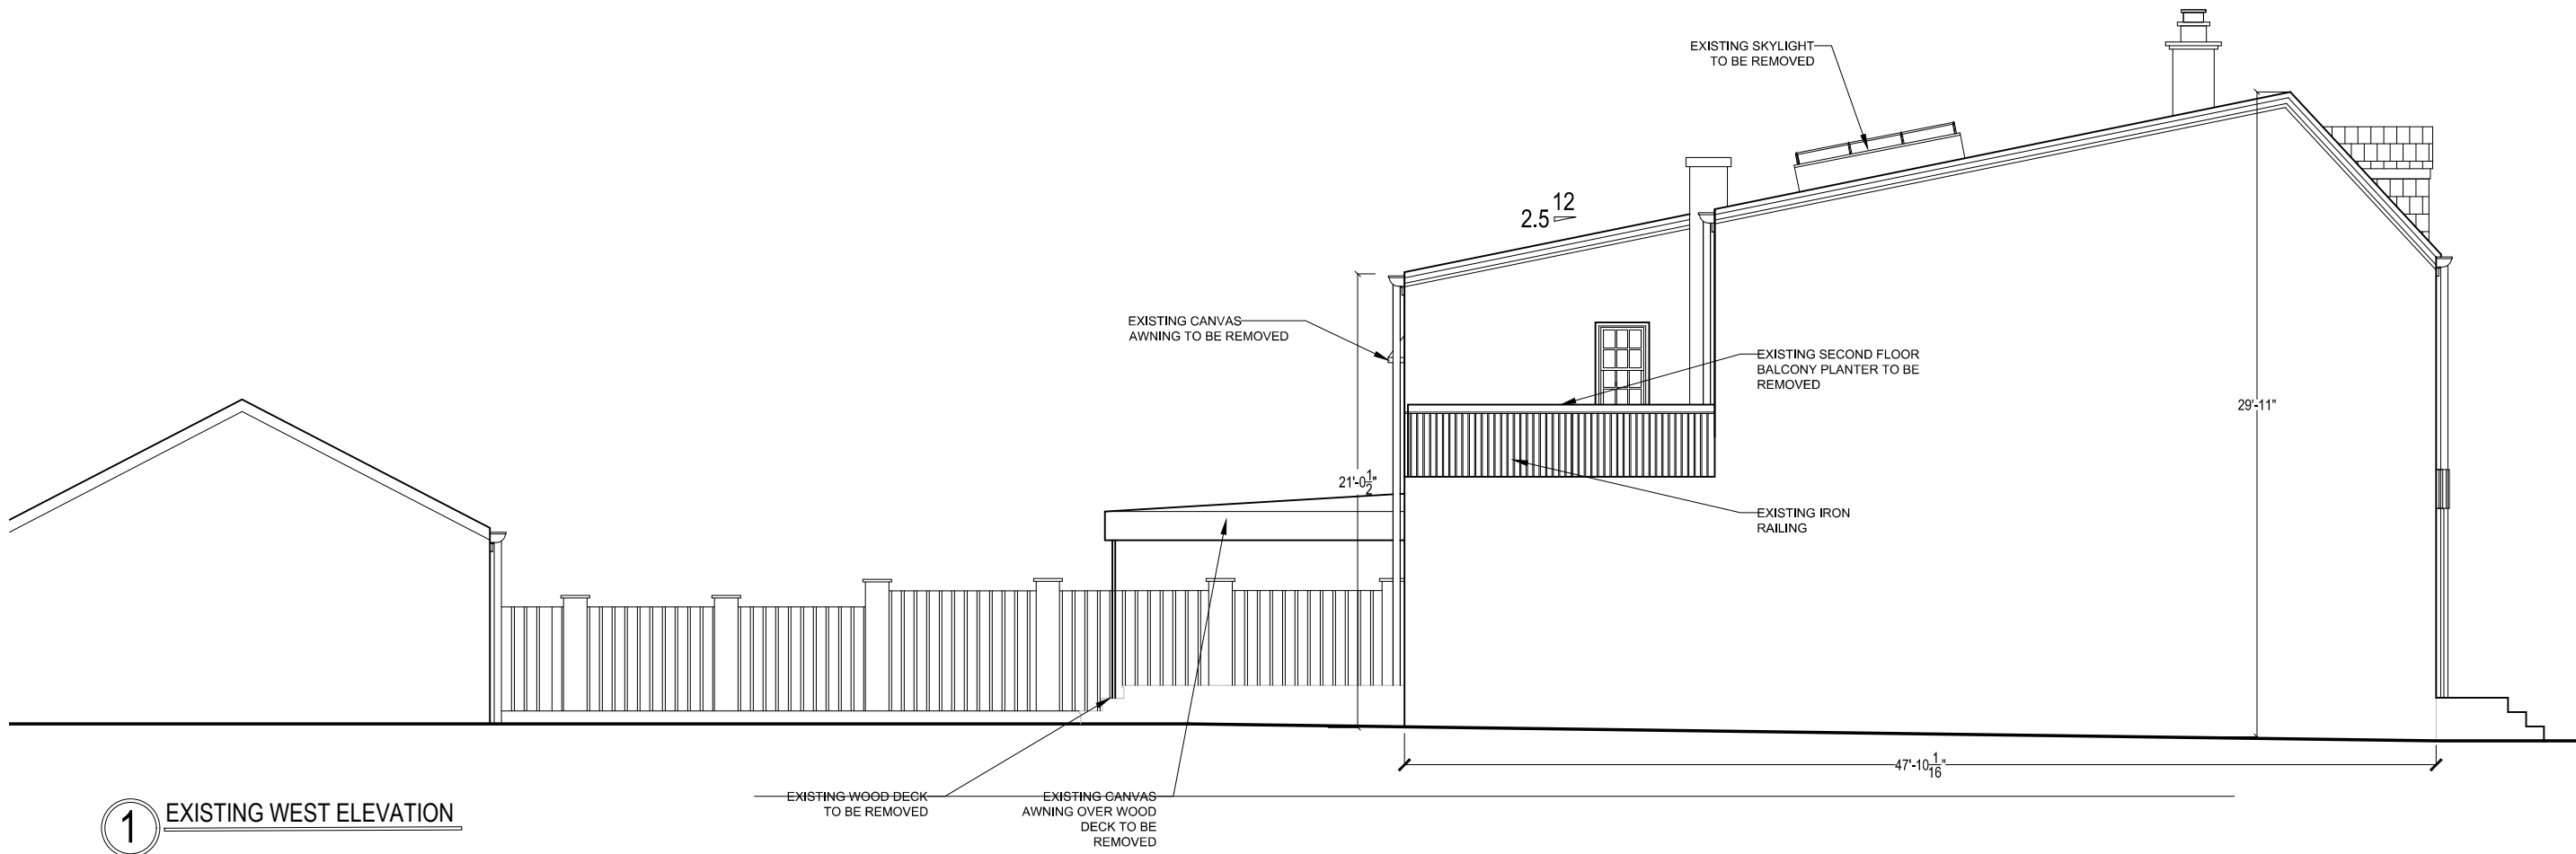

1 EXISTING WEST ELEVATION

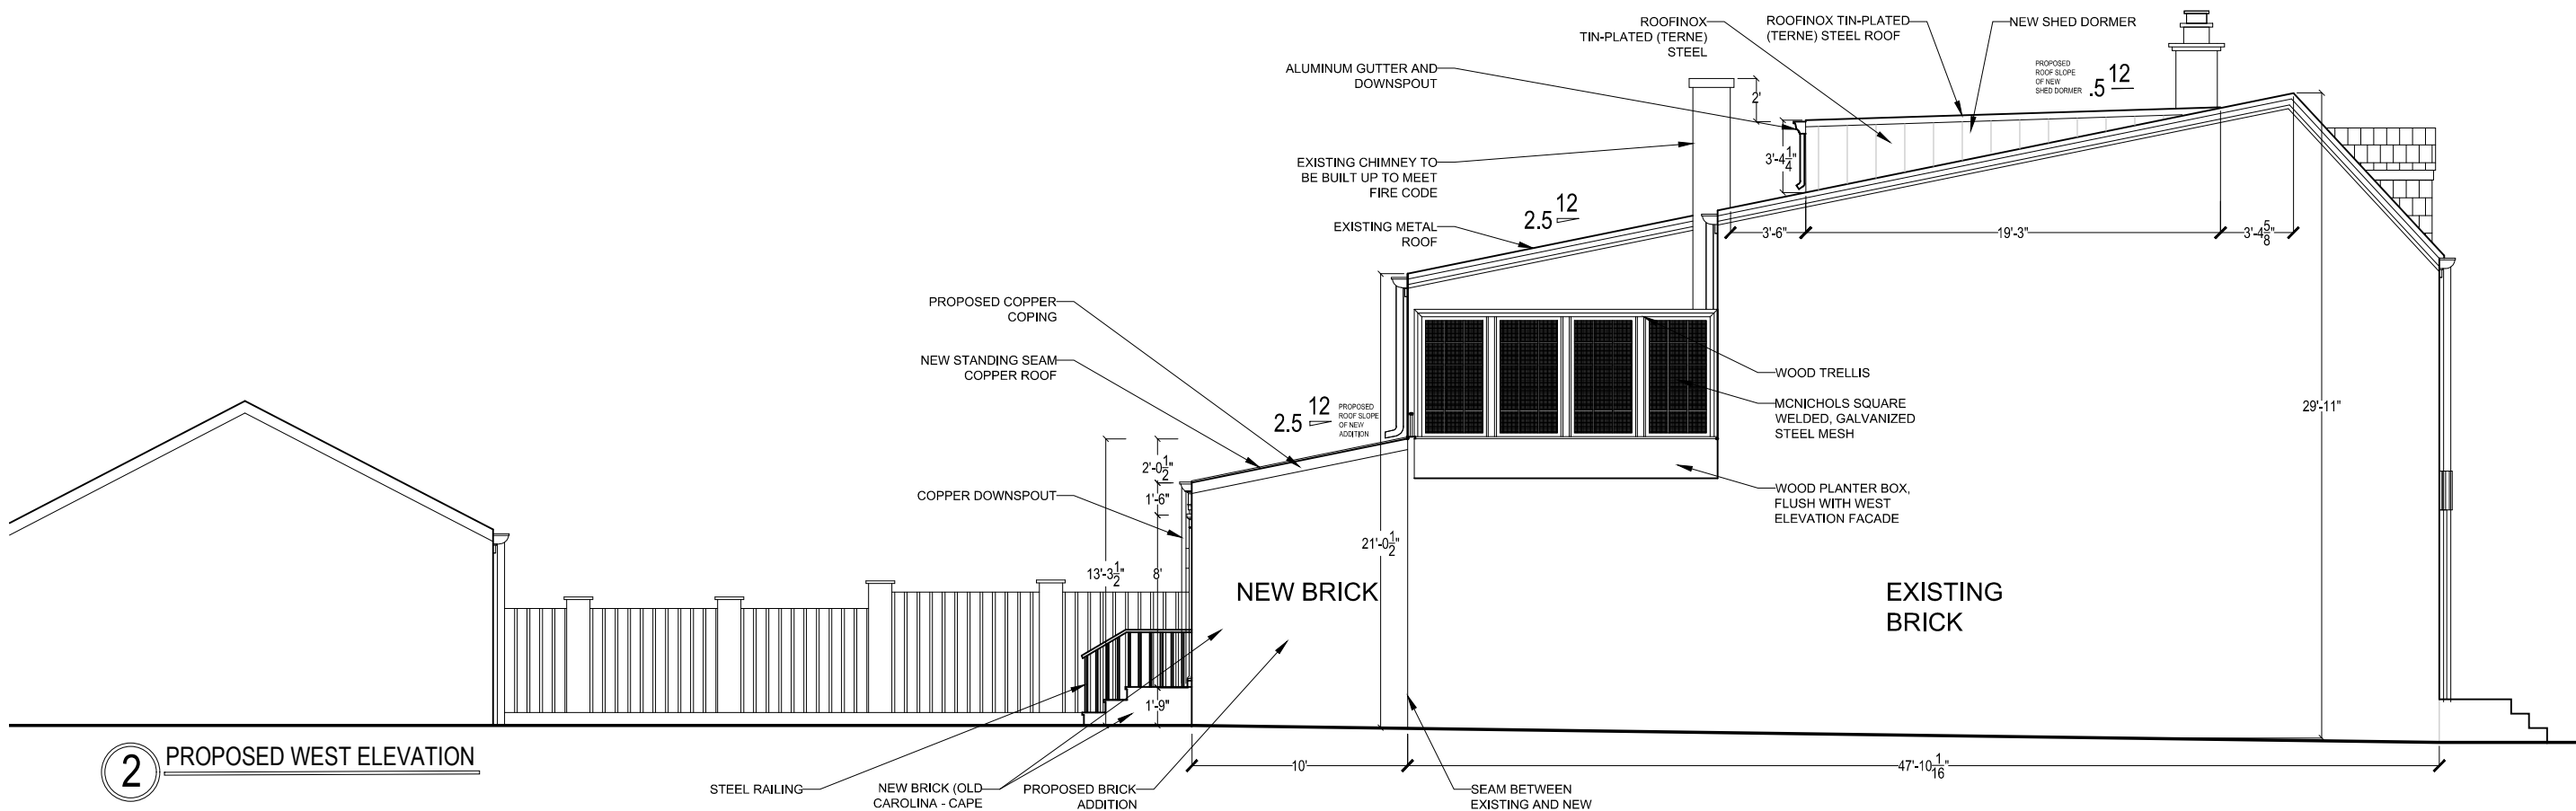

2 PROPOSED WEST ELEVATION

CHRISTIAN ZAPATKA ARCHITECT, PLLC
1656 33rd STREET NW WASHINGTON DC 20007 202 333 2735

© DRAWING PROTECTED BY COPYRIGHT. THIS DRAWING
CANNOT BE DISTRIBUTED OR REPRODUCED WITHOUT WRITTEN
PERMISSION FROM CHRISTIAN ZAPATKA ARCHITECT, PLLC.

PROJECT:

MONGAN RESIDENCE
3015 "P" STREET, N.W.
WASHINGTON D.C. 20007
SQ: 1269 LOT: 801

DRAWING TITLE:

 
EXISTING AND
PROPOSED WEST
ELEVATIONS

SUBMISSION:

PERMIT

DATE: JANUARY 14, 2016

SCALE: 1/8" = 1'-0"



A012