


EXISTING CONDITIONS GENERAL NOTES	
A.	ALL DIMENSIONS SHOWN ON THE EXISTING CONDITIONS PLAN TO BE VERIFIED BY THE GENERAL CONTRACTOR, IMMEDIATELY SUBMIT DISCREPANCIES TO THE ARCHITECT PRIOR TO BEGINNING CONSTRUCTION.
B.	SHOWN OR NOT, ANY ELEMENTS THAT CANNOT BE REMOVED FROM THE SPACE THAT INTERFERES WITH CONSTRUCTION AS SHOWN ON THESE PLANS ARE TO BE IDENTIFIED, DIMENSIONED, AND INDICATED ON THE PLAN AND SUBMITTED TO THE ARCHITECT, PRIOR TO BEGINNING CONSTRUCTION.
C.	GENERAL CONTRACTOR SHALL TAKE DIGITAL PHOTOS OF THE INTERIOR OF THE DEMISED SPACE IMMEDIATELY AFTER DEMOLITION, PRIOR TO THE START OF CONSTRUCTION, AND SEND TO THE ARCHITECT FOR REVIEW AND RECORD. ANY STRUCTURE, PIPING, CONDUIT, ETC. THAT MAY NEGATIVELY IMPACT THE PROPOSED CONSTRUCTION, OR BE UNSIGHTLY IF EXPOSED IS OF PARTICULAR INTEREST.
D.	GENERAL CONTRACTOR TO FIELD VERIFY THAT EXTERIOR ENVELOPE CONSTRUCTION IS INSTALLED WITH CONSTRUCTION, INCLUDING INSULATION, TO MEET LOCAL STANDARDS.
E.	ALL DIMENSIONS TO EXISTING CONSTRUCTION ARE TO THE EXPOSED FACE OF EXISTING SHEATHING OR FINISH, UNLESS NOTED OTHERWISE.
F.	NO EXPLORATORY DEMOLITION WAS PERFORMED TO CREATE THIS EXHIBIT. UNKNOWN OR UNFORESEEN ITEMS MIGHT EXIST WITHIN THE SPACE.
G.	GENERAL CONTRACTOR TO FIELD VERIFY LOCATION AND SIZE OF EXISTING UTILITY CONNECTIONS - NOTIFY ARCHITECT IF DIFFERENT FROM INFORMATION PROVIDED ELSEWHERE IN THE CONSTRUCTION DOCUMENTS

KEYNOTE LEGEND	
1	NOT USED
2	EXISTING CONCRETE COLUMN
3	EXISTING DEMISING WALL
4	EXISTING MANUAL FIRE ALARM PULL, HORN AND STROBE
5	EXISTING STOREFRONT - EXISTING SILL AT 0'-0" A.F.F. AND HEAD AT 10'-4" - FIELD VERIFY
6	EXISTING FIRE ALARM HORN AND STROBE
7	EXISTING MANUAL FIRE ALARM PULL
8	NOT USED
9	NOT USED
10	EXISTING STOREFRONT - EXISTING SILL AT 2'-0" A.F.F. AND HEAD AT 10'-4" - FIELD VERIFY
11	EXISTING WASTE STUB
12	EXISTING GAS PIPE
13	SANITARY SEWER LINES
14	FIRE SPRINKLER PIPE AND DRAIN LINE
15	EXISTING ELECTRIC SPACE HEATER
16	EXISTING ELECTRIC SPACE HEATER THERMOSTAT
17	EXISTING ELECTRICAL OUTLET

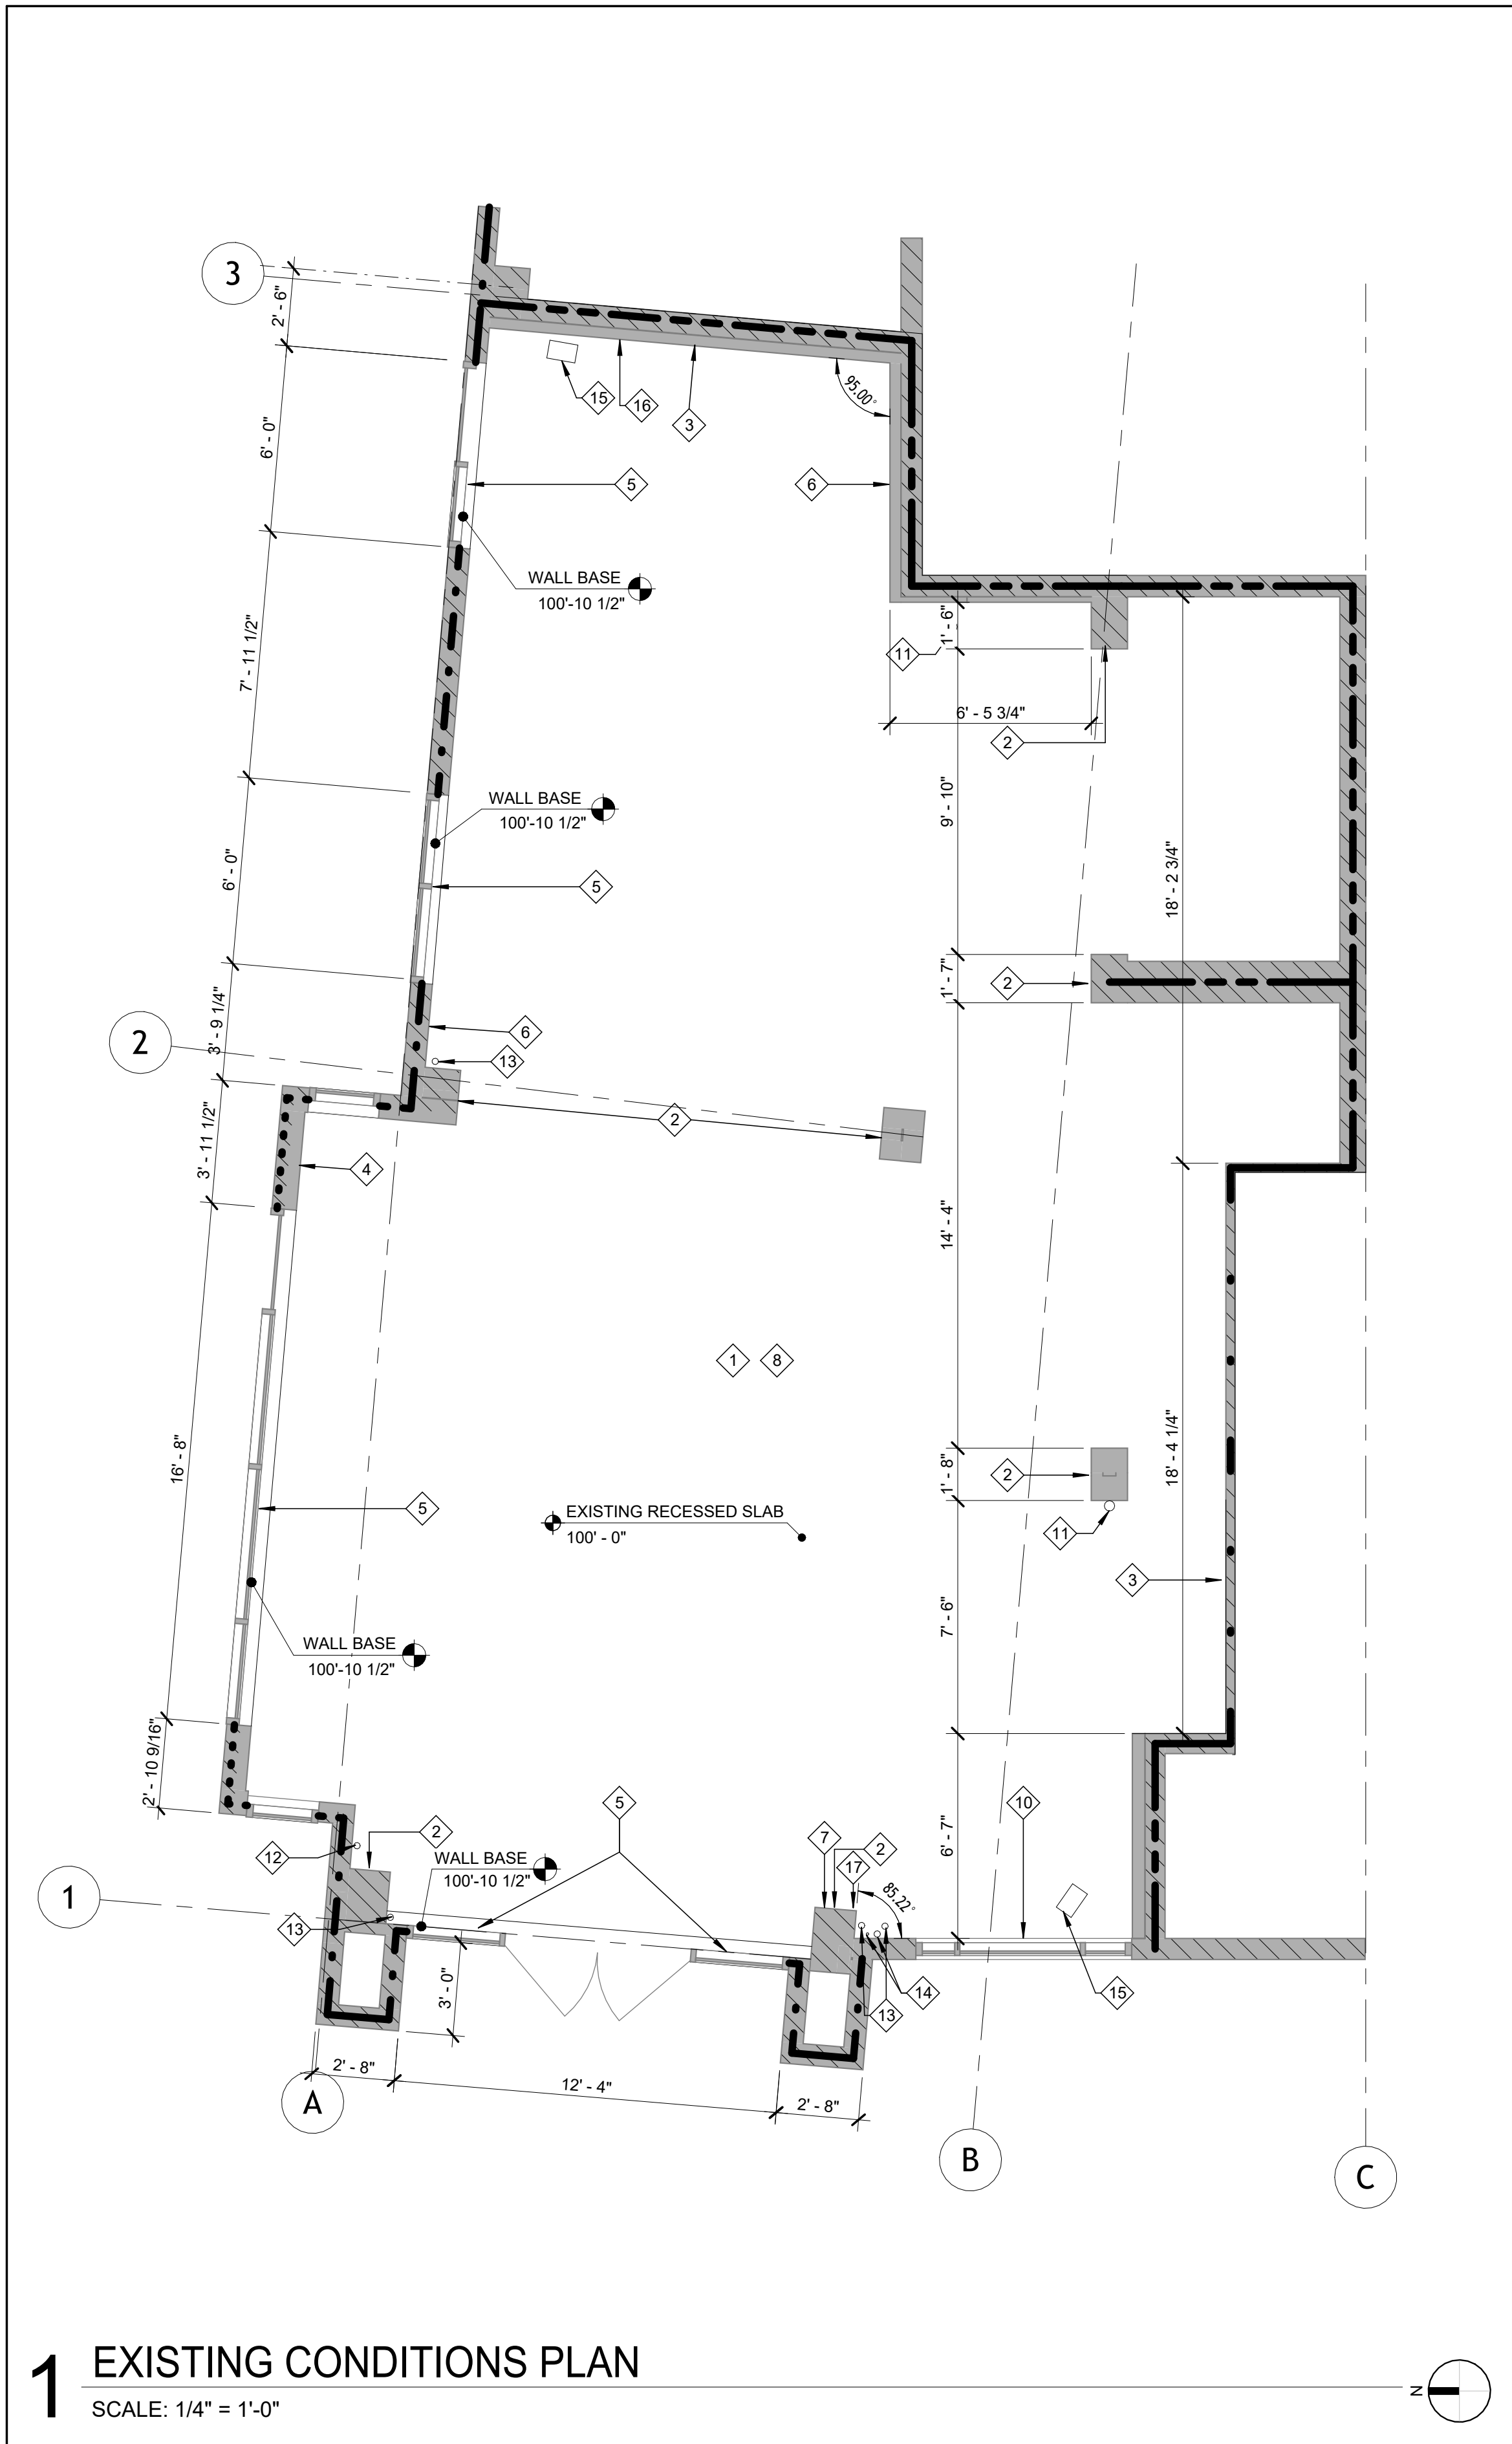

CONSULTANT



WILKUS
ARCHITECTS



WINGSTOP

2801 NORTH CENTRAL
EXPRESSWAY, SUITE 1600
DALLAS, TX 75204
TELEPHONE: (972) 686-6500
FAX: (972) 686-6502

THESE DRAWINGS, IDEAS, SPECIFICATIONS AND DESIGNS ARE EXCLUSIVE PROPERTY OF WINGSTOP RESTAURANTS, INC. NO PART OF THESE DRAWINGS MAY BE COPIED, REPRODUCED, OR OTHER STRUCTURES BUILT FROM SUCH WITHOUT THE WRITTEN CONSENT OF WINGSTOP RESTAURANTS, INC.

COPYRIGHT © 2025
WINGSTOP RESTAURANTS, INC.
ALL RIGHTS RESERVED

PROJECT INFORMATION

WINGSTOP
(GL#A216)

THE AUGUSTA ON GEORGIA
3831 GEORGIA AVENUE NW
WASHINGTON, D.C. 20009

SEAL

12360 REGISTERED
ARCHITECT

MATTHEW M. WILKUS
STATE OF WASHINGTON



June 10, 2026

MATTHEW M. WILKUS
LICENSE #12360
(EXPIRES 06/16/2025)

PROJECT NO. 2025-0430
DRAWN BY ANC
CHECKED BY JSS

ISSUE DATE
DESIGN INTENT REVIEW 2026/03/30
PERMIT SET 2026/06/10

REVISION DATE


NG_DELCO_2025.02

TITLE
EXISTING
CONDITIONS PLAN

SHEET NUMBER
A0.0

- SITE GENERAL NOTES**
- A. VERIFY ALL PAVED SURFACES ADJACENT TO BUILDING SLOPE AWAY FROM THE BUILDING TO PROVIDE POSITIVE DRAINAGE. NOTIFY CLIENT AND ARCHITECT IF EXISTING GRADE SLOPES TOWARDS THE EXISTING BUILDING FOOTPRINT.
- B. CONTRACTOR SHALL PROTECT ADJACENT LANDS AND STRUCTURES FROM DAMAGE DURING CONSTRUCTION. ANY OFF-SITE AREAS DISTURBED SHALL BE RETURNED TO A CONDITION EQUAL TO OR BETTER THAN THE EXISTING CONDITION.
- C. NECESSARY PERMITS FOR SITE WORK AND CONSTRUCTION SHALL BE OBTAINED BY THE GENERAL CONTRACTOR PRIOR TO BEGINNING OF WORK.
- D. NECESSARY BARRICADES, SUFFICIENT LIGHTING, SIGNS AND OTHER TRAFFIC CONTROL METHODS MAY BE NECESSARY FOR THE PROTECTION AND SAFETY OF THE PUBLIC SHALL BE PROVIDED AND MAINTAINED THROUGHOUT THE LIFE OF THE CONSTRUCTION.
- E. GENERAL CONTRACTOR SHALL COORDINATE UTILITIES, ALL NEW LOCATIONS AND RELOCATIONS WITH THE LOCAL UTILITY COMPANIES.
- F. ANY UTILITY INFORMATION IS FOR REFERENCE PURPOSES ONLY. THE ARCHITECT ASSUMES NO RESPONSIBILITY FOR THE ACCURACY OF THE LOCATIONS SHOWN. IT SHALL BE THE CONTRACTORS RESPONSIBILITY TO VERIFY AND LOCATE UTILITIES.
- G. COORDINATE WITH THE LOCAL AUTHORITY HAVING JURISDICTION PRIOR TO ANY CONSTRUCTION IN THE PUBLIC RIGHT OF WAY.
- H. NO DEMOLITION MATERIALS SHALL BE DISPOSED ON ON-SITE. ALL DEBRIS SHALL BE HAULED OFF-SITE TO A RECYCLING AREA APPROVED BY THE LOCAL AUTHORITY HAVING JURISDICTION FOR THE HANDLING OF DEMOLITION DEBRIS.
- I. EXTERIOR LANDINGS, EXISTING AND NEW, TO BE FLUSH WITH INTERIOR FINISHED FLOOR AND SLOPE AWAY FROM THE FACE OF THE BUILDING AS REQUIRED BY CODE TO PROVIDE POSITIVE DRAINAGE.
- J. ANY SITE WORK AND/OR LANDSCAPE DESIGN IS BIDDER-DESIGNED AND IS NOT THE RESPONSIBILITY OF THE CLIENT.
- K. GENERAL CONTRACTOR IS RESPONSIBLE TO COORDINATE THE LOCATION OF THE EXTERIOR GREASE INTERCEPTOR AND FIELD VERIFY EXISTING SITE CONDITIONS THAT COULD IMPACT THE LOCATION DURING THE BIDDING PHASE OF THE PROJECT AND ASSIGN THE APPLICABLE COSTS. THE LOCATION SHALL NOT INTERFERE WITH ANY EXISTING SETBACKS, EASEMENTS, UNDERGROUND UTILITIES OR OTHER SITE FEATURE.
- L. THE CONSTRUCTION SHALL NOT RESTRICT A FIVE-FOOT CLEAR AND UNOBSTRUCTED ACCESS TO ANY WATER OR POWER DISTRIBUTION FACILITIES (POWER POLES, PULL BOXES, TRANSFORMERS, VAULTS, PUMPS, VALVES, METERS, ETC.) OR TO THE LOCATION OF THE CONNECTION. THE CONSTRUCTION SHALL NOT BE WITHIN TEN-FEET OF ANY POWER LINES, WHETHER OR NOT THE LINES ARE LOCATED ON THE PROPERTY.

- KEYNOTE LEGEND**
- 1 WINGSTOP TENANT LEASE AREA
2 EXISTING ACCESSIBLE PARKING BY LANDLORD TO REMAIN, TYPICAL
3 EXISTING TRASH ENCLOSURE TO REMAIN - PROTECT
4 EXISTING BIKE STORAGE

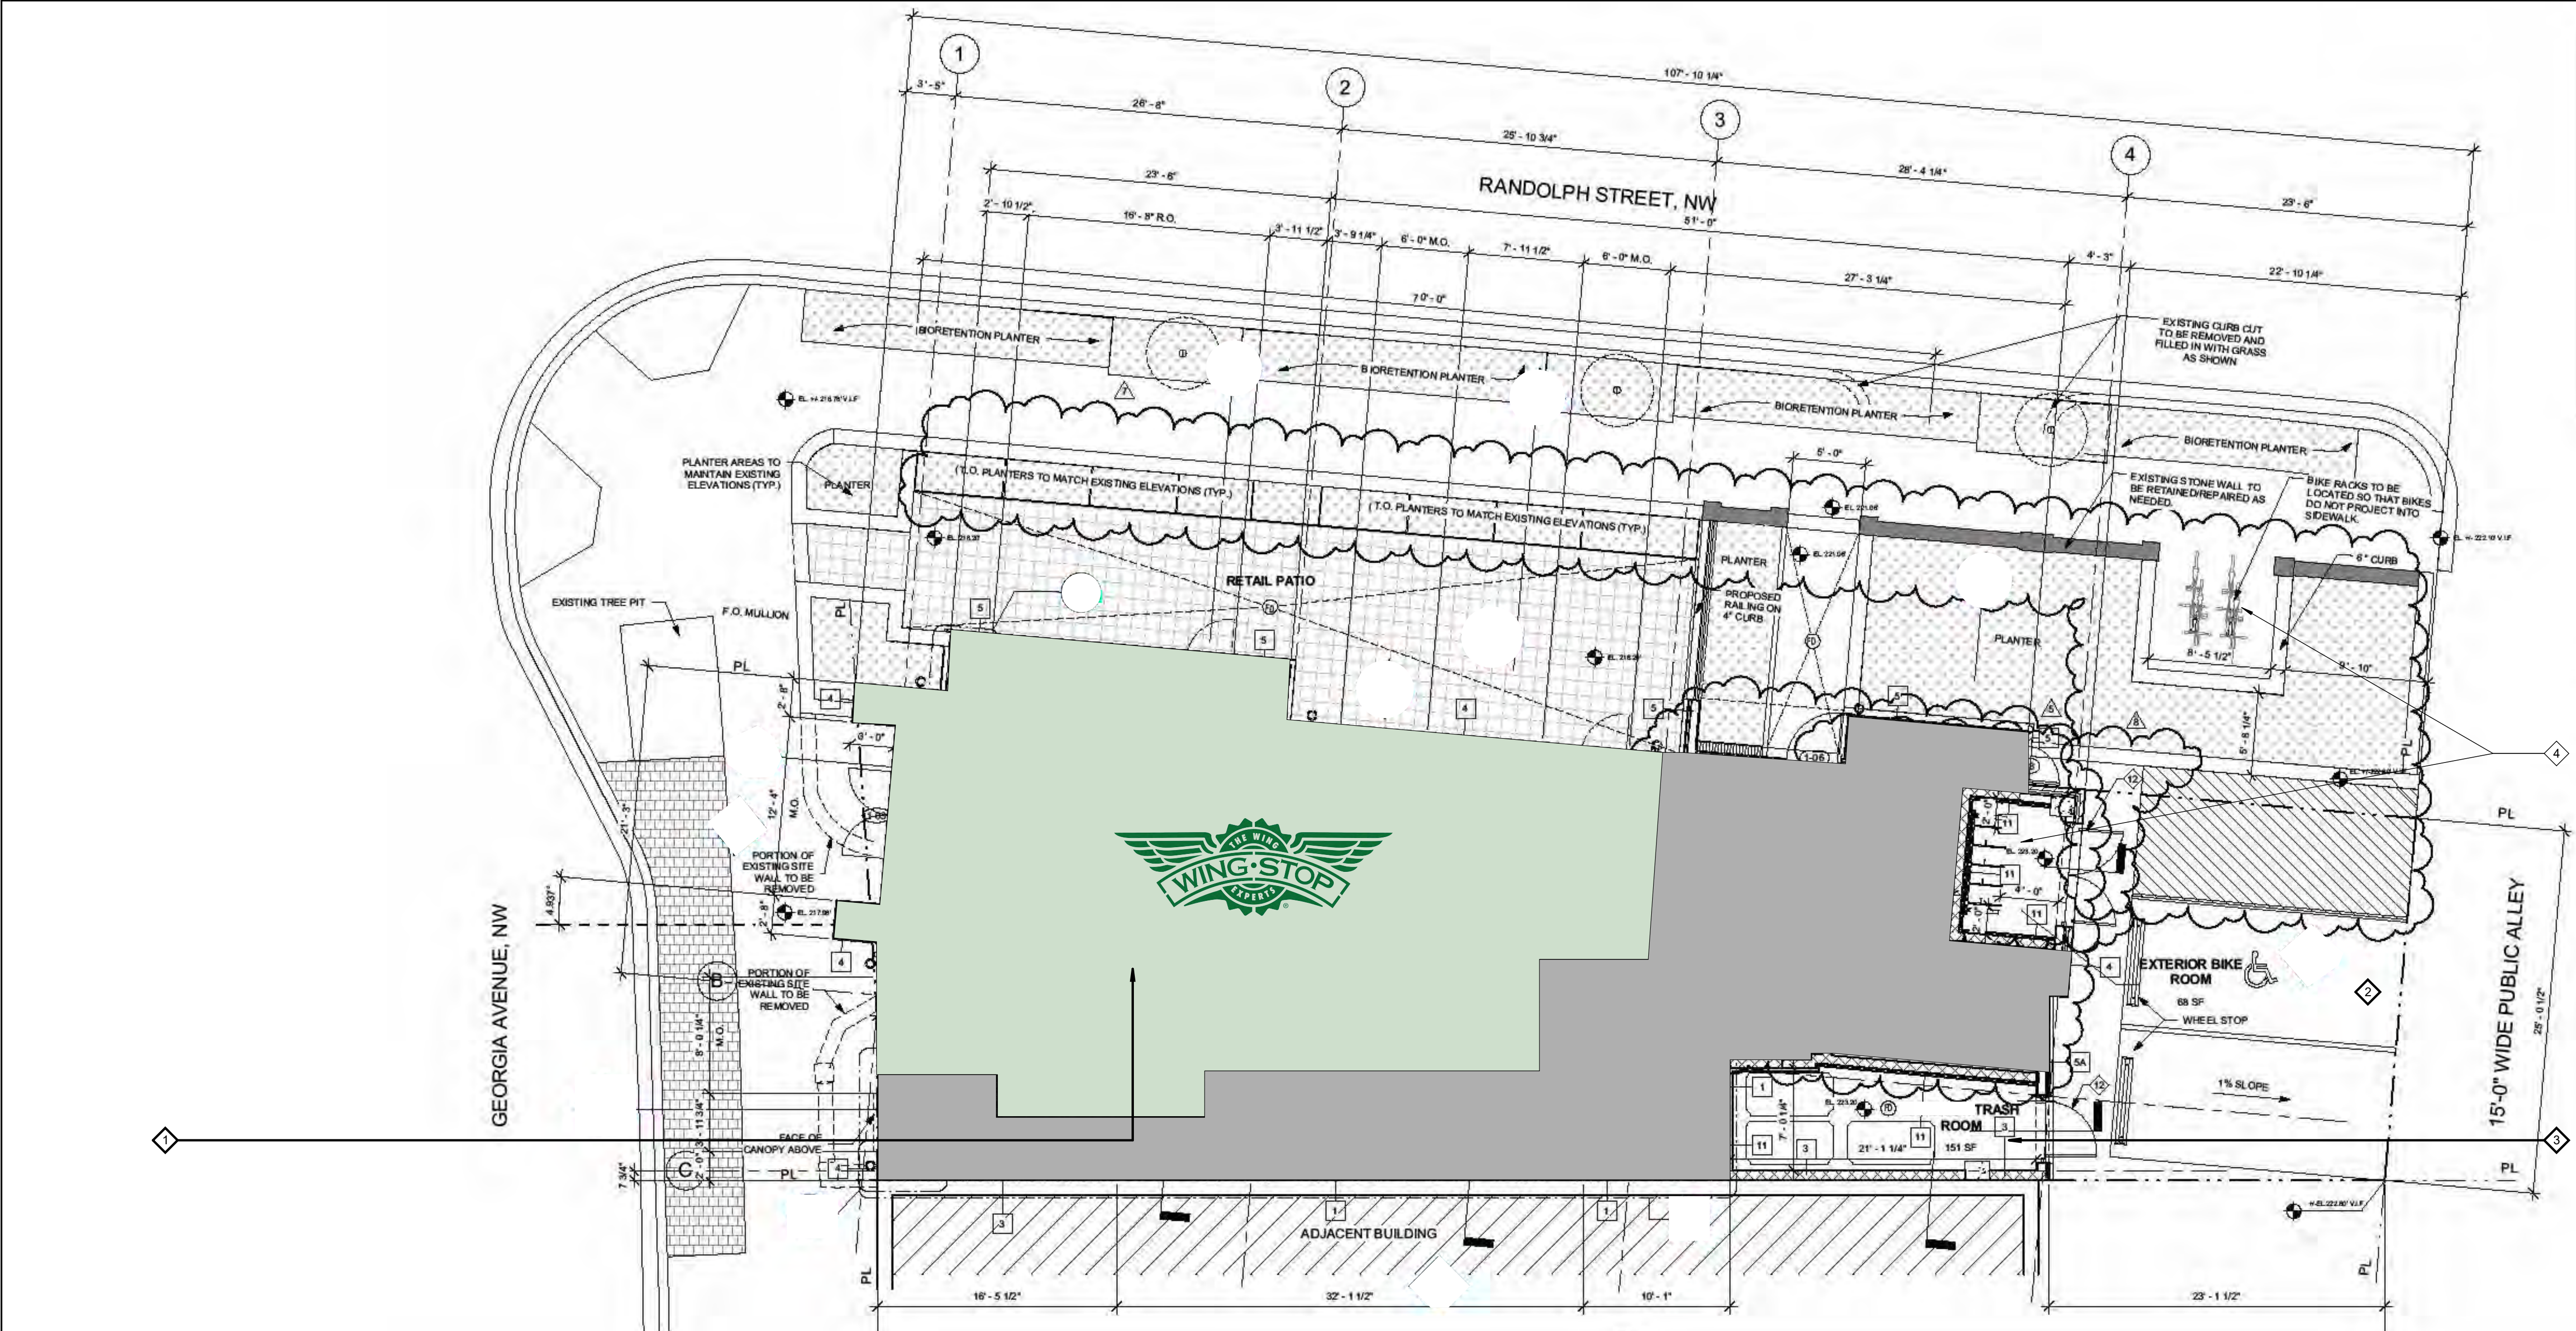

1 SITE PLAN
SCALE: 1" = 50'-0"

CONSULTANT

WILKUS ARCHITECTS

WINGSTOP

2801 NORTH CENTRAL EXPRESSWAY, SUITE 1600
DALLAS, TX 75204
TELEPHONE: (972) 686-6500
FAX: (972) 686-6502

THESE DRAWINGS, IDEAS, SPECIFICATIONS AND DESIGNS ARE EXCLUSIVE PROPERTY OF WINGSTOP RESTAURANTS, INC. NO PART OF THESE DRAWINGS MAY BE COPIED, REPRODUCED, OR OTHER STRUCTURES BUILT FROM SUCH WITHOUT THE WRITTEN CONSENT OF WINGSTOP RESTAURANTS, INC.

COPYRIGHT © 2025 WINGSTOP RESTAURANTS, INC. ALL RIGHTS RESERVED.

PROJECT INFORMATION

WINGSTOP (GL#A216)

THE AUGUSTA ON GEORGIA
3831 GEORGIA AVENUE NW
WASHINGTON, D.C. 20009


SEAL

12360 REGISTERED ARCHITECT
MATTHEW M. WILKUS
STATE OF WASHINGTON


June 10, 2026
MATTHEW M. WILKUS
LICENSE #12360
(EXPIRES 06/16/2026)

PROJECT NO.	2025-0430
DRAWN BY	ANC
CHECKED BY	JSS
ISSUE	DATE
DESIGN INTENT REVIEW	2026/03/30
PERMIT SET	2026/06/10
REVISION	DATE
NG_DELCO_2025.02	
TITLE	SITE PLAN
SHEET NUMBER	A1.0

SLAB PLAN GENERAL NOTES	
A.	REFER TO DRAWINGS BY OTHERS FOR ADDITIONAL INFORMATION REGARDING UNDERGROUND UTILITIES, SUCH AS: TYPES OF OPENINGS, IN-FLOOR FIXTURES, SUPPORT OF SUSPENDED FIXTURES, ETC.
B.	REFER TO STRUCTURAL DRAWINGS FOR TYPICAL CONTROL JOINT REQUIREMENTS, IF REQUIRED. ALIGN NEW CONTROL JOINTS TO EXISTING.
C.	TRENCH CUT OR CORE EXISTING SLAB AS NECESSARY FOR UNDERGROUND UTILITIES. USE GROUND PENETRATING RADAR TO SCAN THE SLAB FOR HIDDEN CONDITIONS PRIOR TO TRENCH CUTTING OR CORE DRILLING. NOTIFY ARCHITECT IF ANY HIDDEN CONDITIONS ARE DISCOVERED THAT COULD IMPACT THE UNDERGROUND UTILITY CONDITIONS OR ROUTING OR WHERE TRENCH CUTTING OR CORE DRILLING MAY ADVERSELY IMPACT THE INTEGRITY OF THE SLAB. IF REQUIRED, ALL SAW-CUTTING AND CORING LOCATIONS SHALL BE COORDINATED WITH THE OWNER AND/OR LANDLORD PRIOR TO COMMENCING WORK.
D.	IF CONCRETE FLOOR SLAB TRENCHING IS DETERMINED TO DEVIATE FROM THE PLUMBING PLANS, THE GENERAL CONTRACTOR IS REQUIRED TO SUBMIT A PROPOSED TRENCHING PLAN TO THE OWNER FOR REVIEW AND APPROVAL AT LEAST 48 HOURS PRIOR TO COMMENCING THE WORK.
E.	WHENEVER POSSIBLE, SAW CUTS SHALL BE LOCATED INSIDE THE PROPOSED COOKING AND SERVICE AREAS SCHEDULED TO RECEIVE FLOOR TILE AND SHALL NOT OCCUR IN PROPOSED SEATING AREAS OR PASSAGEWAYS.
F.	THE HOOD AND WALK-IN COOLER/FREEZER SUPPLIER SHALL SUBMIT SHOP DRAWINGS TO WINGSTOP RESTAURANTS, INC. FOR REVIEW PRIOR TO FABRICATION.
G.	PROVIDE/MAINTAIN POSITIVE SLOPE AROUND EACH FLOOR DRAIN OF 1:40 OR A 48" DIAMETER DEPRESSION THAT SLOPES APPROXIMATELY 1/8" PER FOOT.

 DRAIN LEGEND	
	FLOOR SINK
	FLOOR DRAIN
	TRENCH DRAIN
	FLOOR CLEAN-OUT

KEYNOTE LEGEND	
1	FLOOR SINK LOCATION - REFER TO PLUMBING DRAWINGS FOR ADDITIONAL INFORMATION
2	TOILET LOCATION - REFER TO PLUMBING DRAWINGS FOR ADDITIONAL INFORMATION
3	TRENCH DRAIN LOCATION - DRAIN TO BE RECESSED INTO FLOOR SLAB 8" MINIMUM WITH A 4" MINIMUM CONCRETE BED BELOW - REFER TO MANUFACTURERS STANDARD INSTALLATION INSTRUCTIONS - SLOPE FLOOR 1:40 TOWARDS DRAIN
4	FLOOR DRAIN LOCATION - REFER TO PLUMBING DRAWINGS FOR ADDITIONAL INFORMATION
5	FLOOR CLEAN-OUT LOCATION - REFER TO PLUMBING DRAWINGS FOR ADDITIONAL INFORMATION
6	LOCATION OF SERVICE SINK WITH MIXING VALVE - COORDINATE WITH PLUMBING DRAWINGS BY OTHERS
7	LOCATION OF GREASE INTERCEPTOR - COORDINATE WITH PLUMBING DRAWINGS BY OTHERS
8	LOCATION OF FLOOR ELEVATION CHANGE

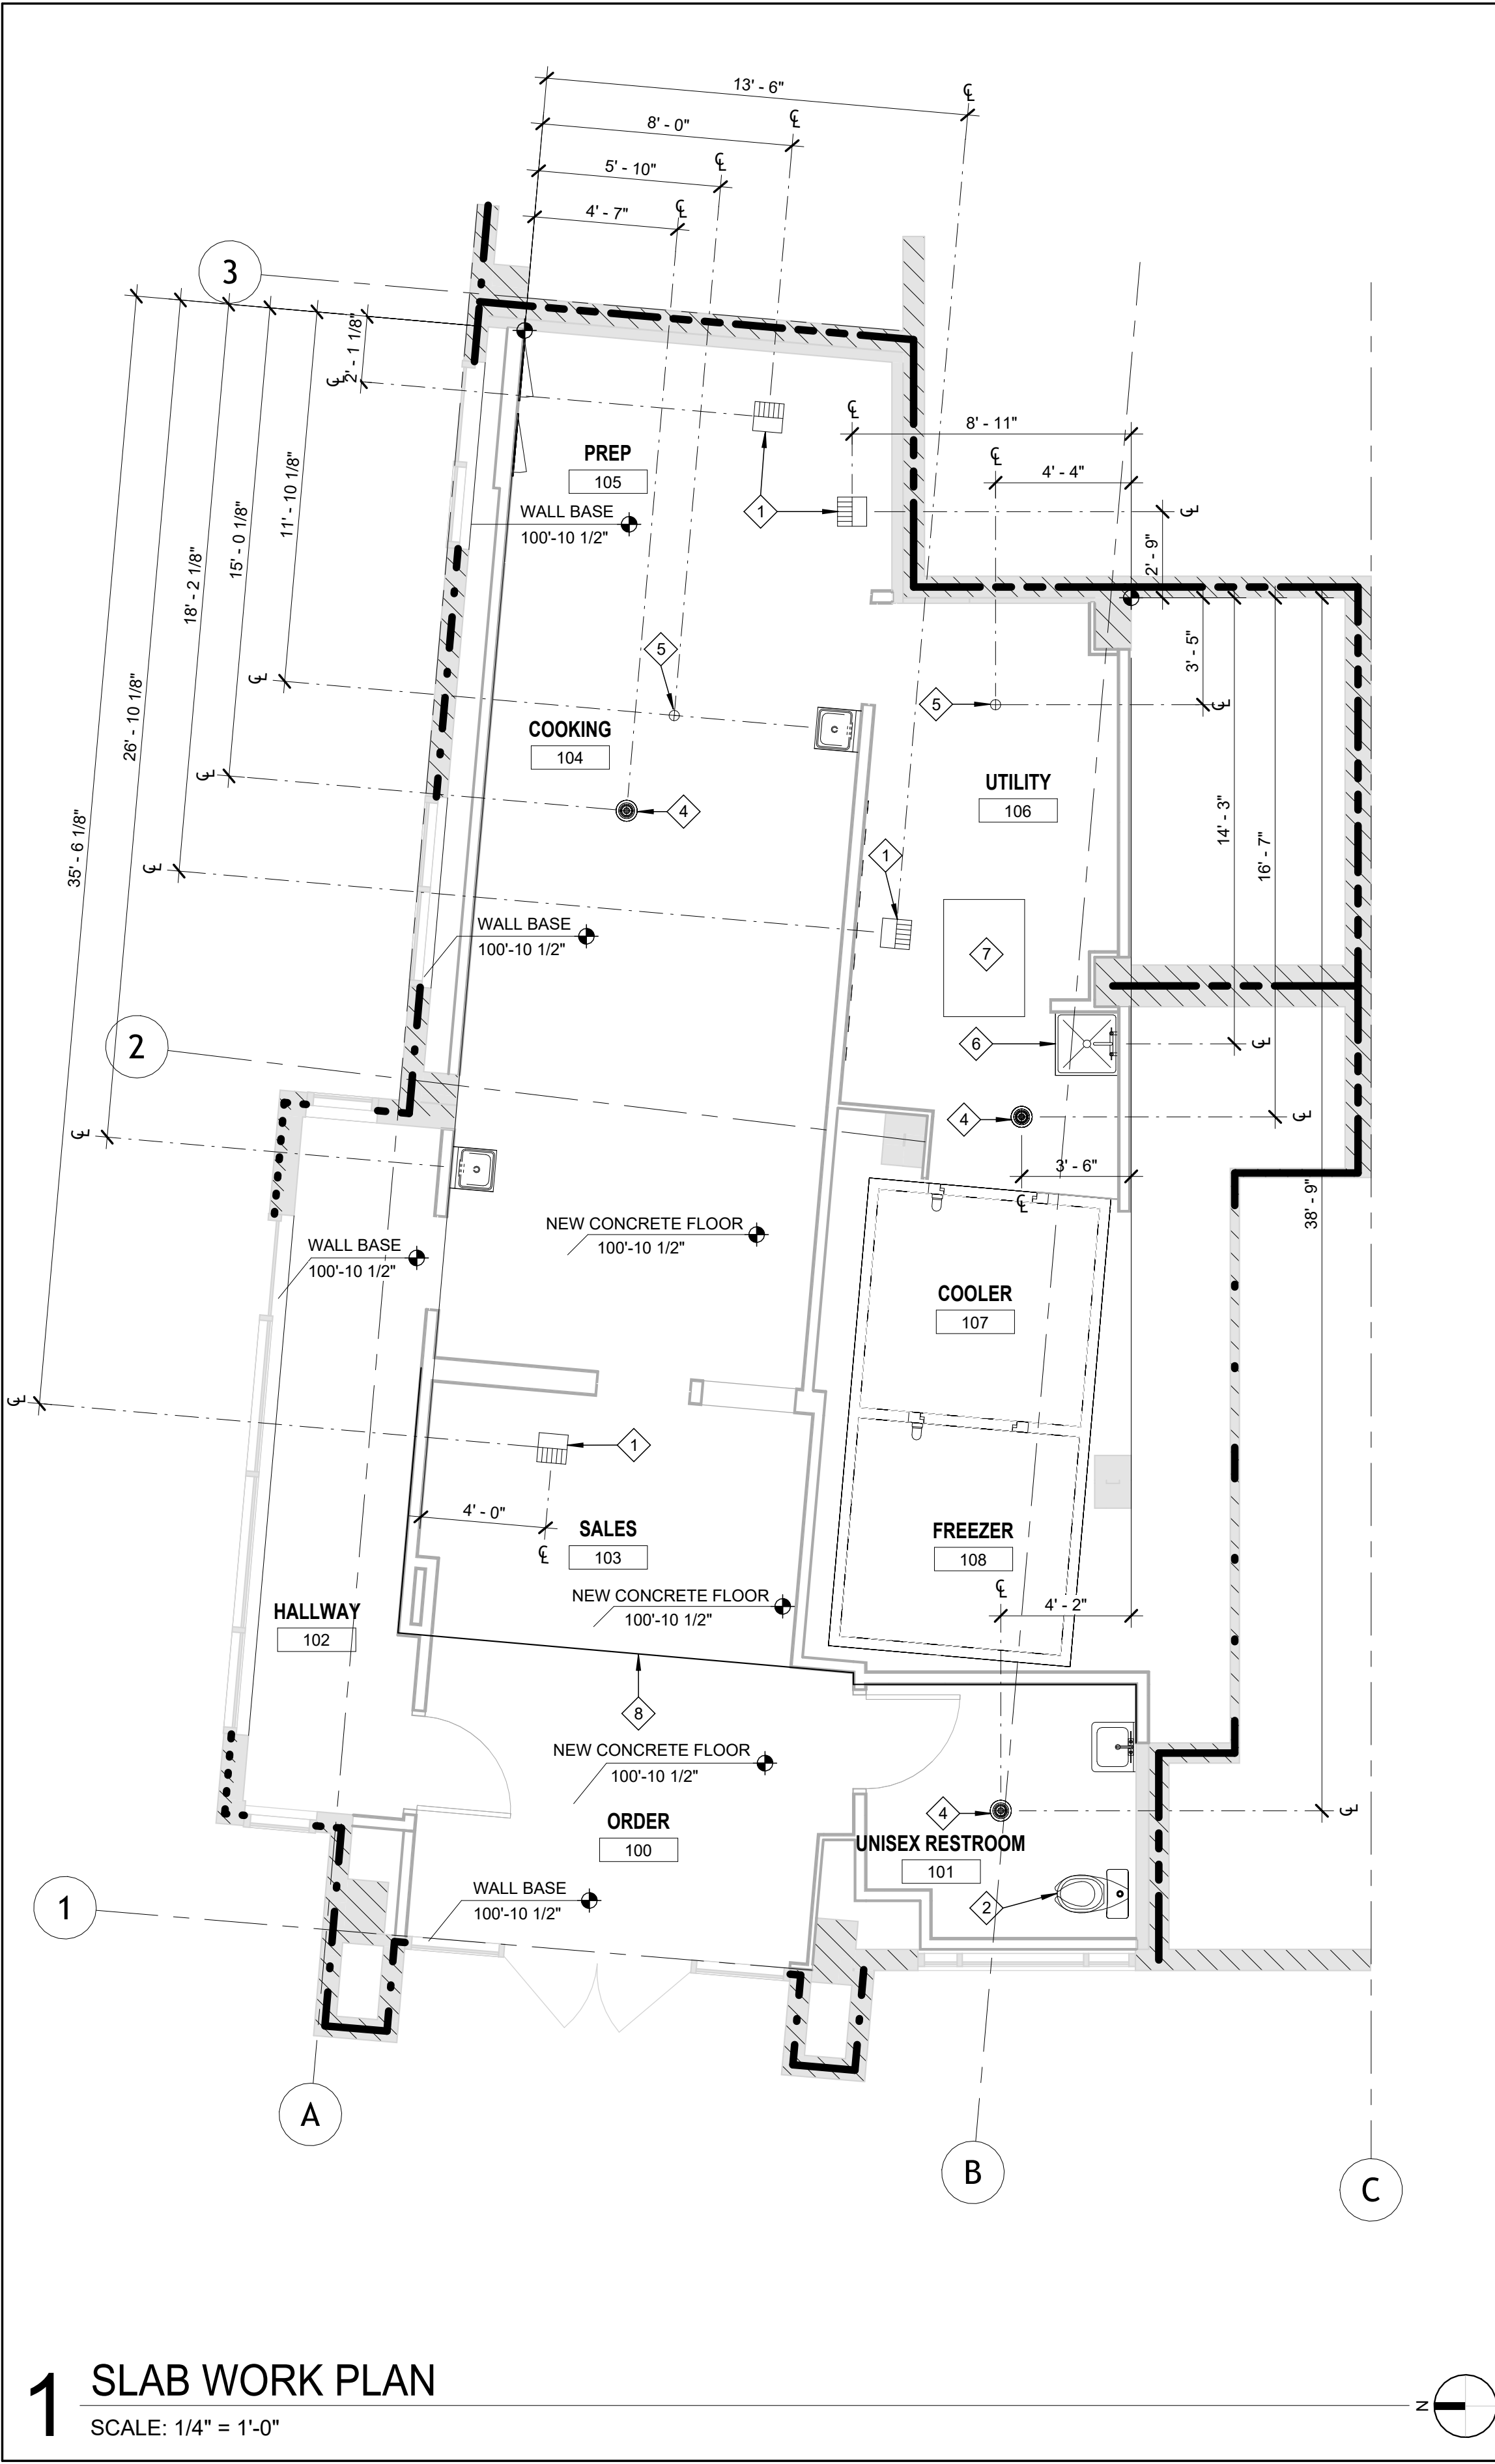

1 SLAB WORK PLAN
SCALE: 1/4" = 1'-0"

CONSULTANT



WILKUS
ARCHITECTS



2801 NORTH CENTRAL
EXPRESSWAY, SUITE 1600
DALLAS, TX 75204
TELEPHONE: (972) 686-6500
FAX: (972) 686-6502

THESE DRAWINGS, IDEAS, SPECIFICATIONS AND DESIGNS ARE EXCLUSIVE PROPERTY OF WINGSTOP RESTAURANTS, INC. NO PART OF THESE DRAWINGS MAY BE COPIED, REPRODUCED, OR OTHER STRUCTURES BUILT FROM SUCH WITHOUT THE WRITTEN CONSENT OF WINGSTOP RESTAURANTS, INC.

COPYRIGHT © 2025
WINGSTOP RESTAURANTS, INC.
ALL RIGHTS RESERVED

PROJECT INFORMATION

WINGSTOP
(GL#A216)

 
THE AUGUSTA ON GEORGIA
3831 GEORGIA AVENUE NW
WASHINGTON, D.C. 20009

SEAL

12360

REGISTERED
ARCHITECT

MATTHEW M. WILKUS
STATE OF WASHINGTON



June 10, 2026

MATTHEW M. WILKUS
LICENSE #12360
(EXPIRES 06/16/2025)

PROJECT NO. 2025-0430
DRAWN BY ANC
CHECKED BY JSS

ISSUE	DATE
DESIGN INTENT REVIEW	2026/03/30
PERMIT SET	2026/06/10

REVISION	DATE
----------	------

NG_DELCO_2025.02

TITLE
SLAB WORK PLAN

SHEET NUMBER
A2.0

FLOOR PLAN GENERAL NOTES

A.

FIELD VERIFY THAT EXISTING DOORS, FRAMES AND HARDWARE TO REMAIN ARE IN COMPLIANCE WITH ACCESSIBILITY CODES AND ORDINANCES.

B.

IF EXISTING EXTERIOR THRESHOLDS TO REMAIN EXCEED THE REQUIRED A.D.A. MAXIMUM HEIGHT OF 1/2", REMOVE AND REPLACE WITH ACCESSIBLE THRESHOLD. FLOOR LEVEL CHANGES AT ACCESSIBLE DOORWAYS TO HAVE BEVELED EDGES WITH A SLOPE NO GREATER THAN 1:2.

C.

EXTERIOR LANDINGS SHALL BE FLUSH WITH THE INTERIOR FINISHED FLOOR SLAB AND SLOPE AWAY FROM THE FACE OF THE BUILDING TO PROVIDE POSITIVE DRAINAGE.

D.

OPEN EXTERIOR JOINTS AROUND WINDOW AND DOOR FRAMES, BETWEEN WALL ASSEMBLIES AND FOUNDATIONS, BETWEEN WALL AND ROOF ASSEMBLIES, BETWEEN WALLS PANELS, AT PENETRATIONS FOR UTILITY SERVICES, FLOOR ASSEMBLIES AND ROOF ASSEMBLIES OR ANY OTHER OPENING IN THE EXTERIOR ENVELOPE SHALL BE SEALED, CAULKED, GASKETED AND/OR WEATHER-STRIPPED TO LIMIT AIR LEAKAGE.

E.

ALL EXIT DOORS TO BE OPERABLE FROM THE INSIDE WITHOUT SPECIAL KNOWLEDGE, KEY, OR EFFORT.

F.

THE HINGE SIDE OF ALL INTERIOR DOOR FRAMES SHALL BE PLACED 4" FROM THE ADJACENT INTERIOR WALL AS MEASURED TO THE JAMB, UNLESS NOTED OTHERWISE. INTERIOR DOORS PLACED IN MASONRY WALLS SHALL BE PLACED A MINIMUM OF 4". UNLESS NOTED OTHERWISE.

G.

A READILY VISIBLE SIGN SHALL BE ADJACENT TO THE MAIN PUBLIC DOORWAY STATING "THIS DOOR TO REMAIN UNLOCKED DURING BUSINESS HOURS".

H.

SAFETY GLAZING SHALL BE PROVIDED AT HAZARDOUS LOCATIONS, INCLUDING, BUT NOT LIMITED TO, GLAZING WITHIN 18" OF WALKING SURFACE, GLAZING IN DOORS AND AT WINDOWS ADJACENT TO DOORS.

I.

DIMENSION NOTES:

a. ALL STRUCTURAL GRID DIMENSIONS ARE FROM CENTERLINE OF EXISTING STRUCTURAL ELEMENTS UNLESS NOTED OTHERWISE.

b. ALL DIMENSIONS ARE TAKEN TO THE FACE OF STUD AT INTERIOR WALL ASSEMBLIES, UNLESS NOTED OTHERWISE.

c. CLEAR SHALL MEAN DIMENSION BETWEEN FACE OF THE FURTHEST PROTRUDING FINISH MATERIAL AT EACH SIDE OF OPENING.

d. ALL DIMENSIONS ARE FROM INTERIOR FACE OF EXISTING EXTERIOR WALL. CONSTRUCTION UNLESS NOTED OTHERWISE.

J.

STUD PARTITIONS TO BE SPACED 16" ON CENTER, OR AS REQUIRED BY SPECIFIED TESTED ASSEMBLY, OR UNLESS APPROVED BY ARCHITECT.

K.

PROVIDE SLOTTED SLIP TRACKS AT METAL STUD WALLS THAT EXTEND TO THE BOTTOM OF THE FLOOR, OR ROOF ASSEMBLY ABOVE, TO ALLOW FOR DEFLECTION.

L.

RATED PARTITIONS ARE TO BE CONSTRUCTED BEFORE NON-RATED PARTITIONS. ABOUT NON-RATED PARTITIONS TO RATED PARTITIONS.

M.

REFER TO UNDERWRITERS LABORATORIES, INC. LISTINGS FOR COMPLETE INSTALLATION DETAILS FOR FIRE-RESISTIVE ASSEMBLIES (WHERE NOTED), PROVIDE AND INSTALL FIRE STOPS EVERY 10'-0" O.C. BOTH VERTICALLY & HORIZONTALLY, AND USE APPROVED FIREBLOCKING MATERIALS AS REQUIRED WITHIN RATED WALL ASSEMBLIES.

N.

WALL TYPES WITH FIRE RATINGS SHALL CONTINUE FROM FLOOR TO FLOOR OR ROOF ABOVE, UNLESS NOTED OTHERWISE.

O.

PROVIDE AND INSTALL FIRE STOPS EVERY 10'-0" O.C. BOTH VERTICALLY & HORIZONTALLY, AND USE APPROVED FIREBLOCKING MATERIALS AS REQUIRED WITHIN RATED WALL ASSEMBLIES.

P.

THROUGH-WALL PENETRATIONS IN FIRE-RESISTANCE RATED ASSEMBLIES SHALL BE SEALED WITH MATERIALS AND ASSEMBLIES NECESSARY TO MAINTAIN THE REQUIRED FIRE-RESISTIVE RATING OF THE PARTITION.

Q.

PROVIDE AND INSTALL APPROVED FIRE STOPPING AT PENETRATIONS OF RATED WALL, FLOOR/CEILING, ROOF/CEILING AND ROOF ASSEMBLIES. FIRE STOPPING TO BE PROVIDED AND INSTALLED BY CONTRACTOR REQUIRING PENETRATION. FIREPROOFING, SEALANTS AND DAMPERS MAY NOT BE SHOWN ON SOME DRAWINGS FOR CLARITY; HOWEVER, ASSEMBLIES MUST BE INSTALLED AS REQUIRED TO MAINTAIN AND/OR PROVIDE RATINGS INDICATED ON DRAWINGS. PENETRATION SEALANTS OR ASSEMBLIES SHALL BE UL LISTED (OR EQUIVALENT) FOR APPROVED INSTALLATION WITHIN THE RATED ASSEMBLY NOTED ON THE PLANS.

S.

STEEL STUD GAUGE TO BE DESIGNED AS REQUIRED IN ORDER TO MEET DEFLECTION CRITERIA INCLUDING ADDITIONAL LOADING INCURRED DUE TO WALL MOUNTED EQUIPMENT, FIXTURES, GRAB BARS, ETC. REFER TO STEEL STUD HEIGHT LIMIT CHART.

T.

PARTITIONS SHALL BE ANCHORED FIRMLY AS PER MANUFACTURERS SPECIFICATIONS AND AS REQUIRED BY THE STATE AND LOCAL CODES, ORDINANCES AND LAWS.

U.

PROVIDE BRACING BETWEEN TOP OF WALL CONSTRUCTION (ABOVE CEILING) AND FLOOR OR ROOF ASSEMBLY ABOVE AS NEEDED.

V.

THE CONTRACTOR SHALL PROVIDE WOOD BLOCKING AS REQUIRED FOR MOUNTING TABLES, SHELVING, CABINETS, AND ANY OTHER EQUIPMENT NOT SPECIFICALLY MENTIONED. ALL WOOD SHALL BE NON-COMBUSTIBLE AS REQUIRED PER LOCAL AUTHORITY HAVING JURISDICTION. WITHIN RATED WALL ASSEMBLIES SOLID WOOD BLOCKING, FIRE TREATED BLOCKING, OR ALTERNATE APPROVED METHODS INSTALLED PER CODE.

W.

GENERAL CONTRACTOR TO COORDINATE, PROVIDE AND INSTALL NECESSARY BLOCKING FOR OWNER CONTRACTED SIGNAGE.

X.

GENERAL CONTRACTOR SHALL FIELD VERIFY SIZE AND LOCATIONS OF MECHANICAL EQUIPMENT PADS AND BASES, INCLUDING POWER AND/OR DRAIN INSTALLATIONS WITH EQUIPMENT MANUFACTURERS REQUIREMENTS PRIOR TO PROCEEDING WITH THE WORK. INFORM THE ARCHITECT IMMEDIATELY OF ANY DISCREPANCIES WITH THE CONSTRUCTION DOCUMENTS. CHANGES TO ACCOMMODATE FIELD CONDITIONS AND/OR SUBSTITUTIONS NOT PREVIOUSLY COMMUNICATED WITH THE ARCHITECT SHALL BE MADE WITHOUT CHARGE TO THE OWNER.

Y.

GENERAL CONTRACTOR SHALL PROVIDE SUFFICIENT FRAMING IN WALL ASSEMBLIES FOR DUCTWORK, RETURN AIR OPENINGS, GRILL OPENINGS, ETC. ABOVE AND BELOW THE HUNG CEILING. COORDINATE WITH MECHANICAL ENGINEERED DOCUMENTS AND REVIEWED AND APPROVED MECHANICAL SHOP DRAWINGS. OPENINGS SHALL BE PROPERLY SEALED FOR SOUNDPROOFING AND VIBRATION.

Z.

VERIFY LOCATION, SIZE AND WALL THICKNESS REQUIRED TO RECESS MECHANICAL, PLUMBING AND ELECTRICAL ITEMS AND MAINTAIN FIRE RATING REQUIREMENTS OF THE WALL (IF REQUIRED) AT BUILT-INS UNLESS NOTED OTHERWISE: UNIT HEATERS, CONVECTORS, ELECTRICAL PANELS, FIRE EXTINGUISHERS, CABINETS, DUCTS, PIPING AND OTHER SUCH ITEMS REQUIRING RECESSES.

AA.

GENERAL CONTRACTOR SHALL PROVIDE AND INSTALL ACCESS PANELS AS REQUIRED FOR MECHANICAL, ELECTRICAL AND PLUMBING INSTALLATIONS AS PER LOCAL CODES, ORDINANCES AND LAWS.

AB.

MECHANICAL, PLUMBING, AND ELECTRICAL CONTRACTORS SHALL COORDINATE WITH GENERAL CONTRACTOR TO INSTALL ROUGH CARPENTRY AS NECESSARY, FOR ANY REQUIRED CEILING AND/OR WALL ACCESS PANELS FOR INSTALLATIONS REQUIRED WITHIN THEIR SCOPE OF WORK.

AC.

GENERAL CONTRACTOR TO COORDINATE SIZE AND LOCATION OF REQUIRED ACCESS PANELS WITH TRADE REQUIRING THE SAME. ACCESS PANELS SHALL BE PROVIDED BY THE TRADE REQUIRING ACCESS. LOCATIONS TO BE PRELIMINARILY LOCATED IN GYPSUM BOARD CEILINGS AND RECEIVE APPROVAL FROM THE ARCHITECT'S FIELD REPRESENTATIVE PRIOR TO INSTALLATION.

AD.

INSTALL 5/8" WATER RESISTANT GYPSUM BOARD INSIDE TOILET ROOMS TO 8'-0" MINIMUM ABOVE FINISHED FLOOR ELEVATION.

AE.

ITEMS DETAILED TO BE RECESSED, FULLY OR SEMI, SHALL BE INSTALLED FLUSH WITH FINAL FACE OF PARTITION FINISH MATERIAL, UNLESS NOTED OTHERWISE. INSTALL OFFSET STUDS, WHERE REQUIRED, SO THAT THE FINISH SURFACE IS TRUE AND FLUSH.

AF.

INSTALL METAL CORNER BEADS TREATED WITH DRYWALL COMPOUND, AT EXPOSED GYPSUM BOARD EDGES. INSTALL CASING BEADS WHEREVER GYPSUM BOARD, PLASTER, ETC. ABUTS A DISSIMILAR FINISH MATERIAL AND PROVIDE SEALANT AS REQUIRED, UNLESS NOTED OTHERWISE.

AG.

PROVIDE HORIZONTAL AND VERTICAL GYPSUM BOARD CONTROL JOINTS TO PREVENT CRACKING AT 30' - 0". LOCATED AS DESCRIBED BY BEST PRACTICES IN ACCORDANCE WITH US GYPSUM ASSOCIATION, COORDINATE LOCATIONS WITH ARCHITECT.

AH.

REFER TO THE FINISH SCHEDULE, FLOOR PLANS, AND/OR ELEVATIONS FOR LOCATION AND EXTENTS OF FINISH MATERIALS APPLIED.

AI.

PROVIDE WOOD BLOCKING (OR STEEL STUD) ABOVE GYPSUM BOARD CEILINGS AS REQUIRED FOR MISCELLANEOUS SUSPENDED ITEMS (E.G. CURTAIN TRACKS, WINDOW SHADES, ACOUSTICAL BAFFLES, ETC.).

AJ.

CARPENTER TO PROVIDE FURRED CHASE AND/OR SOFFIT AS REQUIRED TO CONCEAL MECHANICAL DUCTS, PIPING AND ELECTRICAL WIRING. REFER TO AND COORDINATE WITH ENGINEERED CONSTRUCTION DOCUMENTS BY OTHERS TO VERIFY SIZE AND LOCATIONS REQUIRED. COORDINATE WITH ARCHITECT TO DETERMINE FINISHED SIZE, HEIGHT, PROFILE AND FINISH MATERIAL.

AK.

GAS PIPING ON THE EXTERIOR, UNDER FLOOR, AND BELOW EXISTING ROOF/CEILING, ASSEMBLY SHALL BE GALVANIZED.

AL.

GENERAL CONTRACTOR SHALL SNAKE AND CLEAR FLOOR DRAINS PRIOR TO TURN OVER. CLEANING SHALL INCLUDE, BUT NOT BE LIMITED TO, REMOVAL OF ANY GROUT FROM FLOOR DRAIN COVERS.

AM.

USE ONLY NON-CORROSIVE FASTENERS ON PRESSURE TREATED LUMBER.

AN.

PROVIDE AND INSTALL ESCUTCHEON PLATES AT KITCHEN AND TOILET WALL PENETRATIONS.

AO.

EXISTING UTILITY SERVICES SHOWN TO REMAIN, REROUTE AS REQUIRED TO CONCEAL THE SERVICE IN WALLS AND ABOVE CEILING.

KEYNOTE LEGEND

1

SIGNAGE LOCATION - REFER TO SIGNAGE DRAWINGS BY OTHERS FOR ADDITIONAL INFORMATION - EXTERIOR SIGNAGE TO BE PROVIDED, PERMITTED, INSTALLED, AND INSPECTED UNDER A SEPARATE PERMIT

2

EXISTING COLUMN TO REMAIN - PROTECT

3

EXISTING ANODIZED ALUMINUM STOREFRONT SYSTEM WITH GLAZING TO REMAIN - PROTECT

4

PROVIDE CODE COMPLIANT OCCUPANT LOAD SIGN - FIELD VERIFY LOCATION WITH INSPECTOR ON SITE PRIOR TO INSTALLATION

5

PROVIDE INTERNATIONAL SYMBOL OF ACCESSIBILITY - MOUNT 60" A.F.F. TO CENTERLINE OF SIGN

6

EXISTING THRESHOLD TO REMAIN - VERIFY 1/2" LIP MAXIMUM AND BEVELED SIDES THAT SLOPE 1:2 MAXIMUM - REPLACE AS NEEDED

7

NOT USED

8

PROVIDE DOWELED CONNECTION AT FLOOR SLAB INFILL LOCATIONS - REFER TO STRUCTURAL FOR ADDITIONAL INFORMATION

9

FIRE EXTINGUISHER - FIELD VERIFY FINAL LOCATION WITH FIRE MARSHAL PRIOR TO INSTALLATION

10

GENERAL CONTRACTOR TO INSTALL 5/8" CEMENT BOARD BEHIND EXHAUST HOOD, EXTEND CEMENT BOARD FROM FINISHED FLOOR TO 6" ABOVE CEILING, AND A MINIMUM OF 18" BEYOND EACH END OF THE EXHAUST HOOD

11

NOT USED

12

TRANSACTION SURFACE - 36" LONG PORTION TO MEET ADA COMPLIANCE REQUIREMENTS - NOT TO EXCEED 34" A.F.F. ON CUSTOMER SIDE

13

DASHED LINE INDICATES SOFFIT/HEADER ABOVE - REFER TO REFLECTED CEILING PLAN FOR ADDITIONAL INFORMATION

14

NOT USED

15

SODA CHASE FROM CEILING TO BELOW CABINET - REFER TO DETAIL

16

GENERAL CONTRACTOR TO INSTALL 3/4" FIRE RETARDANT PRESSURE TREATED PLYWOOD BACKING AT WALL ASSEMBLIES WITHIN THE COOKING, PREP, AND UTILITY ROOMS FROM 30" A.F.F. TO 6" ABOVE SCHEDULED CEILING ELEVATION TO ALLOW FOR INSTALLATION OF FUTURE EQUIPMENT AND ACCESSORIES

17

DASHED LINE INDICATES EXHAUST HOOD - REFER TO REFLECTED CEILING PLAN FOR ADDITIONAL INFORMATION

18

GENERAL CONTRACTOR TO INSTALL STAINLESS STEEL WALL PANELS BEHIND COOKING LINE - REFER TO INTERIOR ELEVATIONS FOR EXTENTS BEYOND EDGE OF HOOD ON BOTH SIDES - SEE STAINLESS STEEL WALL PANEL DETAIL FOR ADDITIONAL INFORMATION

19

STAINLESS STEEL END CAPS TO THE HEADER OR CEILING ELEVATION THROUGHOUT ENTIRE KITCHEN AND SERVICE AREAS

20

STAINLESS STEEL CORNER GUARDS TO THE HEADER OR CEILING ELEVATION THROUGHOUT ENTIRE KITCHEN AND SERVICE AREAS

21

SERVICE SINK WITH MIXING VALVE - REFER TO PLUMBING DRAWINGS FOR ADDITIONAL INFORMATION

22

WALL-MOUNTED STRIP AT SERVICE SINK FOR FLOOR MATS

23

MUSIC, AUDIO, VISUAL, AND SECURITY EQUIPMENT - VERIFY EQUIPMENT AND EXTENTS WITH OWNER

24

ELECTRICAL PANELS - PROVIDE 30" X 48" CLEAR FLOOR SPACE IN FRONT OF PANEL(S) - REFER TO ELECTRICAL PLANS FOR MORE INFORMATION

25

NOT USED

26

NOT USED

27

NOT USED

28

10" X 4" MIN. WALL VENT FOR CIRCULATION BEHIND STOREFRONT. COLOR TO BE WHITE - REFER TO INTERIOR ELEVATIONS

29

INFILL WALL BELOW EXISTING STAIRS

30

GENERAL CONTRACTOR TO INSTALL OPAQUE WINDOW TINT/FILM. VERIFY WITH OWNER AND LANDLORD.

31

24" X 24" METAL ACCESS DOOR, 12" A.F.F., WHITE - REFER TO INTERIOR ELEVATIONS

WALL TYPE DESCRIPTION (EXAMPLE)

ASSEMBLY ABOVE PER PLANS

CEILING PER PLANS

SLAB PER PLANS

(R) - ASSEMBLY RATING:

0 - 0 SMOKE RATING

1 - 1 HOUR FIRE RATING

2 - 2 HOUR FIRE RATING

3 - 3 HOUR FIRE RATING

(M) - WALL MATERIAL:

B - BRICK

C - CH STUD

H - HAT CHANNEL

M - MASONRY

R - RESILIENT CHANNEL

S - STEEL STUD

W - WOOD STUD

Z - Z FURRING

(#) - NOMINAL SIZE:

0 - 7/8"

1 - 2X2 OR 1-5/8"

2 - 2-1/2"

3 - 3-5/8"

4 - 2X4, 4" OR 4" CMU

6 - 2X6, 6" OR 6" CMU

8 - 2X8, 8" OR 8" CMU

(T) - TERMINATION OF STUD

A - 6" ABOVE CEILING

C - BOTTOM OF CEILING (ASSEMBLY)

D - FULL HEIGHT TO DECK

P - PARTIAL HEIGHT KNEE WALL

(S) - SHEATHING INFORMATION:

A - ONE LAYER GYP BOARD ONE SIDE - TO TERMINATE 6" ABOVE CEILING

B - ONE LAYER GYP BOARD ONE SIDE - TO TERMINATE AT DECK

C - ONE LAYER GYP BOARD ON EACH SIDE - TO TERMINATE 6" ABOVE CEILING

D - ONE LAYER GYP BOARD ON EACH SIDE - TO TERMINATE AT CEILING OR TOP OF STUD

E - ONE LAYER GYP BOARD ON EACH SIDE - TO TERMINATE AT DECK

F - TWO LAYERS GYP BOARD ON EACH SIDE - TO TERMINATE AT DECK

G - PROJECT SPECIFIC SHEATHING START HERE

SEE PLAN FOR INSULATION LOCATIONS TO TERMINATE 6" ABOVE CEILING UNO

NOTE: WHEN WALL IS UNBALANCED, THE WALL TAG IS LOCATED ON THE "TAG SIDE" OF THE ASSEMBLY WHEN SHOWN ON THE DESCRIPTION.

STEEL STUD HEIGHT LIMIT CHART

STEEL STUD HEIGHT LIMIT CHART

TYPE

MAX. CLEAR HEIGHT 16" O.C.

3-5/8" X 1-5/8" X 18 MILS / 25 GAUGE

13'-8"

3-5/8" X 1-5/8" X 30 MILS / 20 GAUGE

17'-0"

3-5/8" X 1-5/8" X 43 MILS / 18 GAUGE

18'-6"

3-5/8" X 1-5/8" X 54 MILS / 16 GAUGE

20'-0"

6" X 1-5/8" X 30 MILS / 20 GAUGE

25'-6"

6" X 1-5/8" X 43 MILS / 18 GAUGE

27'-6"

WALL TYPE MARKER KEY

(R) - ASSEMBLY RATING

(M) - WALL MATERIAL

(#) - NOMINAL SIZE

(T) - TERMINATION OF STUD

(S) - SHEATHING INFORMATION

DECK (OR ASSEMBLY) PER PLANS

CEILING ASSEMBLY PER PLANS

EXISTING WALL ASSEMBLY

WALL MATERIAL: S - STEEL STUD

NOMINAL SIZE: 1 - 1 5/8" 3 - 3 5/8"

SLAB (OR ASSEMBLY) PER PLANS

WALL TYPE: (S1C) (S3C) (S6C) (S8C)

DESIGN NO: N/A

STC/NRC RATING: N/A

COMMENTS: N/A

DECK (OR ASSEMBLY) PER PLANS

CEILING ASSEMBLY PER PLANS

EXISTING WALL ASSEMBLY

WALL MATERIAL: S - STEEL STUD

NOMINAL SIZE: 1 - 1 5/8" 3 - 3 5/8"

SLAB (OR ASSEMBLY) PER PLANS

WALL TYPE: (S1A) (S3A) (S6A)

DESIGN NO: N/A

STC/NRC RATING: N/A

COMMENTS: N/A

DECK (OR ASSEMBLY) PER PLANS

CEILING ASSEMBLY PER PLANS

EXISTING WALL ASSEMBLY

WALL MATERIAL: S - STEEL STUD

NOMINAL SIZE: 3 - 3-5/8"

SLAB (OR ASSEMBLY) PER PLANS

WALL TYPE: (S3D)

DESIGN NO: N/A

STC/NRC RATING: N/A

COMMENTS: N/A

ARCHITECTURAL FLOOR PLAN

SCALE: 1/4" = 1'-0"

CONSULTANT

WILKUS ARCHITECTS

2801 NORTH CENTRAL EXPRESSWAY, SUITE 1600 DALLAS, TX 75204 TELEPHONE: (972) 686-6500 FAX: (972) 686-6502

THESE DRAWINGS, IDEAS, SPECIFICATIONS AND DESIGNS ARE EXCLUSIVE PROPERTY OF WINGSTOP RESTAURANTS, INC. NO PART OF THESE DRAWINGS MAY BE COPIED, REPRODUCED, OR OTHER STRUCTURES BUILT FROM SUCH WITHOUT THE WRITTEN CONSENT OF WINGSTOP RESTAURANTS, INC.

COPYRIGHT © 2025 WINGSTOP RESTAURANTS, INC. ALL RIGHTS RESERVED

PROJECT INFORMATION

WINGSTOP (GL#A216)

THE AUGUSTA ON GEORGIA 3831 GEORGIA AVENUE NW WASHINGTON, D.C. 20009

12360 REGISTERED ARCHITECT MATTHEW M. WILKUS STATE OF WASHINGTON

June 10, 2026 MATTHEW M. WILKUS LICENSE #12360 (EXPIRES 06/16/2025)

PROJECT NO. 2025-0430

DRAWN BY ANC

CHECKED BY JSS

ISSUE DATE

DESIGN INTENT REVIEW 2026/03/30

PERMIT SET 2026/06/10

REVISION DATE


NG_DELCO_2025.02

TITLE ARCHITECTURAL FLOOR PLAN

SHEET NUMBER A2.1

ICC A117.1-2009 : ACCESSIBLE AND USABLE BUILDINGS AND FACILITIES - RESTROOMS

ALL INTERIOR CONSTRUCTION WITHIN THE SCOPE OF THIS PROJECT IS REQUIRED TO BE ACCESSIBLE AS SET FORTH IN THE "ICC A117.1-2009ACCESSIBLE AND USABLE BUILDINGS AND FACILITIES

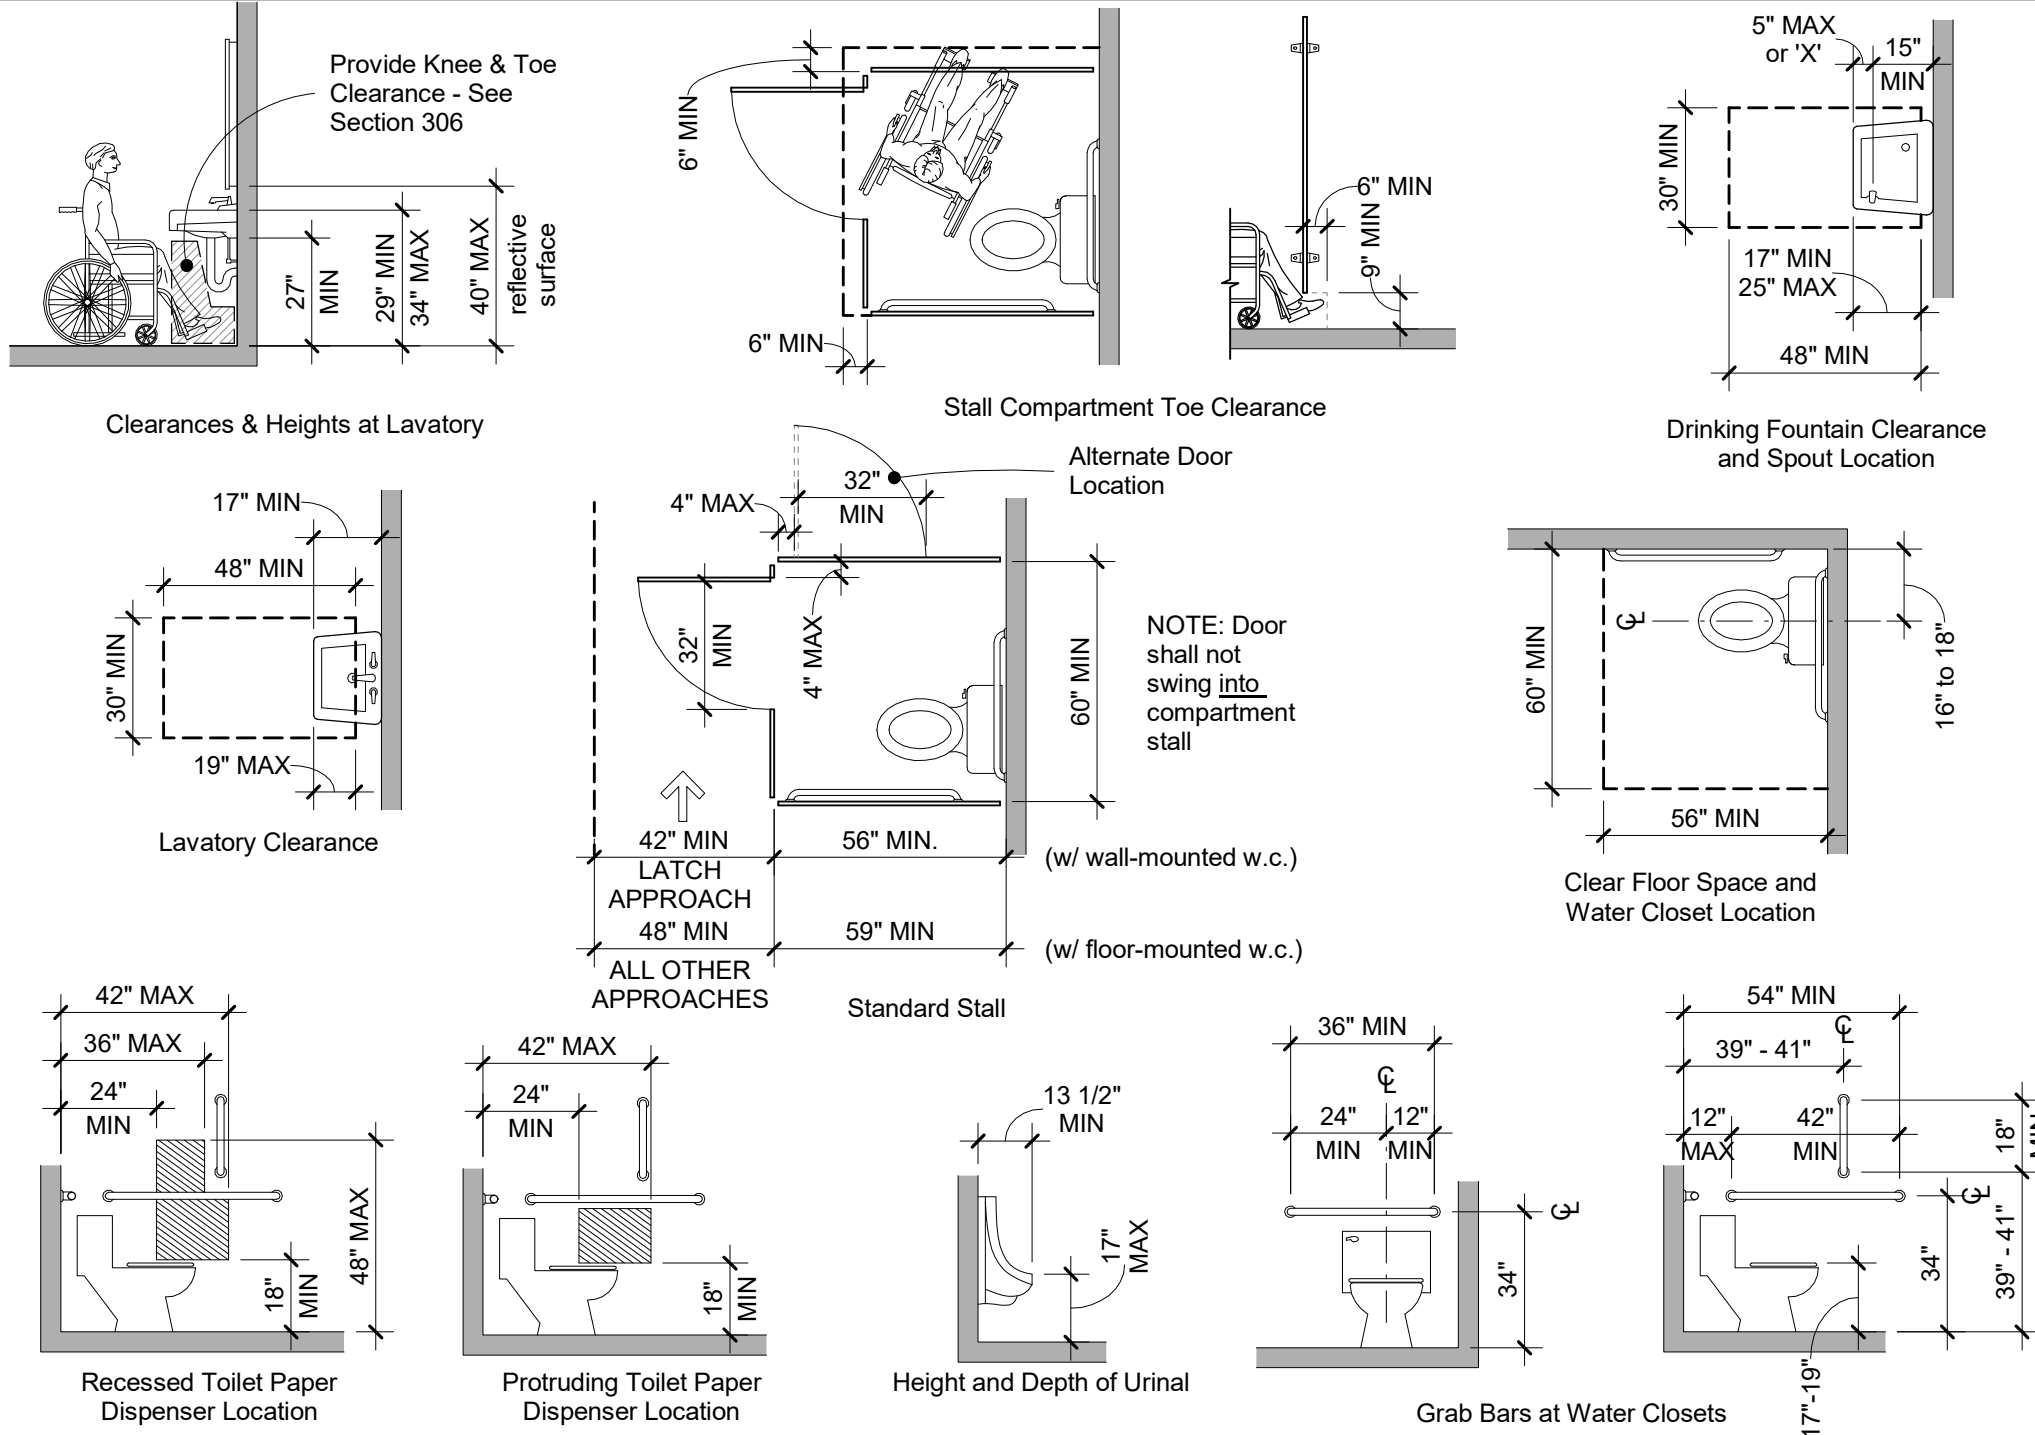

RESTROOM EQUIPMENT SCHEDULE


ITEM	DESCRIPTION	MODEL	MANUFACTURER	REMARKS	SUPPLIED BY	INSTALLED BY
8 - RESTROOMS						
8.1	RESTROOM MIRROR	B-165-2436	BOBRICK	SIZE: 24 IN X 36 IN WITH S.S. CHANNEL FRAME	GC	GC
8.2	SOAP DISPENSER	SF900TBK	SAN JAMAR	-	OWNER	GC
8.3	TOILET PAPER DISPENSER - SURFACE MOUNT	B-2888	BOBRICK	-	OWNER	GC
8.5	ELECTRIC HAND DRYER	XL-SB	EXCEL DRYER	-	OWNER	GC
8.6	SANITARY NAPKIN DISPOSAL - SURFACE MOUNTED	FG614000WHT	RUBBERMAID	-	GC	GC
8.7	GRAB BAR - 36"	B-6806-36	BOBRICK	-	GC	GC
8.8	GRAB BAR - 42"	B-6806-42	BOBRICK	-	GC	GC
8.9	GRAB BAR - 18"	B-6806-18	BOBRICK	-	GC	GC
8.10	28 QUART WASTE RECEPTACLE	SKU: FG295600BLA	RUBBERMAID	-	OWNER	GC

RESTROOM GENERAL NOTES


- PROVIDE AND INSTALL CEMENT SHEATHING AS REQUIRED AT WALL TILE LOCATIONS AND EXTENTS. VERIFY AND COORDINATE ACCEPTABLE SHEATHING MATERIAL WITH TILE SUPPLIER/MANUFACTURER PRIOR TO INSTALLATION.
- REFER TO PLUMBING CONSTRUCTION DOCUMENTS AND CUT SHEETS FOR ADDITIONAL INFORMATION REGARDING FIXTURES, INSTALLATION, AND/OR ACCESSORIES.
- WATER CLOSET FLUSH VALVE CONTROLS AND OPERATING MECHANISM CONTROLS SHALL BE OPERABLE WITH ONE HAND AND SHALL NOT REQUIRE TIGHT GRASPING, PINCHING, OR TWISTING OF THE WRIST, AND SHALL NOT BE MOUNTED MORE THAN 44" ABOVE THE FINISHED FLOOR ELEVATION.
- THE FORCE REQUIRED TO ACTIVATE WATER CLOSET FLUSH VALVE CONTROLS, FAUCETS, AND OPERATING MECHANISM CONTROLS SHALL BE NO GREATER THAN 5 LBF.
- WATER CLOSET FLUSH VALVE AND OPERATING MECHANISM CONTROLS SHALL BE LOCATED ON THE OPEN-SIDE OF THE FIXTURE.

KEYNOTE LEGEND


- 48" WIDE X 30" DEEP CLEAR FLOOR SPACE
- NOT USED
- DASHED LINES INDICATE REQUIRED CLEAR FLOOR SPACES - TYPICAL
- 60" WIDE X 59" DEEP CLEAR FLOOR SPACE
- PROVIDE SEAL AT TOILET CONNECTION - ENTIRE PERIMETER
- INSULATE TRAP - TYPICAL
- DASHED LINE INDICATES EXTENTS OF FIRE RETARDANT PRESSURE TREATED WOOD BLOCKING FOR REFERENCE - COORDINATE REQUIREMENTS AND LIMITS WITH MANUFACTURERS INFORMATION
- TILE STARTING POINT
- 10" X 4" MIN. RETURN AIR GRILLE, WHITE

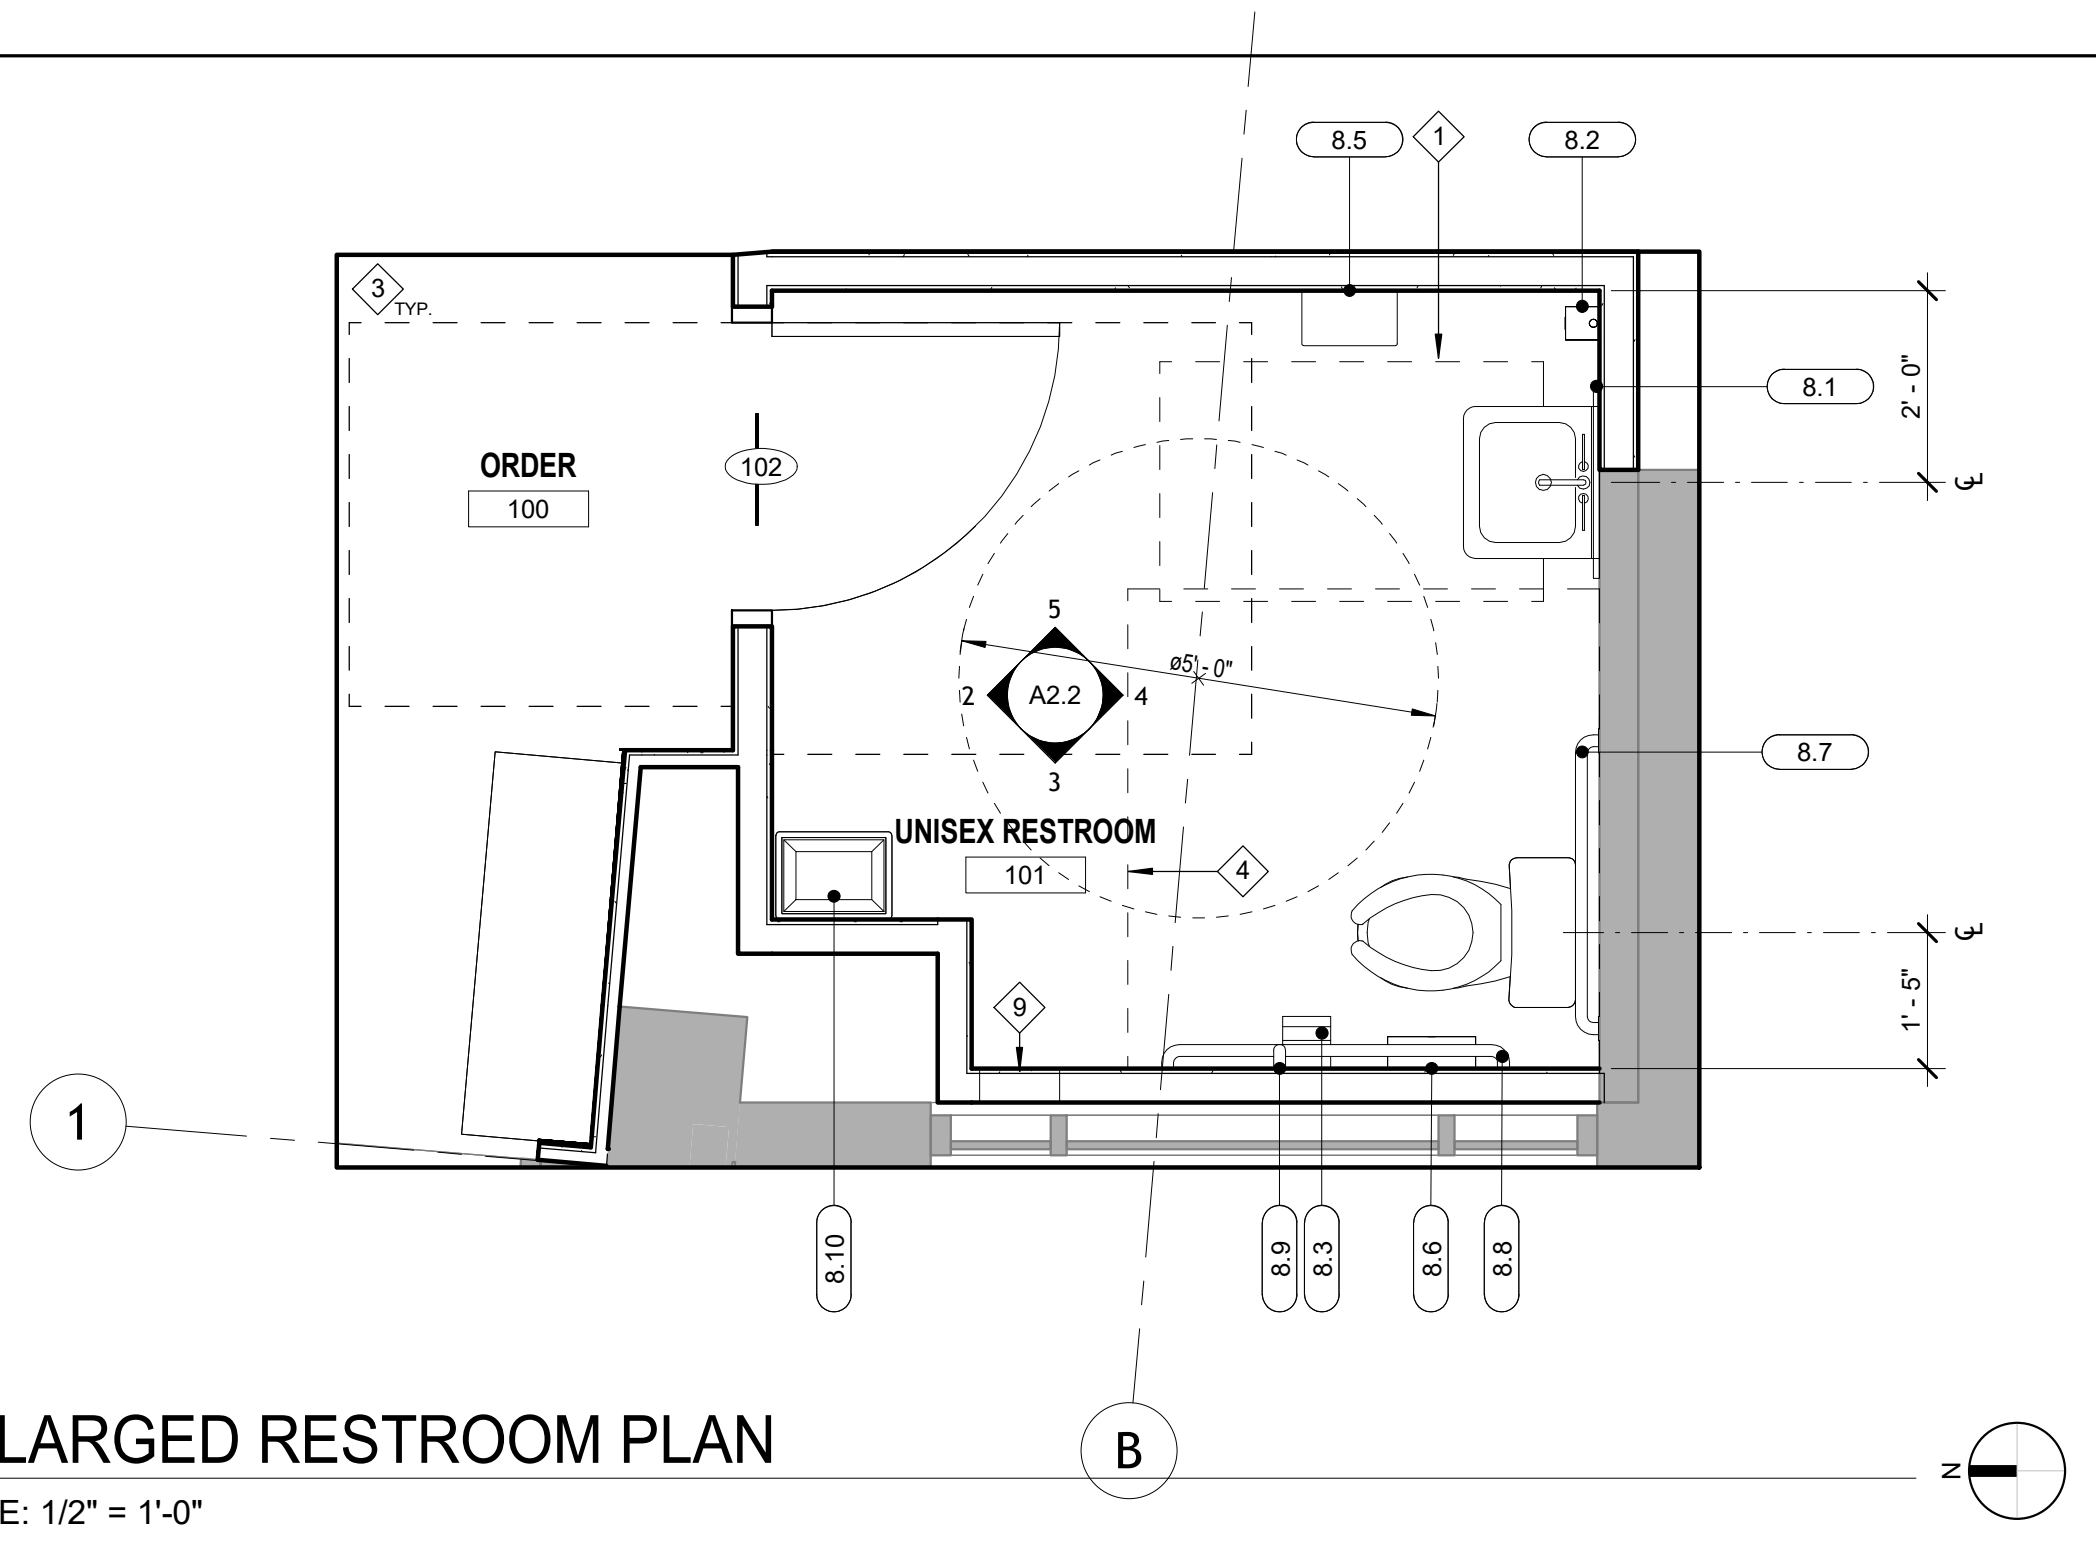


1 ENLARGED RESTROOM PLAN
SCALE: 1/2" = 1'-0"

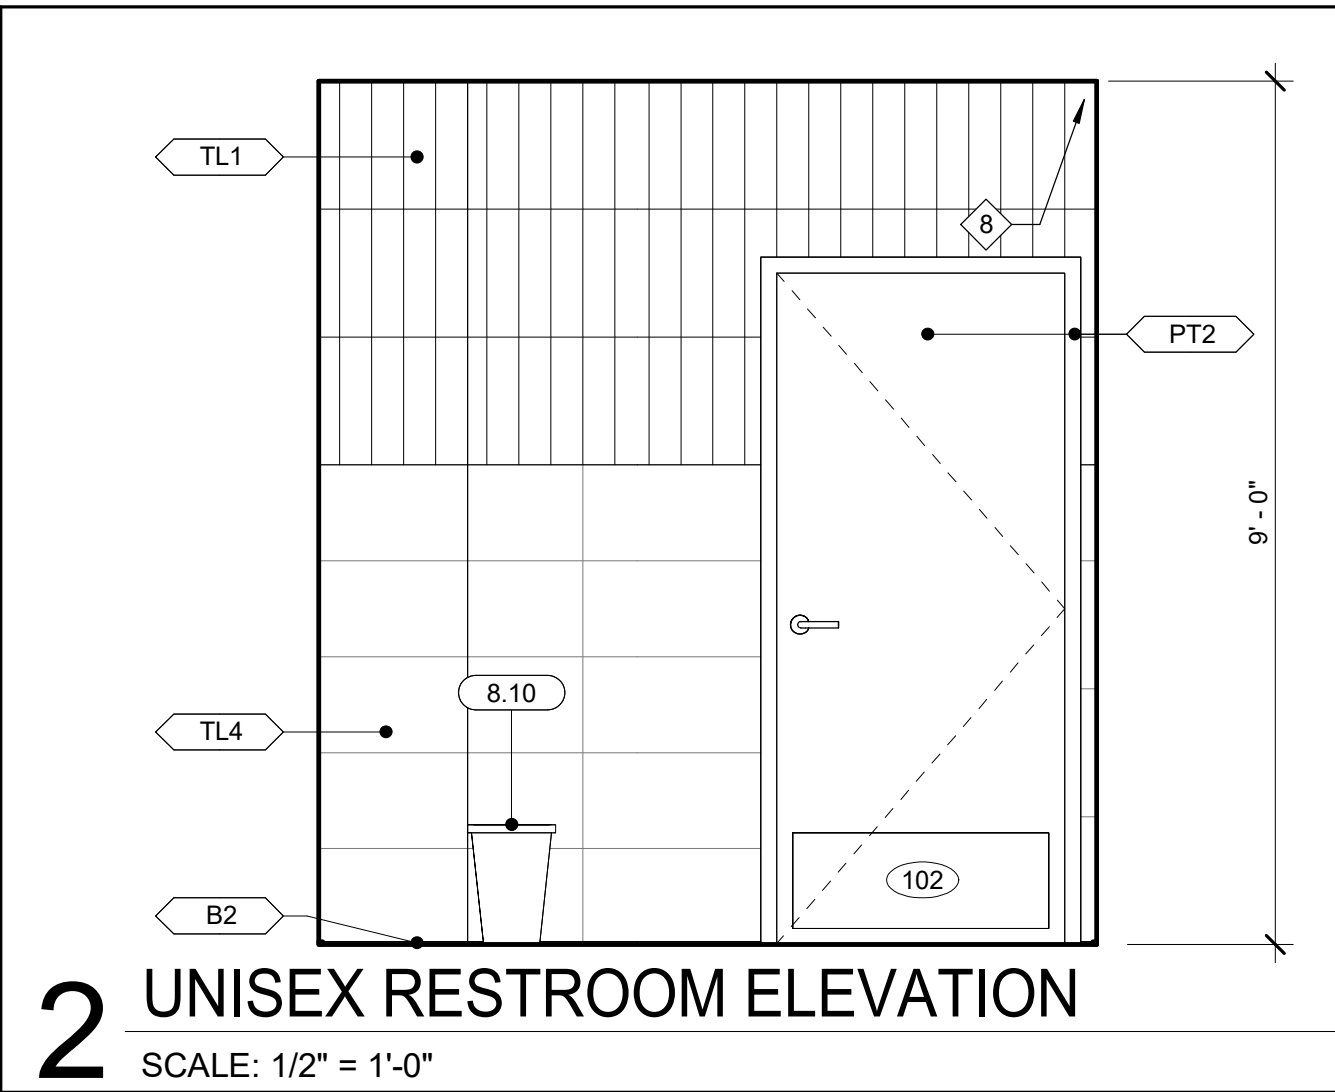


2 UNISEX RESTROOM ELEVATION
SCALE: 1/2" = 1'-0"

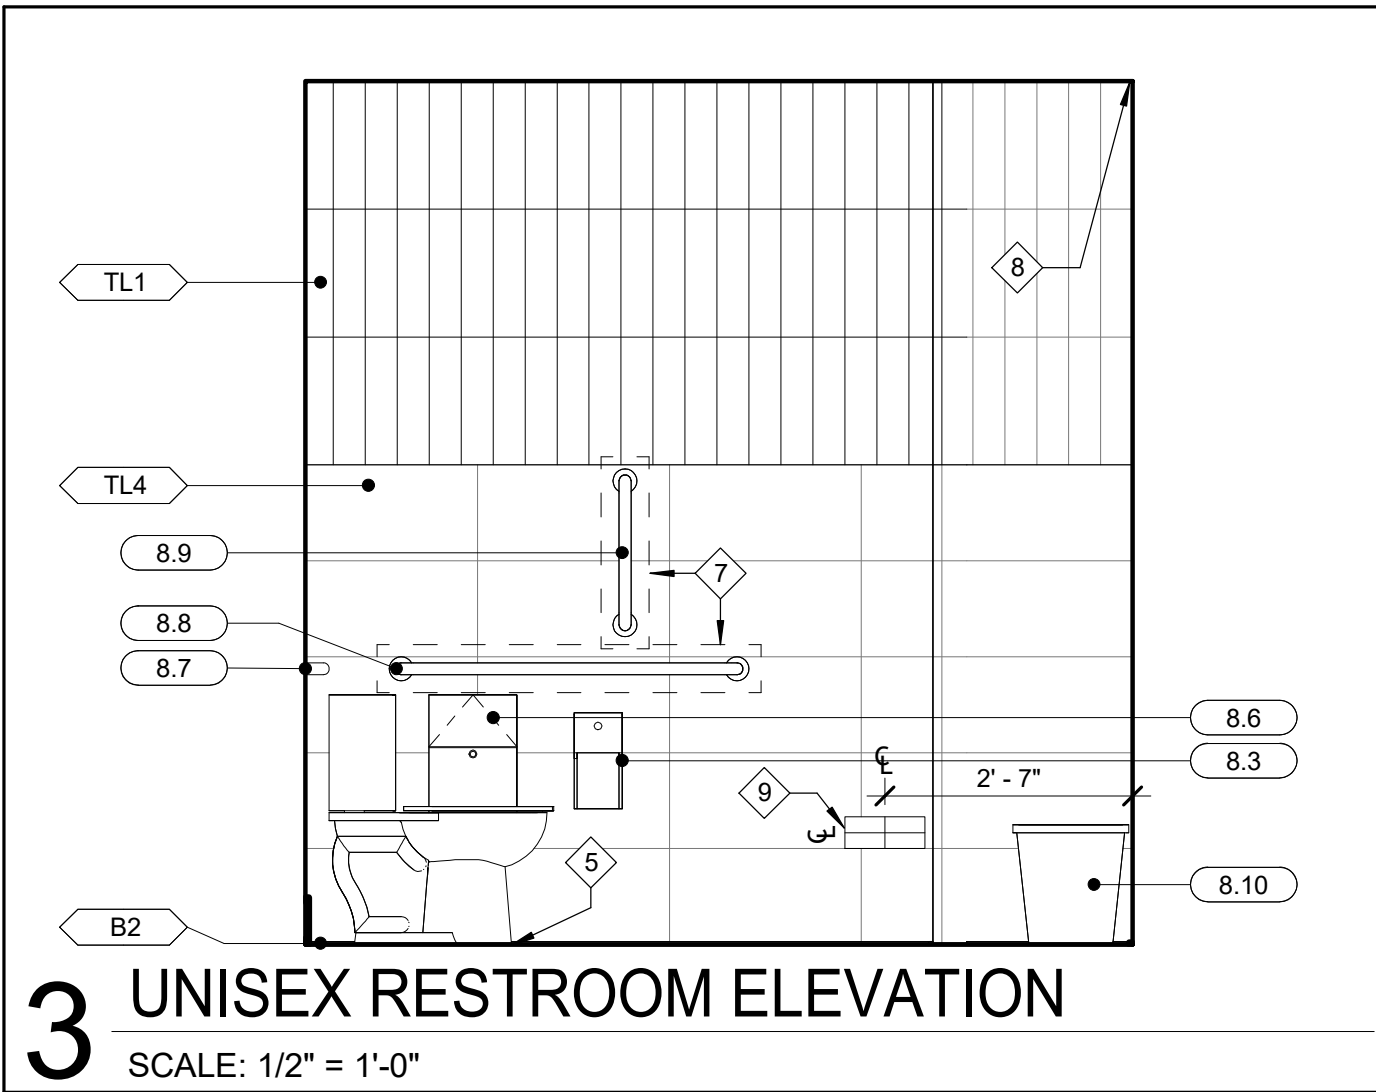

3 UNISEX RESTROOM ELEVATION
SCALE: 1/2" = 1'-0"

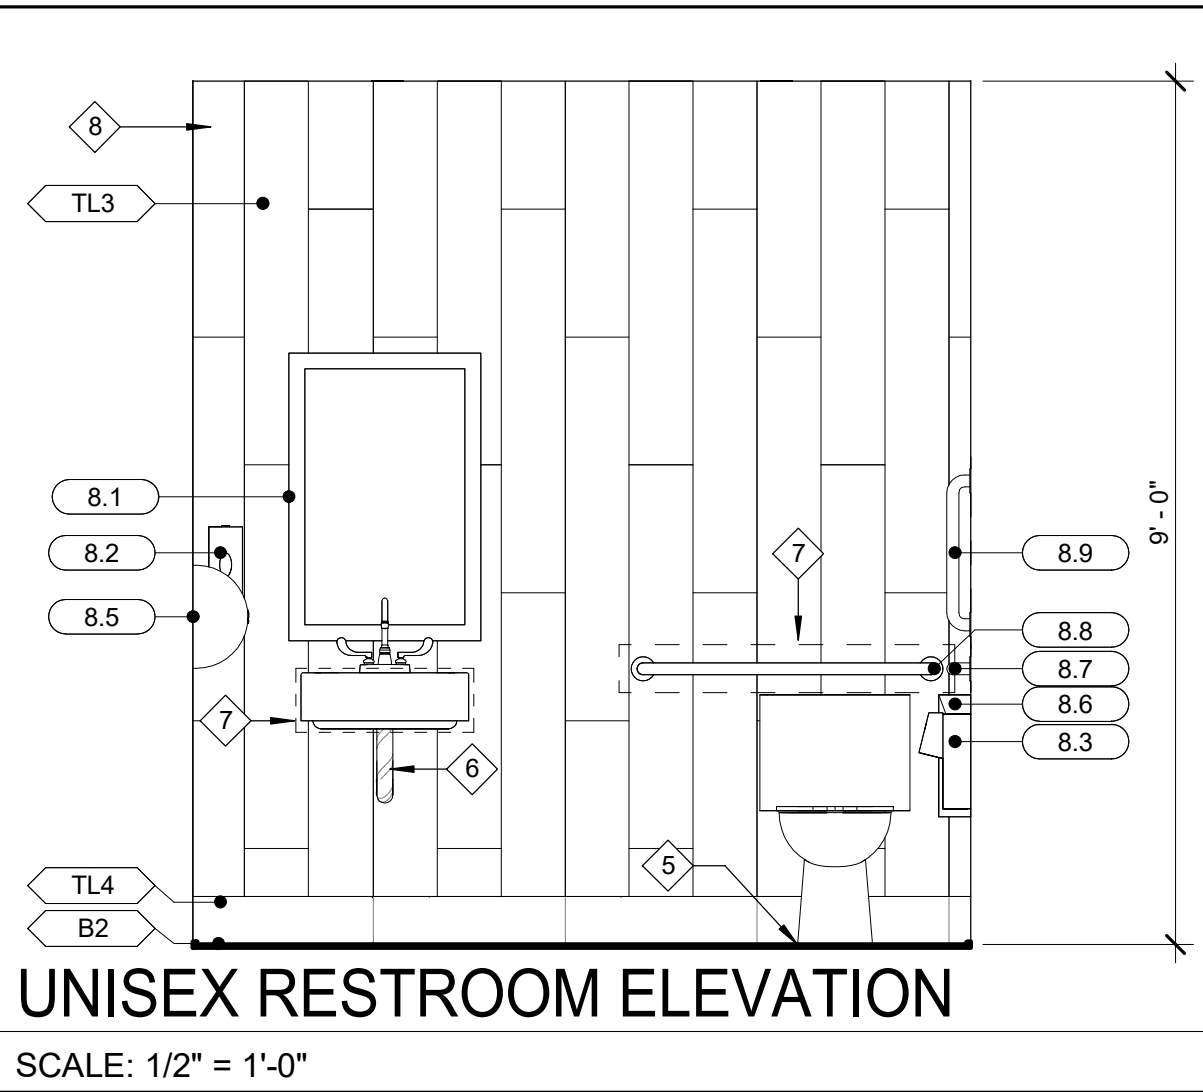

4 UNISEX RESTROOM ELEVATION
SCALE: 1/2" = 1'-0"

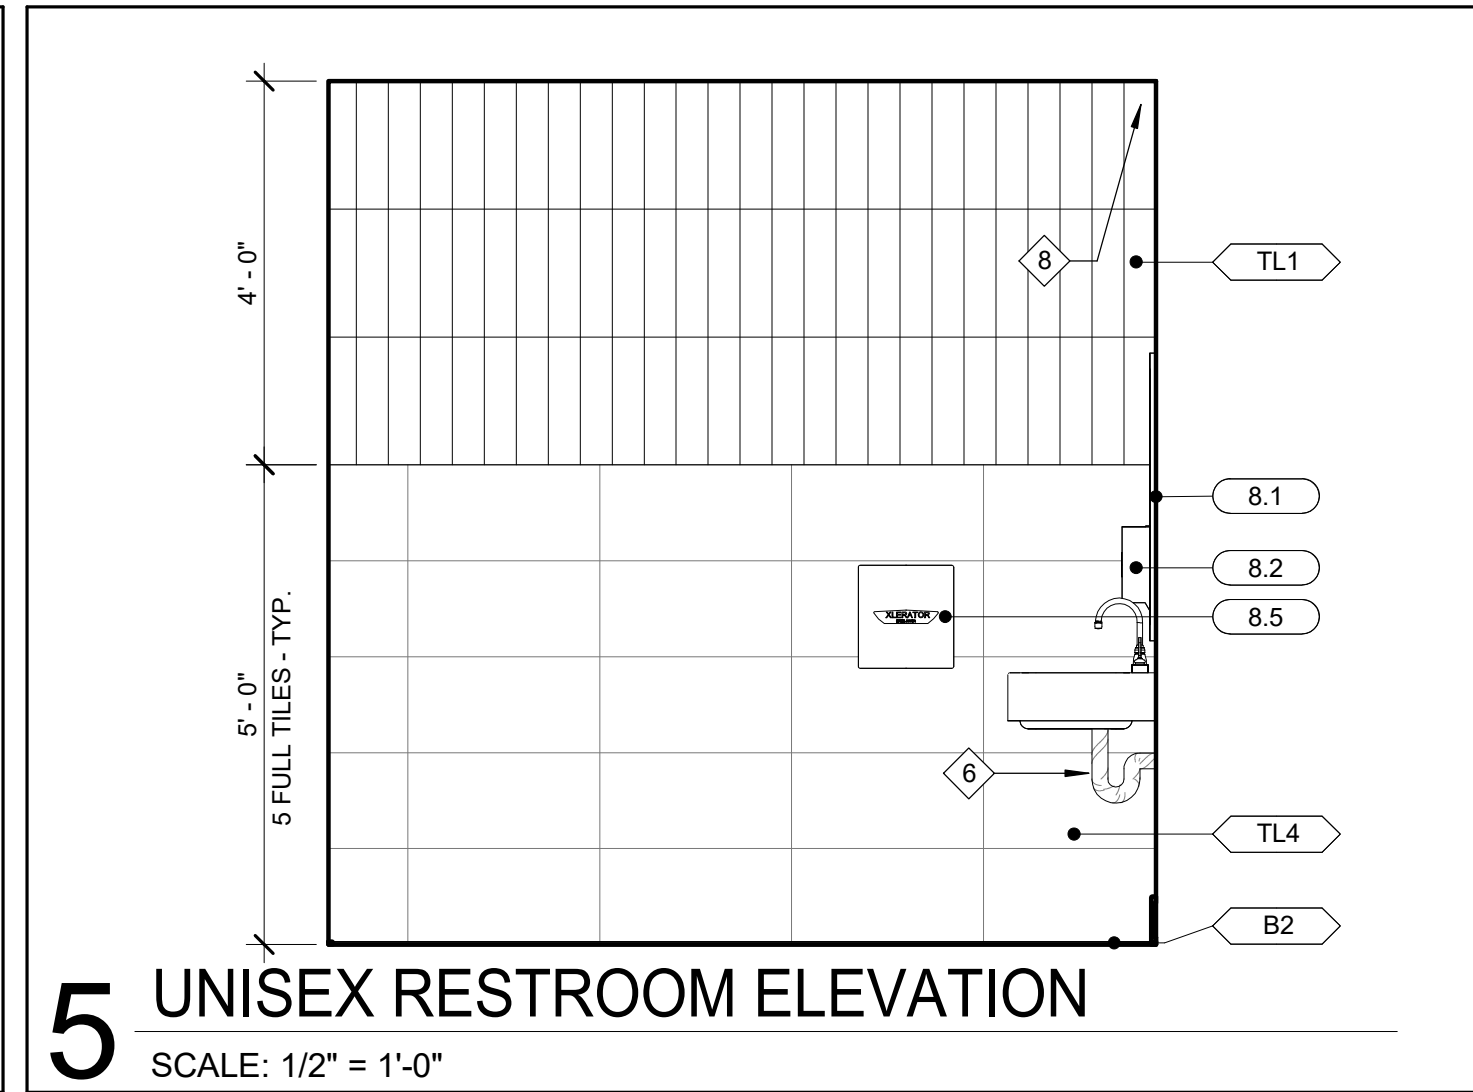

5 UNISEX RESTROOM ELEVATION
SCALE: 1/2" = 1'-0"

CONSULTANT



THESE DRAWINGS, IDEAS, SPECIFICATIONS AND DESIGNS ARE EXCLUSIVE PROPERTY OF WINGSTOP RESTAURANTS, INC. NO PART OF THESE DRAWINGS MAY BE COPIED, REPRODUCED, OR OTHER STRUCTURES BUILT FROM SUCH WITHOUT THE WRITTEN CONSENT OF WINGSTOP RESTAURANTS, INC.


COPYRIGHT © 2025 WINGSTOP RESTAURANTS, INC. ALL RIGHTS RESERVED

PROJECT INFORMATION

WINGSTOP (GL#A216)

THE AUGUSTA ON GEORGIA
3831 GEORGIA AVENUE NW
WASHINGTON, D.C. 20009

SEAL

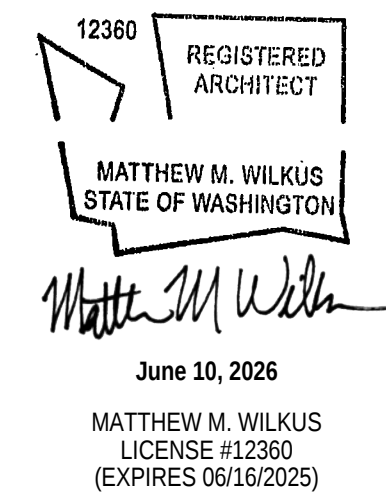

PROJECT NO. 2025-0430
DRAWN BY ANC
CHECKED BY JSS

ISSUE DATE
DESIGN INTENT REVIEW 2026/03/30
PERMIT SET 2026/06/10

REVISION DATE

NG_DELCO_2025.02

TITLE ENLARGED RESTROOM AND ELEVATIONS

SHEET NUMBER A2.2

FINISH GENERAL NOTES	
A.	INTERIOR FINISHES TO HAVE FLAME SPREAD RATING AND SMOKE DEVELOPED INDEX TO MEET APPLICABLE CODES. REFER TO CODE INFORMATION FOR ADDITIONAL INFORMATION.
B.	REFER TO INTERIOR ELEVATIONS, REFLECTED CEILING PLANS, AND DETAILS FOR ADDITIONAL INFORMATION.
C.	REMOVAL OF EXCESS GROUT WILL BE DONE WITH WATER. THE USE OF SULFURIC OR MURIATIC ACID IS PROHIBITED.
D.	PROVIDE CEMENT BOARD SHEATHING AS REQUIRED AT WALL TILE LOCATIONS AND EXTENTS. VERIFY AND COORDINATE ACCEPTABLE SHEATHING MATERIAL WITH SUPPLIER/MANUFACTURER OF TILE PRIOR TO INSTALLATION.
E.	IT IS THE INTENT OF THE DRAWINGS THAT EXPOSED SURFACES TO RECEIVE FINISHES AS INDICATED ON THE DRAWINGS, UNLESS NOTED OTHERWISE. ANY SURFACE WHICH DOES NOT HAVE A FINISH NOTED SHALL BE BROUGHT IMMEDIATELY TO THE ARCHITECTS ATTENTION FOR CLARIFICATION.
F.	ALL MATERIALS TO BE INSTALLED PER MANUFACTURERS SPECIFICATIONS AND RECOMMENDATIONS.
G.	NO SUBSTITUTIONS ARE ALLOWED WITHOUT ARCHITECT AND CLIENT'S WRITTEN APPROVAL.
H.	ALL MATERIALS SPECIFIED ARE AVAILABLE AS OF ORIGINAL DATE ON PLAN. THE ARCHITECT IS NOT RESPONSIBLE FOR ANY MATERIALS ORDERED AFTER THIS DATE THAT ARE DISCONTINUED OR UNAVAILABLE. ANY SUBSTITUTIONS MUST BE REVIEWED AND APPROVED IN WRITING BY THE ARCHITECT AND CLIENT.
I.	GYPSUM BOARD TO BE FINISHED TO A CLASS 4 FINISH.
J.	KITCHEN SPACES SHALL HAVE A WASHABLE ACOUSTICAL CEILING TILE SURFACE (WHITE).
K.	ALL 1x WOOD TRIM AS NOTED SHALL BE OF A CLEAR, MODIFY STAIN GRADE PINE.
FLOOR COVERING NOTES	
A.	GENERAL CONTRACTOR SHALL BE RESPONSIBLE FOR PROVIDING A CLEAN CLEAR FLOOR FREE OF HOLES AND/OR DEPRESSIONS AND ACCEPTABLE FOR INSTALLATION OF FLOOR COVERINGS AND UNDER-LAYMENTS. ANY DISCREPANCIES SHALL BE IMMEDIATELY REPORTED TO THE ARCHITECT AND OWNER.
B.	INSTALLER SHALL BE RESPONSIBLE FOR QUANTITY TAKE-OFF, SUPPLYING, RECEIVING, WAREHOUSING AND INSPECTING OF FLOOR COVERINGS AND UNDER-LAYMENTS PRIOR TO FABRICATION AND/OR INSTALLATION. DISCREPANCIES SHALL BE IMMEDIATELY REPORTED TO THE GENERAL CONTRACTOR.
C.	PRIOR TO INSTALLATION OF ANY FLOOR FINISH, CHECK SURFACE MATERIAL TO ENSURE STRUCTURAL INTEGRITY, ABSOLUTE DRYNESS AND THOROUGHLY CLEAN. REMOVE TRACES OF DIRT, DUST, LOOSE FIBERS, OIL, GREASE, ETC.
D.	TILE TO BE INSTALLED PER TILE COUNCIL OF NORTH AMERICA STANDARDS.
E.	WALL TILE AND THRESHOLD GROUT JOINTS TO ALIGN WITH FLOOR GROUT JOINTS.
F.	FLOOR MATERIAL CHANGES TO OCCUR AT DOOR CENTERLINES UNLESS NOTED OTHERWISE.
PAINT NOTES	
A.	SURFACES RECEIVING PAINT TO BE PROPERLY PREPARED AND READY TO RECEIVE PAINT IN ACCORDANCE WITH MANUFACTURERS PRINTED INSTRUCTIONS. WALL TO BE FINISHED (MINIMUM 3 COATS, SANDED AND PRIMED). SURFACES SHALL BE CLEAN, FREE OF DUST, GREASE, OILS AND FOREIGN SUBSTANCES THAT WILL INTERFERE WITH PAINT.
B.	HOLES, CRACKS AND OTHER IMPERFECTIONS SHALL BE SUITABLY PATCHED AND FILLED WITH A COMPOUND RECOMMENDED BY THE MANUFACTURER OF THE PAINT AND THEN PRIMED. SURFACES SHALL BE BROUGHT TO TRUE, EVEN SURFACES PRIOR TO PAINTING.
C.	ADEQUATE NUMBER OF PRIMER AND FINISH COATS TO BE APPLIED TO COMPLETE COVERAGE.
D.	APPLY PAINT IN ACCORDANCE WITH MANUFACTURERS DIRECTION. USE APPLICATIONS AND TECHNIQUES BEST SUITED FOR THE TYPE OF MATERIAL BEING APPLIED. APPLY EACH MATERIAL AT NOT LESS THAN THE MANUFACTURERS RECOMMENDED SPREADING RATE.
E.	METAL DOOR JAMBS TO THE PAINTED SEMI-GLOSS.
F.	NEW PAINT/STAINED WOOD SURFACES TO BE CLEANED OF DIRT, OIL AND OTHER FOREIGN SUBSTANCES WITH SCRAPPERS, MINERAL SPIRITS AND SANDPAPER AS REQUIRED. SANDPAPER SMOOTH THOSE FINISHED SURFACES EXPOSED TO VIEW, AND DUST OFF. SCRAPE AND CLEAN KNOTS AND APPLY THIN COATS OF CLEAR SHELLAC BEFORE APPLICATION OF PRIME COAT. AFTER PRIMING, FILL WITH PUTTY OR PLASTIC WOOD FILLER AND SANDPAPER SMOOTH WHEN DRY.
G.	REMOVE MISAPPLIED PAINT FROM ADJACENT SURFACES. DISPOSE OF EXCESS MATERIALS OFF JOB SITE.
H.	PAINT SUBSTITUTIONS ARE NOT ALLOWED.
I.	ADDITIONAL PAINT SHALL BE PROVIDED FOR FUTURE OWNER USE - THREE (3) GALLONS MINIMUM OF EACH MATERIAL.
J.	PAINT METAL ACCESS DOORS AND PANELS TO MATCH ADJACENT WALL OR CEILING FINISH. GRAPHICS ON DOORS OR PANELS, IF ANY, ARE TO BE APPLIED AFTER ADJACENT SURFACES HAVE BEEN FINISHED.
K.	FINISHES TO MEET N.F.P.A. 101, LIFE SAFETY CODE SECTION 263.3 - INTERIOR FINISHES.
L.	GENERAL CONTRACTOR SHALL EXAMINE AREAS OF CONSTRUCTION AFTER COMPLETE WORK BY TRADES AND INDICATE NECESSARY "TOUCH UP" PAINTING AND/OR PATCHING LOCATIONS.
M.	BEFORE PAINTING OR FINISHING WORK IS TO BEGIN, ARRANGEMENTS SHALL BE MADE FOR PROPER VENTILATION AND LIGHTING IN AREAS IMPACTED.
N.	WOOD DOORS AND TRIM TO BE FILLED, STAINED SEALED AND SHOP FINISHED. WORK TO BE PERFORMED IN A DUST FREE ENVIRONMENT.


KEYNOTE LEGEND	
1	REFER TO DETAIL FOR WAINSCOT CONSTRUCTION
2	REFER TO INTERIOR ELEVATIONS FOR WALL COVERING SIZE AND POSITIONING
3	REFER TO INTERIOR ELEVATIONS FOR TOILET ROOM WALL FINISH APPLICATION
4	10" HIGH MOLDED STONE BASIN AROUND MOP SINK - REFER TO DETAIL
5	NO FLOORING BELOW FREEZER - COORDINATE EXACT LOCATION WITH WALK-IN MANUFACTURERS SHOP DRAWINGS
6	CONCRETE SLAB
7	TILE STARTING POINT - START WITH FULL TILE

FINISH SCHEDULE				
MARK	DESCRIPTION	MANUFACTURER	STYLE / COLOR	PATTERN / NOTES
PAINT				
PT1	WALL PAINT	SHERWIN WILLIAMS	#SW7065 ARGOS	PROMAR 200 ZERO VOC, SEMI-GLOSS FINISH
PT2	WALL PAINT	SHERWIN WILLIAMS	#SW6258 TRICORN BLACK	PROMAR 200 ZERO VOC, SEMI-GLOSS FINISH
PT3	WALL PAINT	SHERWIN WILLIAMS	#SW6203 SPARE WHITE	PROMAR 200 ZERO VOC, SEMI-GLOSS FINISH
PT4	WALL PAINT	SHERWIN WILLIAMS	CUSTOM COLOR #2016 WINGSTOP GREEN	PROMAR 200 ZERO VOC, SEMI-GLOSS FINISH
SOLID SURFACE				
SS1	1/2" SOLID SURFACING	AVONITE	#7842 NEW CONCRETE	-
PLASTIC LAMINATE				
PL1	PLASTIC LAMINATE	FORMICA	#ASHWOOD BEIGE 5785-NG	STANDARD FINISH
PL2	PLASTIC LAMINATE	FORMICA	#BLACKENED LEGNO 8848-58	STANDARD FINISH
TILE				
TL1	4" X 16" GLAZED CERAMIC TILE	CREATIVE MATERIALS	AGELESS #GREY 04 GLOSSY	VERTICAL STACKED BOND INSTALLATION, MAPEI #27 SILVER GROUT (1/16" GROUT LINES)
TL2	4" X 16" GLAZED CERAMIC TILE	CREATIVE MATERIALS	CUSTOM GREEN	STACKED BOND INSTALLATION, MAPEI #27 SILVER GROUT (1/16" GROUT LINES)
TL3	8" X 48" PORCELAIN TILE	CREATIVE MATERIALS	PRESERVE #PINE MATTE	1/3 OFFSET INSTALLATION, MAPEI #04 BAHAMA BEIGE GROUT (1/8" GROUT LINES)
TL4	12" X 24" PORCELAIN TILE	CREATIVE MATERIALS	CONTEMPO #BLACK MATTE	STACKED BOND INSTALLATION, MAPEI #47 CHARCOAL (1/8" GROUT LINES) - CUT TILE IN HALF LENGTHWISE FOR 6" BASE
WALL CLADDING				
WP1	WALL CLADDING	AM-CLAD	CUSTOM DIAGONAL BLACK	WITH BLACK ANODIZED TRIM - SILICONE MOLDINGS/TRIMS TO WALL PANEL WITH COLORED SILICONE TO MATCH PANELS
WP2	WALL CLADDING (FRP)	AM-CLAD	CUSTOM WHITE TILE-LOOK	WITH ANODIZED TRIM - SILICONE MOLDINGS/TRIMS TO WALL PANEL WITH COLORED SILICONE TO MATCH PANELS
WP3	WALL CLADDING (FRP)	AM-CLAD	2.5 MM WHITE SMOOTH SATIN FINISH	WITH ANODIZED TRIM
M1	STAINLESS STEEL PANELING	KITCHEN EQUIPMENT VENDOR	20 GAUGE 430 STAINLESS STEEL, SMOOTH SURFACE	INSTALLED BY G.C., ADDITIONAL PANELS AT SINKS PROVIDED BY G.C.
BASE / WALL / WAINSCOT TRIM				
TR1	WAINSCOT TRIM WITH LED LIGHTING	MILLWORK VENDOR	3/4" X 4" BLACK PVC	-
TR2	METAL TRIM	SCHLUTER SYSTEMS	SCHIENE PROFILE #SATIN ANODIZED ALUMINUM	FOR USE AT OUTSIDE TILE EDGES
B1	6" VINYL WALL BASE	CREATIVE MATERIALS	SIMPLICITY #BLACK	WITH 45 DEGREE MITERED CORNERS
B2	3/8" METAL COVE WALL BASE	SCHLUTER SYSTEMS	DILEX-AHK PROFILE #SATIN ANODIZED ALUMINUM	TO BE USED IN TOILET ROOMS
B3	COVED TILE BASE	CREATIVE MATERIALS	NIMBLE OBIDOS DIAMOND ANTISLIP	-
KITCHEN FLOORING				
F1	8" x 8" PORCELAIN TILE WITH MATCHING 4" x 8" SIT IN COVE BASE	CREATIVE MATERIALS	NIMBLE OBIDOS DIAMOND ANTISLIP	STACKED BOND INSTALLATION, MAPEI #47 CHARCOAL (1/8" GROUT LINES)
CEILING				
C1	24" X 24" LAY-IN CEILING TILES	PRELUDE PLUS GRID SYSTEM	FINE FISSURED #1728, COLOR: BLACK W/ BLACK GRID	-
C2	24" X 48" LAY-IN CEILING TILES	PRELUDE PLUS GRID SYSTEM	CLEAN ROOM VL #870, COLOR: WHITE	-
C3	GYPSUM BOARD	-	PAINT PT3	-
C4	OPEN CEILING	-	PAINT PT2	-

CONTACTS LISTED BELOW ARE FOR WINGSTOP RESTAURANTS, INC. NATIONAL ACCOUNTS. GENERAL CONTRACTOR IS RESPONSIBLE TO ORDER USING RESPECTIVE ORDER FORMS IN ORDER TO RECEIVE WRI NEGOTIATED PRICING.

CREATIVE MATERIALS CORPORATION
WINGSTOP@CREATIVEMATERIALSCORP.COM
(800) 207-2967 EXT. STOP (7867)

AM-CLAD
WRI@AM-CLAD.COM

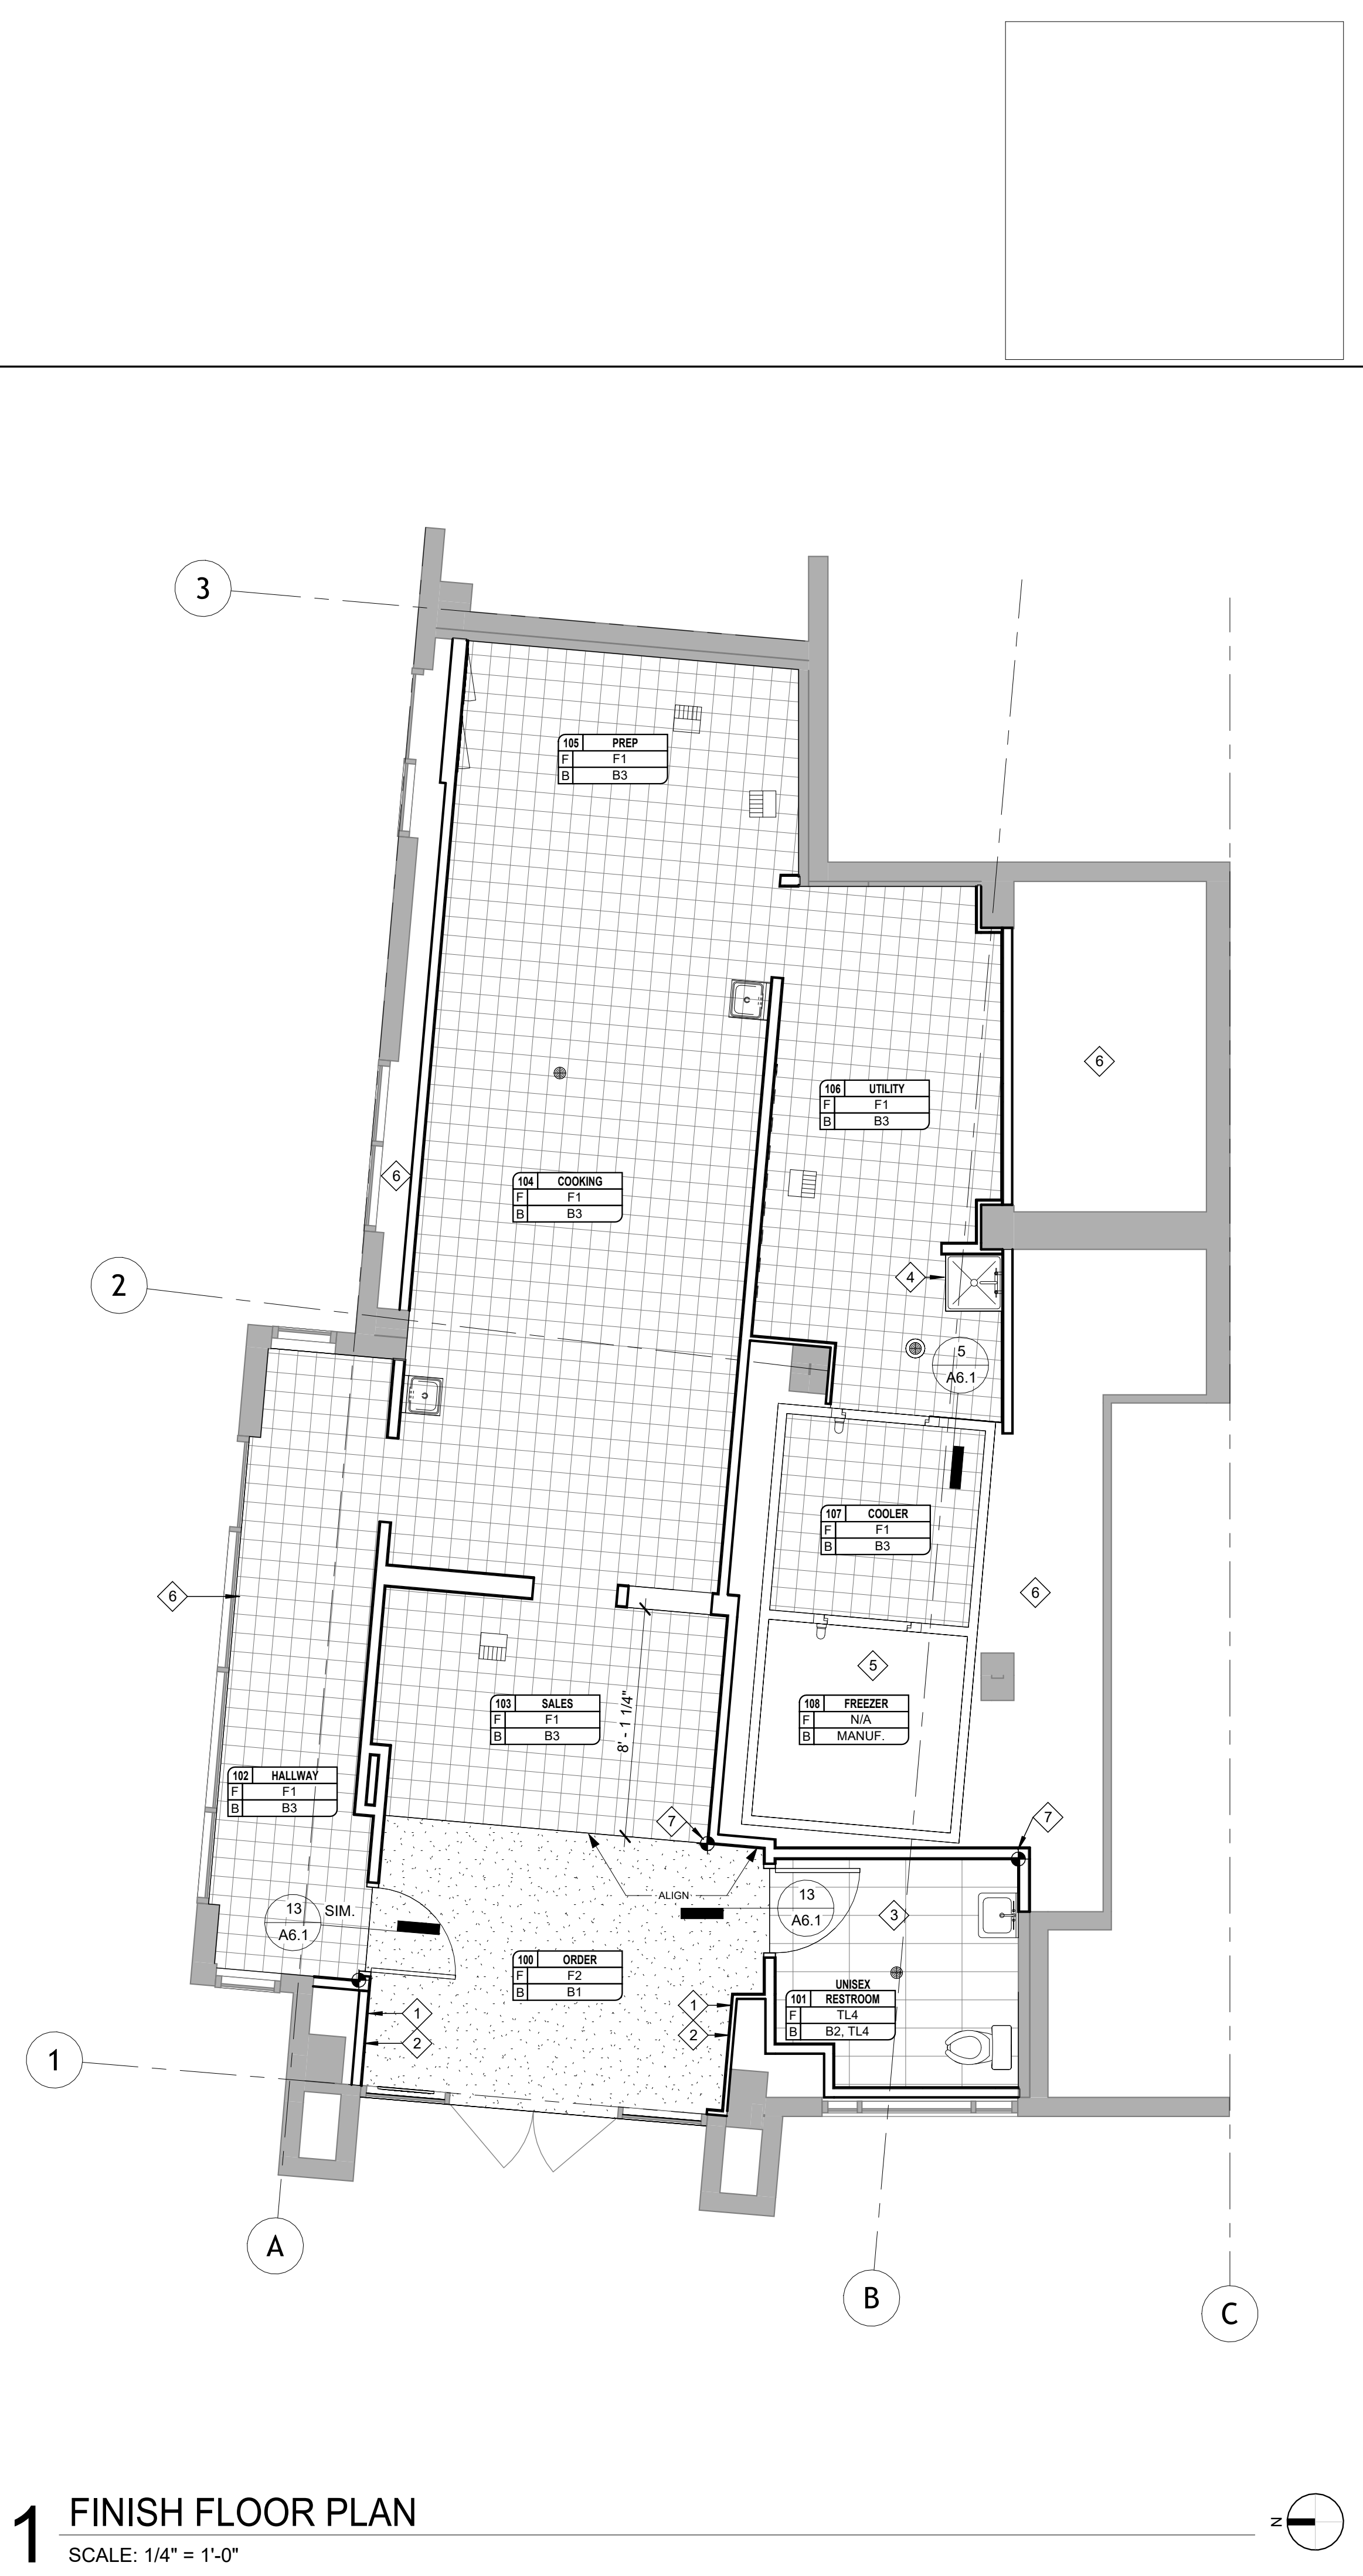

1 FINISH FLOOR PLAN
SCALE: 1/4" = 1'-0"

CONSULTANT



2801 NORTH CENTRAL EXPRESSWAY, SUITE 1600
DALLAS, TX 75204
TELEPHONE: (972) 686-6500
FAX: (972) 686-6502

THESE DRAWINGS, IDEAS, SPECIFICATIONS AND DESIGNS ARE EXCLUSIVE PROPERTY OF WINGSTOP RESTAURANTS, INC. NO PART OF THESE DRAWINGS MAY BE COPIED, REPRODUCED, OR OTHER STRUCTURES BUILT FROM SUCH WITHOUT THE WRITTEN CONSENT OF WINGSTOP RESTAURANTS, INC.

COPYRIGHT © 2025
WINGSTOP RESTAURANTS, INC.
ALL RIGHTS RESERVED

PROJECT INFORMATION

WINGSTOP
(GL#A216)
THE AUGUSTA ON GEORGIA
3831 GEORGIA AVENUE NW
WASHINGTON, D.C. 20009

SEAL

12360 REGISTERED ARCHITECT
MATTHEW M. WILKUS
STATE OF WASHINGTON
June 10, 2026
MATTHEW M. WILKUS
LICENSE #12360
(EXPIRES 06/16/2025)

PROJECT NO. 2025-0430
DRAWN BY ANC
CHECKED BY JSS

ISSUE DATE
DESIGN INTENT REVIEW 2026/03/30
PERMIT SET 2026/06/10


REVISION DATE

NG_DELCO_2025.02

TITLE
FINISH PLAN

SHEET NUMBER
A2.3

RCP GENERAL NOTES	
A.	REFER TO ELECTRICAL LIGHTING PLAN FOR ADDITIONAL INFORMATION, SUCH AS LIGHT FIXTURE SCHEDULE, EXIT SIGNAGE, EMERGENCY LIGHTING, CIRCUITING, LIGHTING CONTROLS, SHATTER RESISTANT BULBS, ETC. WHERE CONFLICTS BETWEEN ARCHITECTURAL AND ELECTRICAL OCCUR, PLACE LIGHTS PER ARCHITECTURAL DRAWINGS. NOTIFY ARCHITECT OF ANY DISCREPANCIES.
B.	REFER TO MECHANICAL PLANS FOR ALL SUPPLY AIR, RETURN AIR, EXHAUST, AND VENTILATION REQUIREMENTS.
C.	ACOUSTICAL TILE CEILINGS SHOULD BE CENTERED IN THE ROOM, UNLESS NOTED OTHERWISE.
D.	ALIGN FIXTURES IN BOTH DIRECTIONS (LAY OUT GRIDS SO THAT ALIGNMENTS ARE CONSISTENT).
E.	CENTER LIGHTS, ELECTRICAL, MECHANICAL DEVICES, AND SPRINKLER HEADS IN ACOUSTIC TILE CEILING GRIDS, UNLESS NOTED OTHERWISE.
F.	EMERGENCY SIGNS, EMERGENCY LIGHTS, FIRE ALARM, HORNS, STROBES, AND SIMILAR FIXTURES SHALL BE ALIGNED OR CENTERED ON WALLS, DOORS/WINDOWS, OR OTHER CONSTRUCTION BELOW, UNLESS NOTED OTHERWISE. COORDINATE WITH ARCHITECT.
G.	SOUND SYSTEM SHALL BE COORDINATED WITH CLIENT AND VENDOR.
H.	CEILING HEIGHTS ARE MEASURED FROM FINISHED FLOOR TO FINISHED CEILING.
I.	COORDINATE ALL DEVICES REQUIRING ACCESS IN NON-ACCESSIBLE CEILINGS AND PROVIDE ACCESS PANELS AS NEEDED. IF ACCESS PANELS ARE REQUIRED, COORDINATE LOCATIONS AND TYPES WITH ARCHITECT.
J.	ELECTRICAL CONTRACTOR TO VERIFY LOCATIONS OF WALL MOUNTED J-BOXES FOR CLOCK OUTLETS WITH OWNER PRIOR TO INSTALLATION.
K.	GENERAL CONTRACTOR TO PAINT ALL GYPSUM BOARD CEILINGS AND SOFFITS.
L.	ELECTRICAL CONTRACTOR TO DIRECT LIGHTS (TRACK AND RECESSED) TO ILLUMINATE CENTER OF DECOR ITEMS, SEE DECOR ELEVATIONS FOR ADDITIONAL INFORMATION.
M.	PROVIDE SHIELDED LIGHT FIXTURES OVER FOOD PREPARATION, SERVICE, FOOD STORAGE, STORAGE, AND UTENSIL WASHING AREAS.
N.	CAULK CEILING TO WALL WITH PAINTABLE CAULK.
O.	SHOP PAINT DIFFUSERS TO MATCH THE COLOR OF ADJACENT SURFACE. NOTIFY ARCHITECT IMMEDIATELY IF ANY ARE IN QUESTION. DIFFUSERS IN LAY-IN CEILING AREA OF KITCHEN ARE TO BE STANDARD WHITE ALUMINUM.
P.	INSTALLED ITEMS ABOVE THE CEILING SHALL BE PLENUM RATED.
Q.	GENERAL CONTRACTOR TO PROVIDE AND INSTALL EMERGENCY EGRESS LIGHTING AT EACH DOOR ALONG EGRESS ACCESS PATH OF TRAVEL AS REQUIRED BY LOCAL CODE. ORDINANCE OR LAW.
R.	EMERGENCY LIGHTING TO PROVIDE FIRE CODE AVERAGE ALONG PATH OF EGRESS TRAVEL AT FLOOR AS REQUIRED BY LOCAL CODE, ORDINANCE OR LAW.
S.	EXPOSED MECHANICAL (i.e. DUCTWORK, UNISTRUT, ETC.), EXPOSED ELECTRICAL (i.e. CONDUIT, UNISTRUT, ETC.), EXPOSED STRUCTURAL (i.e. STEEL JOISTS, STEEL BEAMS, ETC.), METAL ROOF DECK, PIPING, CABLE TRAYS, ETC. SHALL BE PAINTED TO MATCH THE PAINTED FINISH OF THE STRUCTURE WITH SPECIFIED PAINT COLOR AS LISTED.
T.	GENERAL CONTRACTOR SHALL ENSURE CLEARANCE FOR LIGHT FIXTURES, DUCTS, FIRE SPRINKLERS, ETC. SHOULD ANY OBSTRUCTION OCCUR THAT PREVENTS INSTALLATION OF ANY REQUIRED COMPONENT, NOTIFY ARCHITECT PRIOR TO INSTALLATION OF CEILING GRID. INSTALLATION WITHOUT APPROVAL SHALL BE REMOVED AND REINSTALLED PER DIRECTION OF ARCHITECT AT GENERAL CONTRACTORS SOLE EXPENSE.
U.	WALL AND SOFFIT ASSEMBLY CONSTRUCTION TO BE INSTALLED TO FIT/TIGHT AROUND ROOF FRAMING MEMBERS, UNLESS NOTED OTHERWISE.
V.	COORDINATE CEILING SUSPENSION SYSTEMS WITH OTHER EQUIPMENT IN CEILING REQUIRING SUPPORT.
W.	FOR AIR CONDITIONING, EXHAUST & SUPPLY FANS, HVAC & REFRIGERATION EQUIPMENT CURBS, GENERAL CONTRACTOR SHALL PROVIDE AND INSTALL SUITABLE BLOCKING IN WALLS AND CEILINGS TO SUPPORT FIXTURES, EQUIPMENT AND CANOPIES.
X.	FOR EXHAUST HOODS, PROVIDE PRODUCT DATA AND PROCESS SPECIFIED DURING FABRICATION, FINISHING AND INSTALLATION. PROVIDE SHOP DRAWINGS SHOWING DIMENSIONED PLANS AND ELEVATIONS, LARGE SCALE DETAILS, ATTACHMENT DEVICES AND OTHER COMPONENTS.
Y.	GENERAL CONTRACTOR SHALL COORDINATE WITH ELECTRICAL CONTRACTOR TO FURNISH AND INSTALL ELECTRICAL CIRCUIT INCLUDING CONDUIT, WIRE CONNECTIONS AND BREAKERS AT PANEL BOARD NECESSARY TO SERVE PROPOSED SIGNAGE. VERIFY EXTENTS WITH OWNER.
Z.	SIGNAGE CONTRACTOR TO PERMIT, SUPPLY AND INSTALL SIGNAGE SEPARATE FROM THIS CONSTRUCTION DOCUMENT PACKAGE. SIGNAGE CONTRACTOR TO VERIFY SIGNAGE COMPLIANCE WITH LOCAL CODES AND OBTAIN APPROVAL, UNDER A SEPARATE PERMIT, AND VERIFY LANDLORD APPROVALS AS REQUIRED.
AA.	COORDINATE FIRE SPRINKLER HEAD LOCATIONS WITH ARCHITECT VIA SHOP DRAWINGS.
AB.	MODIFICATIONS TO THE FIRE SUPPRESSION SYSTEM FOR THE AREA OF WORK SHALL BE PER SPRINKLER CONTRACTOR. ENGINEERED AUTOMATIC FIRE SPRINKLER SYSTEM PLANS, CALCULATIONS, AND SPECIFICATIONS SHALL BE DESIGNED BY AN APPROVED INSTALLER AND SUBMITTED TO THE LOCAL AUTHORITY HAVING JURISDICTION PRIOR TO ANY WORK BEING COMPLETED TO THE SYSTEM.
AC.	PROVIDE AND INSTALL SEISMIC BRACING FOR CEILING SYSTEMS AND OTHER SUSPENDED FIXTURES AS NECESSARY.

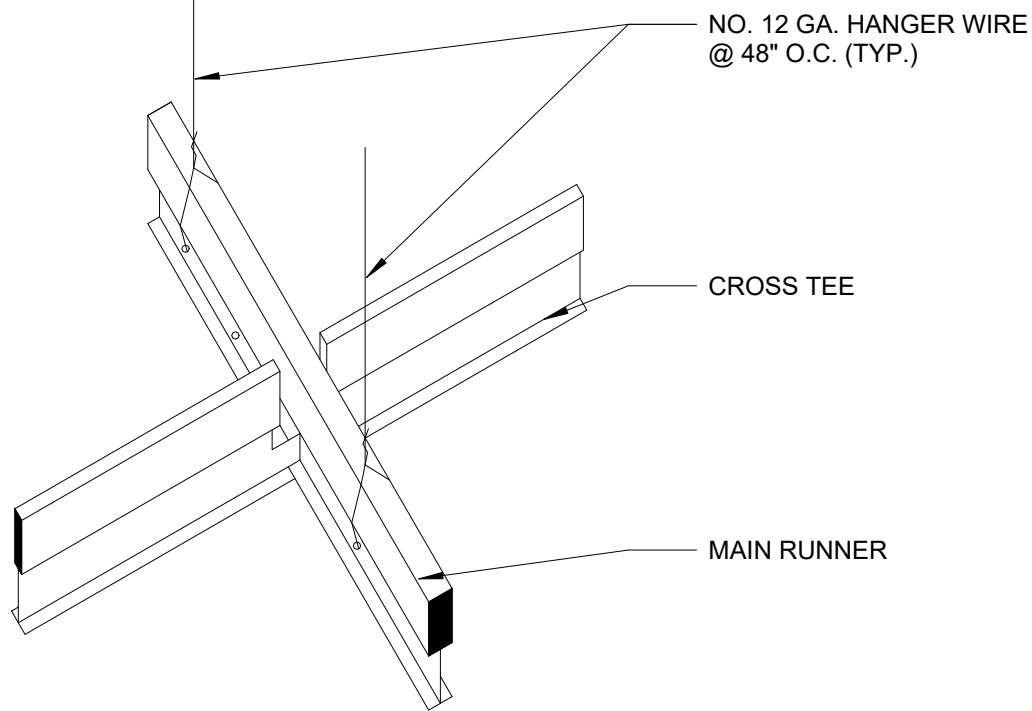

2 SUSPENDED CEILING DETAIL


SCALE: 1/4" = 1'-0"

KEYNOTE LEGEND	
1	INSTALL ALL WALL MOUNTED LCD/TV OUTLET - REFER TO A WALL MOUNTED BRACKET DETAIL - TYP.
2	TRACK LIGHTING (BLACK) - ALIGN WITH PAINT TRANSITION LINE
3	CEILING GRID STARTING POINT
4	PROPOSED SPEAKER LOCATIONS - PROVIDED BY OWNER, SUPPLIED BY APPROVED VENDOR, AND COORDINATED BY GC
5	MENU BOARD - MOUNT BOTTOM OF MENU BOARD AT 7'-0" A.F.F. - REFER TO ELEVATION FOR ADDITIONAL INFORMATION
6	DECORATIVE HALO LIGHT - SEE ELECTRICAL DRAWINGS FOR ADDITIONAL INFORMATION
7	EXTERIOR SIGNAGE LOCATION - EXTERIOR SIGNAGE TO BE PROVIDED, PERMITTED, INSTALLED, AND INSPECTED UNDER A SEPARATE PERMIT - COORDINATE WITH SIGNAGE VENDOR
8	PROTECT EXISTING FIRE SUPPRESSION SYSTEM TO REMAIN - ADJUST AS REQUIRED TO MEET CONSTRUCTION CONDITIONS AND CODE REQUIREMENTS - REVISIONS TO SYSTEM TO BE PROVIDED, REVIEWED, INSTALLED, AND INSPECTED THROUGH A DEFERRED SUBMITTAL
9	PROVIDE STAINLESS STEEL CLOSURE TRIM BETWEEN PERIMETER OF HOOD AND ADJACENT WALLS AS REQUIRED
10	NOT USED
11	EXISTING ROOF ASSEMBLY CONSTRUCTION NOT SHOWN FOR CLARITY - PAINT
12	COORDINATE CEILING/ROOFING PENETRATIONS AS REQUIRED WITH DRAWINGS BY OTHERS - FIRESTOP PENETRATIONS AS REQUIRED
13	DUCTWORK SHOWN FOR REFERENCE PURPOSES ONLY - REFER TO MECHANICAL DRAWINGS FOR ADDITIONAL INFORMATION
14	NEW EXPOSED DUCTWORK AND DIFFUSERS TO BE INSTALLED BETWEEN AND THROUGH EXISTING ROOF STRUCTURE - PAINTED PT2 - REFER TO MECHANICAL DRAWINGS FOR ADDITIONAL INFORMATION
15	LED STRIP LIGHTING ABOVE SOFFIT - REFER TO DETAIL AND ELECTRICAL DRAWINGS FOR ADDITIONAL INFORMATION
16	LIGHTING FOR FREEZER/COOLER UNIT PROVIDED BY FREEZER/COOLER MANUFACTURER - GENERAL CONTRACTOR TO PROVIDE ROUGH-IN AND FINAL HOOK-UP
17	PVC PIPES ABOVE CEILING FOR SODA BUNDLE - COORDINATE WITH SODA DISPENSER MANUFACTURER

LIGHTING FIXTURE LEGEND				
MARK	SYMBOL	SPECIFICATIONS	MOUNTING HEIGHT	NOTES
L1		48" LINEAR LED PENDANT MANUFACTURER: ELITE LIGHTING	MOUNT LIGHTING AT 11'-6"	
L2		24" WALL WASH TRACK LIGHT MANUFACTURER: JUNO	MOUNT LIGHTING AT 11'-6"	DIRECT TRACK HEADS TO ILLUMINATE DECOR ITEMS
L3		LED TAPE LIGHT - WHITE LIGHT MANUFACTURER: ATTAINED	LIGHTING INTERGRATED WITH SALES COUNTER MILLWORK, MOUNTED ON THE UNDERSIDE OF THE CUSTOMER SIDE OF THE SALES COUNTERTOP OVERHANG SEE DETAILS FOR ADDITIONAL INFORMATION	
L4		LED TAPE LIGHT - GREEN LIGHT MANUFACTURER: ATTAINED	MOUNT LIGHTING ON SALES HEADER AND ABOVE WAINSCOT - SEE DETAILS FOR ADDITIONAL INFORMATION	
L5		2' X 4' LED TROFFER LIGHT W/ ACRYLIC LENS MANUFACTURER: TCP	MOUNT IN ACT CEILING GRID	
L6		4" LED DOWNLIGHT MANUFACTURER: ENVISION	MOUNT IN ACT CEILING GRID OR GYPSUM BOARD CEILING	
L7		LINEAR MENU BOARD WASH MANUFACTURER: ELITE LIGHTING	MOUNT IN ACT CEILING GRID	
SP1		CEILING MOUNTED AUDIO SPEAKERS MANUFACTURER: TBD	MOUNT TO OPEN CEILING WITH SUSPENSION ASSEMBLY	
CH1		LED TAPE LIGHT W/ BLACK ALUMINUM CHANNEL MANUFACTURER: ATTAINED	MOUNT LIGHTING AT WAINSCOT - SEE DETAILS FOR ADDITIONAL INFORMATION	
CH2		LED TAPE LIGHT W/ 45 DEGREE CHANNEL MANUFACTURER: GM LIGHTING	LOCATED AT SALES SOFFIT - NOT SHOWN ON REFLECTED CEILING PLAN - REFER TO DETAIL	
WS-1070		"HALO" CIRCULAR CEILING DECOR W/ LOCALIZED NAMING INTERGRATED INTO DESIGN MANUFACTURER: YELLOW POP	MOUNT TO OPEN CEILING WITH SUSPENSION ASSEMBLY	LOCALIZATION FIXTURE - REFER TO LOCALIZATION INFORMATION ON THE DECOR ELEVATIONS SHEET
EMC		EMERGENCY LIGHT - CEILING MOUNTED	SUPPLIER NOTE: 1. CONTACTS LISTED BELOW ARE FOR WINGSTOP RESTAURANTS, INC. NATIONAL ACCOUNTS. GENERAL CONTRACTOR IS RESPONSIBLE TO ORDER USING RESPECTIVE ORDER FORMS IN ORDER TO RECEIVE WRI NEGOTIATED PRICING. SPECIALTY LIGHTING GROUP TIM MESITE WINGSTOP@SSLIGHTING.COM (860) 767-0110 EXT 236	YELLOW POP STEVEN DRESZER ORDERS@YELLOWPOP.COM (786) 706-0357
EM		EMERGENCY LIGHT - WALL MOUNTED		
EMR		EMERGENCY LIGHT - EXIT ACCESS		

FINISH TYPES - RCP				
MARK	DESCRIPTION	MANUFACTURER	STYLE / COLOR	PATTERN / NOTES
CEILING				
C1	24" X 24" LAY-IN CEILING TILES	PRELUDE PLUS GRID SYSTEM	FINE FISSURED #1728, COLOR: BLACK W/ BLACK GRID; OR APPROVED EQUIVILANT	-
C2	24" X 48" LAY-IN CEILING TILES	PRELUDE PLUS GRID SYSTEM	CLEAN ROOM VL #870, COLOR: WHITE; OR APPROVED EQUIVILANT	-
C3	GYPSUM BOARD	GENERAL CONTRACTOR	PAINT PT3	-
C4	OPEN CEILING	-	PAINT PT2	EVERYTHING ABOVE PAINT TRANSITION LINE - SEE ELEVATIONS ON A4.0 FOR LOCATION

GRAPHIC LEGEND - CEILING PLAN	
	EXISTING WALLS, OR PARTITIONS TO REMAIN - PROTECT - ALL WALL FINISHES TO BE REMOVED AND SURFACE PREPARED TO ACCEPT NEW FINISH MATERIALS AS INDICATED ELSEWHERE IN THE CONSTRUCTION DOCUMENTS
	NEW CONSTRUCTION
	HEADER FOR EXISTING DOOR TO REMAIN. SEE DOOR SCHEDULE FOR HARDWARE MODIFICATIONS
	HEADER FOR NEW DOOR AND FRAME
	DRYWALL CEILING (REFER TO PLAN FOR FURTHER PAINT INFORMATION)
	SUSPENDED CEILING TILES - VINYL FACED GYP. BOARD AND GRID - LOCATIONS AS NOTED ON PLAN
	PAINTED STRUCTURE
	MECHANICAL ACCESSORY - REFER TO MECHANICAL DRAWINGS FOR ADDITIONAL INFORMATION

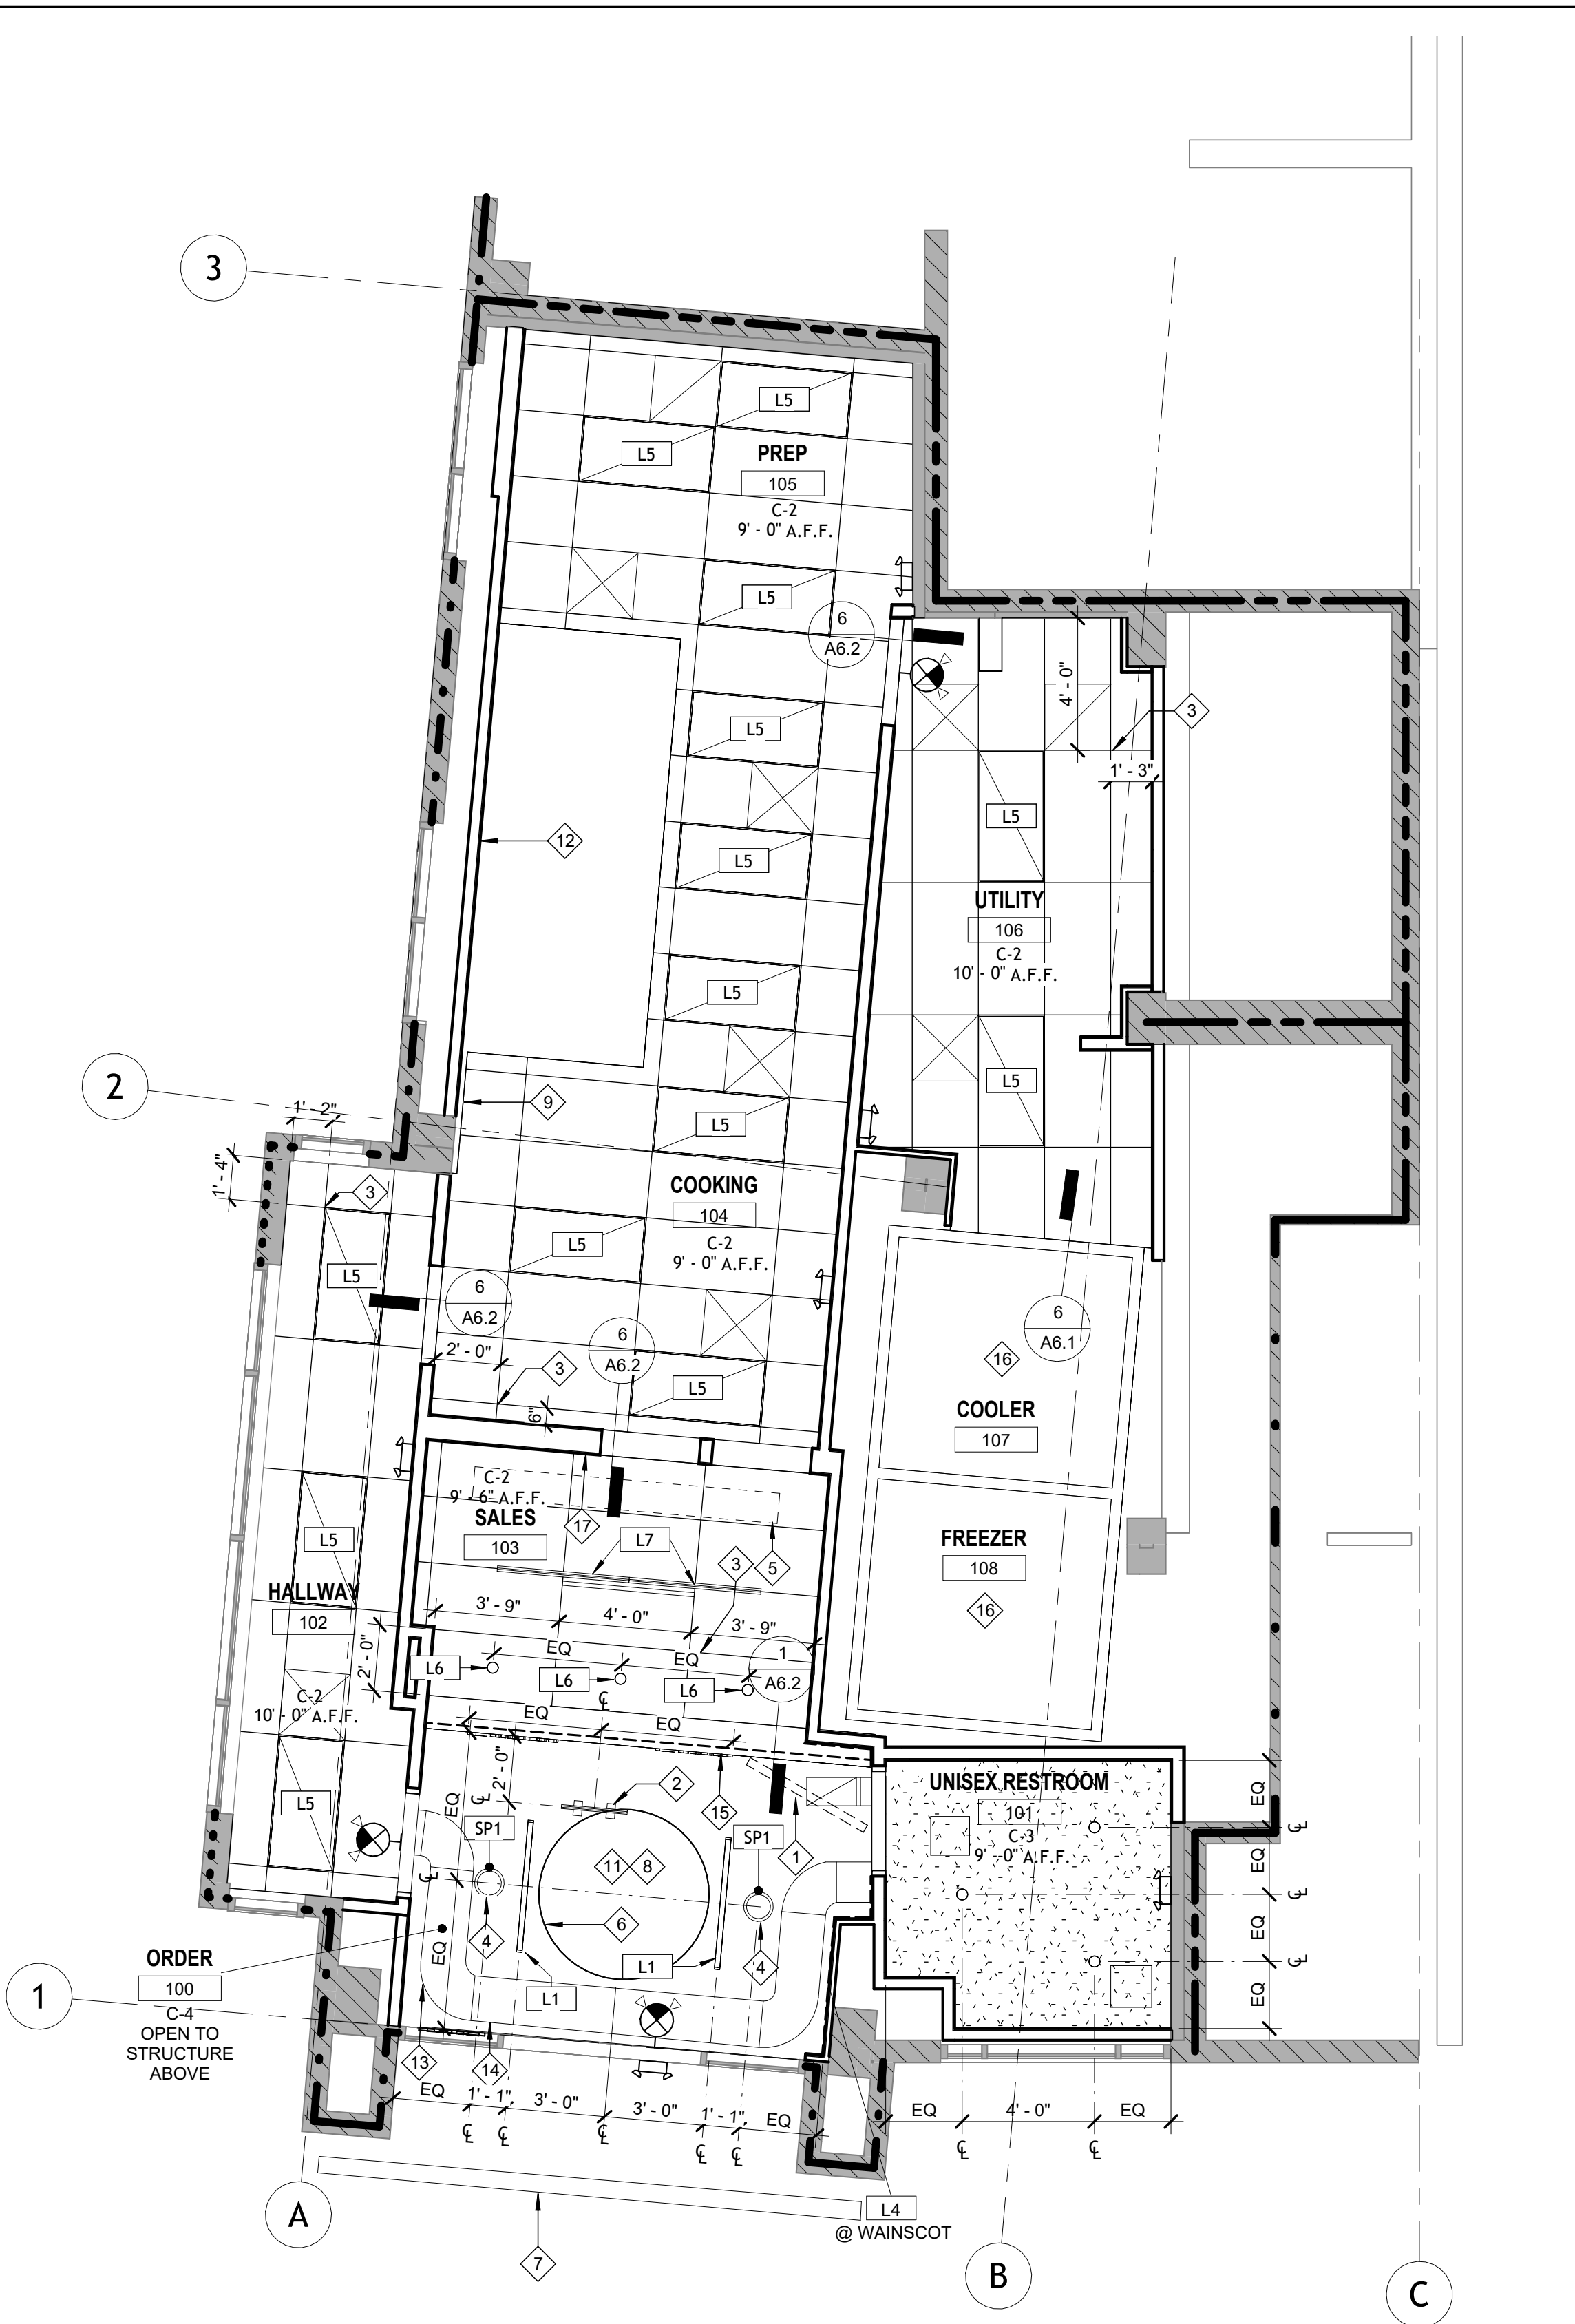

1 REFLECTED CEILING PLAN

SCALE: 1/4" = 1'-0"

CONSULTANT



2801 NORTH CENTRAL EXPRESSWAY, SUITE 1600
DALLAS, TX 75204
TELEPHONE: (972) 686-6500
FAX: (972) 686-6502


THESE DRAWINGS, IDEAS, SPECIFICATIONS AND DESIGNS ARE EXCLUSIVE PROPERTY OF WINGSTOP RESTAURANTS, INC. NO PART OF THESE DRAWINGS MAY BE COPIED, REPRODUCED, OR OTHER STRUCTURES BUILT FROM SUCH WITHOUT THE WRITTEN CONSENT OF WINGSTOP RESTAURANTS, INC.

COPYRIGHT © 2025
WINGSTOP RESTAURANTS, INC.
ALL RIGHTS RESERVED

PROJECT INFORMATION

**WINGSTOP
(GL#A216)**
THE AUGUSTA ON GEORGIA
3831 GEORGIA AVENUE NW
WASHINGTON, D.C. 20009

SEAL

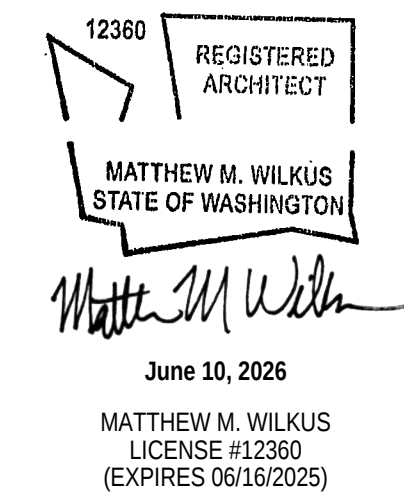

PROJECT NO. 2025-0430
DRAWN BY ANC
CHECKED BY JSS

ISSUE DATE
DESIGN INTENT REVIEW 2026/03/30
PERMIT SET 2026/06/10

REVISION DATE

REVISION DATE

REVISION DATE

NG_DELCO_2025.02

TITLE


**REFLECTED
CEILING PLAN**

SHEET NUMBER

A2.4

ROOF GENERAL NOTES	
A.	GENERAL CONTRACTOR TO ENSURE THAT ANY AIR INTAKES ARE LOCATED 10'-0" MINIMUM AWAY FROM ANY EXHAUST LOCATIONS. NOTIFY ARCHITECT OF ANY NON-CONFORMING CONDITION.
B.	GENERAL CONTRACTOR TO FIELD VERIFY THAT NO EXISTING OR PROPOSED EQUIPMENT IS LOCATED NO CLOSER THAN 5'-0" MINIMUM FROM THE LEASE LINE BELOW. NOTIFY ARCHITECT OF ANY NON-CONFORMING CONDITION.
C.	GENERAL CONTRACTOR TO INSPECT EXISTING ROOF AND ROOF STRUCTURE FOR DAMAGE PRIOR TO COMMENCEMENT OF THE WORK. GENERAL CONTRACTOR TO REPAIR AND REPLACE ANY ROOFING, COPING, FLASHING, ROOF DECKING, ROOF STRUCTURE, ETC. BASED ON INSPECTION AND ANY ITEMS THAT WERE DAMAGED DURING THE COURSE OF CONSTRUCTION.
D.	GENERAL CONTRACTOR SHALL FURNISH AND INSTALL REQUIRED ROOF OPENING FRAMING FOR SCHEDULED HVAC AND EXHAUST UNITS. FOR STRUCTURAL SUPPORT OF EQUIPMENT AND SUPPORT OF ROOF OPENINGS, REFER TO STRUCTURAL DRAWINGS.
E.	ROOF PENETRATIONS FOR MINOR VENTS AND SIMILAR ITEMS MAY NOT BE INDICATED ON THE ROOF PLAN. ITEMS ARE INDICATED FOR REFERENCE PURPOSES ONLY. REFER TO ENGINEERED CONSTRUCTION DOCUMENTS BY OTHERS FOR ADDITIONAL ROOF PENETRATIONS REQUIRING FLASHING INSTALLATION.
F.	ROOFING WORK, INCLUDING FLASHING AND COUNTER-FLASHING, SHALL BE PROVIDED BY THE ROOFING CONTRACTOR SO AS TO OBTAIN AND/OR MAINTAIN ROOFING WARRANTIES.
G.	LOCATIONS OF ROOF PENETRATIONS TO BE FIELD VERIFIED WITH APPROPRIATE SUB-CONTRACTOR.
H.	COORDINATE LOCATIONS OF ROOF-TOP MOUNTED MECHANICAL CURBS WITH BOTH MECHANICAL AND STRUCTURAL ENGINEER PRIOR TO COMMENCING WORK.
I.	PROVIDE AND INSTALL ROOF CRICKET/DIVERTERS AT EXHAUST FANS AND MECHANICAL CURBS TO ENSURE/MAINTAIN POSITIVE AND EFFICIENT ROOF DRAINAGE.
J.	GENERAL CONTRACTOR TO KEEP ROOF CLEAN OF DEBRIS DURING CONSTRUCTION.
K.	REFER TO STRUCTURAL CONSTRUCTION DOCUMENTS FOR ADDITIONAL FRAMING AND ROOF REINFORCEMENT INFORMATION AT ROOF OPENINGS.
L.	GENERAL CONTRACTOR TO COORDINATE WITH OWNER REQUIREMENT TO UTILIZE LANDLORD'S ROOFING CONTRACTOR FOR ROOFING WORK.
M.	WINGSTOP STANDARDS: THE WINGSTOP STANDARD DESIGN, INCLUDING BUT NOT LIMITED TO: LIGHTING, SEATING, PAINT SELECTION, KITCHEN EQUIPMENT, FLOORING, WALL FINISHES, COUNTER HEIGHTS, SIGNAGE, AND ALL OTHER ELEMENTS AS NOTED AND INCLUDED IN THESE CONTRACT DOCUMENTS ARE AS PER THE WINGSTOP RESTAURANTS, INC. FRANCHISE AGREEMENT. ANY REVISIONS TO THESE DOCUMENTS OR FIELD CHANGES TO THIS DESIGN SHALL ONLY OCCUR UPON WRITTEN APPROVALS OF WINGSTOP RESTAURANTS, INC.
N.	GENERAL CONTRACTOR TO INSPECT ROOF AND PATCH ANY EXISTING ROOF PENETRATION(S) TO BE ABANDONED TO MATCH EXISTING ROOFING CONDITION. ENSURE POSITIVE DRAINAGE TO ROOF DRAINAGE LOCATION IS MAINTAINED.
O.	GENERAL CONTRACTOR SHALL FURNISH AND INSTALL REQUIRED ROOF DOCUMENTATION FOR THE MODIFICATION OF EXISTING ROOF AS APPLICABLE PER THE BRAND PARTNER'S LEASE. THE LANDLORD SHALL BE CONTACTED TO OBTAIN ALL REQUIREMENTS FOR LISTED SUBCONTRACTORS WITH WARRANTY WORK FOR THE SPECIFIED ROOFING SYSTEM.
P.	ALL ROOFING DETAILS, INCLUDING FLASHING, CANTS, BLOCKING, ROOF PENETRATIONS AND EXPANSION JOINTS ARE TO BE INSTALLED PER ROOFING MANUFACTURERS DETAILS, STANDARDS AND RECOMMENDATIONS.
Q.	FIELD VERIFY EXISTING EXTERIOR ROOF PENETRATION LOCATIONS TO REMAIN ARE PROVIDED WITH FLASHING AND CAULKING AS REQUIRED TO ENSURE WATER-TIGHT CONDITION. NOTIFY ARCHITECT OF ANY CONISITONS THAT DO NOT COMPLY.
R.	DIMENSIONS FOR ROOF-TOP MOUNTED EQUIPMENT WITH CURBS IS TO THE OUTSIDE FACE OF CURB. DIMENSIONS FOR EQUIPMENT WITHOUT CURBS ARE SHOWN TO THE CENTERLINE OF THE UNIT. DIMENSIONS ARE PROVIDED FOR REFERENCE PURPOSES ONLY. GENERAL CONTRACTOR TO ADJUST AS REQUIRED IN THE FIELD AND CONTACT ENGINEERING CONSULTANT FOR ANY MAJOR MODIFICATION TO PROPOSED LAYOUT.
S.	LOCATE UNITS SO THAT DUCT DROPS BETWEEN EXISTING ROOF MEMBERS. NOTIFY ARCHITECT IMMEDIATELY IF ANY UNIT NEEDS TO SHIFT FROM PLAN LOCATION SHOWN.

KEYNOTE LEGEND	
1	SIGNAGE LOCATION - REFER TO SIGNAGE DRAWINGS BY OTHERS FOR ADDITIONAL INFORMATION - EXTERIOR SIGNAGE TO BE PROVIDED, PERMITTED, INSTALLED, AND INSPECTED UNDER A SEPARATE PERMIT - COORDINATE ELECTRICAL REQUIREMENTS BETWEEN SIGNAGE VENDOR AND ELECTRICAL DRAWINGS
2	GENERAL CONTRACTOR TO COORDINATE WITH SIGNAGE VENDOR AND ELECTRICAL CONTRACTOR TO FURNISH AND INSTALL ELECTRICAL CIRCUIT, INCLUDING ALL CONDUIT, WIRE, CONNECTIONS, AND BREAKERS AT PANEL BOARD NECESSARY TO SERVE PROPOSED SIGNAGE
3	EXISTING CAP FLASHING TO REMAIN - PROTECT
4	EXISTING ROOFING SYSTEM TO REMAIN - PROTECT
5	NO PROPOSED CONSTRUCTION IS INTENDED TO NEGATIVELY IMPACT THE EXISTING ROOF DRAINAGE - NOTIFY ARCHITECT IF ANY MODIFICATION IS IDENTIFIED TO BE REQUIRED TO MAINTAIN EXISTING PRIMARY AND SECONDARY DRAINAGE
6	DASHED LINE INDICATES APPROXIMATE LOCATION OF EXISTING DEMISING WALL BELOW
7	EXISTING ELEVATOR OVERRUN
8	NEW ROOF-TOP MECHANICAL UNIT - REFER TO MECHANICAL DRAWINGS FOR NUMBER, SIZE, HEIGHT, AND WEIGHT OF ALL EQUIPMENT
9	FIELD VERIFY THAT UNITS ARE INSTALLED WITH 10'-0" MINIMUM SEPARATION FROM ROOF EDGE IS PARAPET IS BELOW 42" - NOTIFY ARCHITECT OF ANY NON-CONFORMING CONDITION
10	PROVIDE STRUCTURAL FRAMING AT NEW ROOF PENETRATIONS/OPENINGS AS REQUIRED - REFER TO STRUCTURAL DRAWINGS FOR ADDITIONAL INFORMATION
11	DASHED LINE INDICATES LIMITS OF 10'-0" RADIUS FROM EXHAUST LOCATION
12	EXISTING STAIRWAY
13	NOT USED
14	NOT USED
15	EXISTING OBSTRUCTION ON ROOF - COORDINATE MECHANICAL DESIGN TO AVOID DISRUPTION
16	REFER TO ENGINEERED DRAWINGS BY OTHERS FOR ADDITIONAL ROOF PENETRATIONS REQUIRING FLASHING
17	EXTERIOR DOUBLE WALL GREASE DUCT TO DROP DOWN THROUGH LOUVERED SHAFT INTO TENANT SPACE
18	EXISTING MECHANICAL EQUIPMENT ENCLOSURE
19	EXISTING TERRACE
20	EXISTING GREEN ROOF INTENSIVE

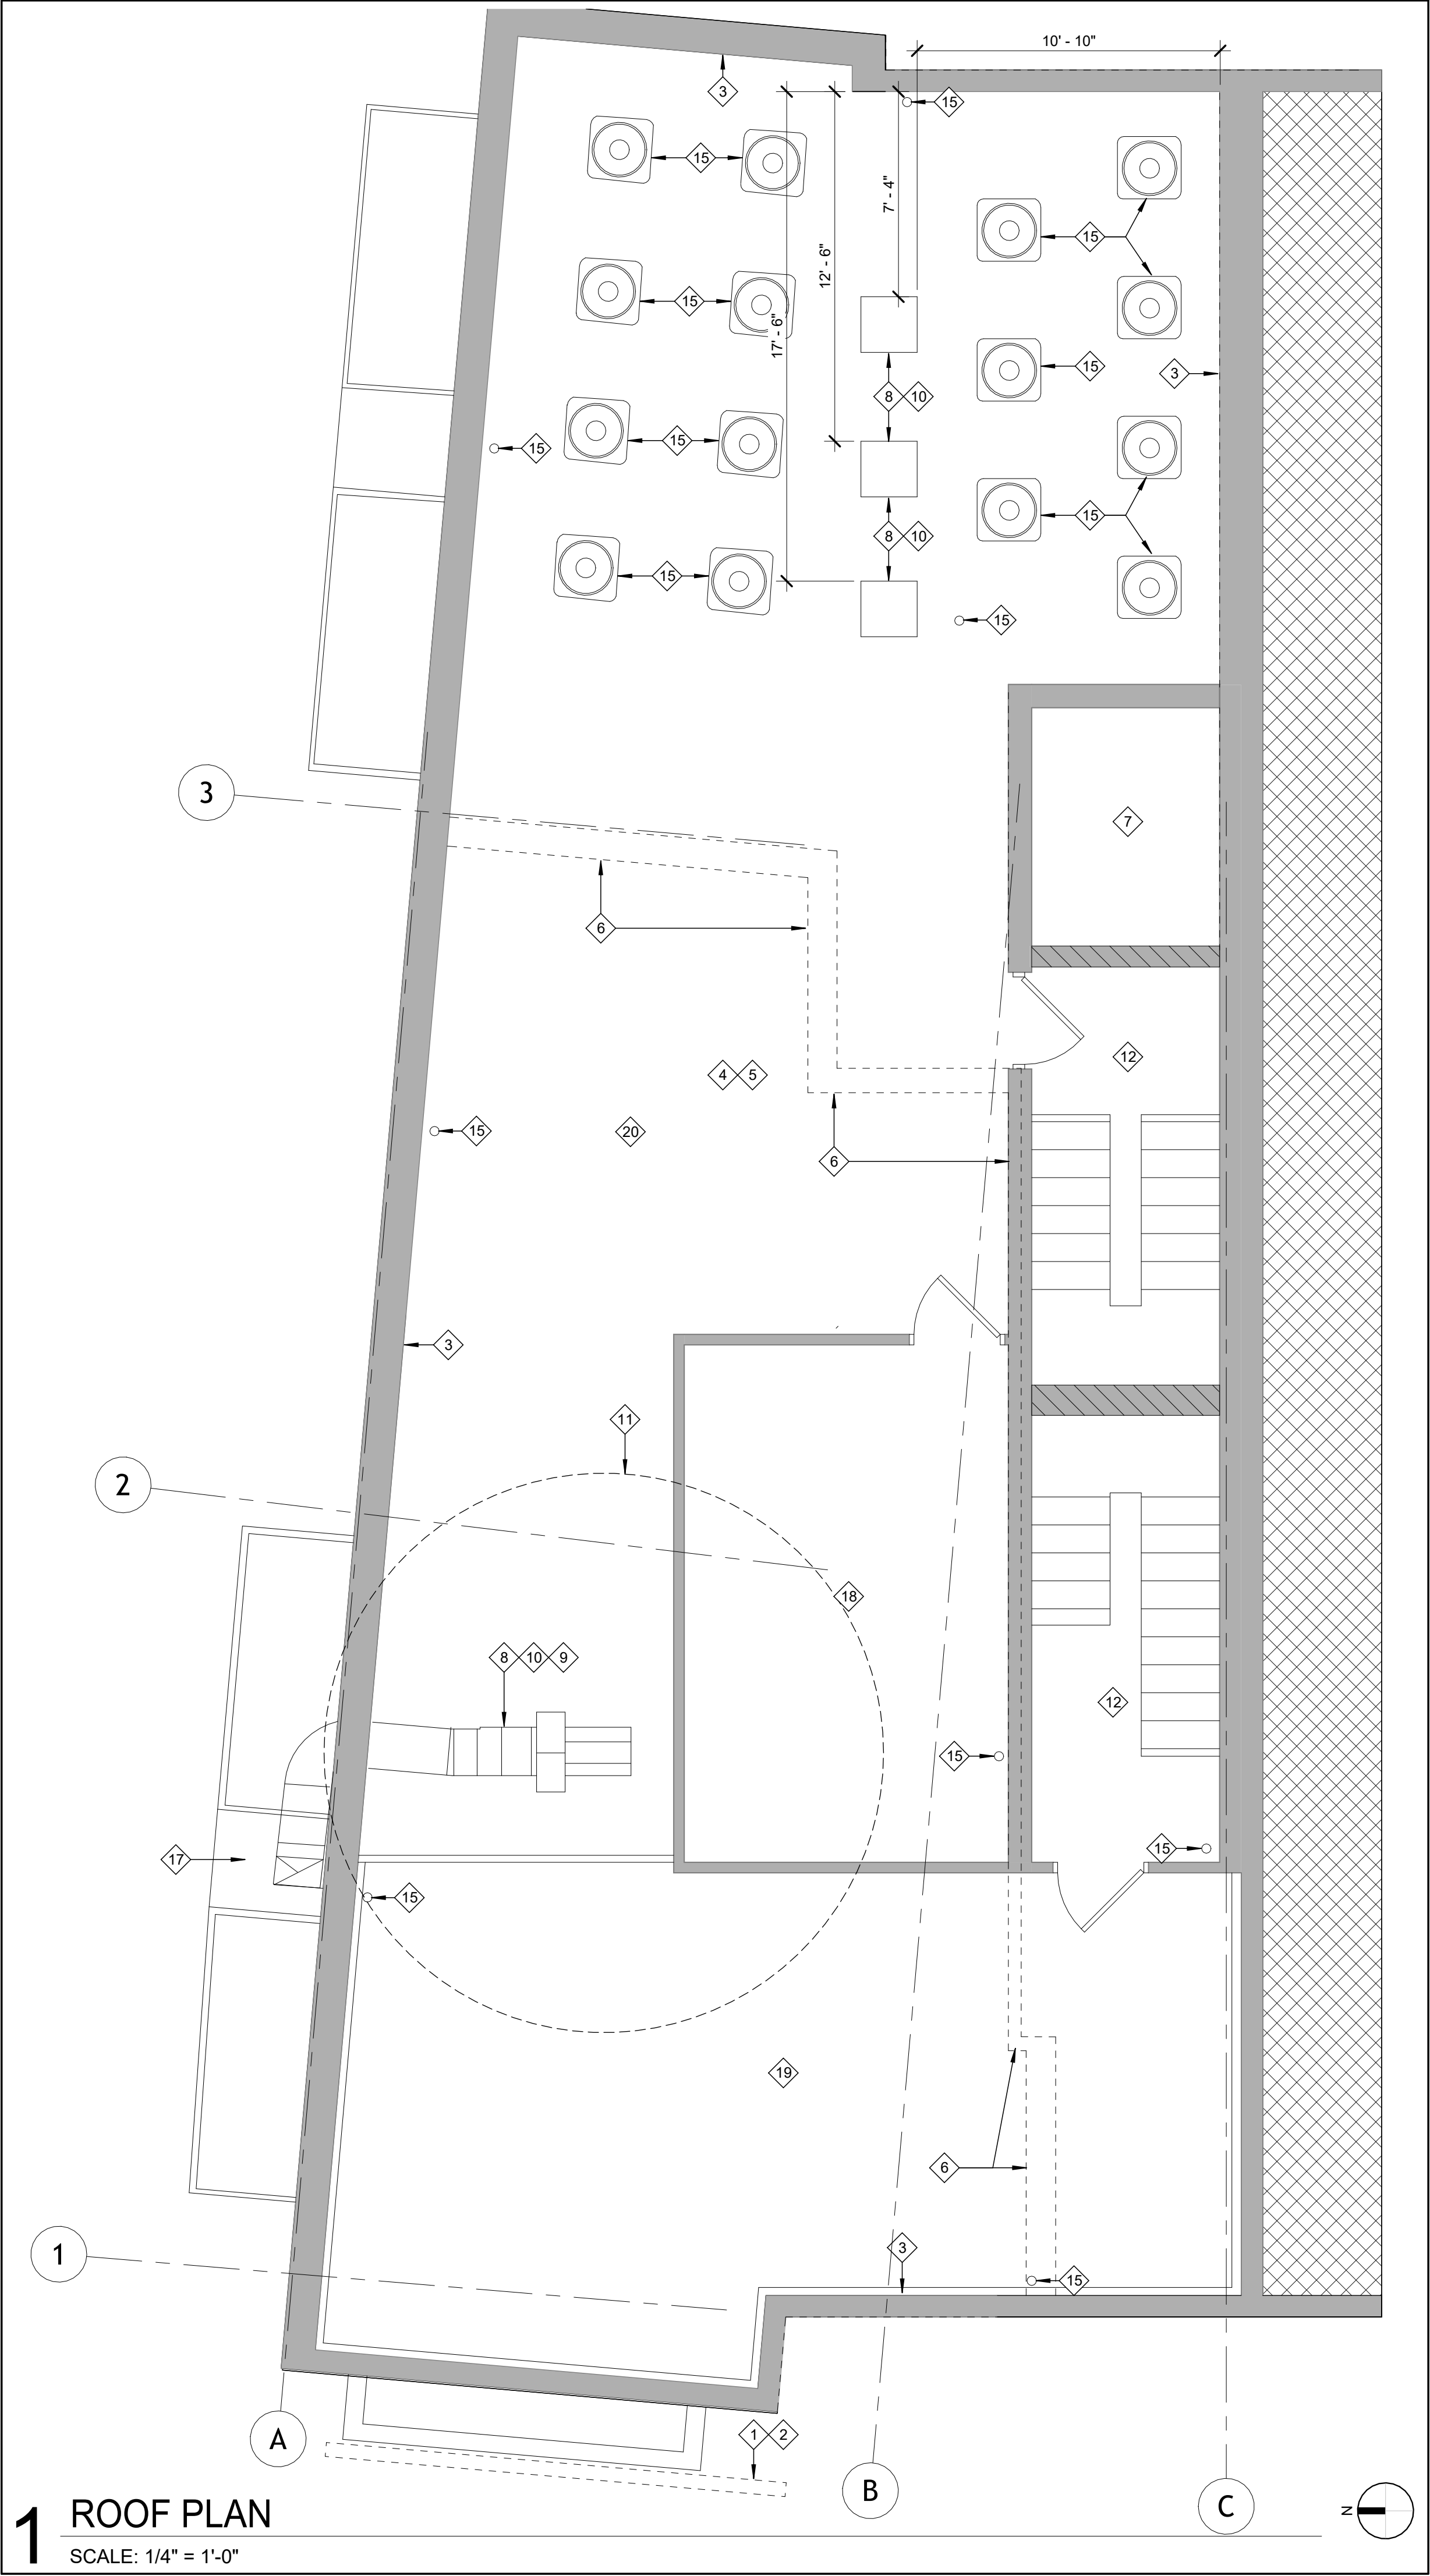

1 ROOF PLAN
SCALE: 1/4" = 1'-0"

CONSULTANT



2801 NORTH CENTRAL
EXPRESSWAY, SUITE 1600
DALLAS, TX 75204
TELEPHONE: (972) 686-6500
FAX: (972) 686-6502


THESE DRAWINGS, IDEAS, SPECIFICATIONS AND
DESIGNS ARE EXCLUSIVE PROPERTY OF
WINGSTOP RESTAURANTS, INC. NO PART OF
THESE DRAWINGS MAY BE COPIED,
REPRODUCED, OR OTHER STRUCTURES BUILT
FROM SUCH WITHOUT THE WRITTEN CONSENT
OF WINGSTOP RESTAURANTS, INC.

COPYRIGHT © 2025
WINGSTOP RESTAURANTS, INC.
ALL RIGHTS RESERVED

PROJECT INFORMATION

**WINGSTOP
(GL#A216)**
THE AUGUSTA ON GEORGIA
3831 GEORGIA AVENUE NW
WASHINGTON, D.C. 20009

SEAL

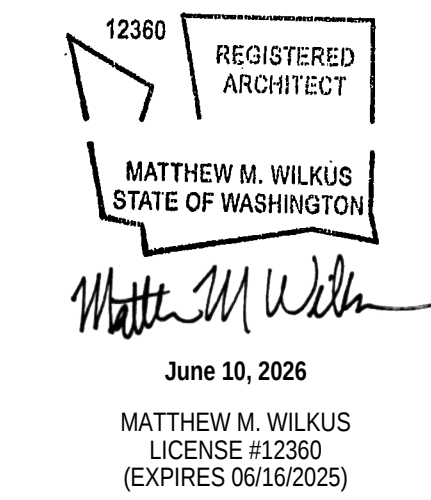

PROJECT NO. 2025-0430
DRAWN BY ANC
CHECKED BY JSS

ISSUE DATE
DESIGN INTENT REVIEW 2026/03/30
PERMIT SET 2026/06/10

REVISION DATE


NG_DELCO_2025.02

TITLE

ROOF PLAN

SHEET NUMBER

A2.5

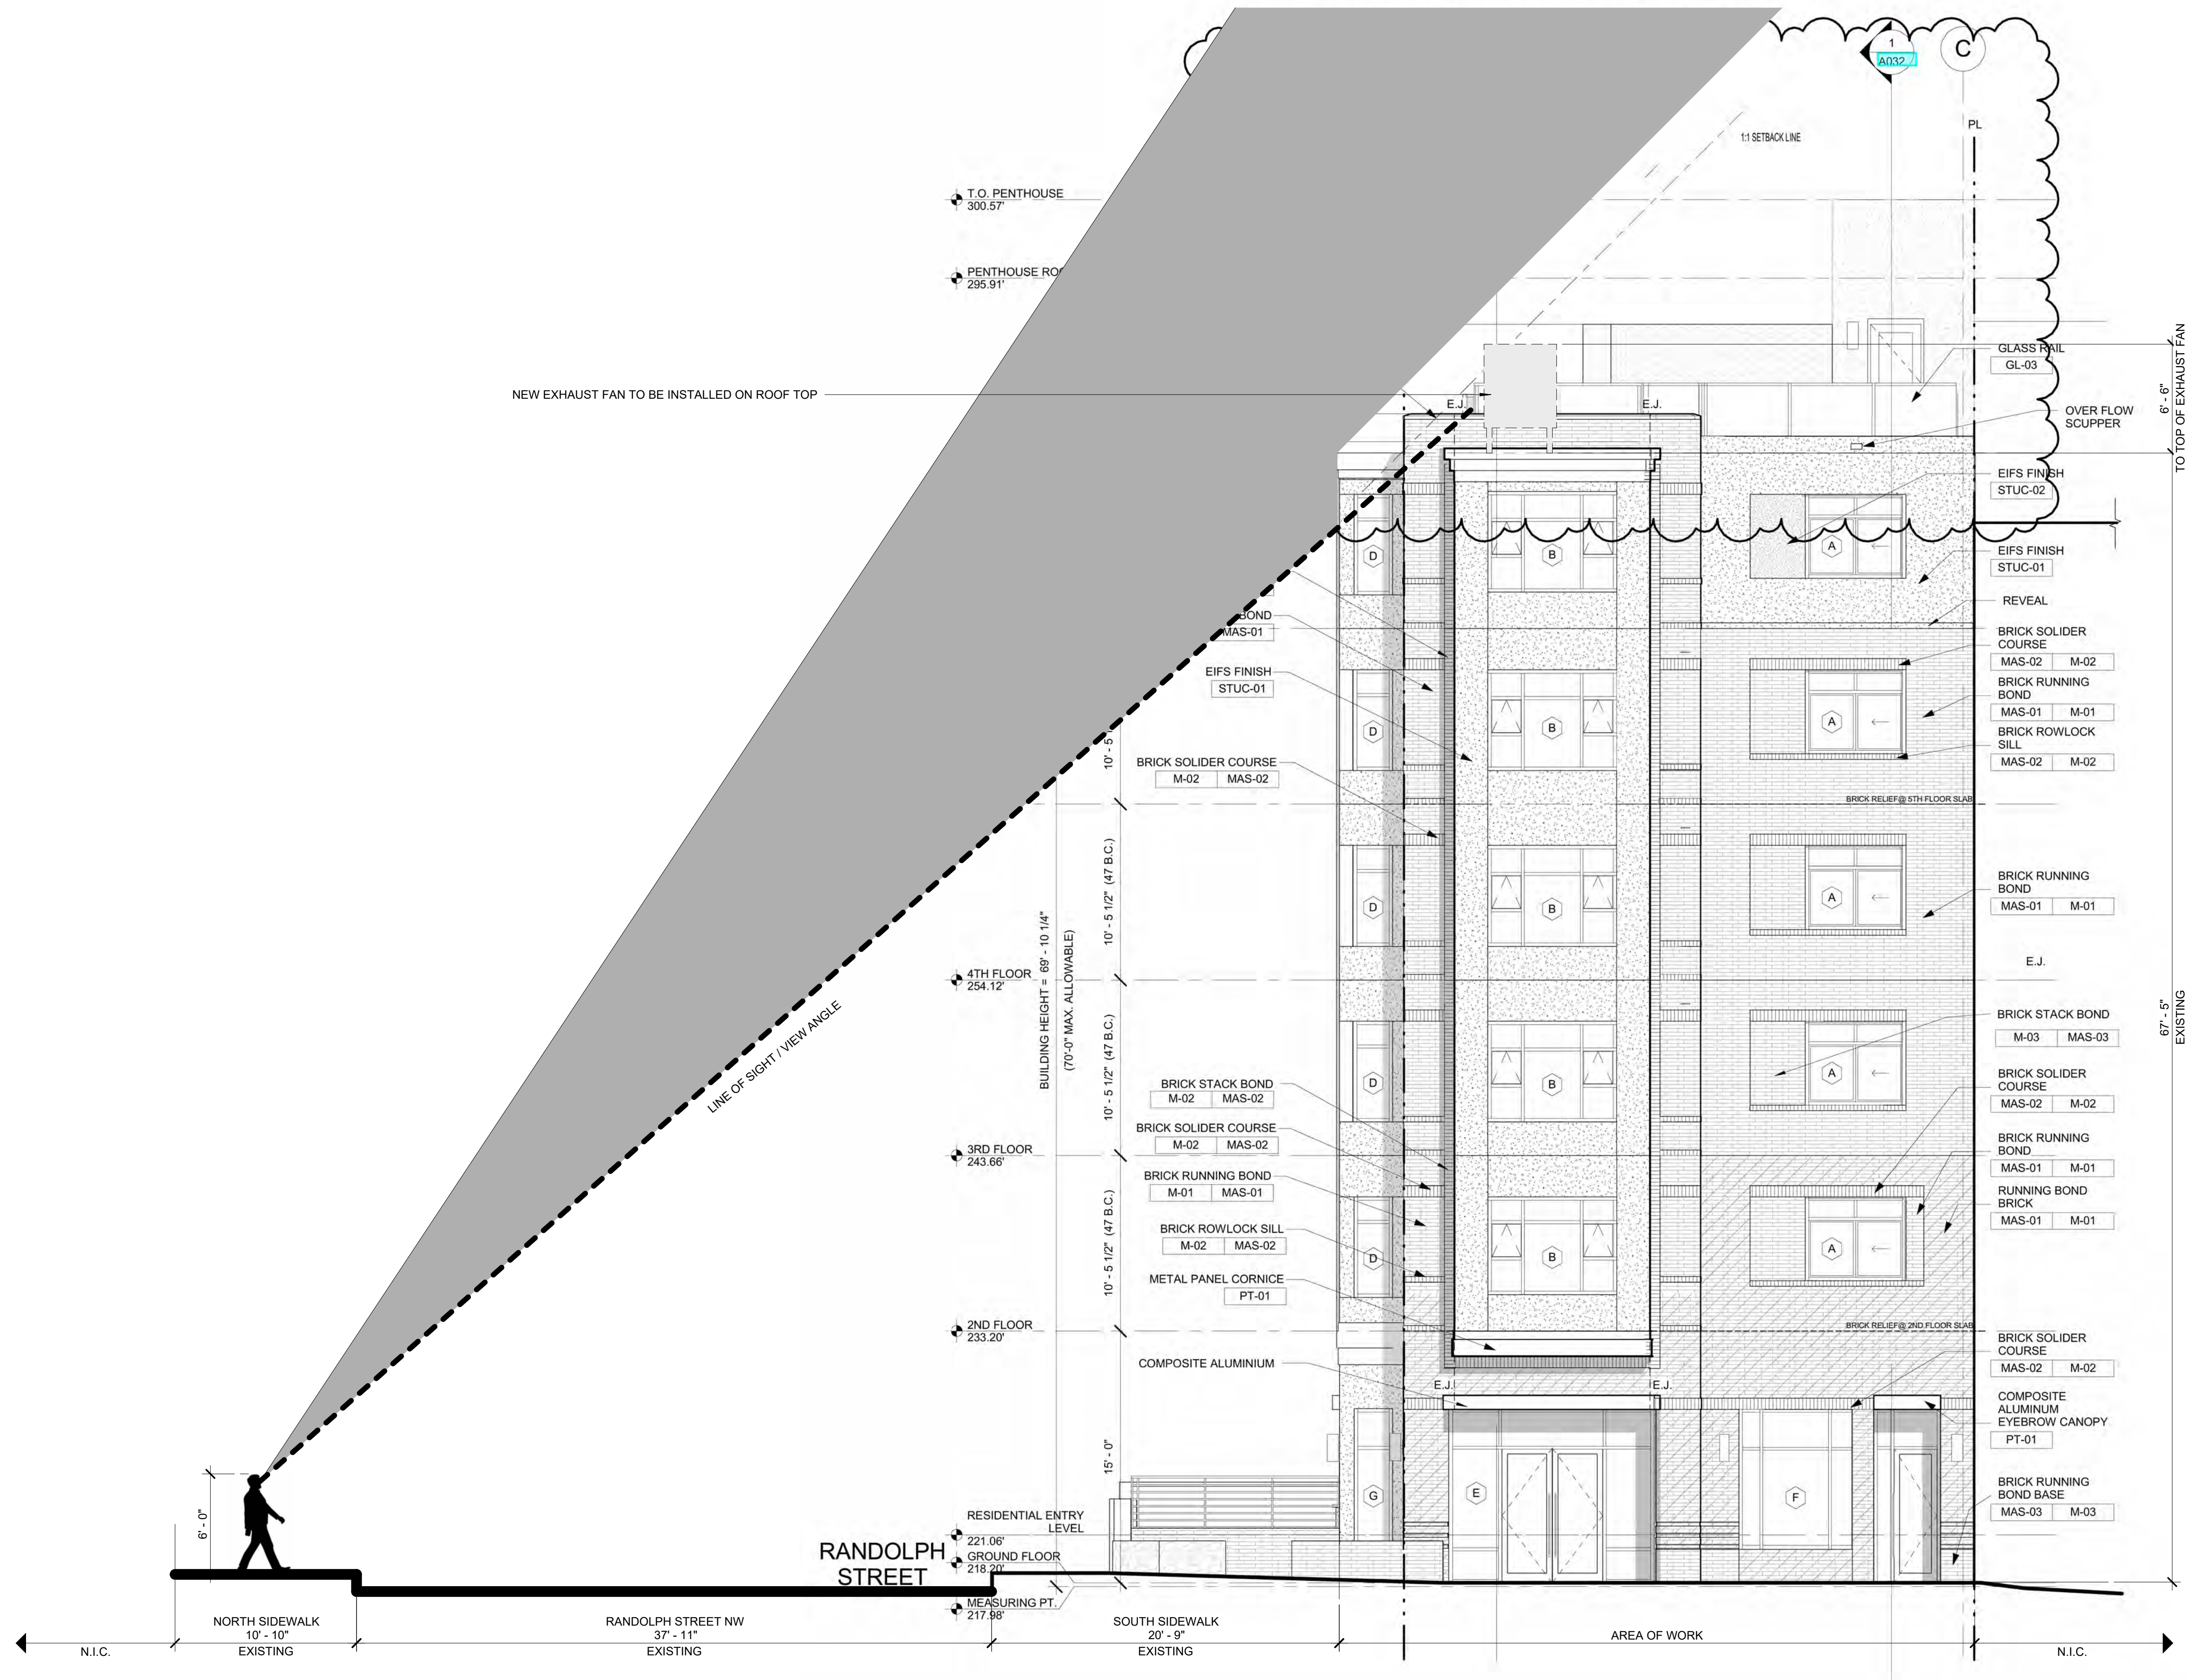

1 SIGHT LINE STUDY

SCALE: 3/16" = 1'-0"

CONSULTANT



2801 NORTH CENTRAL
EXPRESSWAY, SUITE 1600
DALLAS, TX 75204
TELEPHONE: (972) 686-6500
FAX: (972) 686-6502

THESE DRAWINGS, IDEAS, SPECIFICATIONS AND
DESIGNS ARE EXCLUSIVE PROPERTY OF
WINGSTOP RESTAURANTS, INC. NO PART OF
THESE DRAWINGS MAY BE COPIED,
REPRODUCED, OR OTHER STRUCTURES BUILT
FROM SUCH WITHOUT THE WRITTEN CONSENT
OF WINGSTOP RESTAURANTS, INC.


COPYRIGHT © 2025
WINGSTOP RESTAURANTS, INC.
ALL RIGHTS RESERVED

PROJECT INFORMATION

**WINGSTOP
(GL#A216)**

THE AUGUSTA ON GEORGIA
3831 GEORGIA AVENUE NW
WASHINGTON, D.C. 20009

SEAL

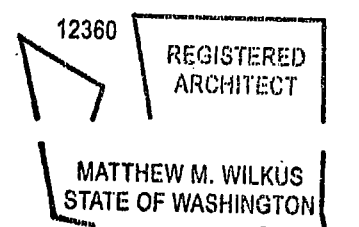

Matthew M. Wilkus

June 10, 2026

MATTHEW M. WILKUS
LICENSE #12360
(EXPIRES 06/16/2025)

PROJECT NO. 2025-0430

DRAWN BY ANC

CHECKED BY JSS

ISSUE DATE

DESIGN INTENT REVIEW 2026/03/30

PERMIT SET 2026/06/10

REVISION DATE

NG_DELCO_2025.02

TITLE

SIGHT LINE STUDY

SHEET NUMBER

A2.6

INTERIOR ELEVATIONS GENERAL NOTES

A.

GENERAL CONTRACTOR TO VERIFY WITH OWNER WINDOW SHADE LOCATIONS

B.

REFER TO ENLARGED PLAN FOR ACCESSORY & PLUMBING FIXTURE INSTALLATION REQUIREMENTS - TYPICAL

C.

REFER TO EQUIPMENT PLAN FOR EQUIPMENT SCHEDULE

KEYNOTE LEGEND

1

START TILE LAYOUT WITH FULL TILE

2

MOUNT QUAD OUTLET TO METAL SUPPORT FRAME - SEE ELECTRICAL PLAN FOR ADDITIONAL INFORMATION

3

MOUNT DATA AND NETWORK (6 JACKS) TO METAL SUPPORT FRAME - SEE ELECTRICAL PLAN FOR ADDITIONAL INFORMATION

4


ALIGN TILE BASE TO CABINET

5

CONTINUOUS METAL EDGE TRIM


6

GENERAL CONTRACTOR TO INSTALL OPAQUE WINDOW TINT/FILM. VERIFY WITH OWNER AND LANDLORD.

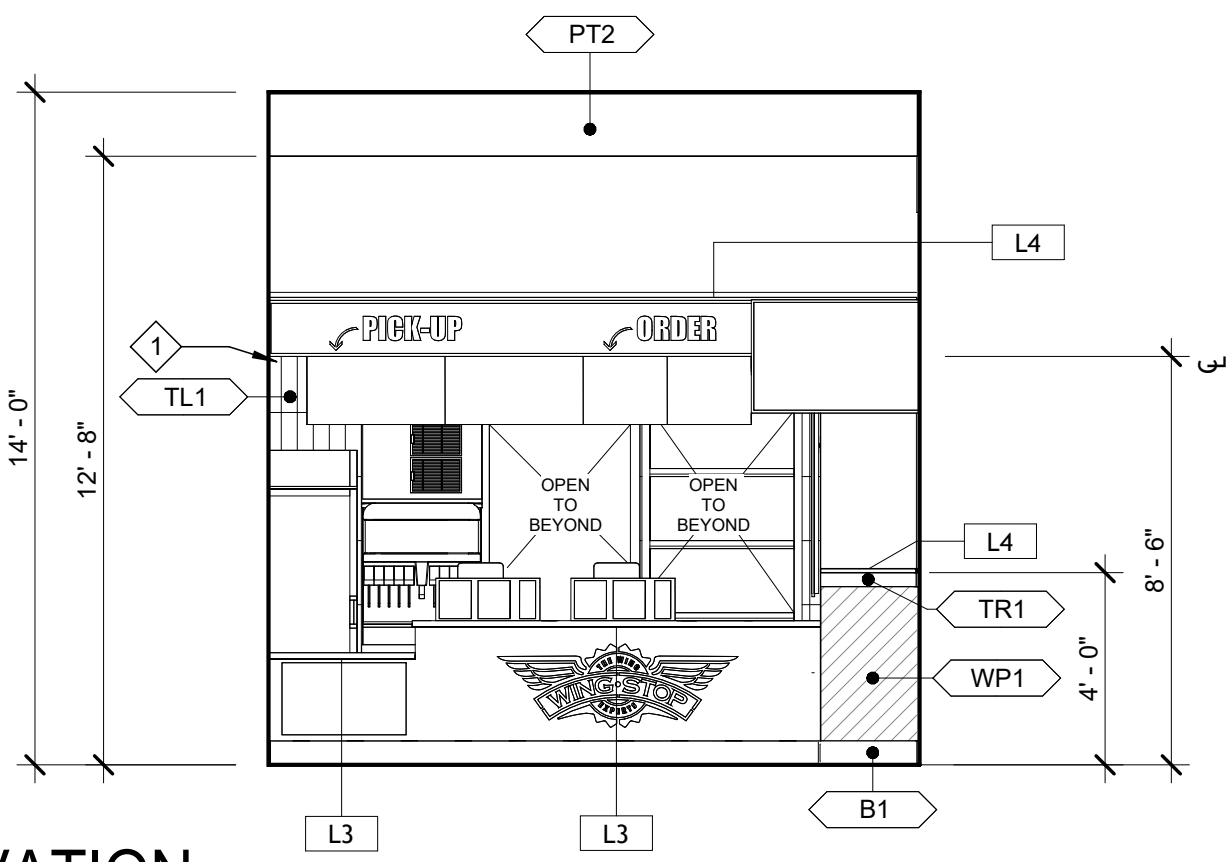


1 ORDER ELEVATION

SCALE: 1/4" = 1'-0"

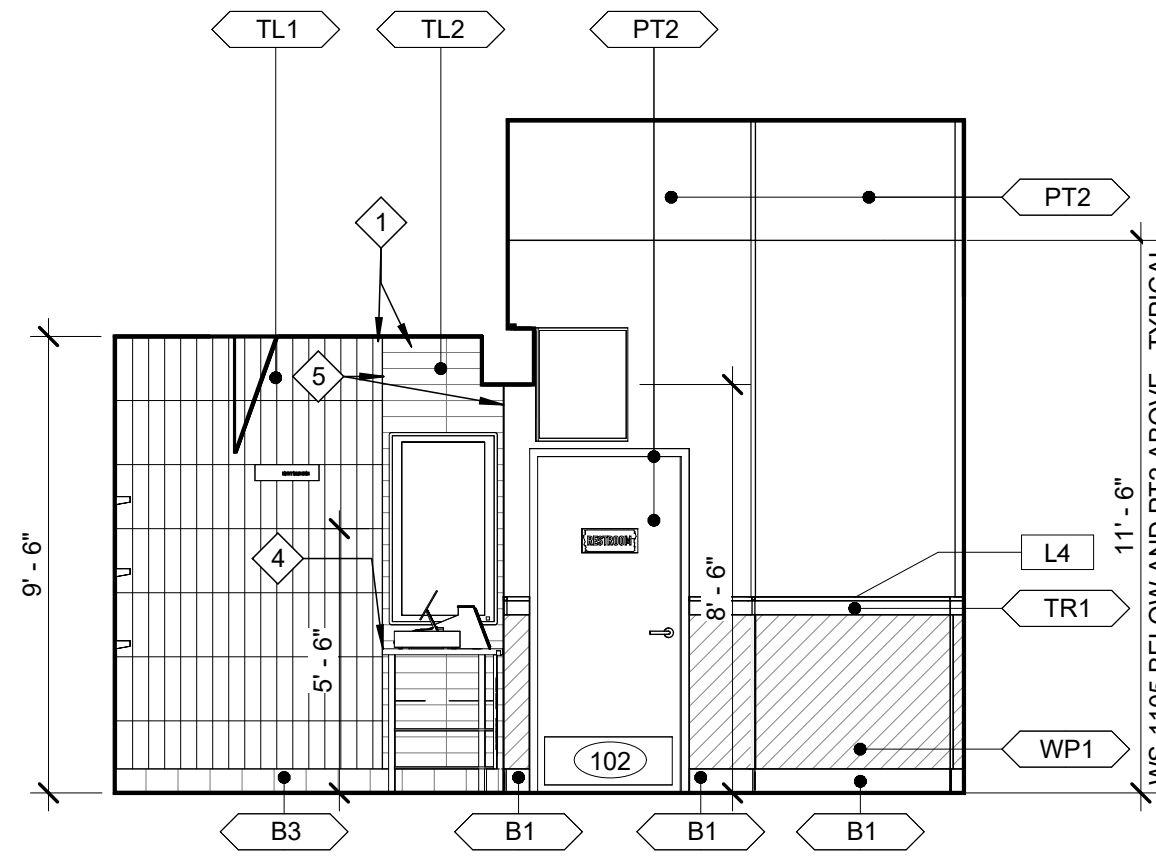


2 PLAN EAST ELEVATION

SCALE: 1/4" = 1'-0"

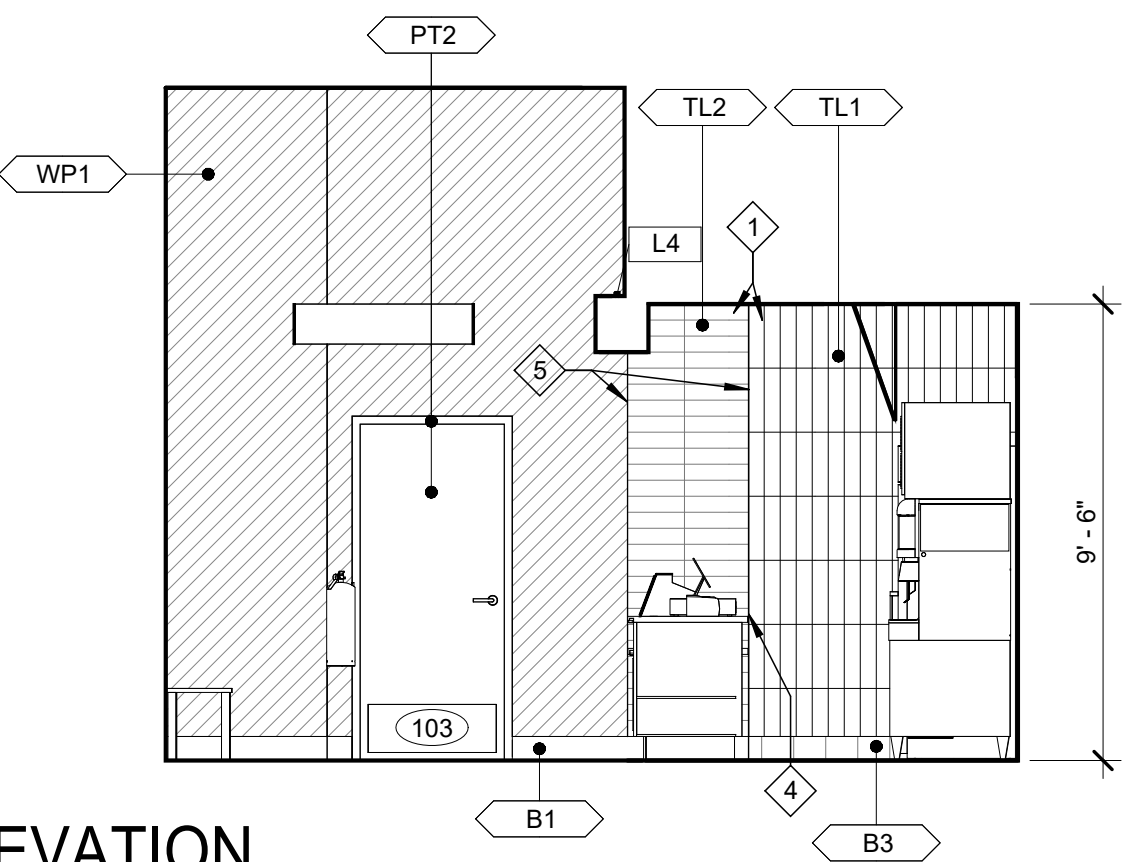


4 PLAN WEST ELEVATION

SCALE: 1/4" = 1'-0"

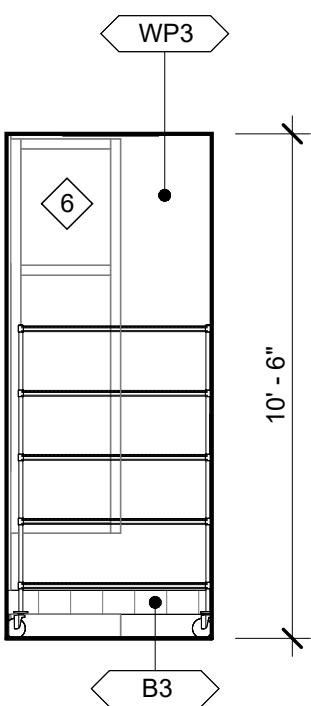


6 HALLWAY ELEVATION

SCALE: 1/4" = 1'-0"

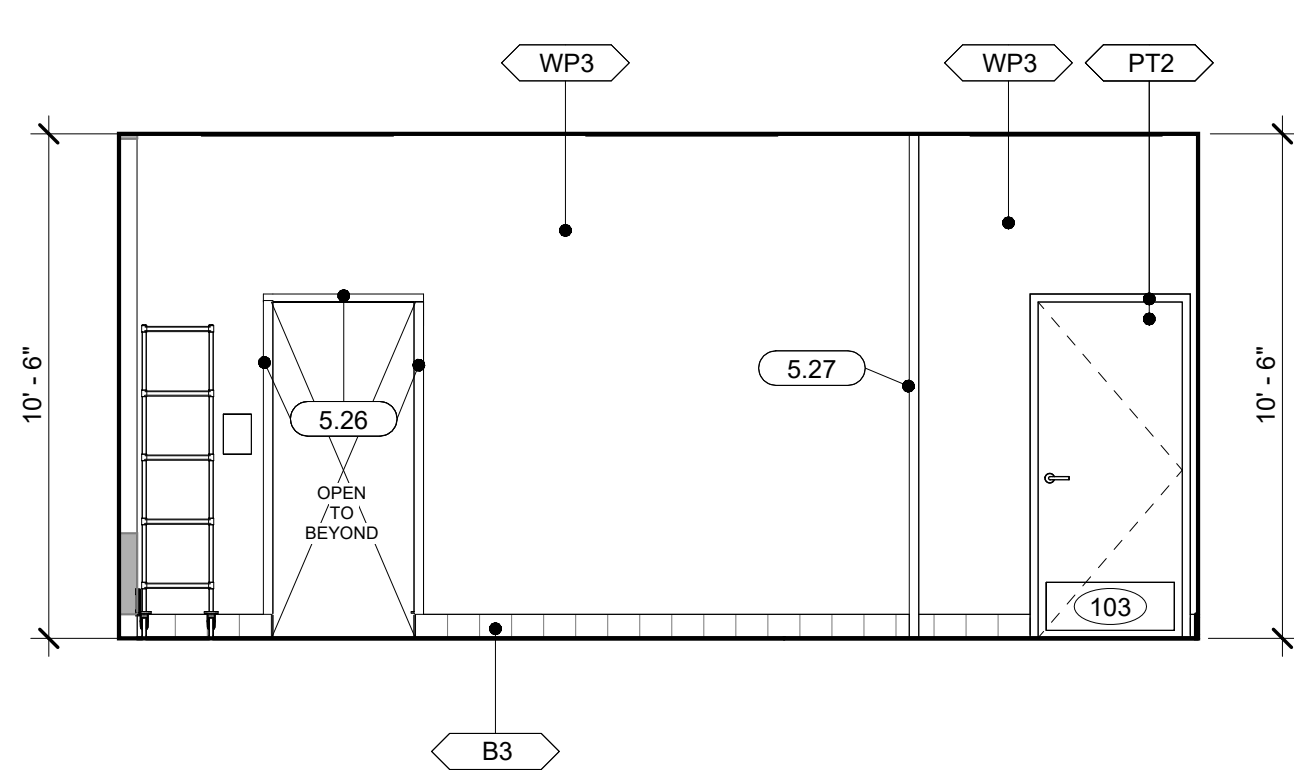


7 HALLWAY ELEVATION

SCALE: 1/4" = 1'-0"

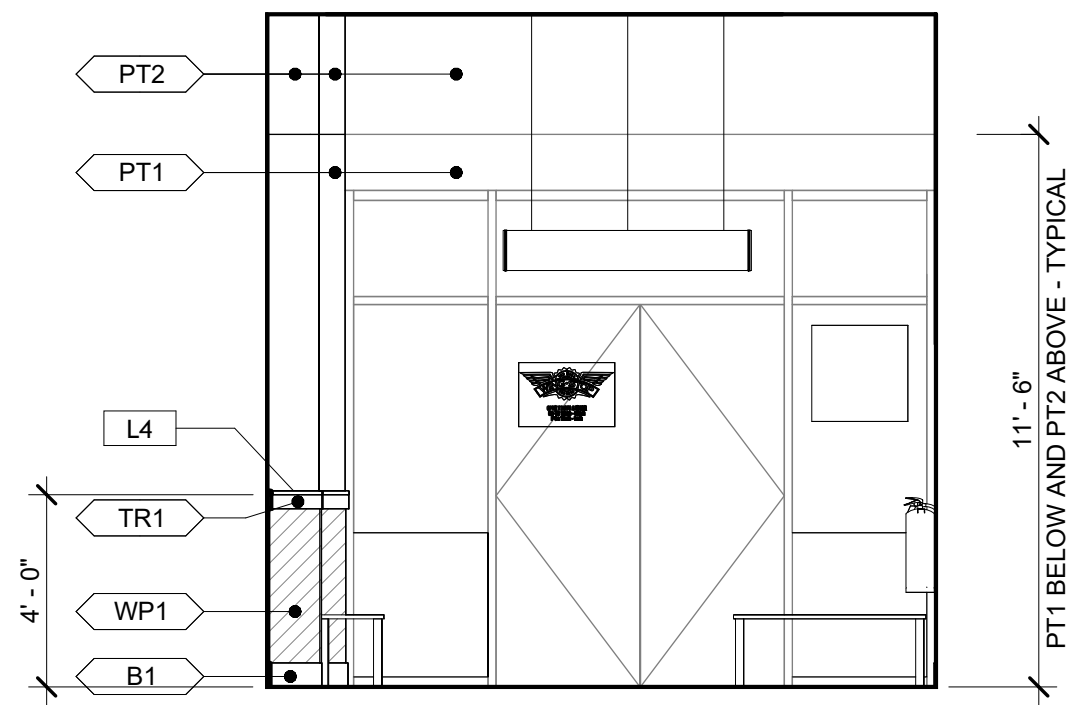


3 STOREFRONT ELEVATION

SCALE: 1/4" = 1'-0"

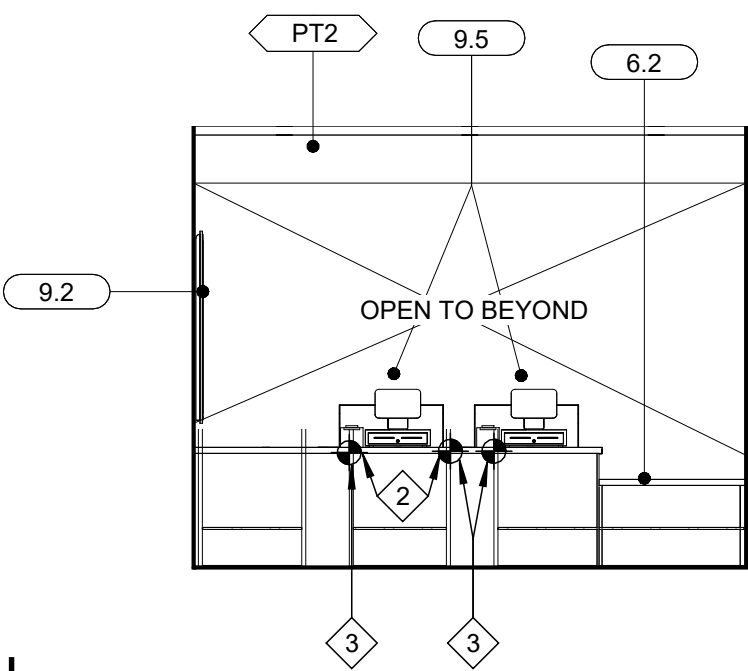


5 DATA ELEVATION

SCALE: 1/4" = 1'-0"

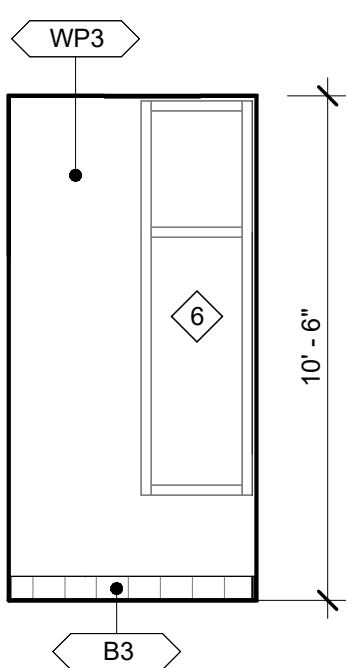

8 HALLWAY ELEVATION

SCALE: 1/4" = 1'-0"

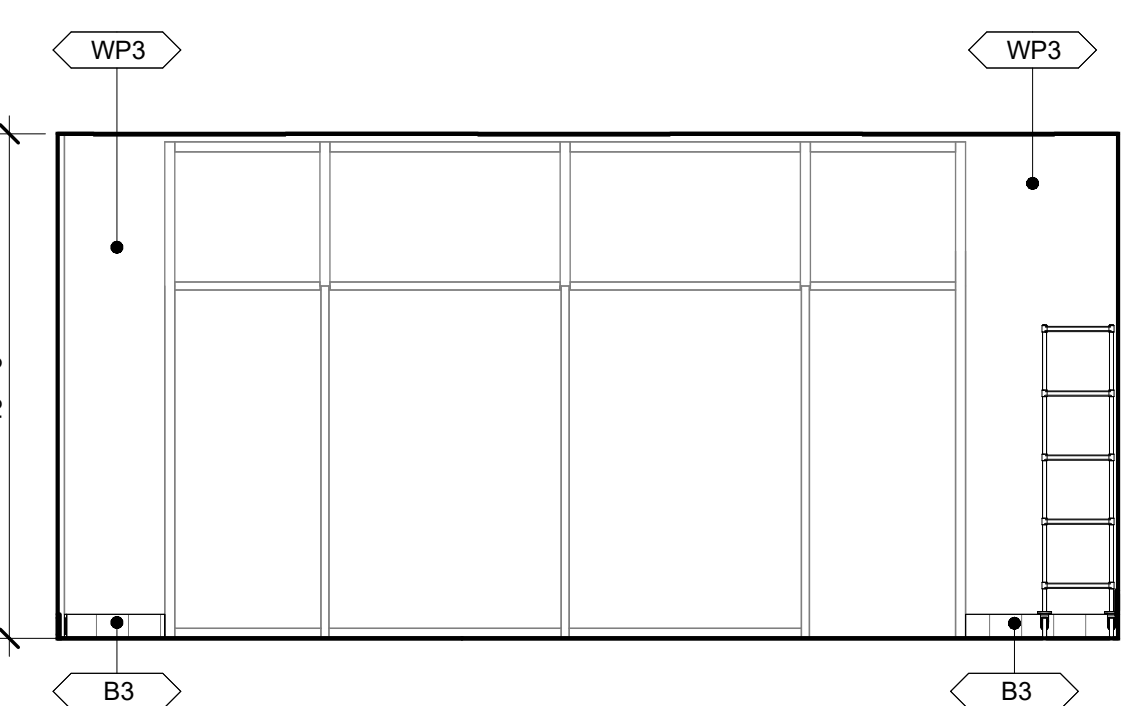

9 STOREFRONT ELEVATION

SCALE: 1/4" = 1'-0"

CONSULTANT





2801 NORTH CENTRAL EXPRESSWAY, SUITE 1600
DALLAS, TX 75204
TELEPHONE: (972) 686-6500
FAX: (972) 686-6502

THESE DRAWINGS, IDEAS, SPECIFICATIONS AND DESIGNS ARE EXCLUSIVE PROPERTY OF WINGSTOP RESTAURANTS, INC. NO PART OF THESE DRAWINGS MAY BE COPIED, REPRODUCED, OR OTHER STRUCTURES BUILT FROM SUCH WITHOUT THE WRITTEN CONSENT OF WINGSTOP RESTAURANTS, INC.

COPYRIGHT © 2025
WINGSTOP RESTAURANTS, INC.
ALL RIGHTS RESERVED

PROJECT INFORMATION

WINGSTOP
(GL#A216)

THE AUGUSTA ON GEORGIA
3831 GEORGIA AVENUE NW
WASHINGTON, D.C. 20009

SEAL

12360 REGISTERED ARCHITECT
MATTHEW M. WILKUS
STATE OF WASHINGTON
June 10, 2026
MATTHEW M. WILKUS
LICENSE #12360
(EXPIRES 06/16/2025)

PROJECT NO. 2025-0430
DRAWN BY ANC
CHECKED BY JSS



 
 
 
 
ISSUE DATE
DESIGN INTENT REVIEW 2026/03/30
PERMIT SET 2026/06/10

REVISION DATE

NG_DELCO_2025.02

TITLE
INTERIOR ELEVATIONS

SHEET NUMBER
A4.0

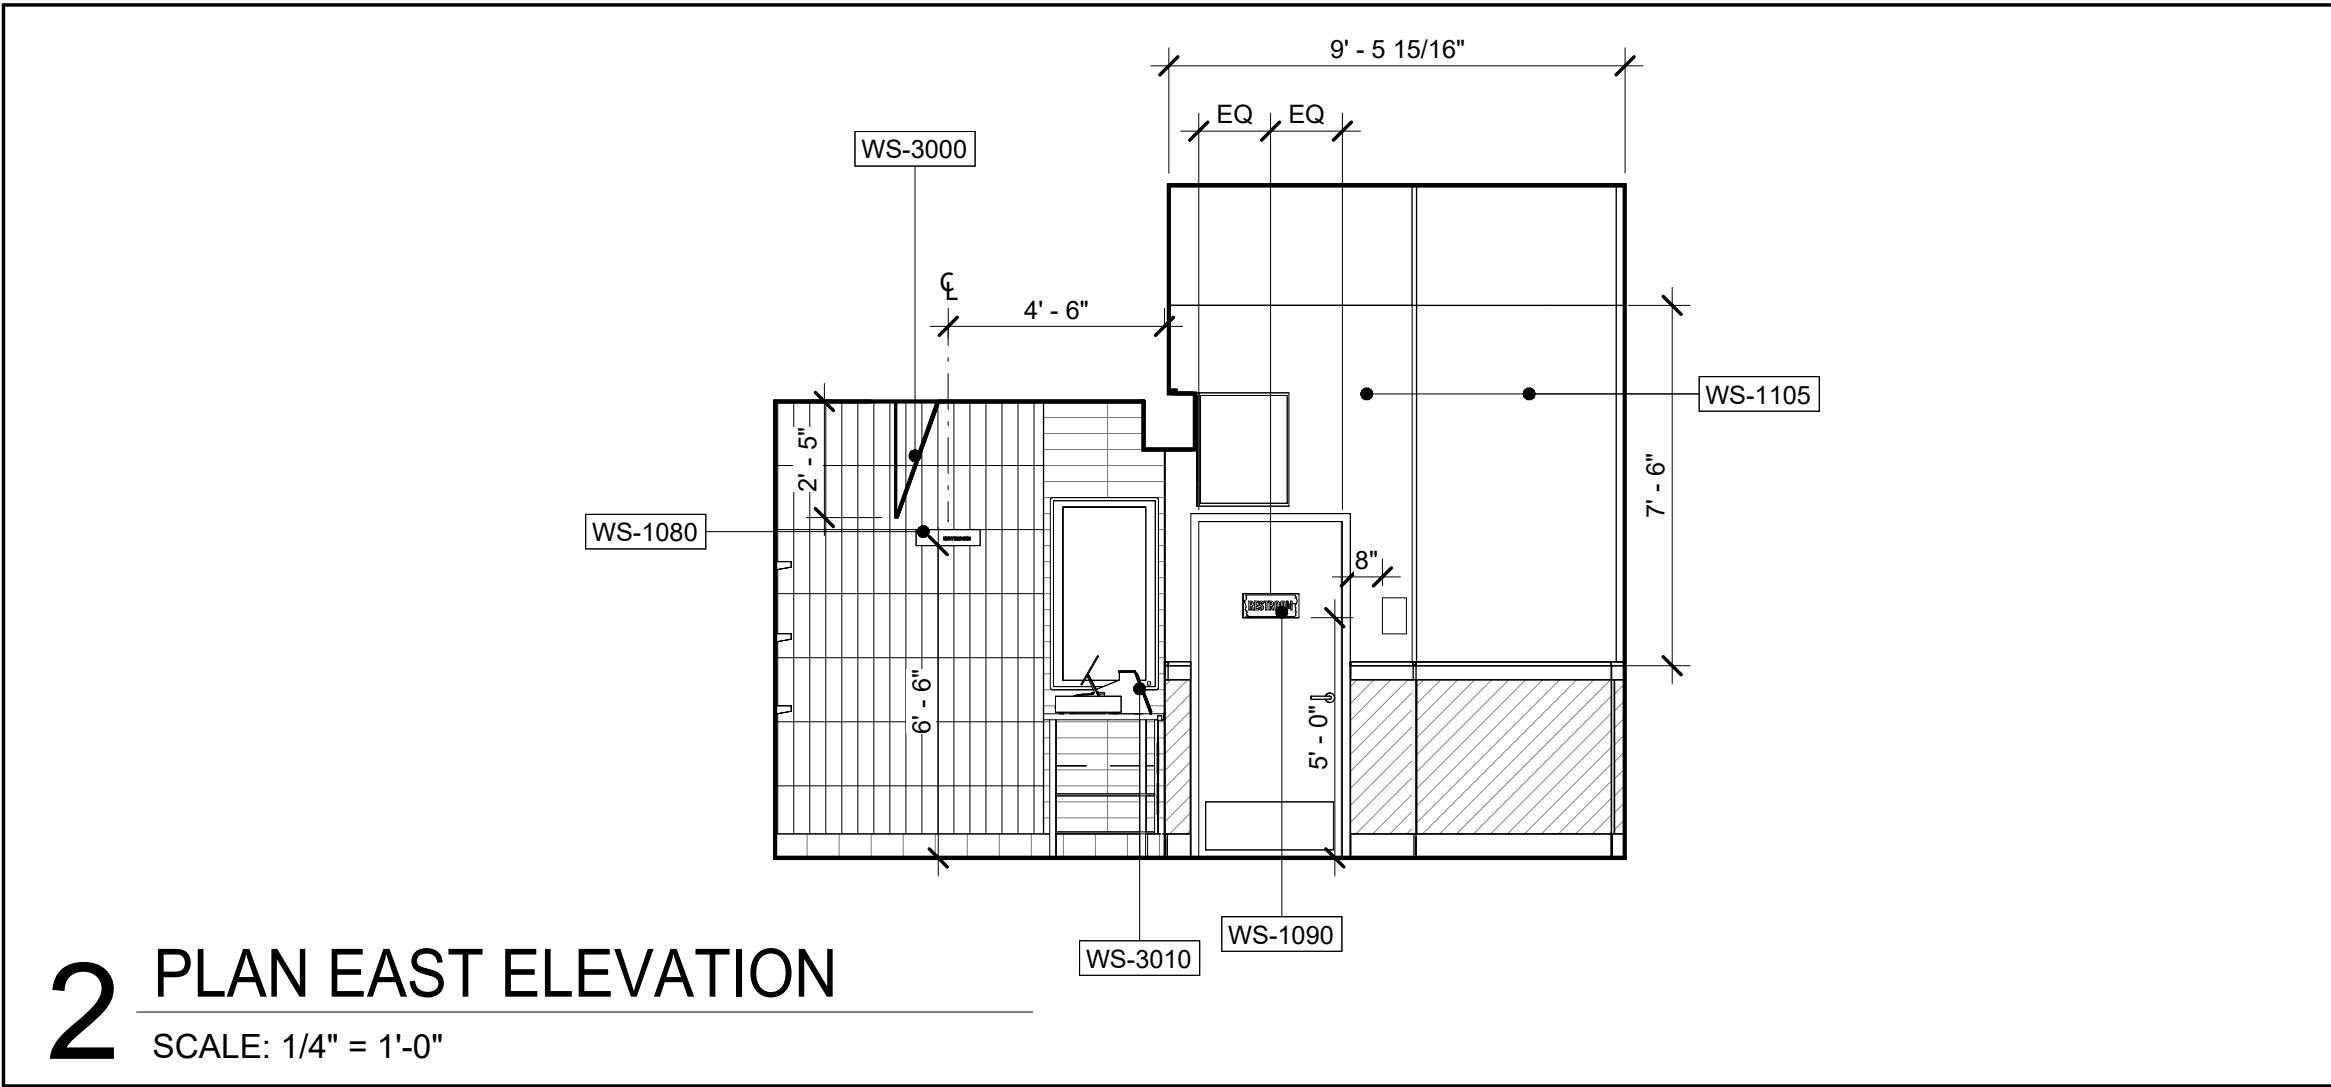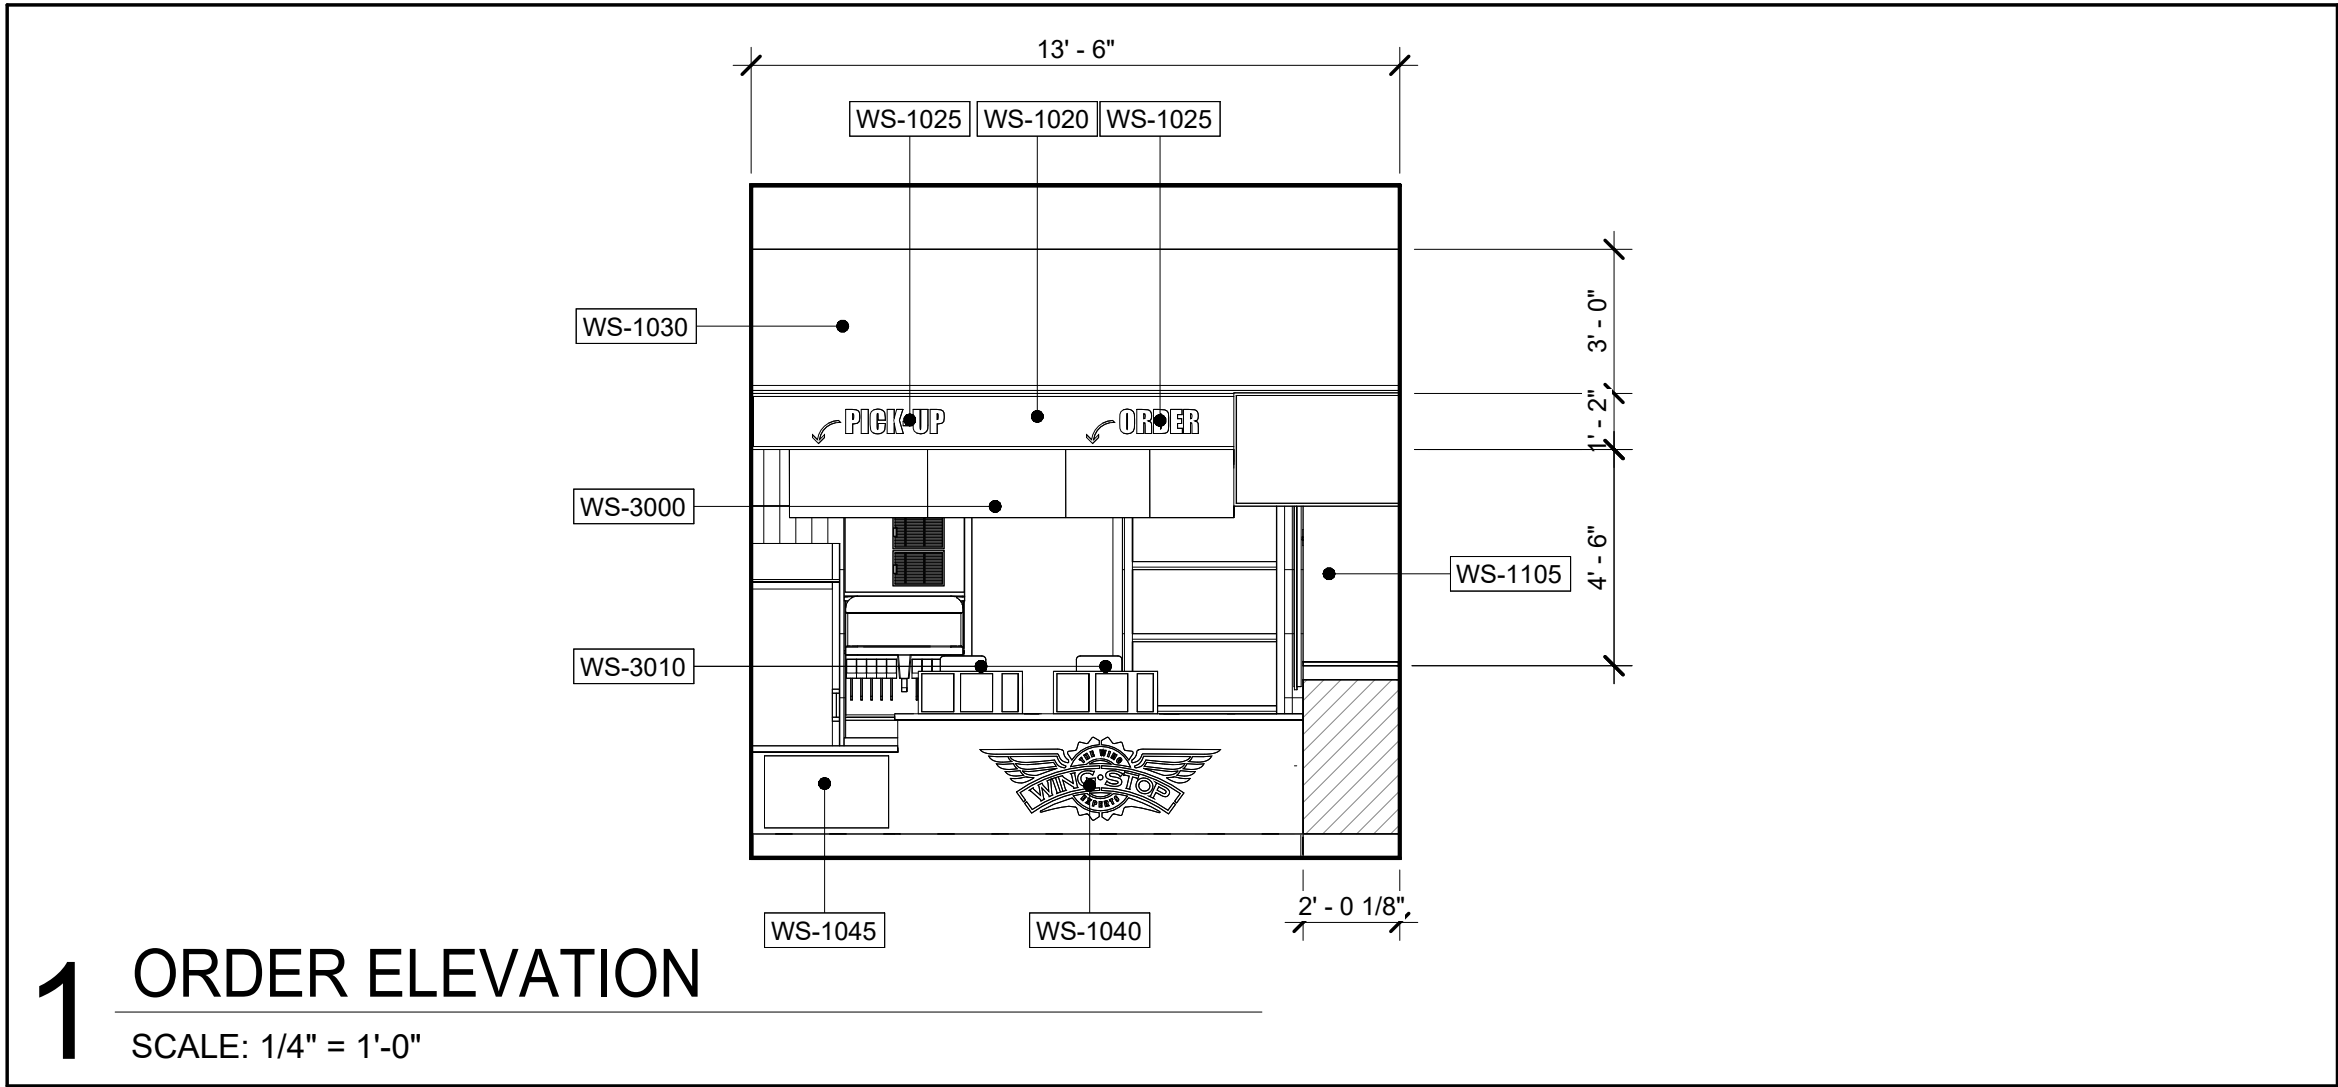



LOCALIZATION INFORMATION

BRAND PARTNER TO CONFIRM THE PREFERRED NAME FOR THIS PROJECT'S SIGNAGE "LOCALIZATION", THIS NAME WILL APPEAR ON LOCALLY BRANDED SIGNAGE:

PROPOSED LOCATION NAMING:

PETWORTH

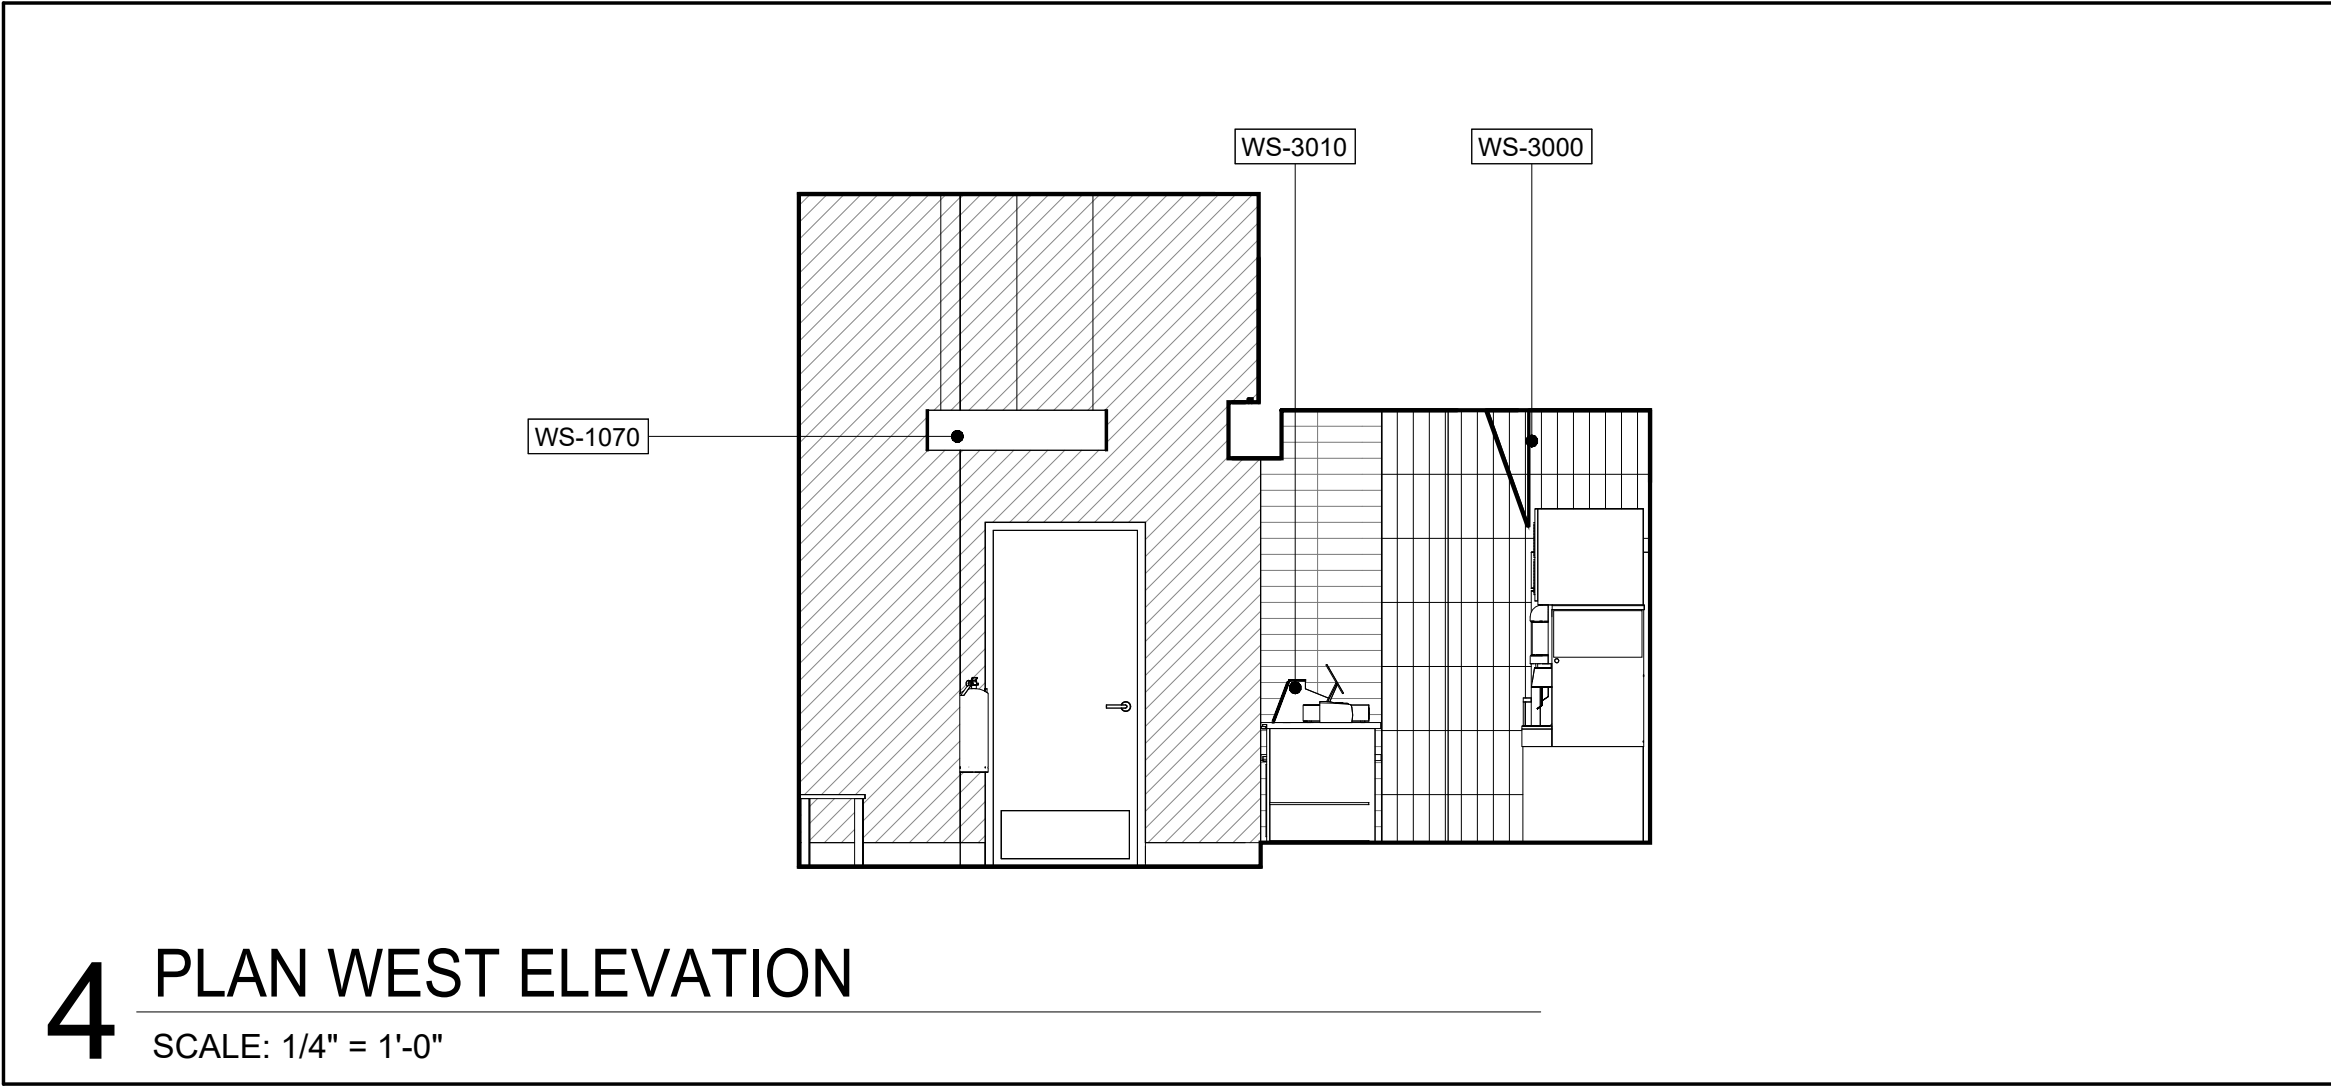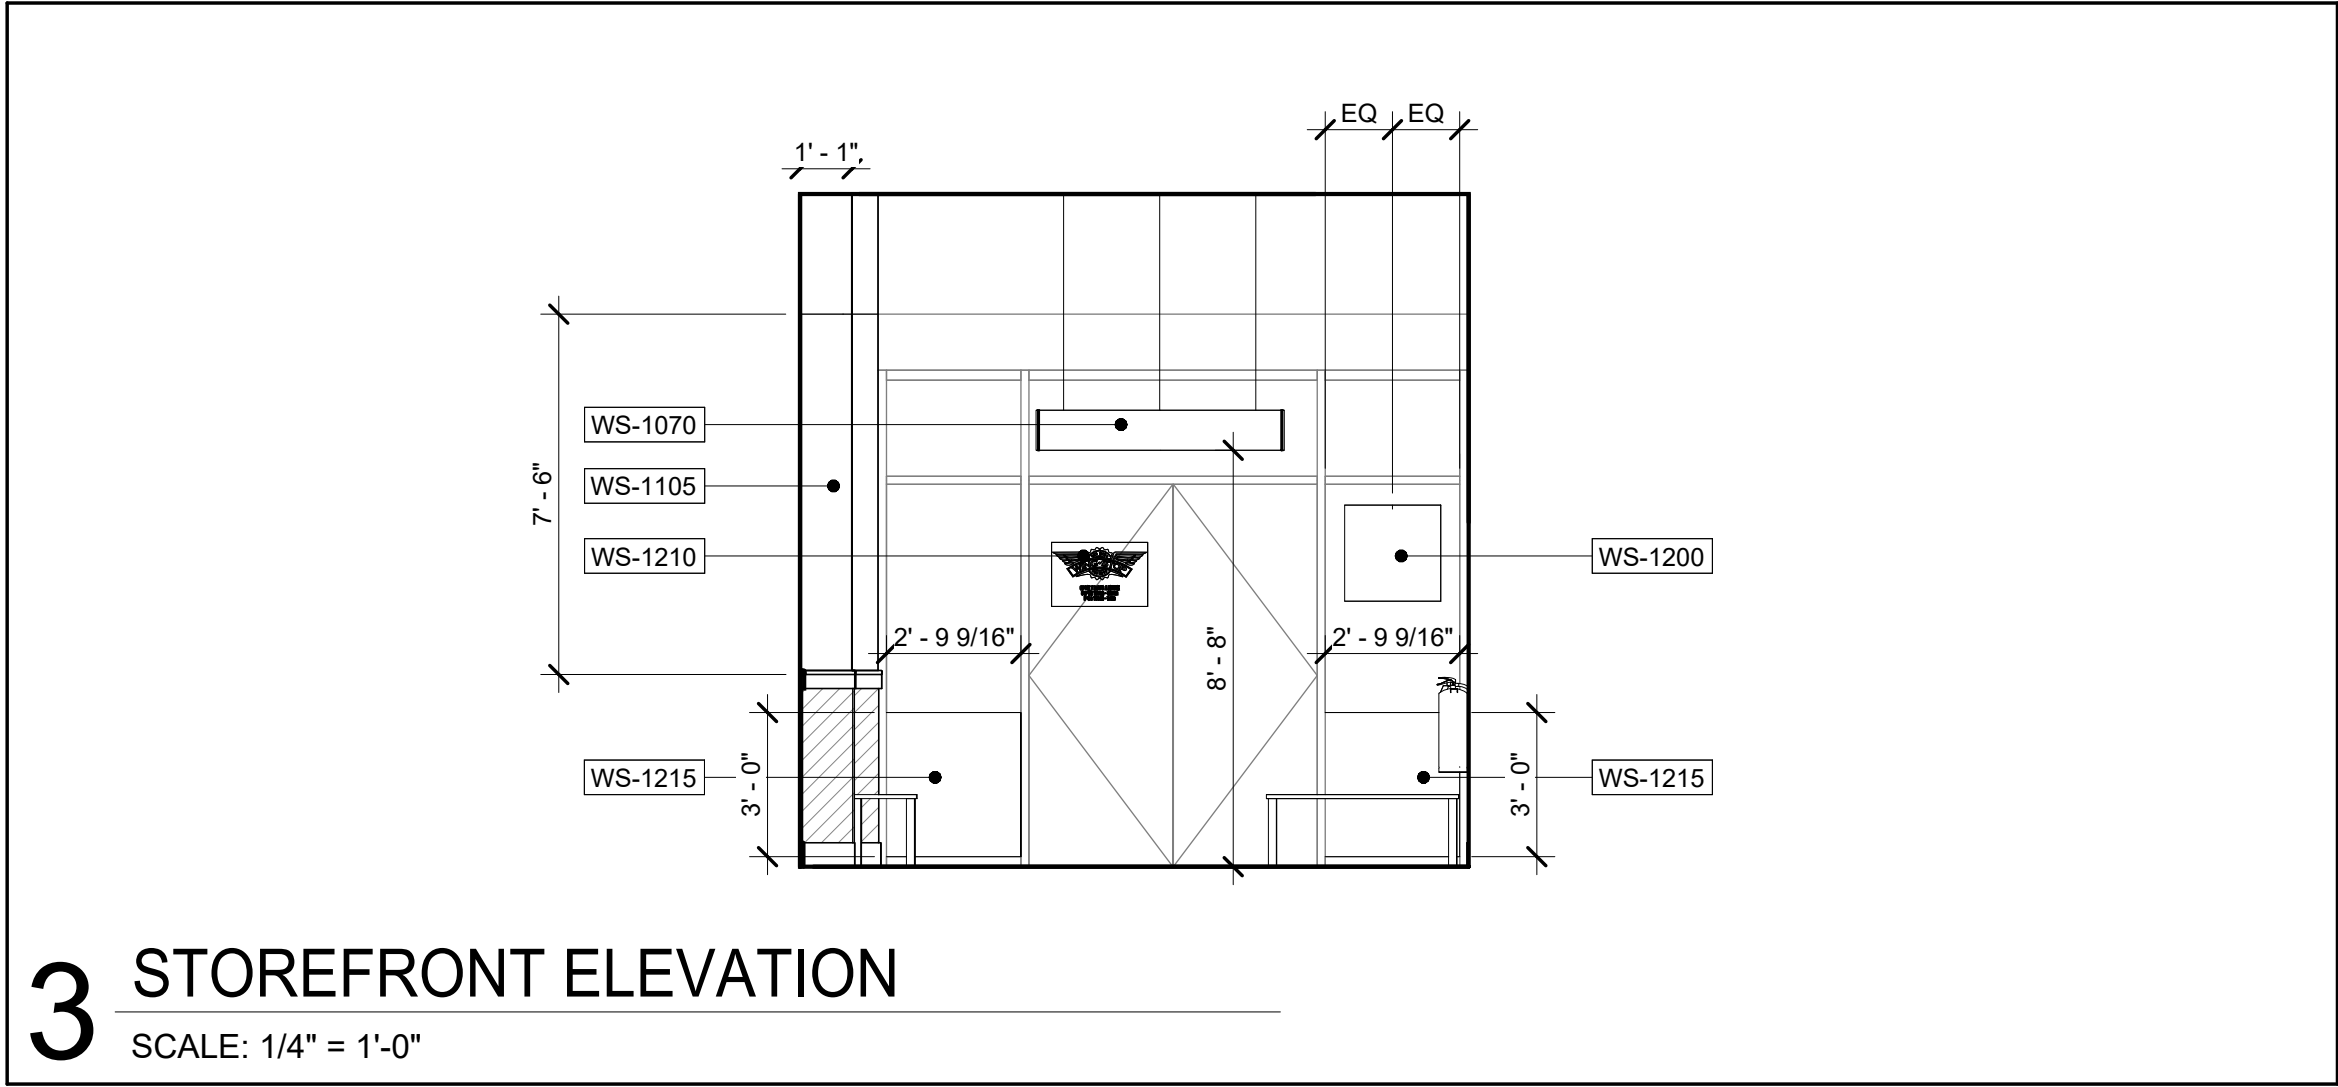

DÉCOR LEGEND				
ITEM	DESCRIPTION	SUPPLIER	INSTALLER	REMARKS
WS-1020	SALES HEADER	OWNER	GC	
WS-1025	ORDER AND PICKUP WAYFINDING	OWNER	GC	
WS-1030	METAL MESH PRINTED PATTERN - WALLCOVERING	OWNER	GC	
WS-1040	POS COUNTER LOGO	OWNER	GC	
WS-1045	PICK-UP COUNTER SIGN	OWNER	GC	
WS-1070	"HALO" CIRCULAR CEILING DECOR WITH LOCALIZED NAMING INTERGRATED	OWNER	GC	
WS-1080	OWNER'S PLAQUE	OWNER	GC	
WS-1090	RESTROOM SIGNAGE - DOOR	OWNER	GC	
WS-1105	WINGS / FRIES / FLAVOR / REPEAT	OWNER	GC	
WS-1200	"OPEN LATE" LED SIGNAGE	OWNER	GC	
WS-1210	STORE HOURS - FRONT DOOR SIGNAGE	OWNER	GC	
WS-1215	STOREFRONT VINYL GRAPHICS - "FLAVOR"	OWNER	GC	
WS-3000	MENU BOARD	OWNER	GC	
WS-3010	POS SHROUD	OWNER	GC	



CONSULTANT



2801 NORTH CENTRAL
EXPRESSWAY, SUITE 1600
DALLAS, TX 75204
TELEPHONE: (972) 686-6500
FAX: (972) 686-6502

THESE DRAWINGS, IDEAS, SPECIFICATIONS AND
DESIGNS ARE EXCLUSIVE PROPERTY OF
WINGSTOP RESTAURANTS, INC. NO PART OF
THESE DRAWINGS MAY BE COPIED,
REPRODUCED, OR OTHER STRUCTURES BUILT
FROM SUCH WITHOUT THE WRITTEN CONSENT
OF WINGSTOP RESTAURANTS, INC.


COPYRIGHT © 2025
WINGSTOP RESTAURANTS, INC.
ALL RIGHTS RESERVED

PROJECT INFORMATION

**WINGSTOP
(GL#A216)**

THE AUGUSTA ON GEORGIA
3831 GEORGIA AVENUE NW
WASHINGTON, D.C. 20009

SEAL

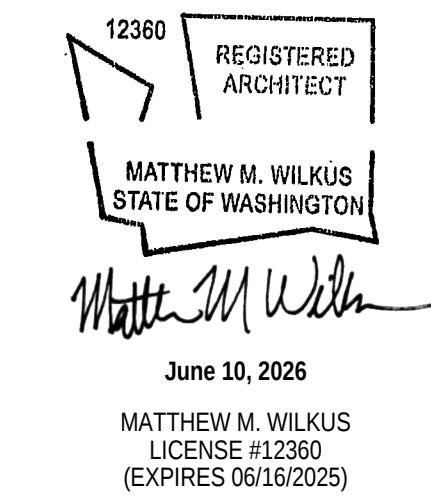

PROJECT NO. 2025-0430
DRAWN BY ANC
CHECKED BY JSS


ISSUE DATE
DESIGN INTENT REVIEW 2026/03/30
PERMIT SET 2026/06/10

REVISION DATE


NG_DELCO_2025.02

TITLE
**DÉCOR
ELEVATIONS**


SHEET NUMBER
A5.0

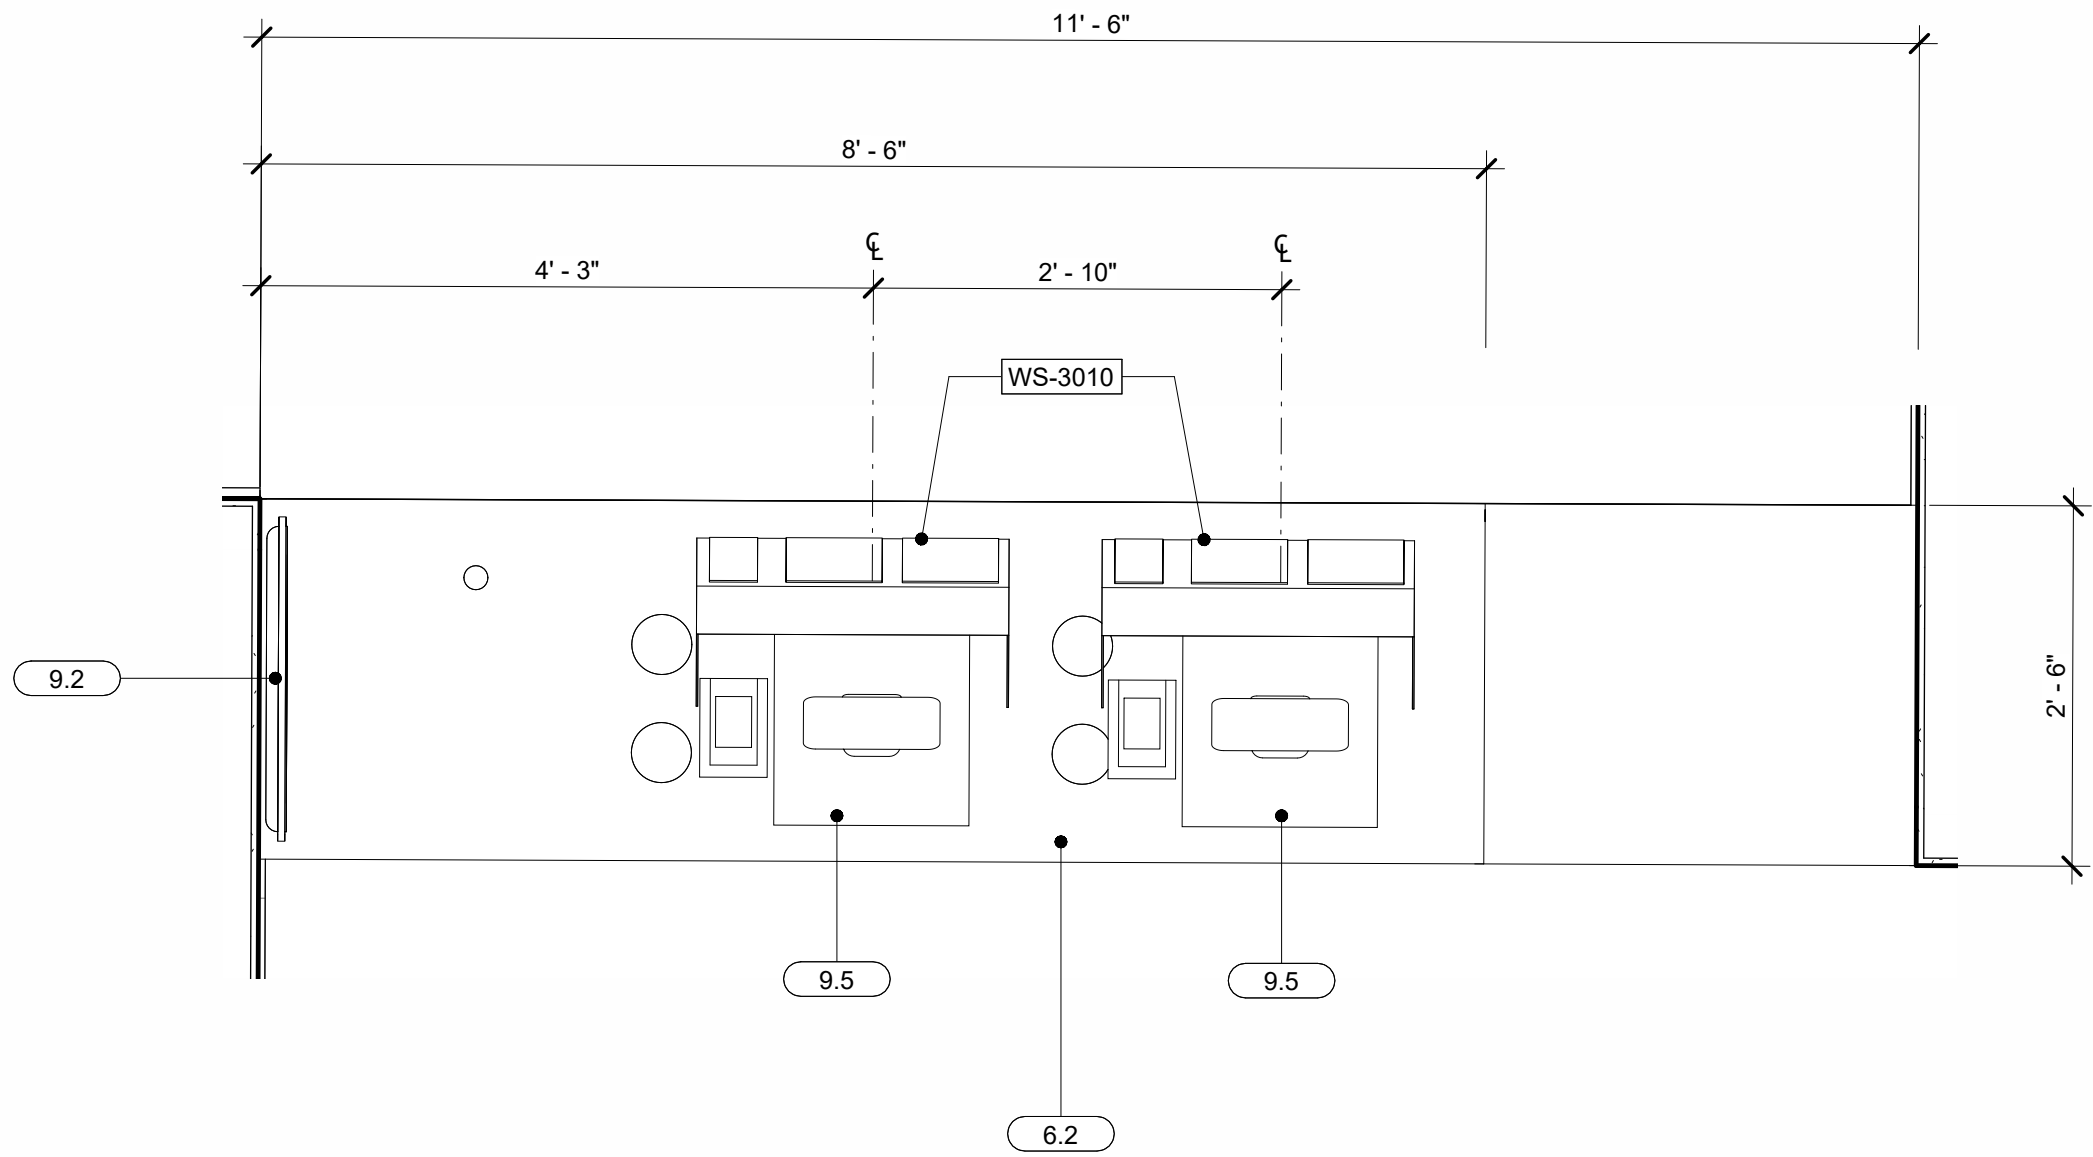


1 SALES COUNTER PLAN
SCALE: 3/4" = 1'-0"

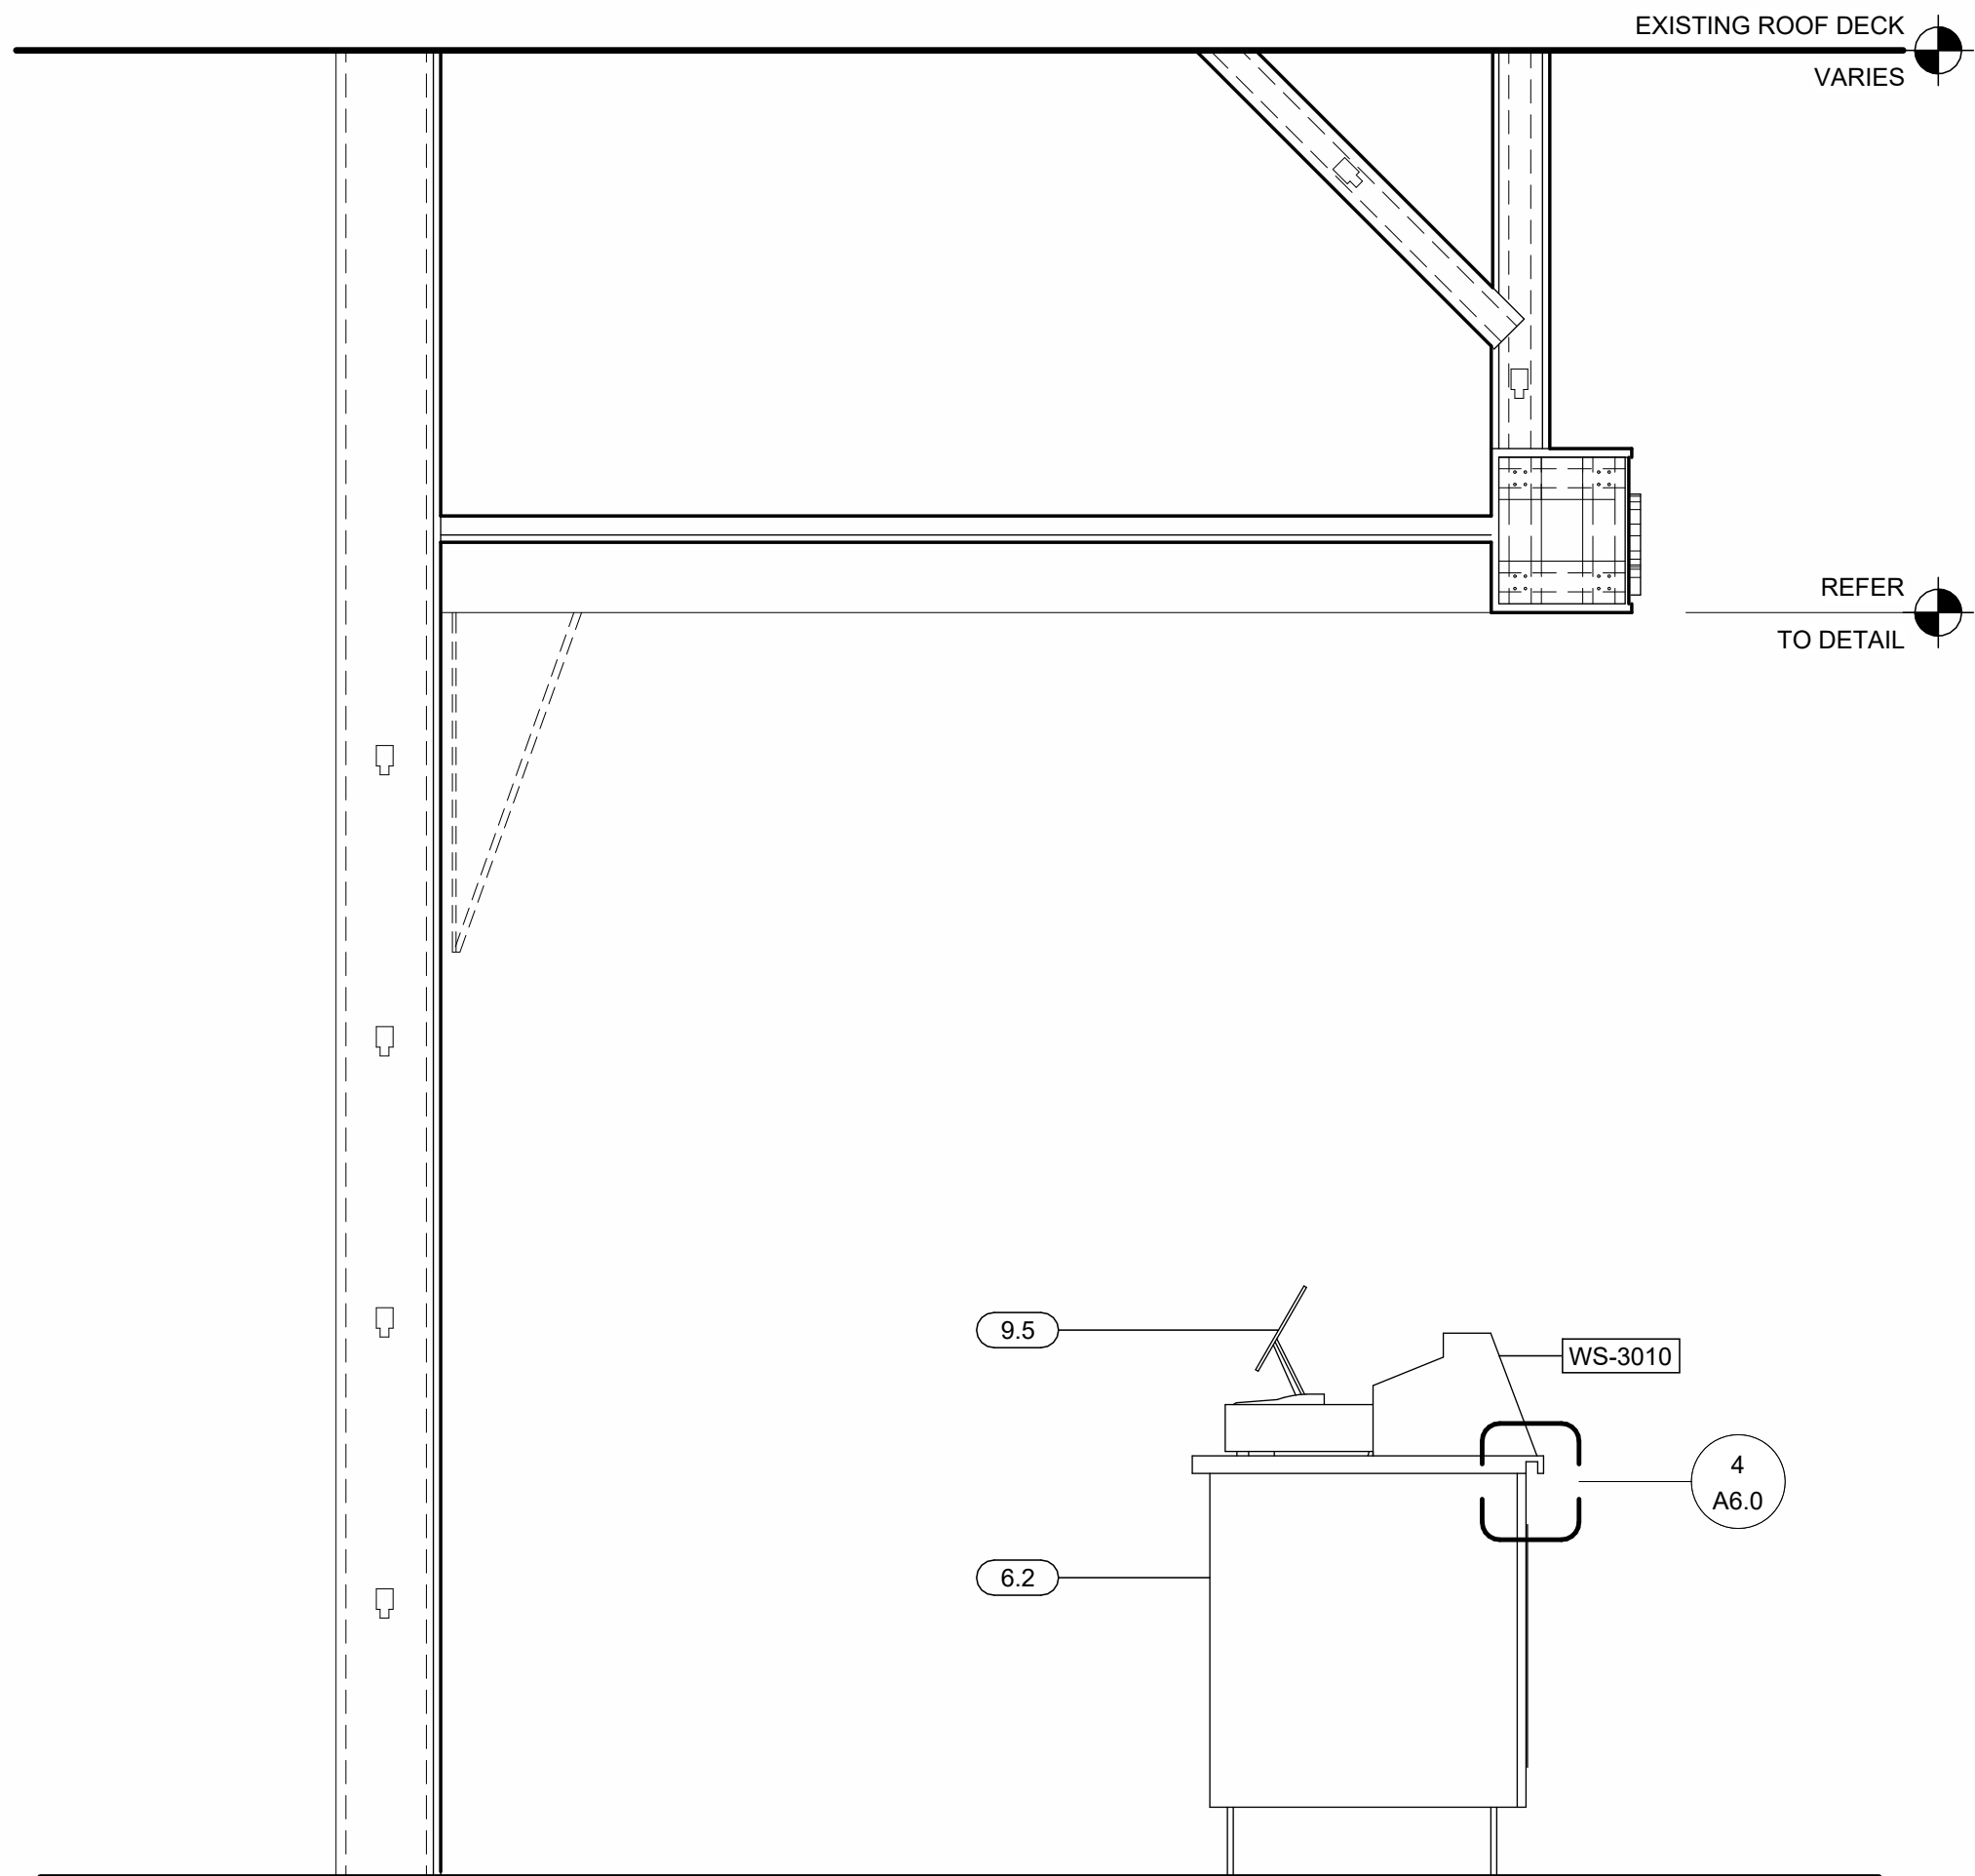

2 SALES AREA SECTION
SCALE: 3/4" = 1'-0"

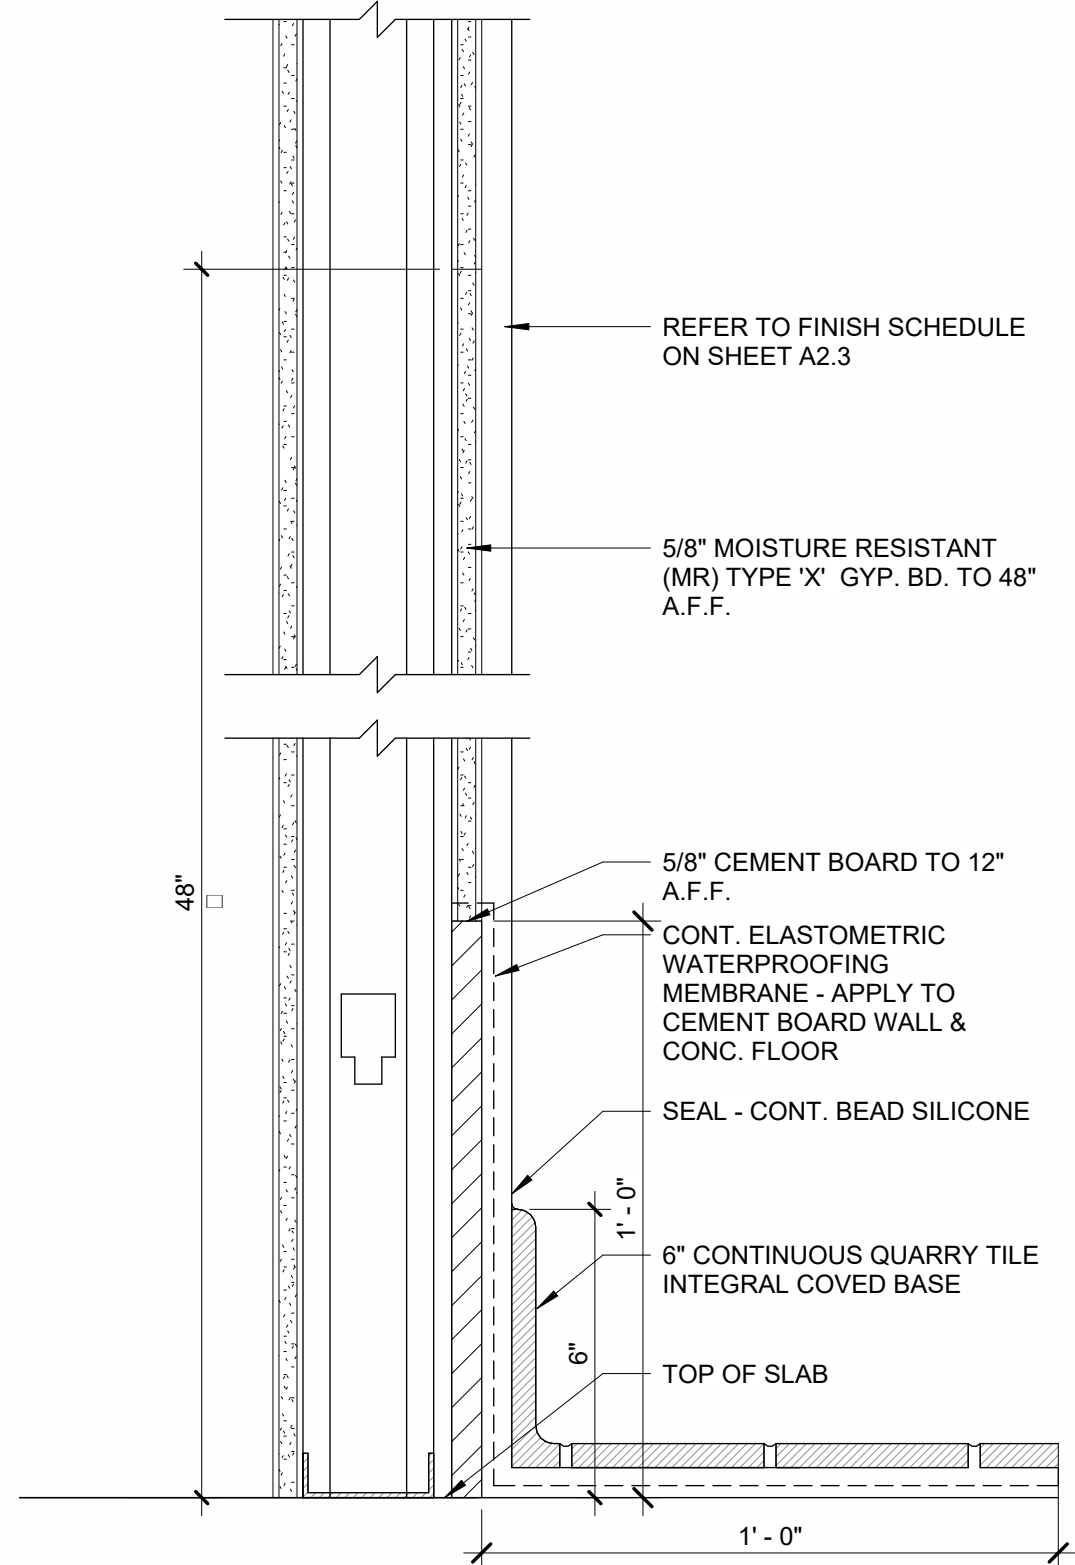

3 TYP. SHEATHING MODIFICATION
SCALE: 3" = 1'-0"

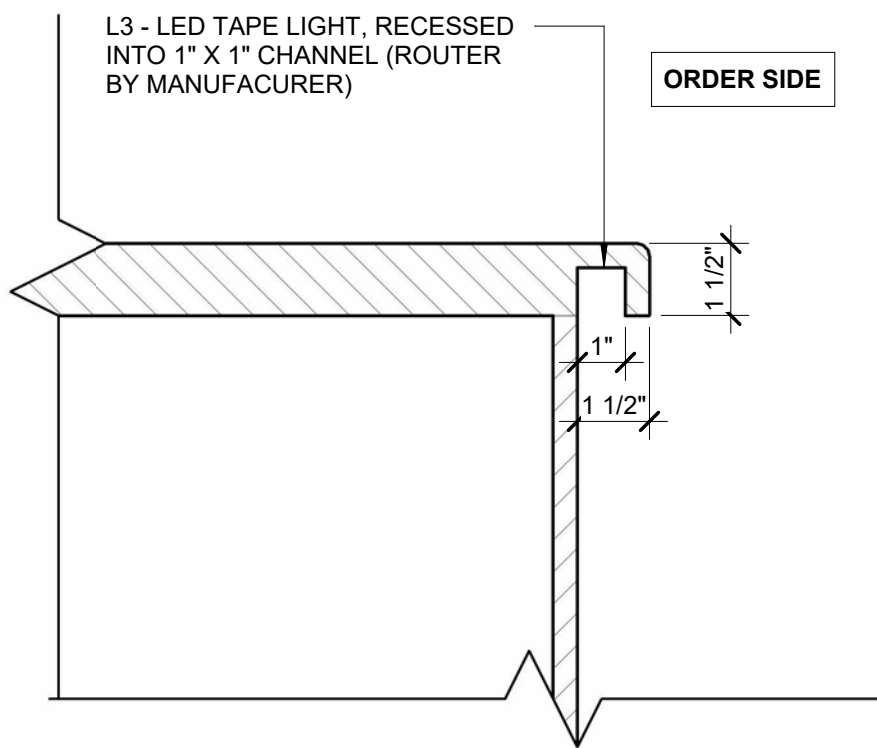

4 COUNTERTOP LIGHTING
SCALE: 3" = 1'-0"

CONSULTANT




THESE DRAWINGS, IDEAS, SPECIFICATIONS AND DESIGNS ARE EXCLUSIVE PROPERTY OF WINGSTOP RESTAURANTS, INC. NO PART OF THESE DRAWINGS MAY BE COPIED, REPRODUCED, OR OTHER STRUCTURES BUILT FROM SUCH WITHOUT THE WRITTEN CONSENT OF WINGSTOP RESTAURANTS, INC.

COPYRIGHT © 2025 WINGSTOP RESTAURANTS, INC. ALL RIGHTS RESERVED

PROJECT INFORMATION

**WINGSTOP
(GL#A216)**

THE AUGUSTA ON GEORGIA
3831 GEORGIA AVENUE NW
WASHINGTON, D.C. 20009

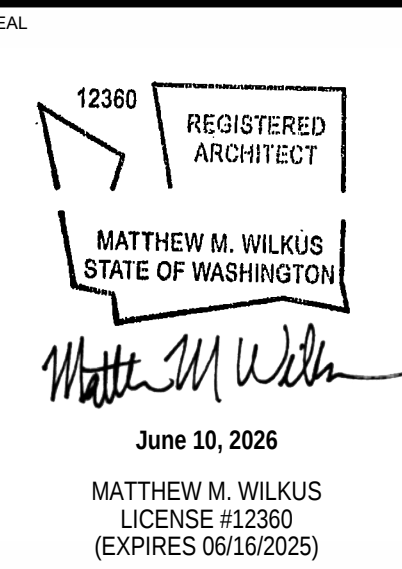

PROJECT NO. 2025-0430
DRAWN BY ANC
CHECKED BY JSS


ISSUE DATE
DESIGN INTENT REVIEW 2026/03/30
PERMIT SET 2026/06/10

REVISION DATE

NG_TRAD_2025.02

TITLE
SECTIONS AND
DETAILS

SHEET NUMBER
A6.0

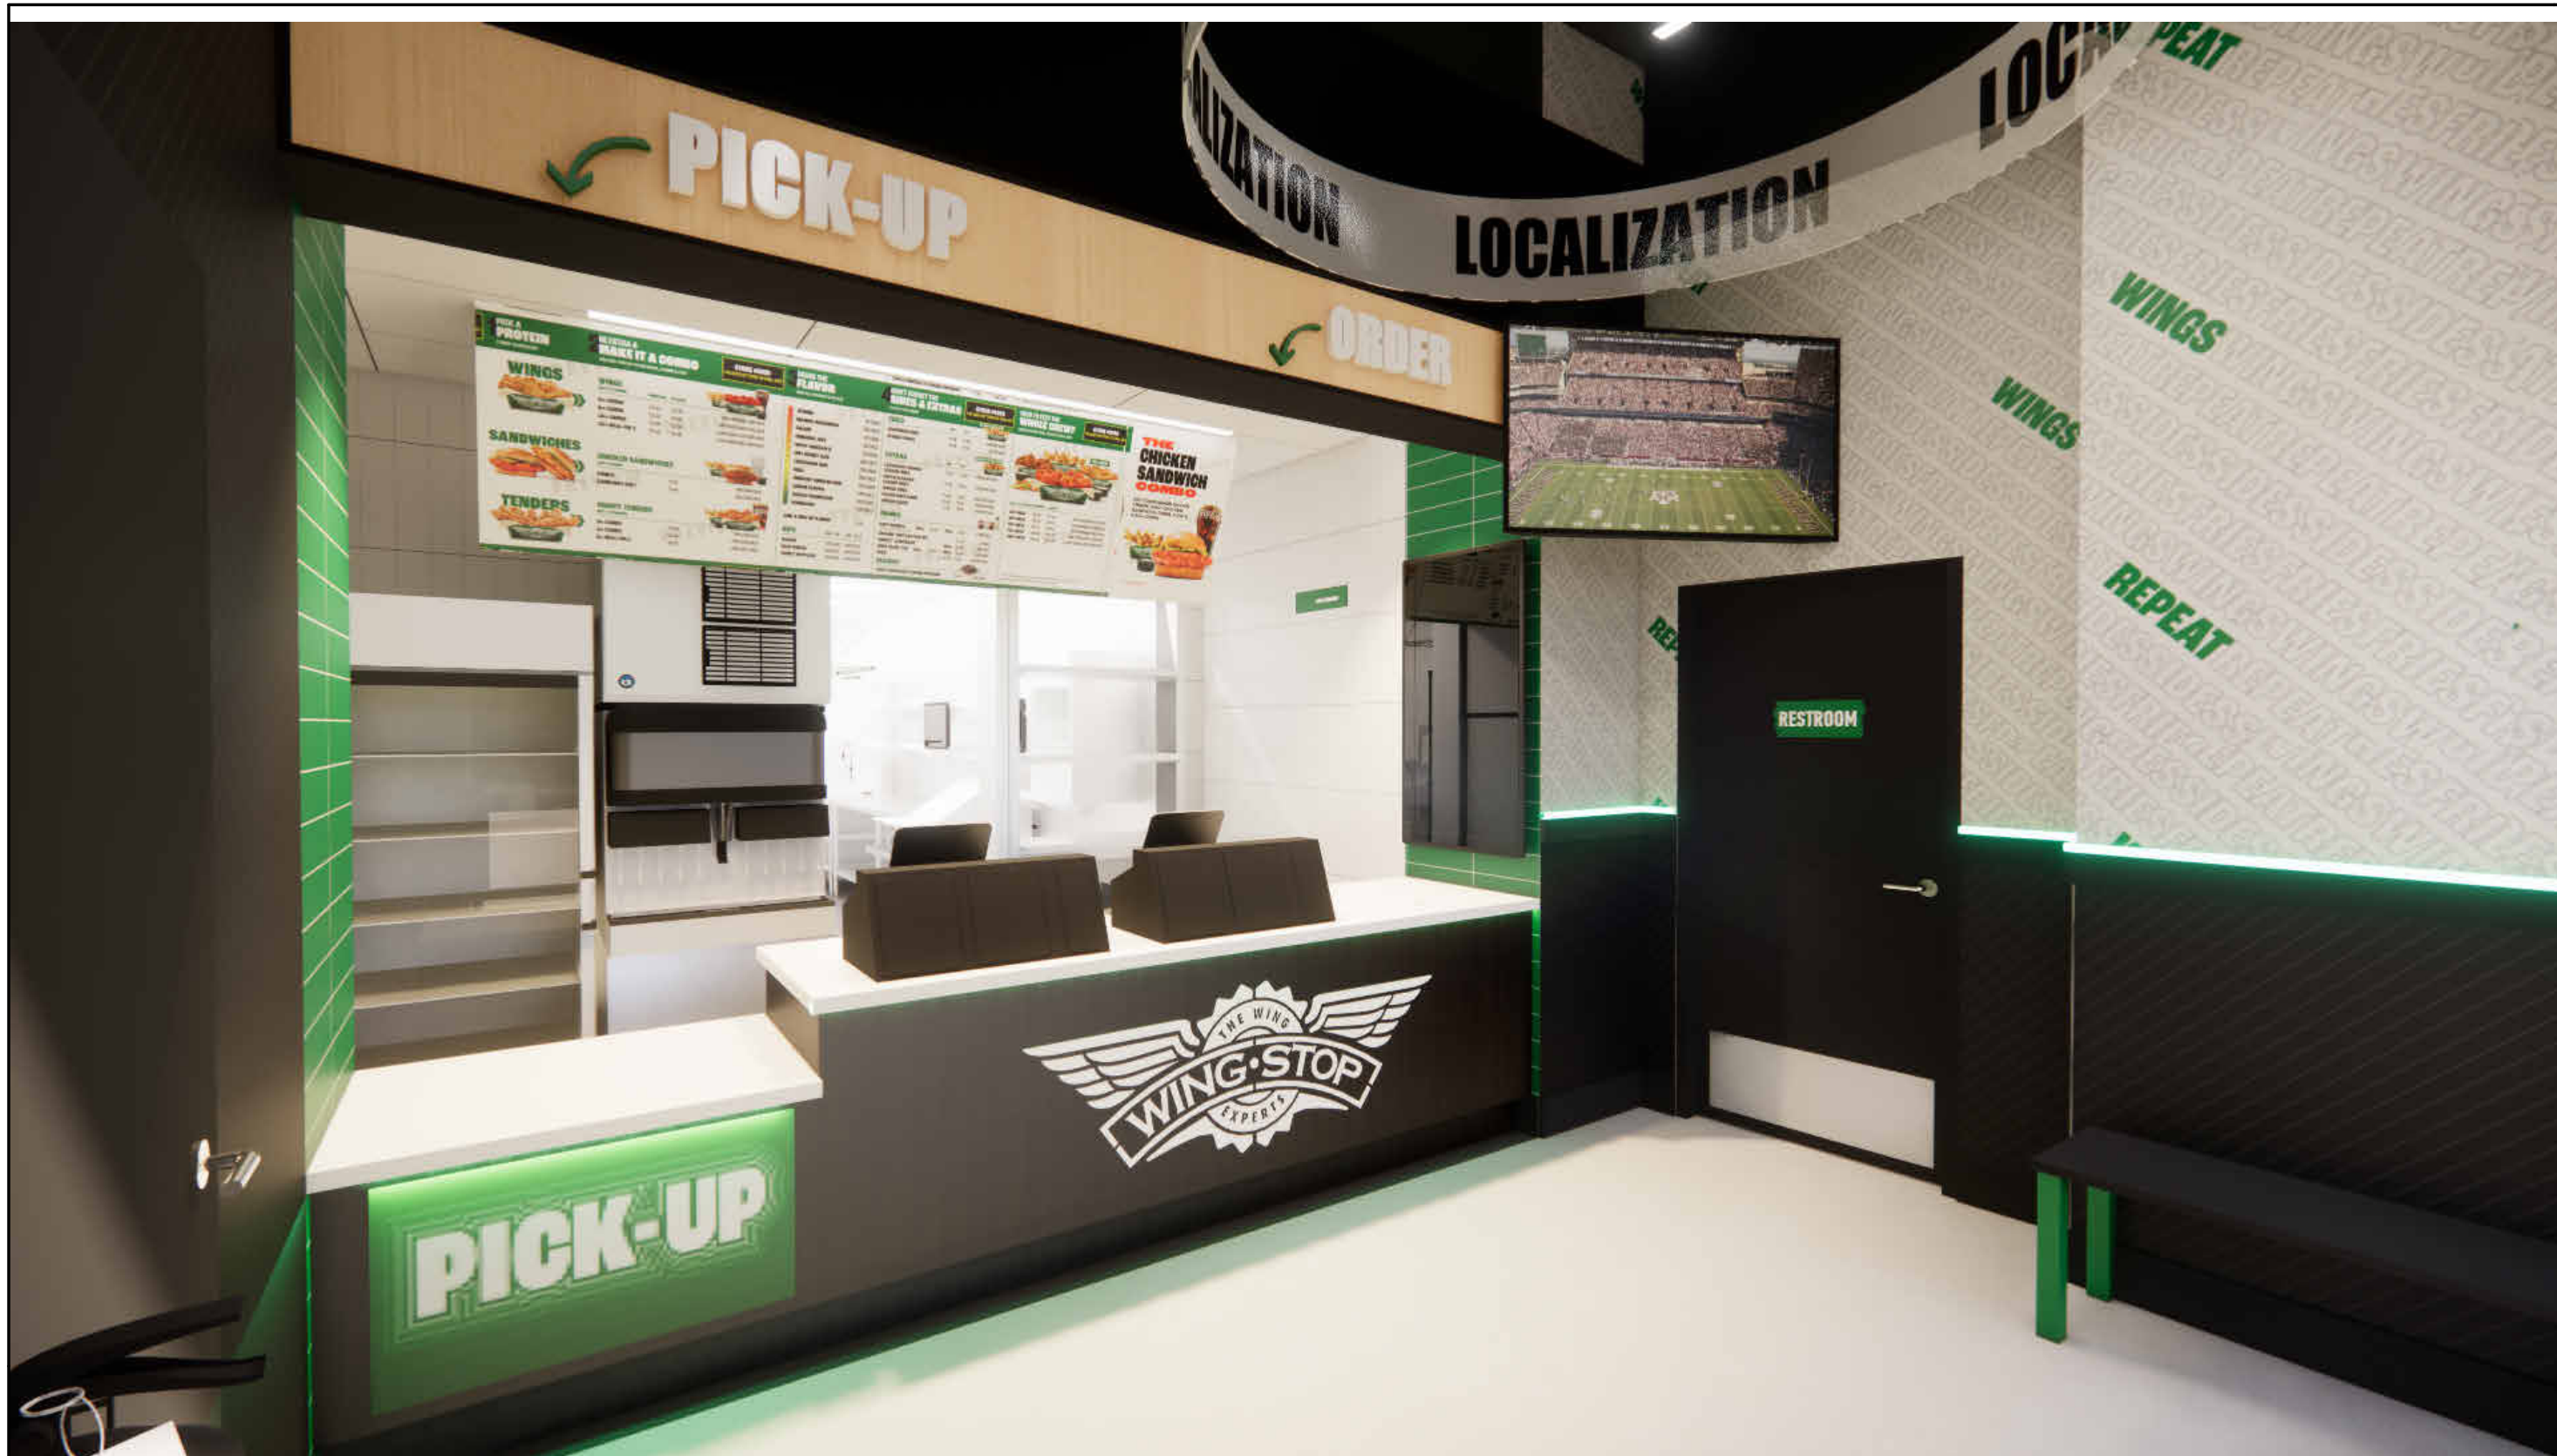


VIEW FROM FRONT DOOR



VIEW FROM SALES COUNTER



VIEW OF SALES COUNTER

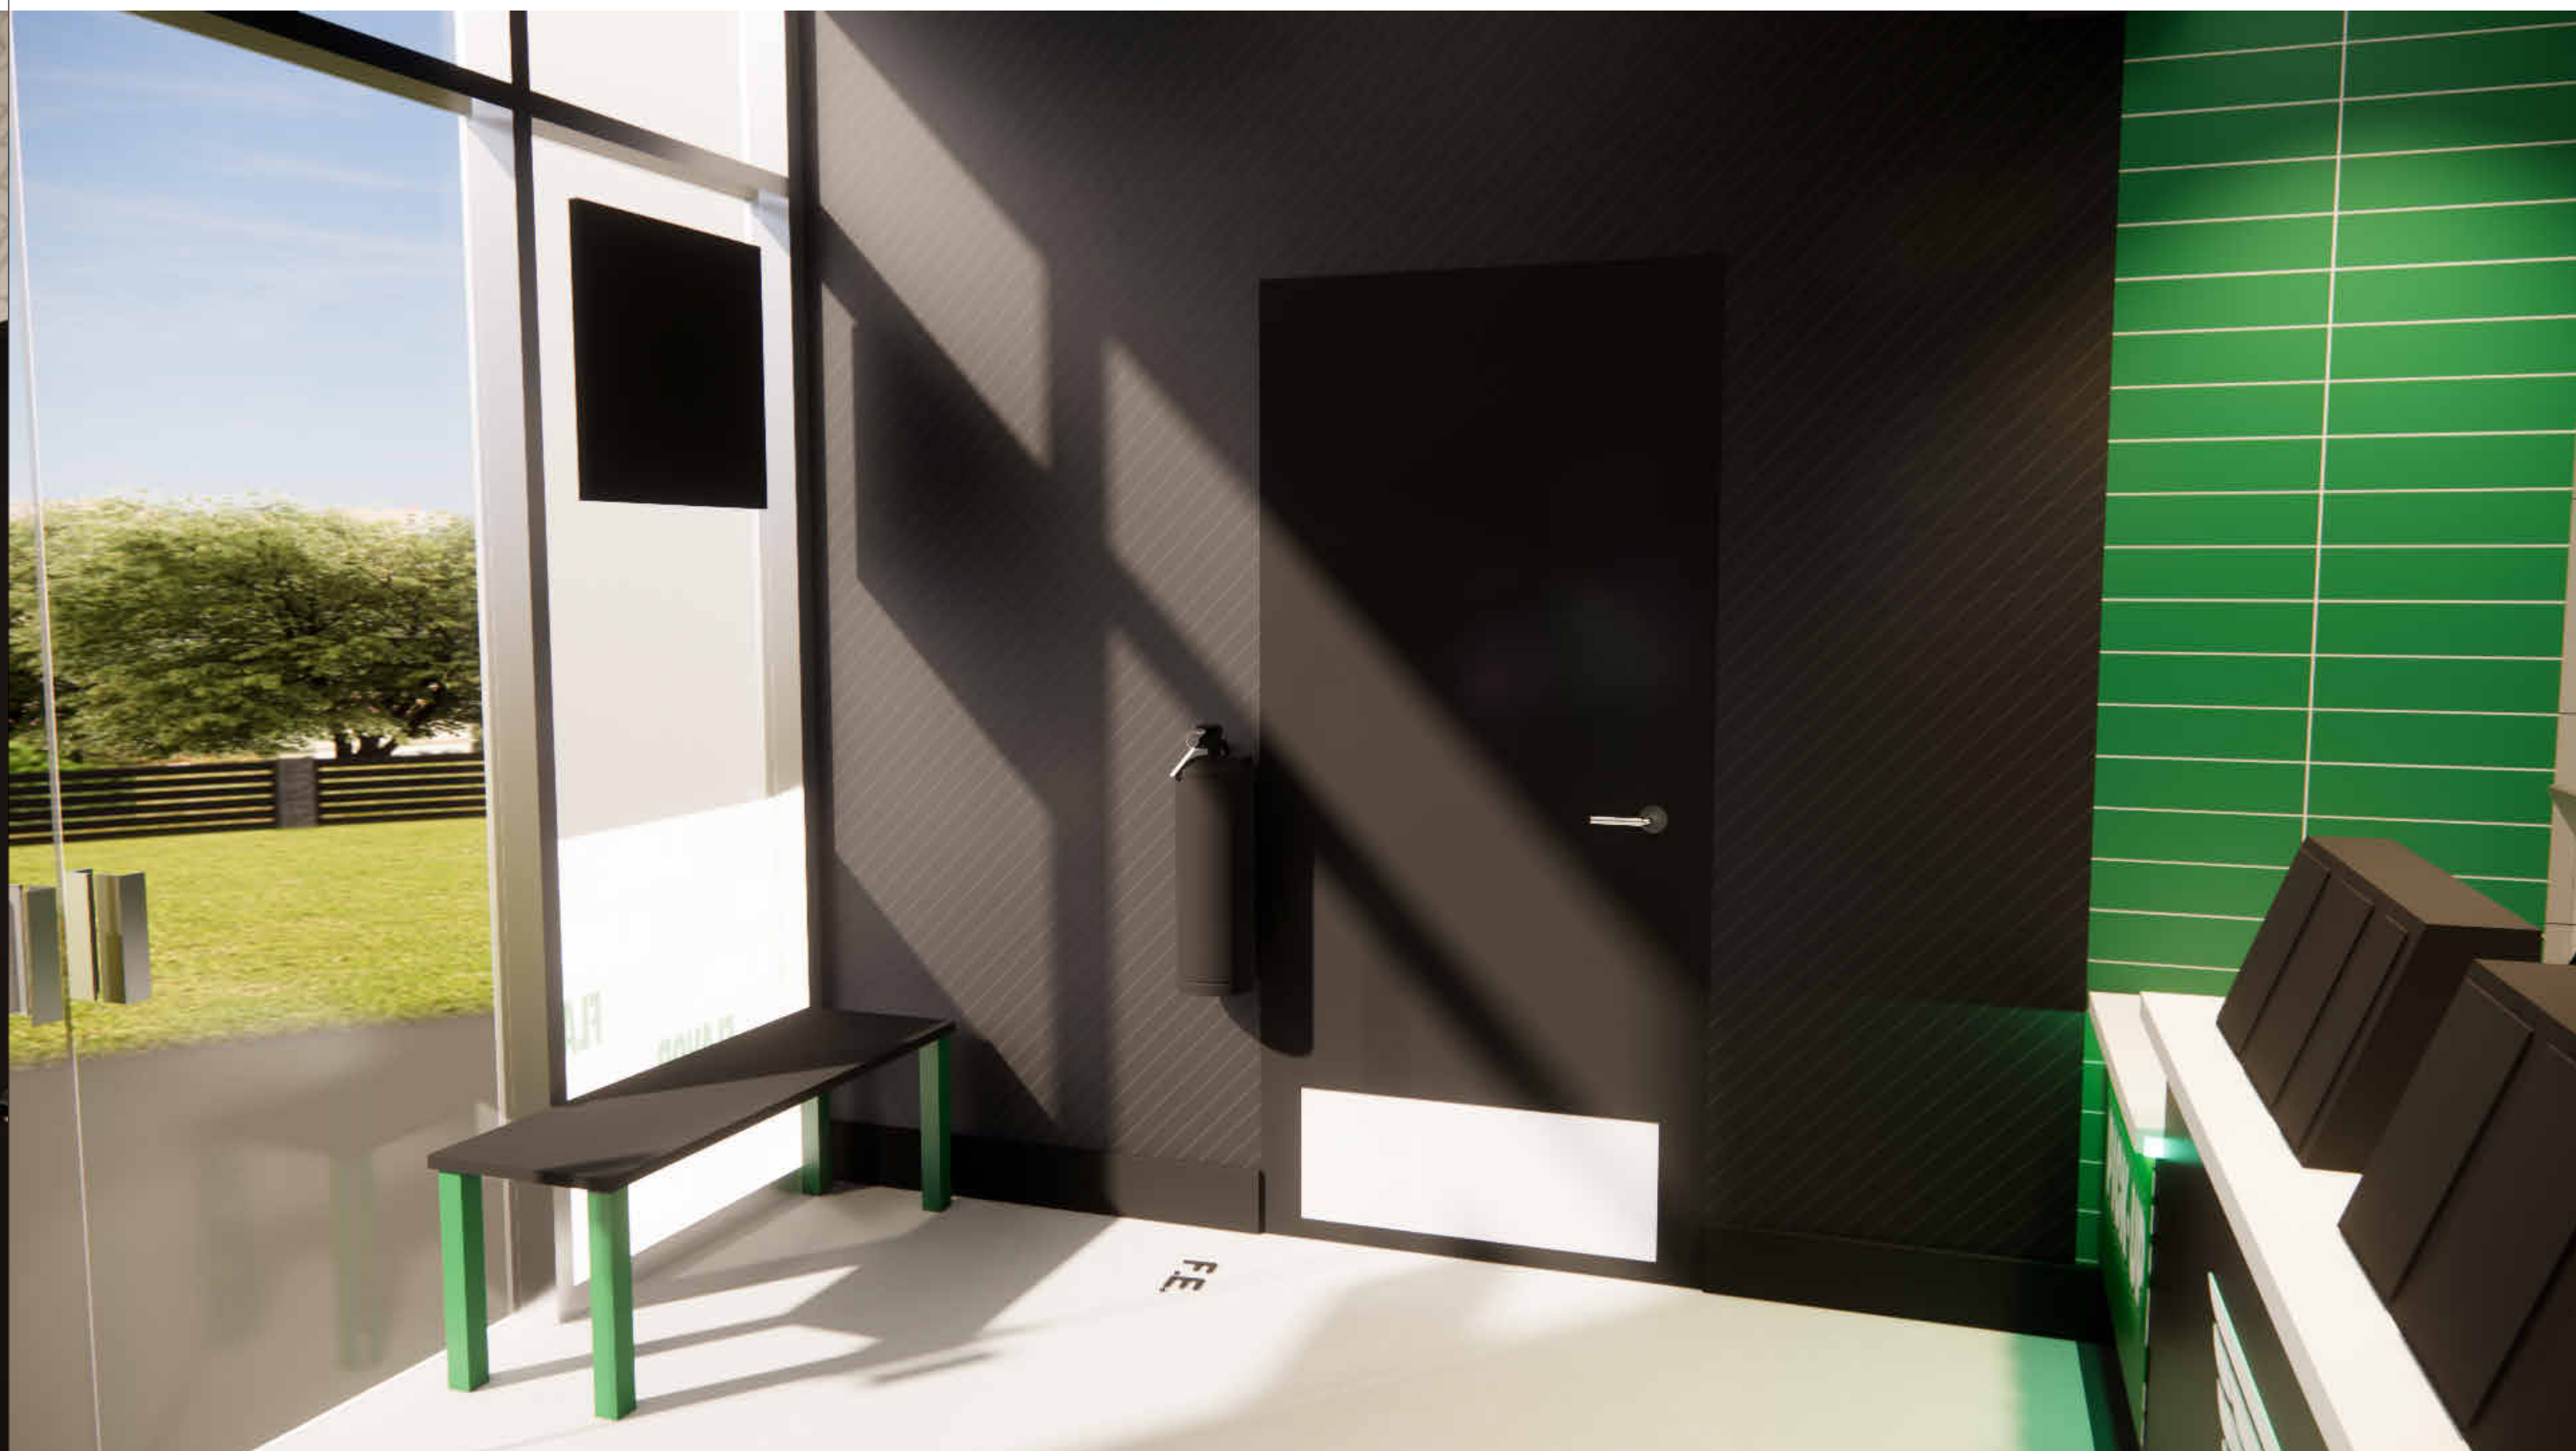

VIEW OF WAITING AREA

CONSULTANT



2801 NORTH CENTRAL
EXPRESSWAY, SUITE 1600
DALLAS, TX 75204
TELEPHONE: (972) 686-6500
FAX: (972) 686-6502


THESE DRAWINGS, IDEAS, SPECIFICATIONS AND
DESIGNS ARE EXCLUSIVE PROPERTY OF
WINGSTOP RESTAURANTS, INC. NO PART OF
THESE DRAWINGS MAY BE COPIED,
REPRODUCED, OR OTHER STRUCTURES BUILT
FROM SUCH WITHOUT THE WRITTEN CONSENT
OF WINGSTOP RESTAURANTS, INC.

COPYRIGHT © 2025
WINGSTOP RESTAURANTS, INC.
ALL RIGHTS RESERVED

PROJECT INFORMATION

**WINGSTOP
(GL#A216)**
THE AUGUSTA ON GEORGIA
3831 GEORGIA AVENUE NW
WASHINGTON, D.C. 20009

SEAL

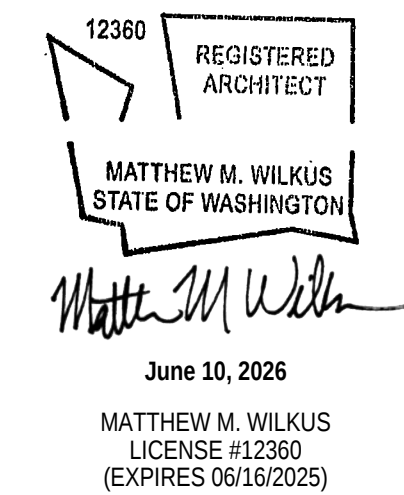

PROJECT NO. 2025-0430
DRAWN BY ANC
CHECKED BY JSS

ISSUE DATE
DESIGN INTENT REVIEW 2026/03/30
PERMIT SET 2026/06/10

REVISION DATE

NG_DELCO_2025.02

TITLE

PERSPECTIVES

SHEET NUMBER

A7.0



2801 NORTH CENTRAL
EXPRESSWAY, SUITE 1600
DALLAS, TX 75204
TELEPHONE: (972) 686-6500
FAX: (972) 686-6502

THESE DRAWINGS, IDEAS, SPECIFICATIONS AND
DESIGNS ARE EXCLUSIVE PROPERTY OF
WINGSTOP RESTAURANTS, INC. NO PART OF
THESE DRAWINGS MAY BE COPIED,
REPRODUCED, OR OTHER STRUCTURES BUILT
FROM SUCH WITHOUT THE WRITTEN CONSENT
OF WINGSTOP RESTAURANTS, INC.

COPYRIGHT © 2025
 WINGSTOP RESTAURANTS, INC.
 ALL RIGHTS RESERVED

PROJECT INFORMATION

OBJECT INFORMATION

WINGSTOP
(GL#A216)

THE AUGUSTA ON GEORGIA
3831 GEORGIA AVENUE NW



VIEW OF HALLWAY



VIEW FROM WALK-IN



VIEW OF PILOT AND WINGMAN STATIONS



VIEW OF DISH ROOM

12360

REGISTERED
ARCHITECT

MATTHEW M. WILKUS
STATE OF WASHINGTON

Matthew M Wilkus

June 10, 2026

MATTHEW M. WILKUS
LICENSE #12360
(EXPIRES 06/16/2025)

PROJECT NO.	2025-0430
DRAWN BY	ANC
CHECKED BY	JSS

ISSUE	DATE
DESIGN INTENT REVIEW	2026/03/
PERMIT SET	2026/06/

REVISION	DATE
----------	------

NG_DELCO_2025.02

PERSPECTIVES


SHEET NUMBER

A7.1


EQUIPMENT GENERAL NOTES	
A.	ALL SWITCHES, COVER PLATES, AND PLUGS IN THE COOKING, JANITOR AND PREPERATION AREAS SHALL BE 'STAINLESS STEEL'.
B.	ALL COVER PLATES AND PLUGS BELOW 4'-0" AND INSTALLED AT (WP1) IN ORDER, DINING, AND HALLWAY AREAS TO BE 'BLACK'.
C.	THE GENERAL CONTRACTOR SHALL PROVIDE THE MOUNTING OF TRANSFORMERS AND FINAL ELECTRICAL CONNECTION OF THE OWNER PROVIDED AND INSTALLED INTERIOR AND EXTERIOR BUILDING SIGNAGE. ALL SIGNS SHALL BE ON INDIVIDUAL CIRCUITS WITH DEDICATED GROUNDS COOKING AREA PROTECTION SYSTEM SHALL BE SUBMITTED FOR PLAN REVIEW UNDER A SEPARATE PLAN CHECK AN PERMIT
D.	NOTE: EXTERIOR SIGNAGE SHALL BE SUBMITTED UNDER SEPARATE PLAN CHECK REVIEW AND PERMIT PROCESS.
E.	

KEYNOTE LEGEND	
1	PROVIDE DEDICATED CIRCUIT AND GROUND FOR LED SIGNS - TYPICAL - REFER TO ELECTRICAL DRAWINGS FOR ADDITIONAL INFORMATION
2	PROVIDE DEDICATED CIRCUIT AND GROUND WITH CIRCUIT TIMER FOR EXTERIOR BUILDING SIGN - TYPICAL - VERIFY LOCATION WITH SIGN VENDOR - REFER TO ELECTRICAL DRAWINGS FOR ADDITIONAL INFORMATION
3	REMOTE HOOD FIRE SUPPRESSION PULL STATION - VERIFY LOCATION(S) WITH LOCAL FIRE MARSHAL
4	GAS SERVICE CONNECTION - REFER TO MECHANICAL DRAWINGS FOR ADDITIONAL INFORMATION
5	6" P.V.C. BEVERAGE CONDUIT RUN IN CEILING WITH 6" 90's AND 6" P.V.C. IN PARTITIONS - REFER TO DETAIL "CHASE DETAIL @ SODA MACHINE" FOR ADDITIONAL INFORMATION
6	CENTER TIMER ON FRYER BANK
7	NOT USED

EQUIPMENT LEGEND NOTES	
1.	FLAT PANEL TV DISPLAY WALL MOUNTING BRACKET & MONITOR BRAND SELECTION TO BE DETERMINED BY OWNER. CONTRACTOR TO COORDINATE WITH OWNER FOR INSTALLATION.
2.	THE OWNER SHALL PROVIDE WALL MOUNTING DÉCOR ITEMS. THESE ITEMS ARE TO BE INSTALLED BY THE CONTRACTOR. THE CONTRACTOR SHALL COORDINATE AND SCHEDULE THE DELIVERY AND INSTALLATION OF ALL DÉCOR ITEMS WITH THE OWNER. REFER TO DÉCOR ELEVATIONS.
3.	THE CONTRACTOR SHALL VERIFY WITH ALL LOCAL AGENCIES QUANTITY AND LOCATION OF ALL FIRE EXTINGUISHERS.
4.	ALL KITCHEN EQUIPMENT SHALL MEET THE REQUIREMENTS OF THE NATIONAL SANITATION FOUNDATION (NSF).
5.	THE EXHAUST HOOD, EXHAUST FAN, EXHAUST DUCT, EXHAUST DUCT FIRE WRAP AND MAKE-UP AIR FAN SHALL BE SUPPLIED BY THE OWNER AND INSTALLED BY THE CONTRACTOR. THE MAKE-UP AIR DUCT SHALL BE SUPPLIED AND INSTALLED BY THE CONTRACTOR.
6.	THE EXHAUST HOOD FIRE SUPPRESSION SYSTEM SHALL BE SUPPLIED AND INSTALLED BY THE OWNER. THE CONTRACTOR SHALL SUPPLY AND INSTALL THE EMERGENCY GAS SHUT-OFF VALVE FOR THE EXHAUST HOOD FIRE SUPPRESSION SYSTEM.
7.	THE CONTRACTOR SHALL COORDINATE AND SCHEDULE THE DELIVERY OF ALL KITCHEN EQUIPMENT WITH THE EQUIPMENT VENDOR.
8.	THE CONTRACTOR SHALL MAKE ALL FINAL ELECTRICAL CONNECTIONS REQUIRED FOR THE OWNER PROVIDED SIGNAGE.
9.	ALL SPECIFIED REFRIGERATION UNITS SHALL BE SELF-CONTAINED AND SELF EVAPORATING.

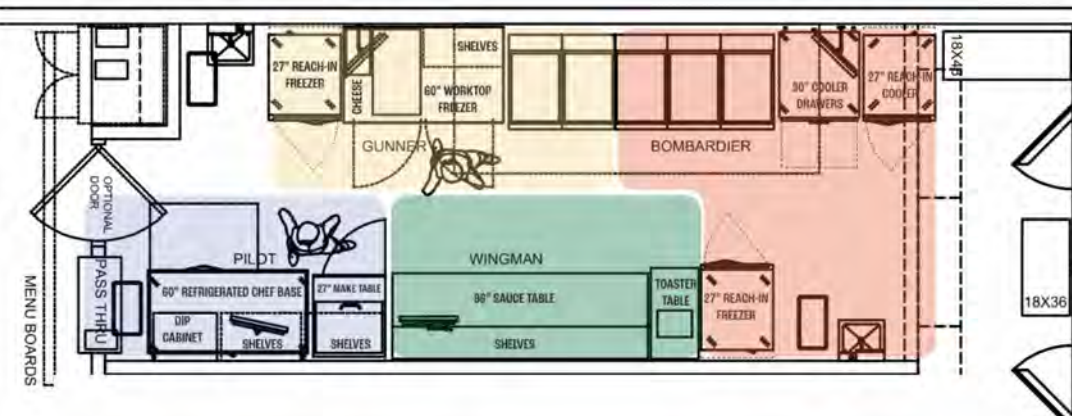TYPICAL STATION LEGEND	
THIS STATION LEGEND IS FOR REFERENCE ONLY - REFER TO EQUIPMENT PLAN AND EQUIPMENT SCHEDULE FOR PROJECT SPECIFIC LOCATIONS AND INFORMATION	
	

EQUIPMENT SCHEDULE						SUPPLIED BY	INSTALLED BY
ITEM	DESCRIPTION	MODEL	MANUFACTURER	REMARKS			
1 - BOMBARDIER							
1.1	12 FT TYPE 1 EXHAUST HOOD	ND SERIES	CAPTIVE AIRE	NOTES 5.6,7 - VERIFY TYPE, SIZE & SERIES AGAINST HOOD DRAWINGS		OWNER	GC
1.2	HOOD FIRE SUPPRESSION SYSTEM	CUSTOM	CAPTIVE AIRE	REFER TO HOOD DRAWINGS FIRE SUPPRESSION PERMITTED / INSTALLED BY CAPTIVEAIRE		OWNER	OWNER
1.3	SOLSTICE SUPREME GAS FRYER / FILTER / GAS CONNECTOR HOSE KIT	SSH75-C / SFSH75-C	PITCO	105,000 BTU, 75 LBS (OIL CAPACITY) / WITH 6 IN CASTERS / 120 VOLTS, 6.2 AMP		OWNER	GC
1.4	COOKING AND HOLDING TIMER	FASTIMER MERIDIAN MET-118	KITCHEN BRAINS	-		OWNER	GC
1.5	30 INCH, 2-DRAWER UNIT	WTRD30BHC-2-WS-FIP	BEVERAGE-AIR	30 IN TALL		OWNER	GC
1.6	1-DR. REACH-IN REFRIGERATOR	R1A-FS(L)	HOSHIZAKI	115 VOLTS, 4.0 AMPS / WITH CASTERS / NOTE 9		OWNER	GC
1.7	1-DR. REACH-IN FREEZER	F1A-FS(L)	HOSHIZAKI	115 VOLTS, 4.0 AMPS / WITH CASTERS / NOTE 9		OWNER	GC
2 - GUNNER							
2.1	1-DR. REACH-IN FREEZER	F1A-FS(L)	HOSHIZAKI	115 VOLTS, 4.0 AMPS / WITH CASTERS / NOTE 9		OWNER	GC
2.2	60 DOUBLE DOOR WORKTOP FREEZER	WF60B	HOSHIZAKI	-		OWNER	GC
2.3	NACHO CHEESE DISPENSER	HT2 SINGLE DISPENSER	GEHLS	-		OWNER	OWNER
2.4	STAINLESS STEEL SHELVING - 48	18026723	FRANKE	-		OWNER	GC
2.5	STAINLESS STEEL SHELVING - 30	18034613	FRANKE	-		OWNER	GC
2.6	STAINLESS STEEL SHELVING ADAPTER - 60	18032887	FRANKE	-		OWNER	GC
3 - WINGMAN							
3.1	TOASTER TABLE	18033683	FRANKE	WITH MID SHELF		OWNER	GC
3.2	TOASTER	VCT-2 (9211047)	ANTUNES	REFER TO ELECTRICAL DRAWINGS		OWNER	GC
3.3	SAUCE TABLE	18033680	FRANKE	WITH UNDERSHELF		OWNER	GC
3.4	STAINLESS STEEL SHELVING - 48	18026723	FRANKE	-		OWNER	GC
3.5	STAINLESS STEEL SHELVING - 36	18034615	FRANKE	-		OWNER	GC
3.6	TICKET RAIL 24	CK6524A	SAN JAMAR	-		OWNER	OWNER
4 - PILOT							
4.1	27 INCH SANDWICH PREP TABLE ONE DOOR MEGATOP	SPE27HC-12M-B-WNGST	BEVERAGE-AIR	-		OWNER	GC
4.2	60 CHEF BASE REFRIGERATOR	WTRCS60HC	BEVERAGE-AIR	WITH 6 IN CASTERS AND (15) 6 IN PLASTIC FULL SIZE PANS		OWNER	GC
4.3	24 WALL MOUNTED REFRIGERATOR	WMR24X-R	GLASTENDER	-		OWNER	GC
4.4	STAINLESS STEEL SHELVING - 30	18034613	FRANKE	-		OWNER	GC
5 - KITCHEN							
5.1	WALK-IN COOLER / FREEZER	PROTO 4B	KOLPAK	NOTE 9, REFER TO EQUIPMENT PLAN FOR DIMENSIONS		OWNER	GC
5.2	DUNNAGE RACK	DASQ	WINHOLT	REFER TO EQUIPMENT PLAN FOR SIZES		OWNER	GC
5.3	STORAGE SHELVING - WALK-IN	K SERIES	CENTAUR	WITH (5) SHELVES, GREEN EXOPY NSF, SIZE VARIES, REFER TO PLAN		OWNER	GC
5.4	STORAGE SHELVING - DRY STORAGE	K SERIES	CENTAUR	WITH (5) SHELVES, GREEN EXOPY NSF, SIZE VARIES, REFER TO PLAN, CASTERS OPTIONAL		OWNER	GC
5.5	BIB FLEX RACK SYSTEM	44239	PROVIDED BY COKE	WITH 6 IN HIGH LEGS		OWNER	OWNER
5.6	CO2 SYSTEM	CARBO-MIZER 450	PROVIDED BY COKE	-		OWNER	OWNER
5.7	CARBONATOR	-	PROVIDED BY COKE	-		OWNER	OWNER
5.8	COOKING OIL COLLECTION	B.O.S.S. SPACE SAVER	DARPRO	-		OWNER	OWNER
5.9	HAND SINK WITH SIDE SPLASH (R & L)	18026936	FRANKE	WITH (2) 8 IN SIDE SPLASHES		OWNER	GC
5.10	PAPER TOWEL DISPENSER	T1190TBK	SAN JAMAR	-		OWNER	GC
5.11	SOAP DISPENSER	SF900TBK	SAN JAMAR	-		OWNER	GC
5.12	23 GALLON WASTE RECEPTACLE	PTC-23SG	WINCO	-		OWNER	GC
5.13	2-COMPARTMENT SINK	18026628	FRANKE	WITH (2) 18 IN DRAIN BOARDS, (2) 8 IN SIDE SPLASHES WITH OPTIONAL LID COVERS, VERIFY W/ LOCAL JURISDICTIONS FOR DRAIN BOARD AND BOWL SIZE		OWNER	GC
5.14	VEGGIE WASH	-	ECOLAB	-		OWNER	GC
5.15	WALL MOUNTED MIXING FAUCET	B-2414	T & S BRASS AND BRONZE WORKS, INC.	-		OWNER	GC
5.16	3-COMPARTMENT SINK	18026714	FRANKE	WITH (2) 18 IN DRAIN BOARDS, (2) 8 IN SIDE SPLASHES, VERIFY WITH LOCAL JURISDICTIONS FOR DRAIN BOARD AND BOWL SIZE		OWNER	GC
5.17	ECOLAB DISPENSER	-	ECOLAB	-		GC	OWNER
5.18	S.S. FLEX HOSE	B-0133-ADF14-B / B-2414	T & S BRASS AND BRONZE WORKS, INC.	-		GC	OWNER
5.19	SCULLERY WALL-MOUNTED WIRE SHELVING 30	K SERIES	CENTAUR	GREEN EPOXY NSF, SIZE VARIES - REFER TO PLAN AND ELEVATION FOR ADDITIONAL INFORMATION		OWNER	GC
5.20	SCULLERY WALL-MOUNTED WIRE SHELVING 48	K SERIES	CENTAUR	GREEN EPOXY NSF, SIZE VARIES - REFER TO PLAN AND ELEVATION FOR ADDITIONAL INFORMATION		OWNER	GC
5.21	MOP BUCKET	RUBFG618688YEL	RUBBERMAID	-		OWNER	GC
5.22	MOP SINK	MSBIDTG2424	FIAT PRODUCTS	WITH BUILT-IN ANTI SYPHON DEVICE		GC	GC
5.23	BROOM AND MOP RACK	786	AMERICAN SPECIALTIES	-		OWNER	GC
5.24	TANKLESS WATER HEATER	NCC199CDV	NORITZ	-		GC	GC
5.25	FIRE EXTINGUISHER	-	-	-		GC	GC
5.26	STAINLESS STEEL WALL END GUARD	CUSTOM	-	-		GC	GC
5.27	STAINLESS STEEL CORNER GUARD	CUSTOM	-	-		GC	GC
5.28	60 IN WIRE SHELVING	K SERIES	CENTAUR	GREEN EPOXY NSF, SIZE VARIES - REFER TO PLAN AND ELEVATION FOR ADDITIONAL INFORMATION		OWNER	GC
5.29	OVERHEAD WALL-MOUNTED WIRE SHELVING	<varies>	METRO	<varies>		OWNER	GC
5.30	WATER FILTER (BEVERAGE)	KAY-T010	ECOLAB	-		GC	OWNER
5.31	WATER FILTER (ICE MACHINE)	KAY-T010S	ECOLAB	-		GC	OWNER
6 - SALES							
6.1	SINGLE DOOR UPRIGHT MERCHANDISER	RM-26-HC	HOSHIZAKI	115 VOLTS, 3.2 AMPS, WITH CASTORS, NOTE 09		OWNER	GC
6.2	SALES COUNTER	3 POS STATIONS	WS-2000	-		OWNER	GC
6.3	PASS-THRU SHELVES WITH CASING	CUSTOM	FRANKE	WS-2020		OWNER	GC
6.6	10 VALVE SODA DISPENSER	DAWN	PROVIDED BY COKE	115 VOLTS, 20 AMPS		OWNER	OWNER
6.7	SODA DISPENSER STAND	PROVIDED BY COKE	OWNER	OWNER		OWNER	OWNER
6.8	ICE MACHINE	KM-901MAJ	HOSHIZAKI	-		OWNER	GC
7 - FURNITURE							
7.1	WAITING BENCH	CUSTOM	PLYMOLD	WS-5070		OWNER	GC
8 - RESTROOMS							
8.1	RESTROOM MIRROR	B-165-2436	BOBRICK	SIZE: 24 IN X 36 IN WITH S.S. CHANNEL FRAME		GC	GC
8.2	SOAP DISPENSER	SF900TBK	SAN JAMAR	-		OWNER	GC
8.3	TOILET PAPER DISPENSER - SURFACE MOUNT	B-2888	BOBRICK	-		OWNER	GC
8.5	ELECTRIC HAND DRYER	XL-SB	EXCEL DRYER	-		OWNER	GC
8.6	SANITARY NAPKIN DISPOSAL - SURFACE MOUNTED	FG614000WHT	RUBBERMAID	-		GC	GC
8.7	GRAB BAR - 36"	B-6806-36	BOBRICK	-		GC	GC
8.8	GRAB BAR - 42"	B-6806-42	BOBRICK	-		GC	GC
8.9	GRAB BAR - 18"	B-6806-18	BOBRICK	-		GC	GC
8.10	28 QUART WASTE RECEPTACLE	SKU: FG295600BLA	RUBBERMAID	-		OWNER	GC
9 - TECHNOLOGY							
9.1	KDS MONITOR	KA-22PCAPWINAI06	KITCHEN ARMOR	-		OWNER	GC
9.2	ORDER READY SCREEN	TRIPP LITE SERIES - 15U	EATON	-		OWNER	GC
9.3	WALL MOUNTED SMARTRACK	-	-	-		OWNER	GC
9.4	STEREO (AMP) RECEIVER	-	-	-		OWNER	OWNER
9.5	POINT OF SALE EQUIPMENT	CX5	NCR	-		OWNER	GC
9.6	SATELLITE RECEIVER	-	-	-		OWNER	GC
9.7	55 IN COMMERCIAL TV	BE55D	SAMSUNG	PROVIDE WITH WALL MOUNTED TV BRACKET		OWNER	GC
9.8	WALL MOUNTED TV BRACKET	MD2268-MK	MOUNTING DREAM	-		OWNER	GC
9.9	MANAGER'S DESK	-	-	COORDINATE WITH EQUIPMENT MANUFACTURER		OWNER	GC
9.10	SAFE	FLH272020-LGBASIC-POLY	BLUE DOT	-		OWNER	GC

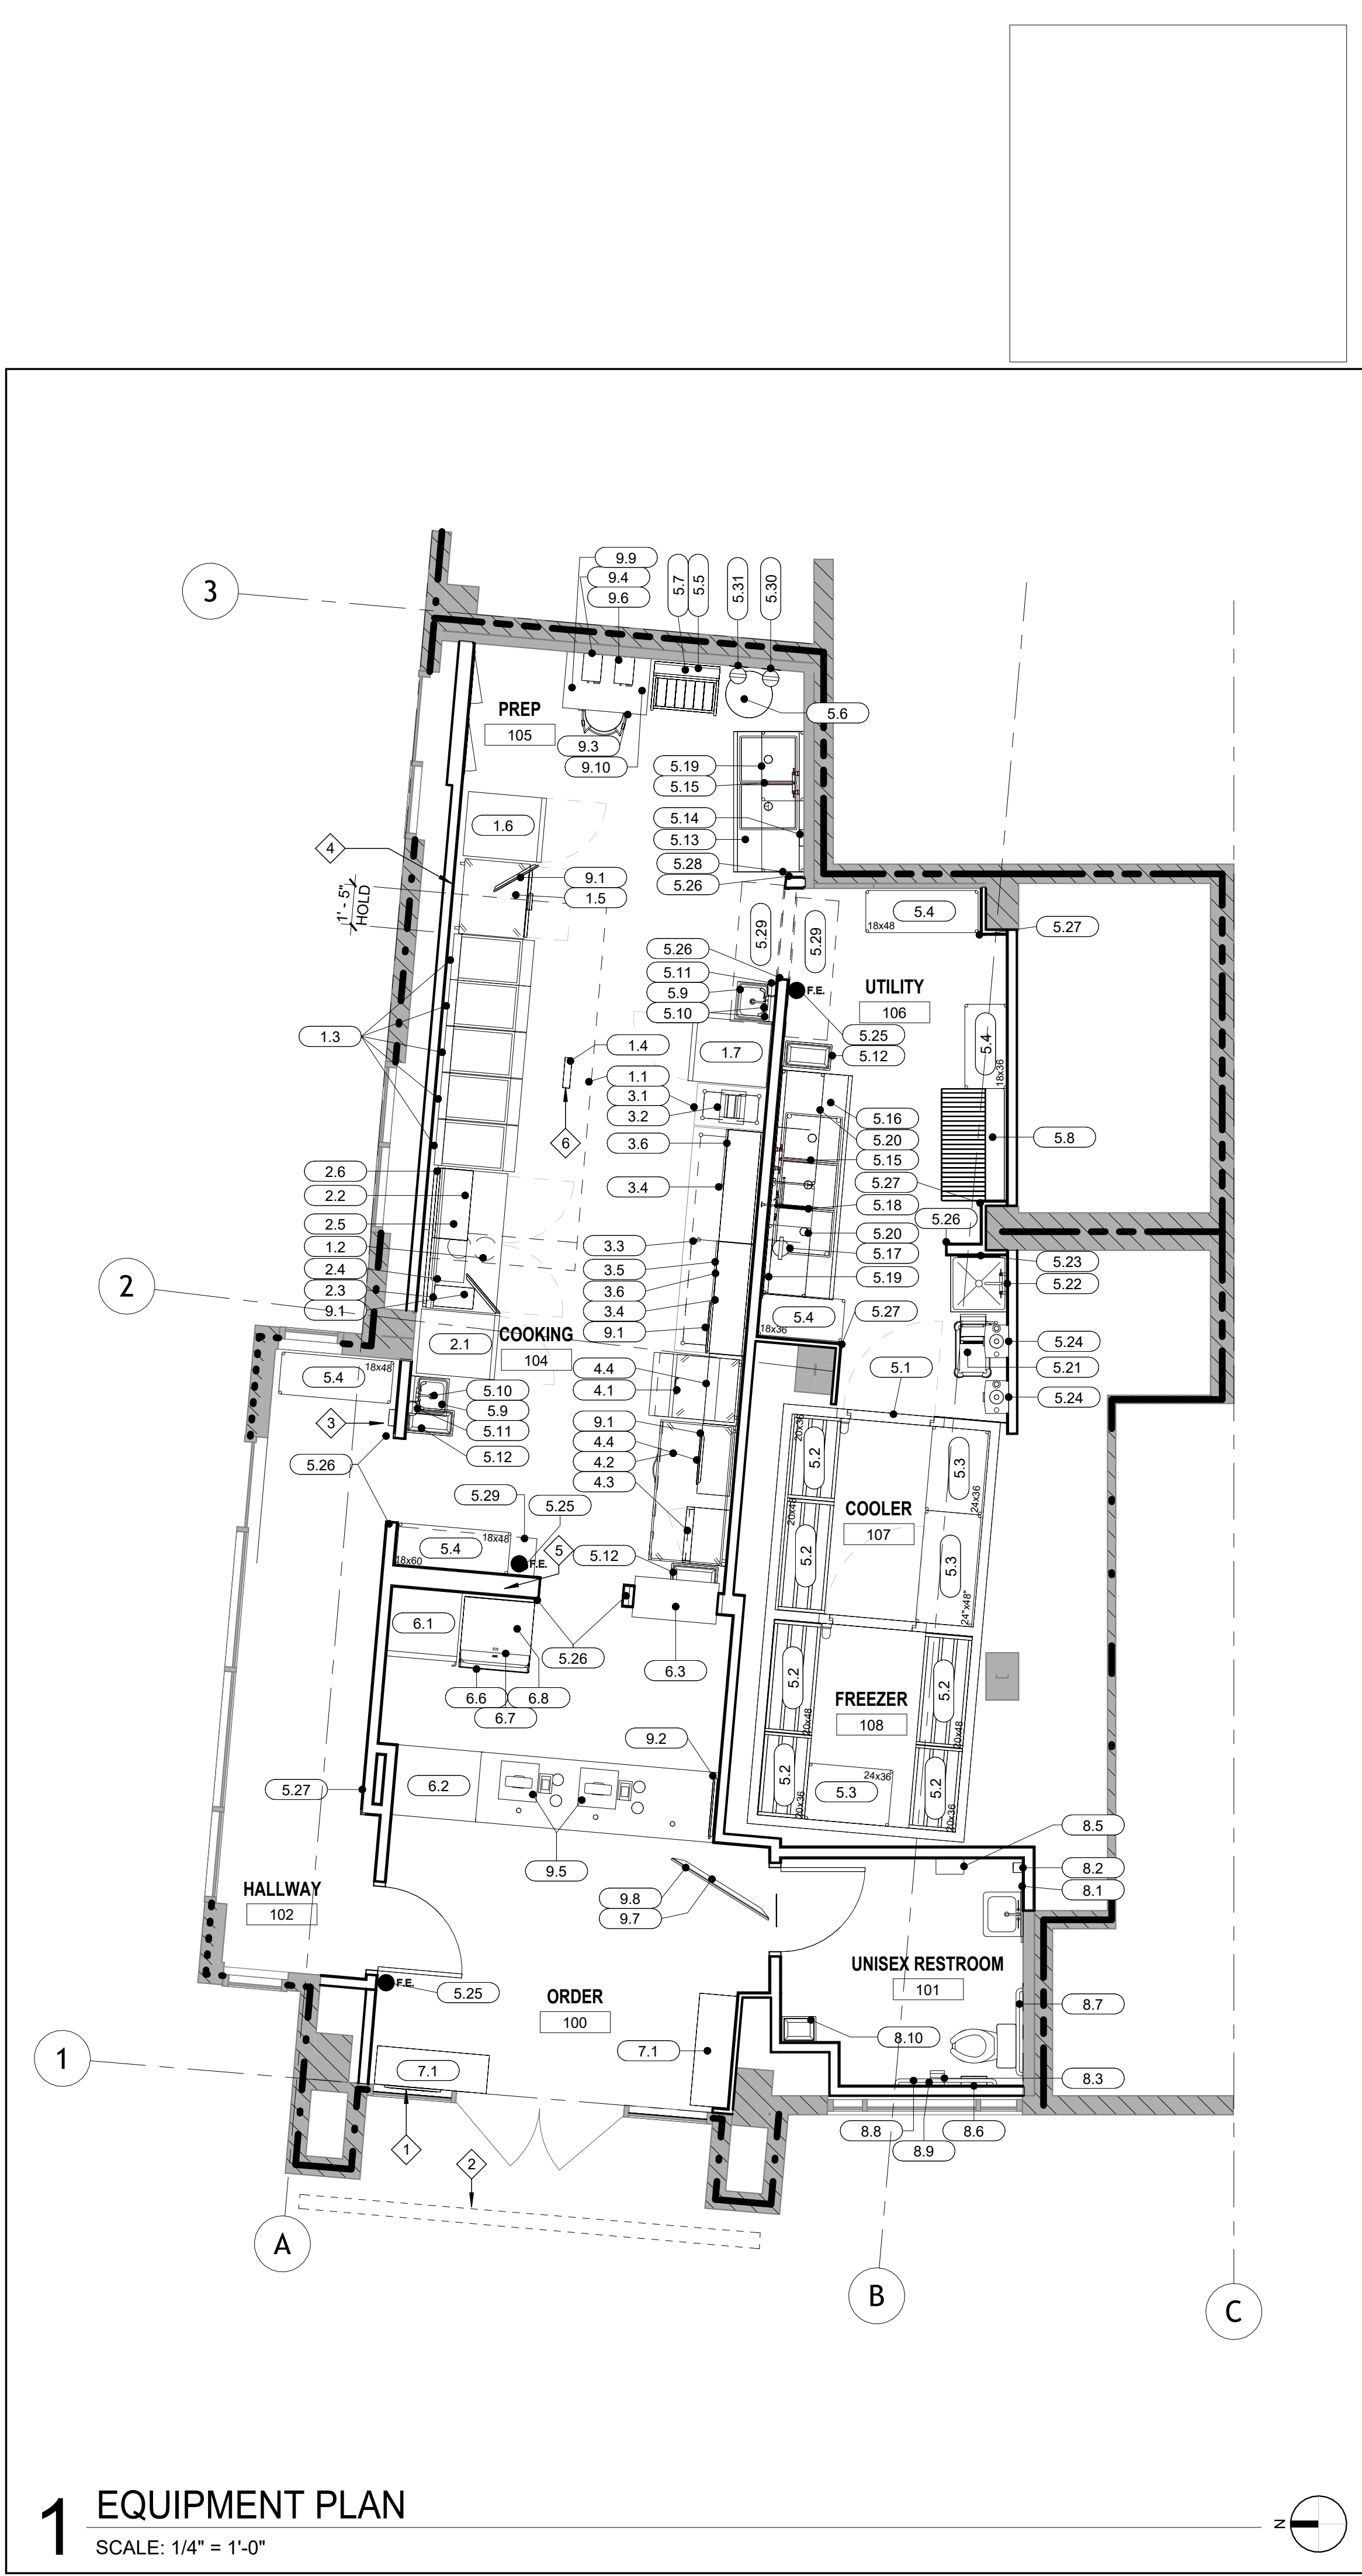

CONSULTANT



2801 NORTH CENTRAL EXPRESSWAY, SUITE 1600
DALLAS, TX 75204
TELEPHONE: (972) 686-6500
FAX: (972) 686-6502

THESE DRAWINGS, IDEAS, SPECIFICATIONS AND DESIGNS ARE EXCLUSIVE PROPERTY OF WINGSTOP RESTAURANTS, INC. NO PART OF THESE DRAWINGS MAY BE COPIED, REPRODUCED, OR OTHER STRUCTURES BUILT FROM SUCH WITHOUT THE WRITTEN CONSENT OF WINGSTOP RESTAURANTS, INC.

COPYRIGHT © 2025 WINGSTOP RESTAURANTS, INC. ALL RIGHTS RESERVED

PROJECT INFORMATION

WINGSTOP
(GL#A216)

THE AUGUSTA ON GEORGIA
3831 GEORGIA AVENUE NW
WASHINGTON, D.C. 20009

SEAL

12360 REGISTERED ARCHITECT

MATTHEW M. WILKUS
STATE OF WASHINGTON

June 10, 2026

MATTHEW M. WILKUS
LICENSE #12360
(EXPIRES 06/16/2025)

PROJECT NO. 2025-0430
DRAWN BY ANC
CHECKED BY JSS

ISSUE DATE

DESIGN INTENT REVIEW 2026/03/30

PERMIT SET 2026/06/10

REVISION DATE

NG_DELCO_2025.02

TITLE

EQUIPMENT PLAN
AND SCHEDULE

SHEET NUMBER

EQ0.0

GENERAL NOTES	
A.	INSTALL FIRE-TREATED MATERIAL, OR ALTERNATIVELY PREVIOUSLY APPROVED MATERIAL, AS REQUIRED TO COMPLY WITH EXISTING/PROPOSED RATED WALL ASSEMBLIES OR APPLICABLE BUILDING/FIRE CODE.

KEYNOTE LEGEND	
1	SS HOOD END PANEL - PROVIDED AND INSTALLED BY HOOD VENDOR
2	FIRE RETARDANT PRESSURE TREATED PLYWOOD BACKING BEHIND WALL FINISH AS REQUIRED TO SUPPORT SERVER RACK
3	NOT USED
4	CENTER QUAD OUTLET ON DATA POINT - SEE ELECTRICAL PLAN FOR ADDITIONAL INFORMATION
6	PROVIDE 2X WOOD BLOCKING, AS REQUIRED PER MANUFACTURER'S SPECIFICATIONS
7	GENERAL CONTRACTOR TO INSTALL 5/8" CONTINUOUS FIRE RETARDANT PRESSURE TREATED PLYWOOD BACKING AT WALL ASSEMBLIES WITHIN THE KITCHEN, PREP, AND UTILITY AREAS FROM 30" A.F.F. TO 6" ABOVE THE PROPOSED CEILING ELEVATION TO ALLOW FOR INSTALLATION OF FUTURE EQUIPMENT AND ACCESSORIES.
8	10" X 4" MIN WALL VENT FOR CIRCULATION BEHIND STOREFRONT - COLOR TO BE WHITE - REFER TO INTERIOR ELEVATIONS
9	24" X 24" METAL ACCESS DOOR, 12" A.F.F., WHITE

