


 EXISTING WALL TO REMAIN
 NEW FRAME/STEEL STUD GYPSUM BOARD PARTITION

 DOOR SYMBOL/MARK IN SCHEDULE
 WINDOW SYMBOL MARK IN SCHEDULE
 NEW FINISHED CEILING GACOUS TILE w/ ALUM GRID TRACK
 (SEE REFLECTED CEILING PLAN)
 NEW FINISH FLOORING TILES


1. ALL WORK SHALL CONFORM TO THE 1990 BOCA CODE AND ZONING REGULATIONS AND ALL OTHER APPLICABLE CODES, REGULATIONS AND REQUIREMENTS.
2. THE WORK INCLUDED WITHIN THESE DRAWINGS AND NOTES ARE DELINEATED WITHIN THESE DRAWINGS AND NOTES.
3. THE CONTRACTOR SHALL PROVIDE ALL MATERIALS, LABOR, EQUIPMENT, TOOLS AND SUPERVISION AS REQUIRED TO COMPLETE ALL PARTS OF THE WORK.
4. THE WORK AREA SHALL BE KEPT CLEAN, NEAT AND IN A SAFE MANNER AT ALL TIMES.
5. THE CONTRACTOR SHALL OBTAIN SEPARATE PLUMBING AND ELECTRICAL PERMITS.
6. THE CONTRACTOR SHALL OBTAIN ALL REQUIRED MONTGOMERY COUNTY INSPECTIONS AND APPROVALS.
7. THE CONTRACTOR SHALL EXERCISE CAUTION TO PREVENT DAMAGE TO AREAS NOT SCHEDULED FOR WORK. PROVIDE A SMOOTH INVISIBLE TRANSITION BETWEEN THE NEW WORK AND AREAS NOT SCHEDULED FOR WORK.
8. THE CONTRACTOR SHALL CONSULT THE ARCHITECT IMMEDIATELY UPON THE OCCURRENCE OF DISCREPANCY BETWEEN THE DRAWINGS AND THE SITE CONDITIONS.
9. THE ARCHITECTURAL DIVISION OF THE SCOPE OF WORK, INCLUDING BUT NOT LIMITED TO FINISHES, FURNISHINGS AND INSTALLATIONS, SHALL BE COORDINATED WITH ALL OTHER DIVISIONS OF THE WORK, INCLUDING BUT NOT LIMITED TO PLUMBING, ELECTRICAL, MECHANICAL AND ELEVATOR. CONTRACTOR SHALL REPAIR DAMAGED AREAS, PATCH HOLES AND REFINISH AREAS DUE TO THE INSTALLATION OF PLUMBING, MECHANICAL, AND ELECTRICAL EQUIPMENT.
10. REPAIRS AND REFINISHES SHALL MATCH AND BLEND WITH ADJACENT AREAS AND SHALL BE AT AN ACCEPTABLE QUALITY.
11. CONTRACTOR SHALL SUBMIT SHOP DRAWINGS, SAMPLES, CATALOG CUTS, AND MANUFACTURER'S LITERATURE FOR ALL INSTALLATIONS TO THE ARCHITECT FOR APPROVAL, PRIOR TO STARTING THE WORK.
12. DOORS, KITCHEN EQUIPMENT, WINDOWS, FLOOR FINISHES, WALL FINISHES, HARDWARE, PLUMBING FIXTURES, LIGHT FIXTURES, PAINT COLORS AND TEXTURES SHALL BE SELECTED BY THE OWNER OR HIS AGENTS.
13. PARTITION SCHEDULE IS SHOWN UNDER A PREVIOUS PERMIT.

24'-6"



5'-0"

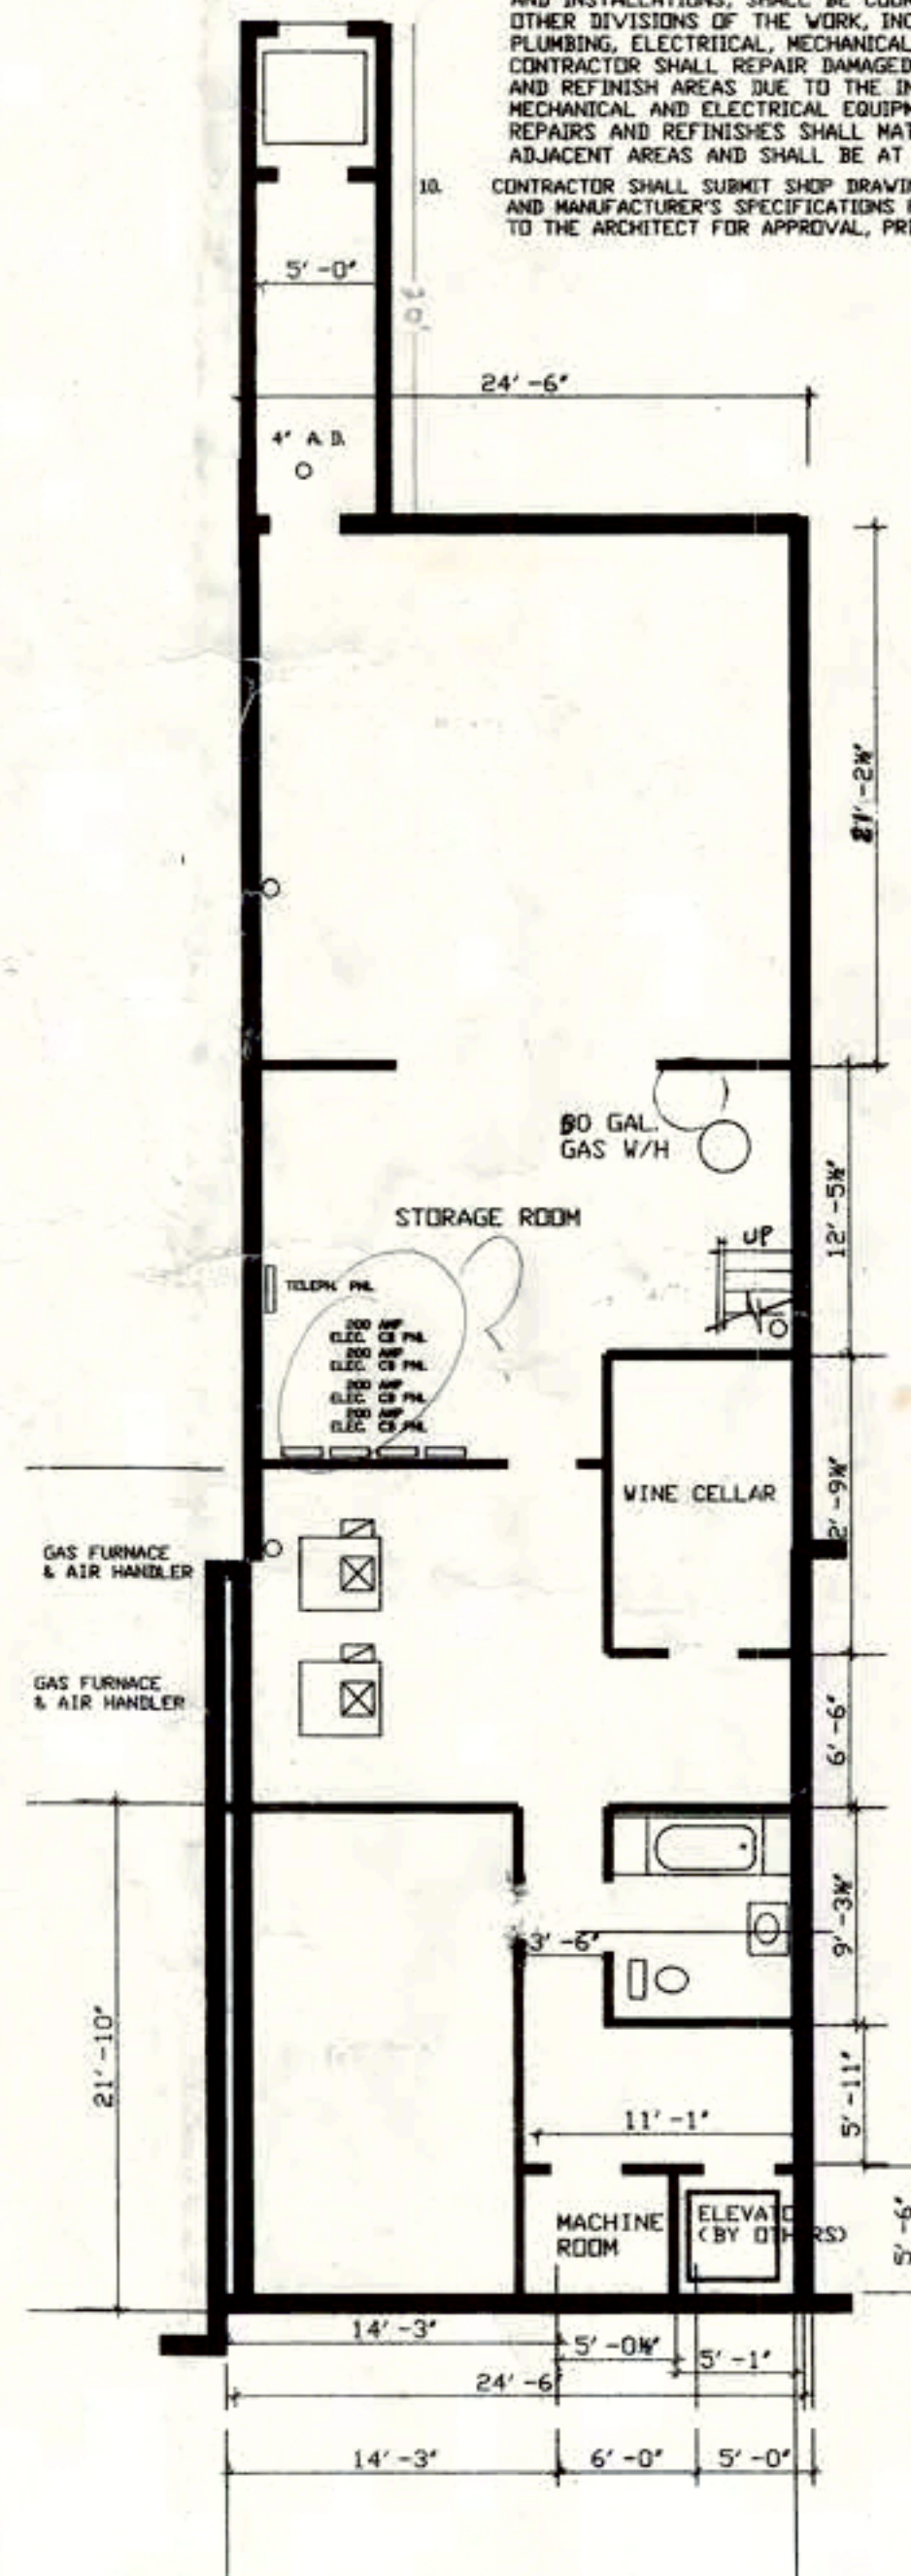


BASEMENT FLOOR PLAN
SCALE 1/8" = 1'-0"

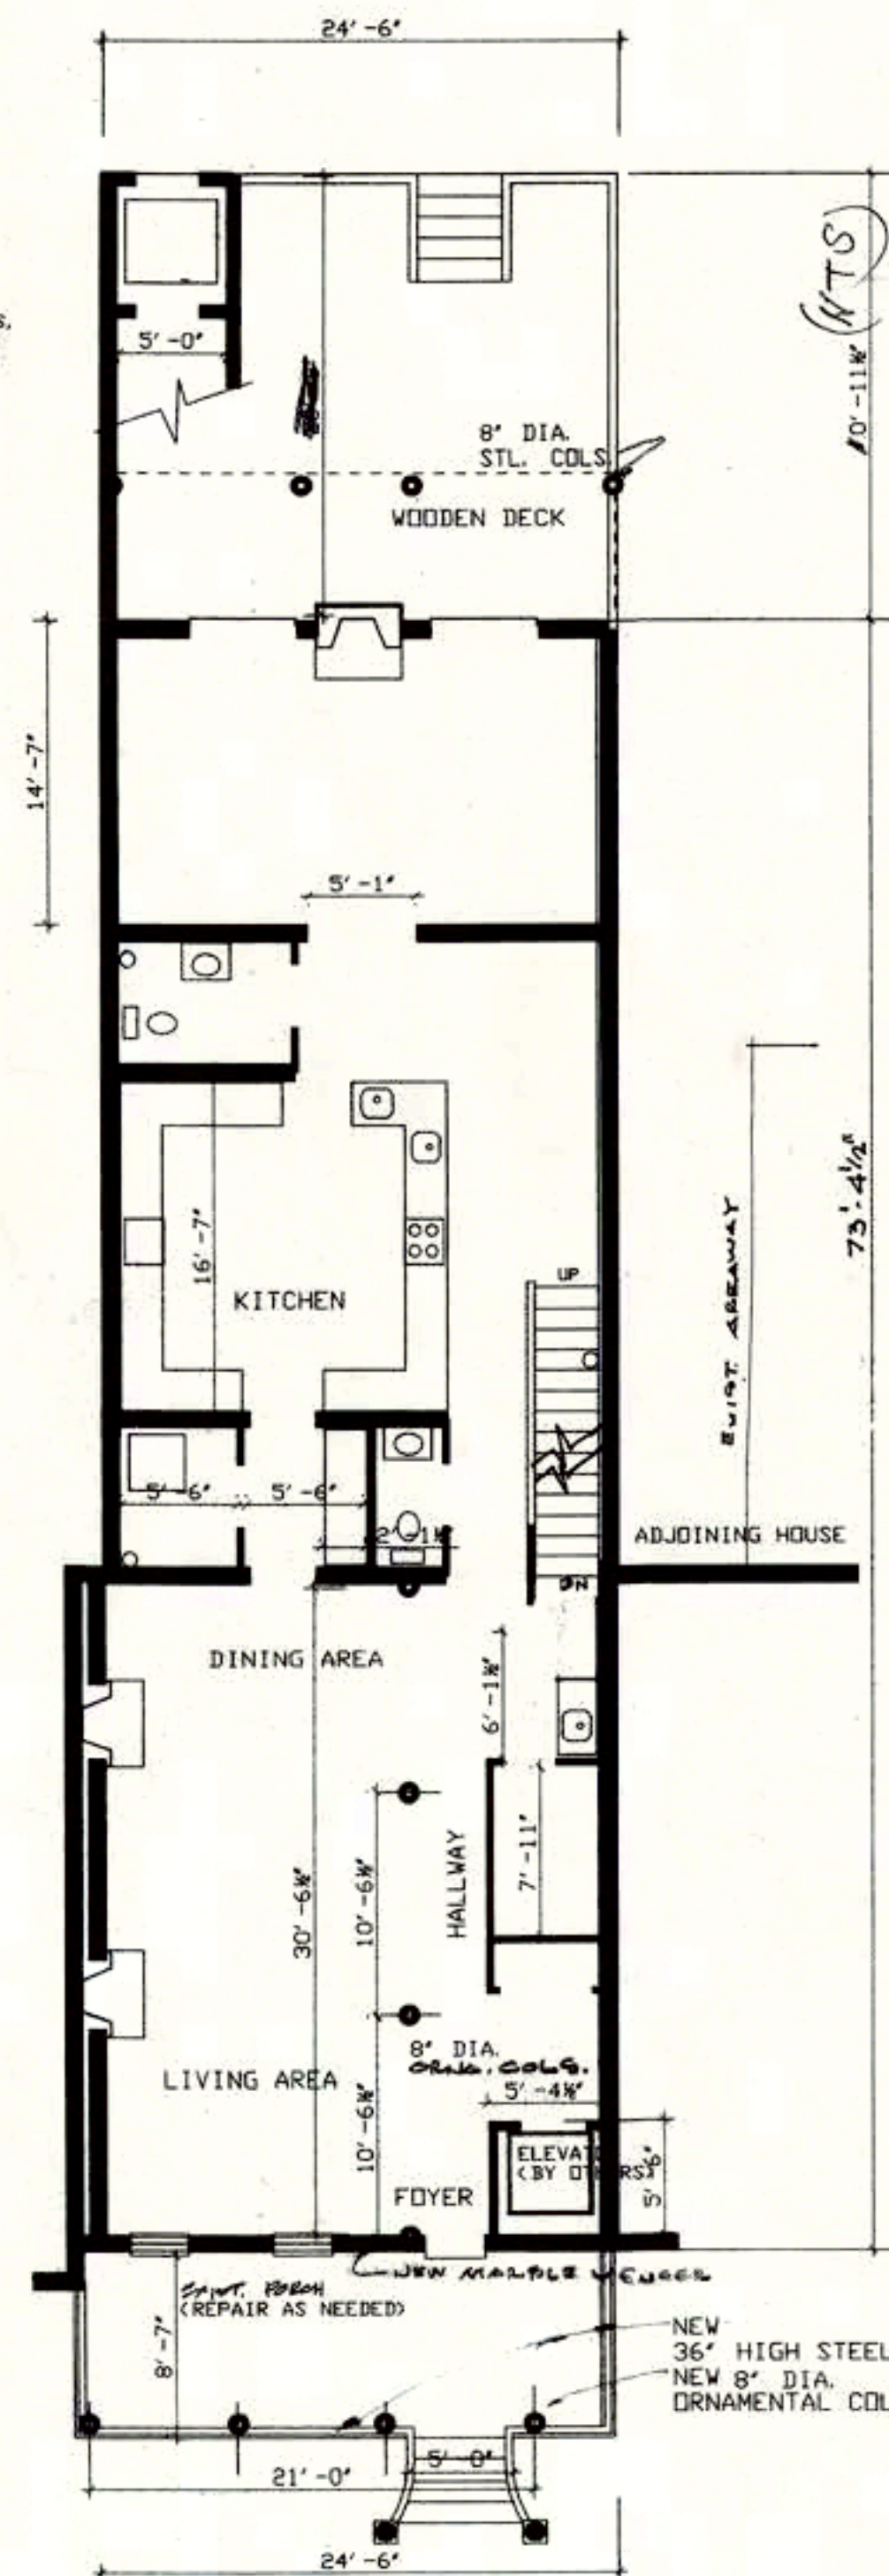

FIRST FLOOR PLAN
SCALE 1/8" = 1'-0"

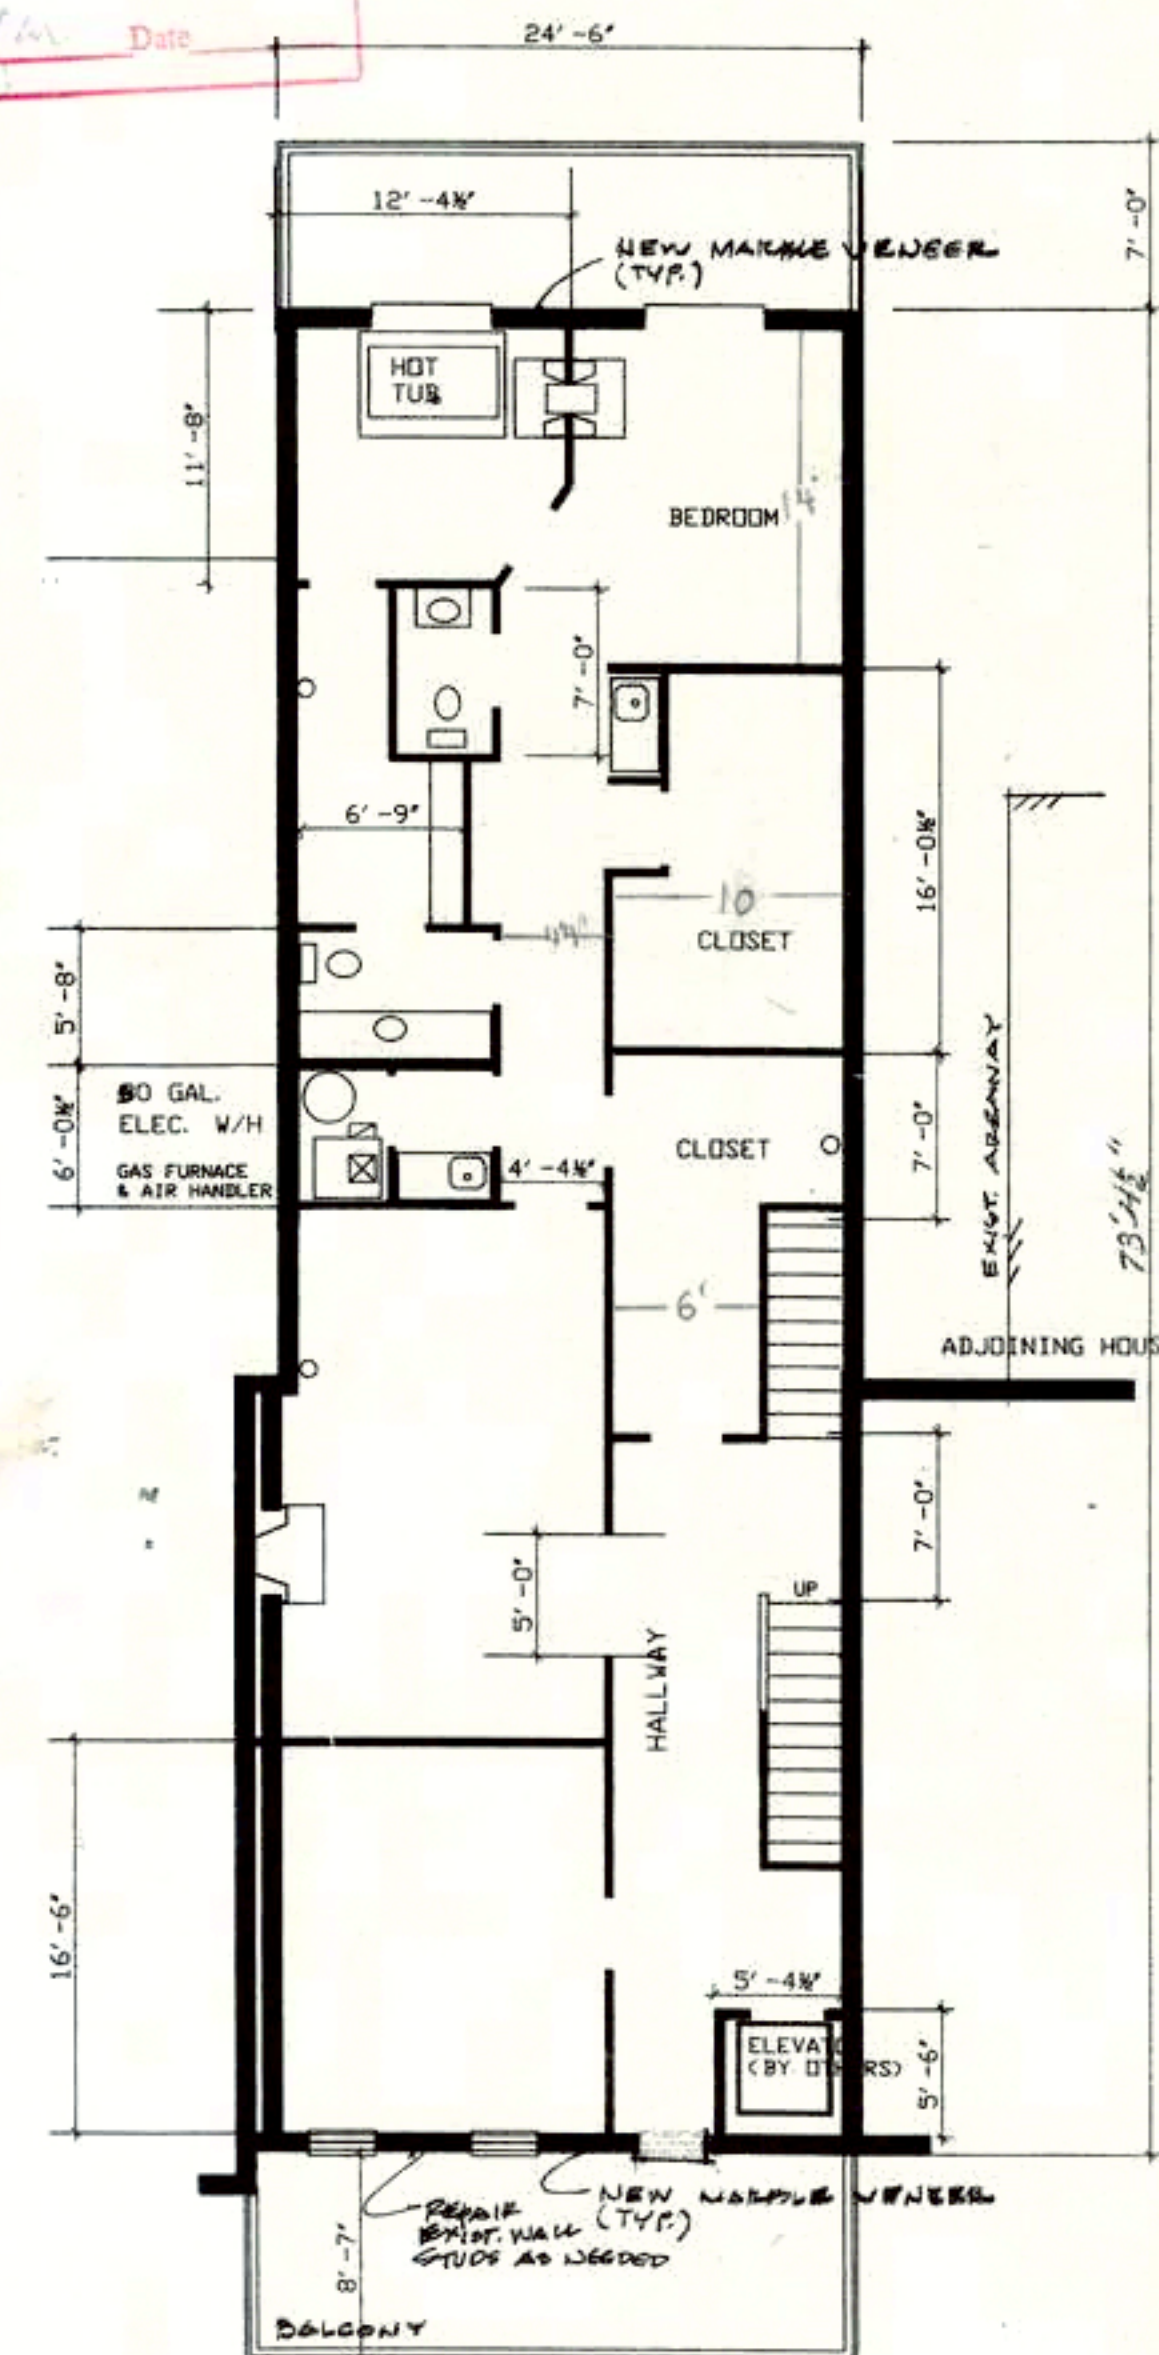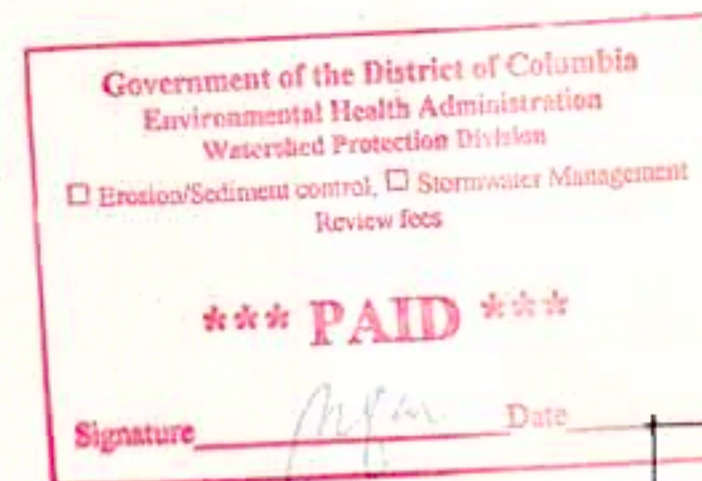


SECOND FLOOR PLAN
SCALE 1/8" = 1'-0"

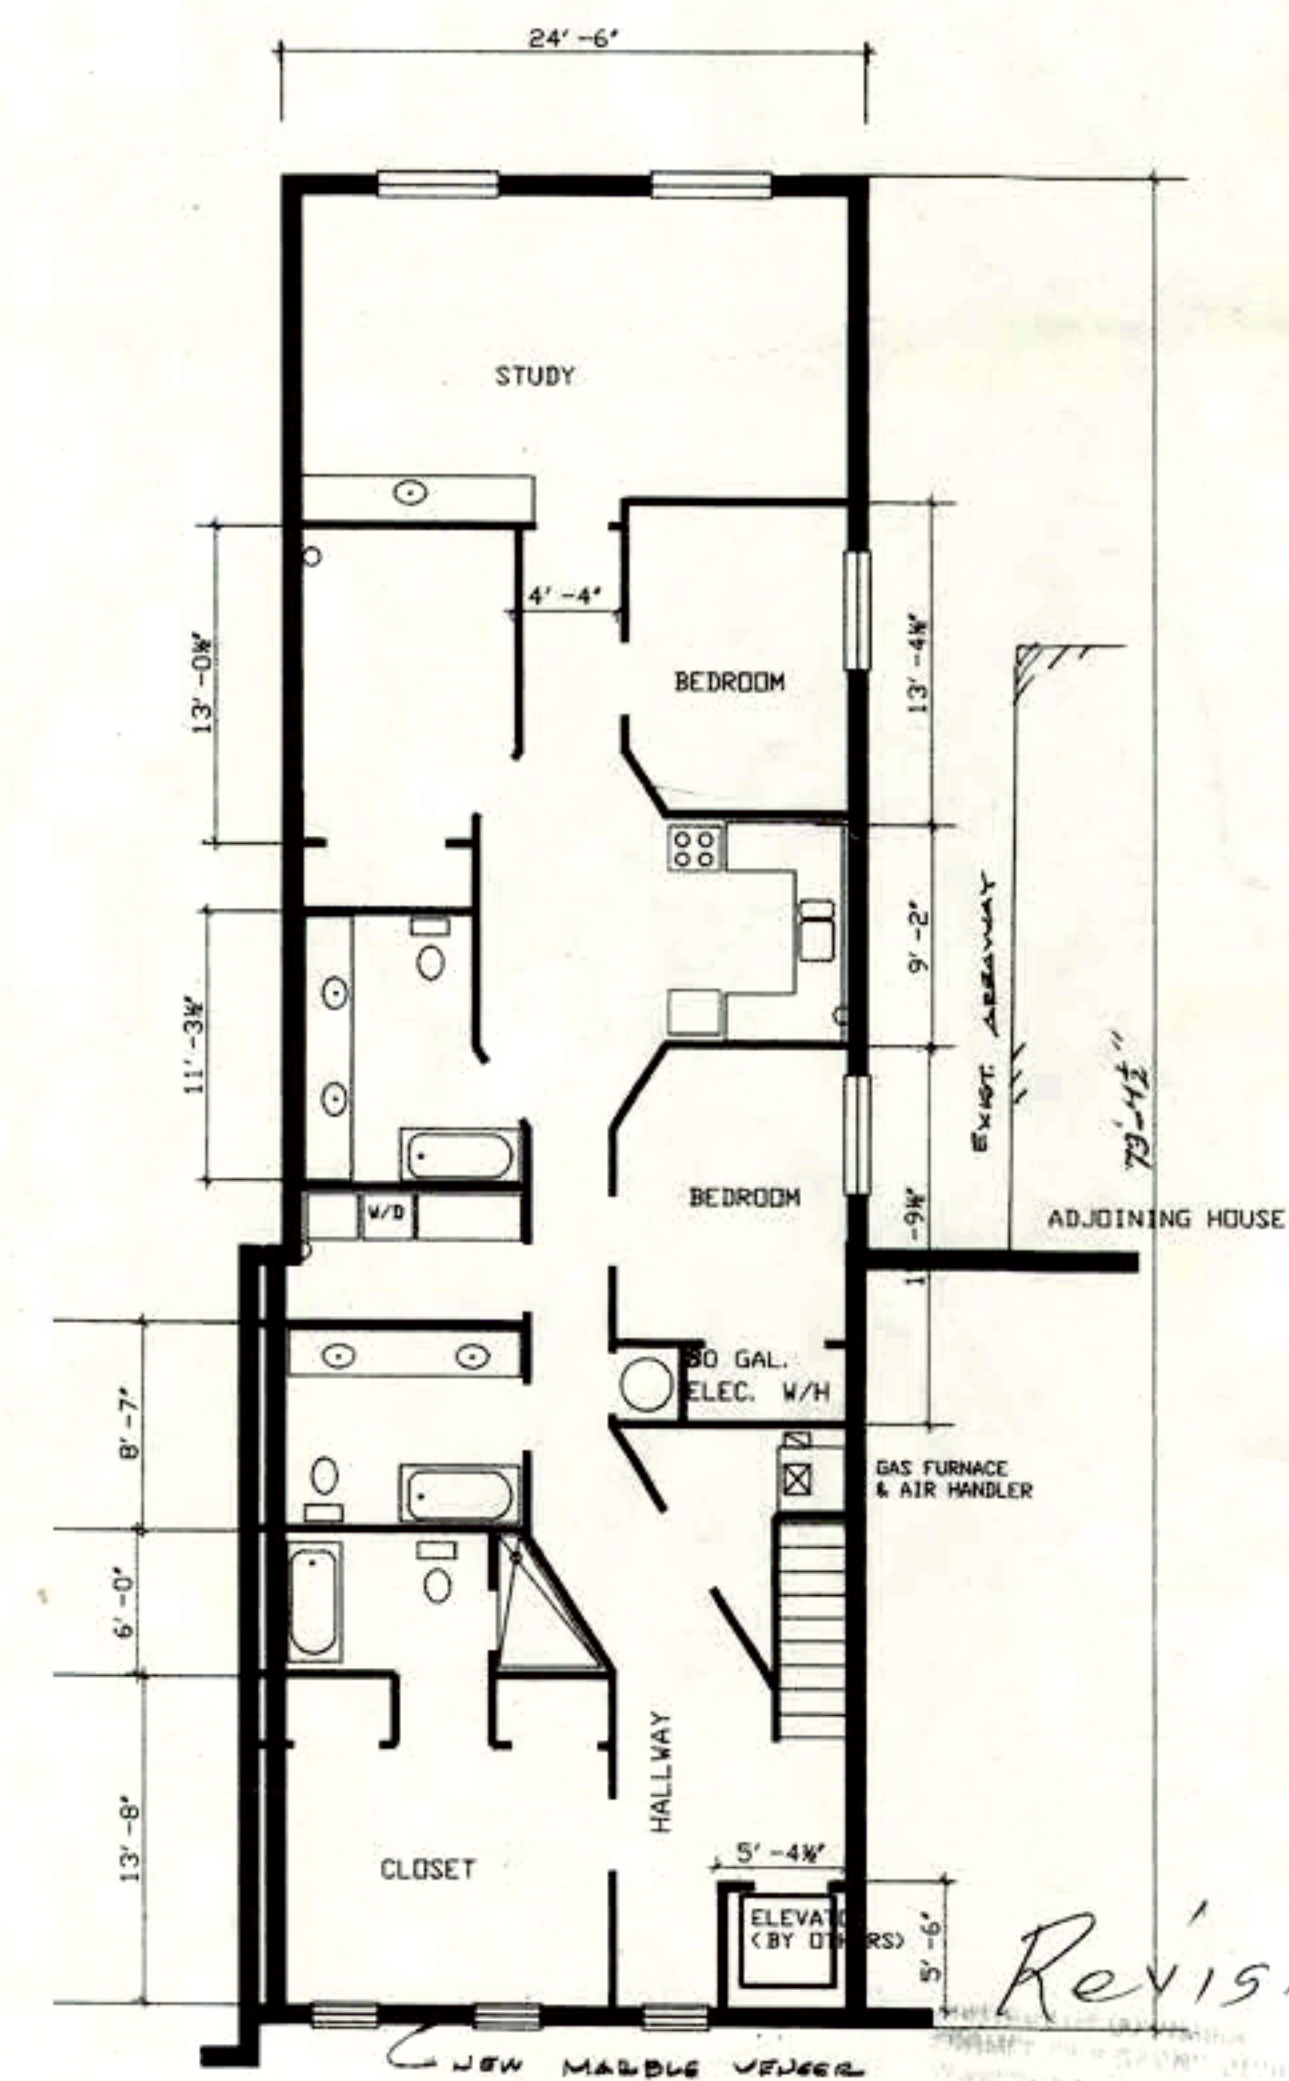

THIRD FLOOR PLAN

A circular professional seal for Willie Maiden, a Registered Architect in the District of Columbia. The seal features the text "DISTRICT OF COLUMBIA" at the top, "WILLIE MAIDEN" in the center, and "REGISTERED ARCHITECT" at the bottom. A large, stylized signature is written across the seal.

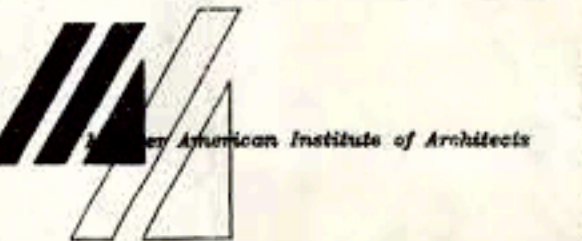

(301) 608-0988 OFFICE
(301) 608-0666 FAX
E-Mail: WJMAIDEN@AOL.COM
Web Site: 1stPage.COM/MAAE

LORRAINE WILSON
1324 Kenyon Street, NW
Washington, D. C. 200
(202) 462-5047

ALTERATION & AD
TO EXISTING BUI
FOR USE AS A
SINGLE-FAMILY H
(ROWHOUSE)

1324 Kenyon Street, NW
Washington, D. C. 20004
RD LOT AREA
842 3,707 S.F.
2848

[illegible]

Drawing Name:

© Copyright 2001
This Drawing and Design in-whole or in-part shall
not be reproduced without written permission from
Malden and Associates.

Contract Date: 01/20/01	Designed by:	Working Sheet Number:
REV. 5/18/2001	Designed by:	
	Autocast by:	
	Checked by:	
Architect's Project Number:	Checked by:	
	Checked by:	

0950

Board of Zoning Adjustment
Sheet of Columbia

A 1

Board of Zoning Adjustment
District of Columbia
CASE NO. 21446
EXHIBIT NO. 3

1. ALL MECHANICAL (HVAC) WORK SHALL CONFORM TO THE 1996 NATIONAL MECHANICAL CODE, 1996 BOB AND ALL APPLICABLE ASHRAE STANDARDS.
2. THE MECHANICAL WORK SHALL INCLUDE ALL MATERIALS, LABOR, SUPERVISION, TOOLS AND APPURTENANCES AS REQUIRED TO A COMPLETE INSTALLATION.
3. ALL MECHANICAL WORK SHALL BE PERFORMED BY A CERTIFIED MECHANIC (HVAC) SUBCONTRACTOR.
4. NEW ROOFTOP HVAC UNITS AND EXTERIOR DUCTWORK SHALL PROPERLY FASTENED AND SECURED TO THE STRUCTURE. INSTALL RESILIENT (NOISE AND VIBRATION CONTROL) PADS AT EACH UNIT. INSTALL PROPER HANGERS AND BRACKETS FOR BOTH THE INDOOR AND OUTDOOR UNITS.
5. INSTALL NEW RECTANGULAR DUCTS, FITTINGS, REGISTERS, DIFFUSERS, DAMPERS, TURNING VANES, FIRE DAMPERS, IN-DUCT SMOKE DETECTORS AND ALL REQUIRED APPURTENANCES AS REQUIRED FOR A COMPLETE INSTALLATION AND PROPER OPERATION.
6. INSTALL 2" THICK PIPE INSULATION ON THE EXTERIOR SIDE OF ALL REFRIGERANT LINES. INSTALL 2" THICK FIBERGLASS DUCT INSULATION ON THE ENTIRE LENGTH OF ALL SUPPLY DUCTS.
7. DUCTS SHALL BE FABRICATED FROM 24 GAGE GALVANIZED STEEL SHEET METAL.
8. COORDINATE MECHANICAL WORK WITH THE FABRICATION OF MOUNTING BRACKETS PLUMBING WORK AND ELECTRICAL WORK.
9. INSTALL AUTOMATIC FIRE DAMPERS AT DUCT PENETRATION OF ALL FIRE RATED WALLS, INCLUDING BUT NOT LIMITED TO EXTERIOR BUILDING WALL AND CORRIDOR WALLS, ETC.
10. INSTALL IN-LINE SMOKE DETECTORS WITHIN THE PLENUM AS REQUIRED BY CODE.
11. CONTRACTOR SHALL SUBMIT SHOP DRAWINGS, SAMPLES, CATALOG CUTS AND MANUFACTURER'S SPECIFICATIONS FOR APPROVAL TO THE ARCHITECT PRIOR TO INSTALLATION.



Inter American Institute of Architects

8030-B GEORGIA AVENUE
SILVER SPRING, MD 20910

(301) 608-0988 OFFICE
(301) 608-0666 FAX
E-Mail: WJMAIDEN@AOL.COM
Web Site: 1stPage.COM/MAAE

Owner's Name:


LORRAINE WILSON
1324 Kenyon Street, NW
Washington, D. C. 200
(202) 462-5047

Project Name:

ALTERATION & REPAIR
TO EXISTING BUILDING
FOR USE AS A
SINGLE-FAMILY HOUSE
(ROWHOUSE)

AT
1324 Kenyon Street, NW
Washington, D. C. 200
R4 LOT AREA:
842 3,707 S. F.
2848

ALL ELECTRICAL EQUIPMENT AND/OR APPLIANCES THAT
BEAR THE LABEL OF AN APPROVED MEMBER SHALL BE
APPROVED FOR THE PROPOSED USE AND LOCATION AND
SHALL BE INSTALLED IN ACCORDANCE WITH THE
MANUFACTURER'S INSTALLATION INSTRUCTIONS.

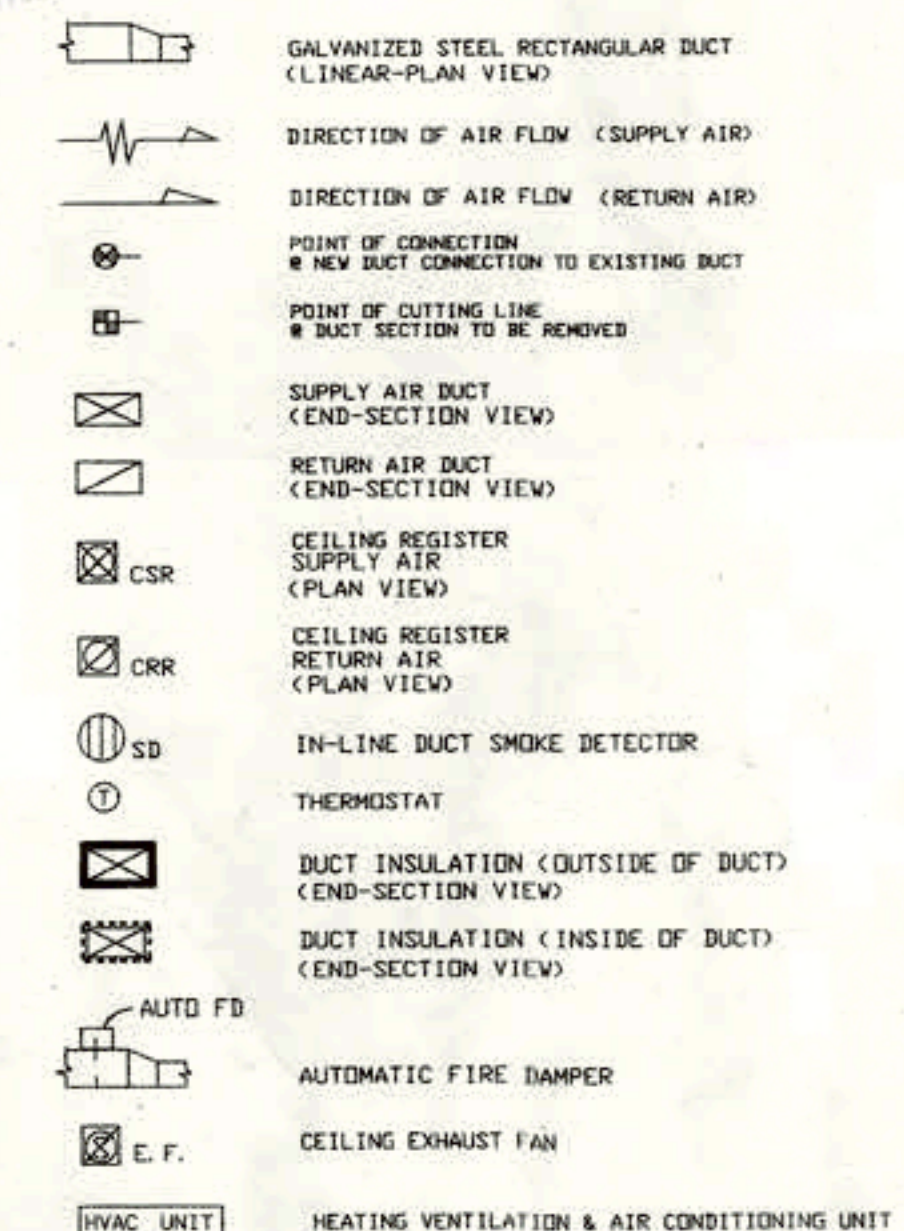

NOTE:

1. ALL BATHROOM EXHAUST FANS SHALL BE VENTED THRU ROOF WITH G.P.D.A.
2. INDIVIDUAL ROOM DUCT/REGISTERS/GRILLS SHALL BE LOCATED NEAR OUTSIDE WALLS AT EACH ROOM; AND SHALL BE LOCATED IN A PLACE SELECTED BY THE OWNER & HVAC INSTALLER.

THE GENERAL LAYOUT OF THE MECHANICAL SYSTEMS AND/OR THE MECHANICAL EQUIPMENT SHOWN ON THESE DRAWINGS HAS BEEN REVIEWED FOR COMPLIANCE WITH THE APPLICABLE PROVISIONS OF THE U.S. CONSTRUCTION CODES AND IS APPROVED


Date AUG 23 2001
Mechanical Engineering Division 1681

Revision Number	Revision Name	Revision Date
-----------------	---------------	---------------


Drawing Names

© Copyright 2001
This Drawing and Design in-whole or in-part shall
not be reproduced without written permission from
Maiden and Associates.


Harden and Associates.		Drawing Sheet Number:
Contract Date: 01/20/01 REV. 5/18/2001	Designed by:	M1
	Designed by:	
	Autocad by:	
	Checked by:	
Architect's Project Number:	Checked by:	Sheet _____ of _____
	Checked by:	
	Checked by:	

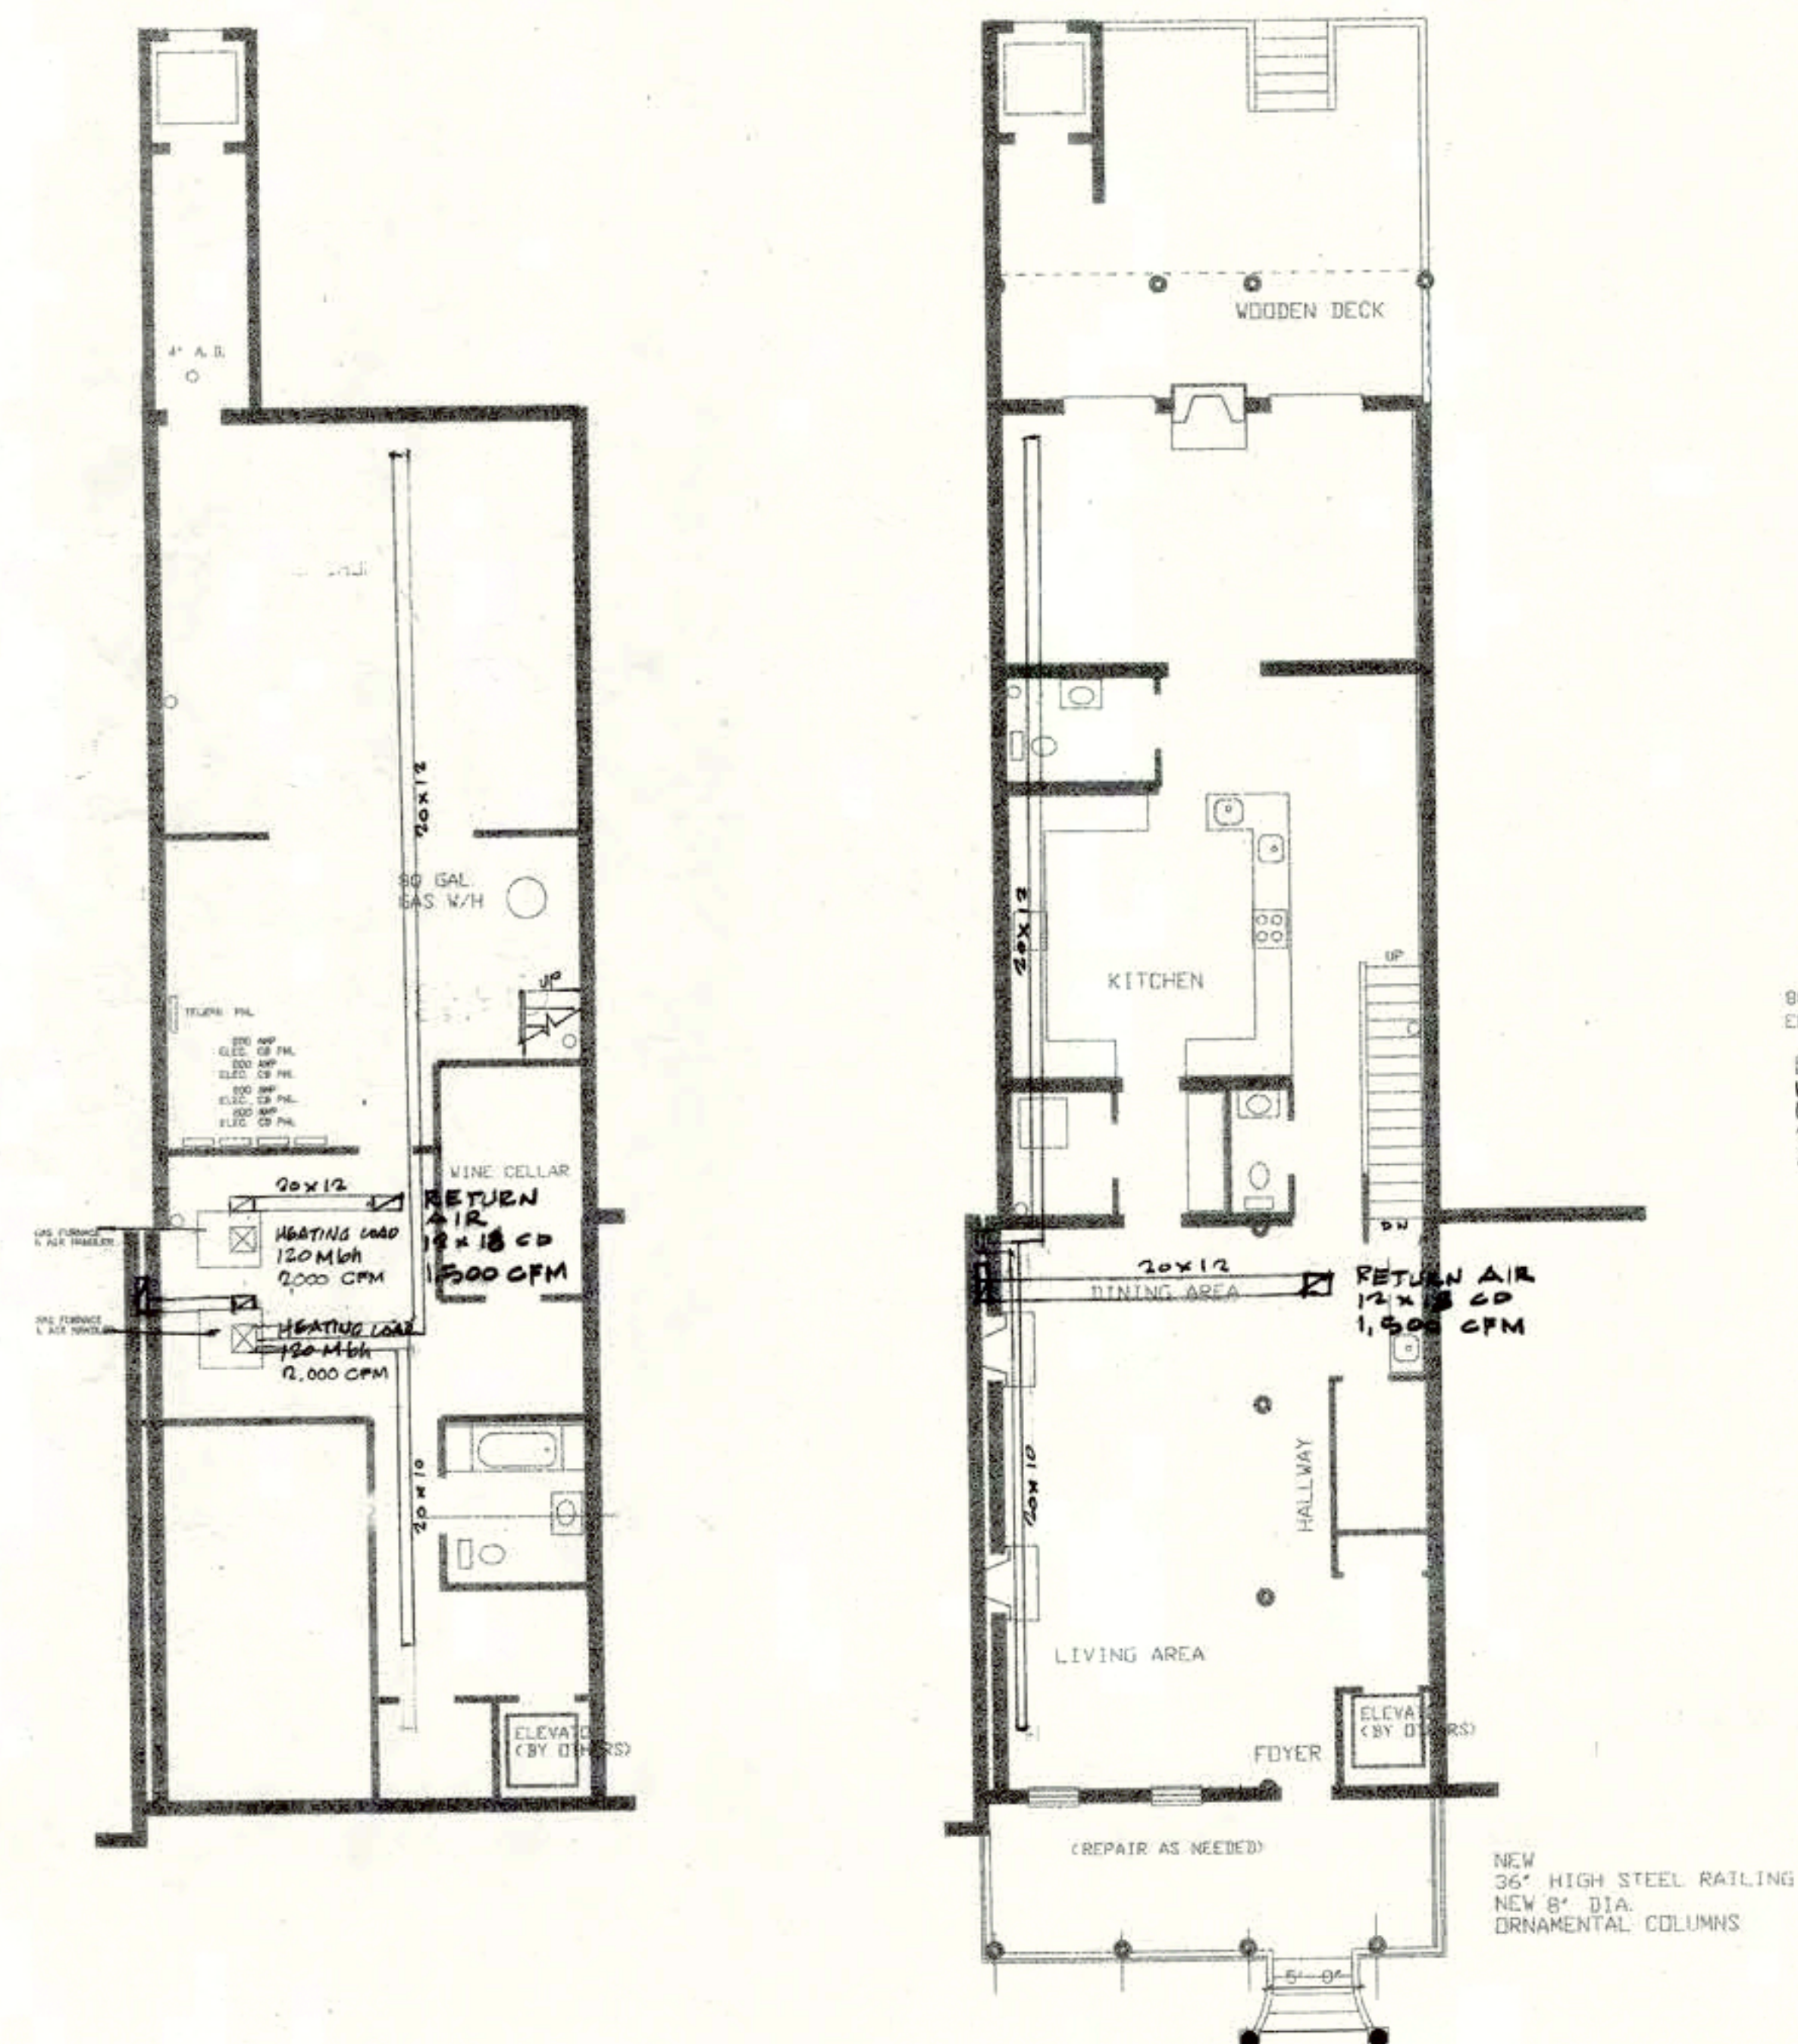


BASEMENT FLOOR PLAN
SCALE 1/8" = 1'-0"

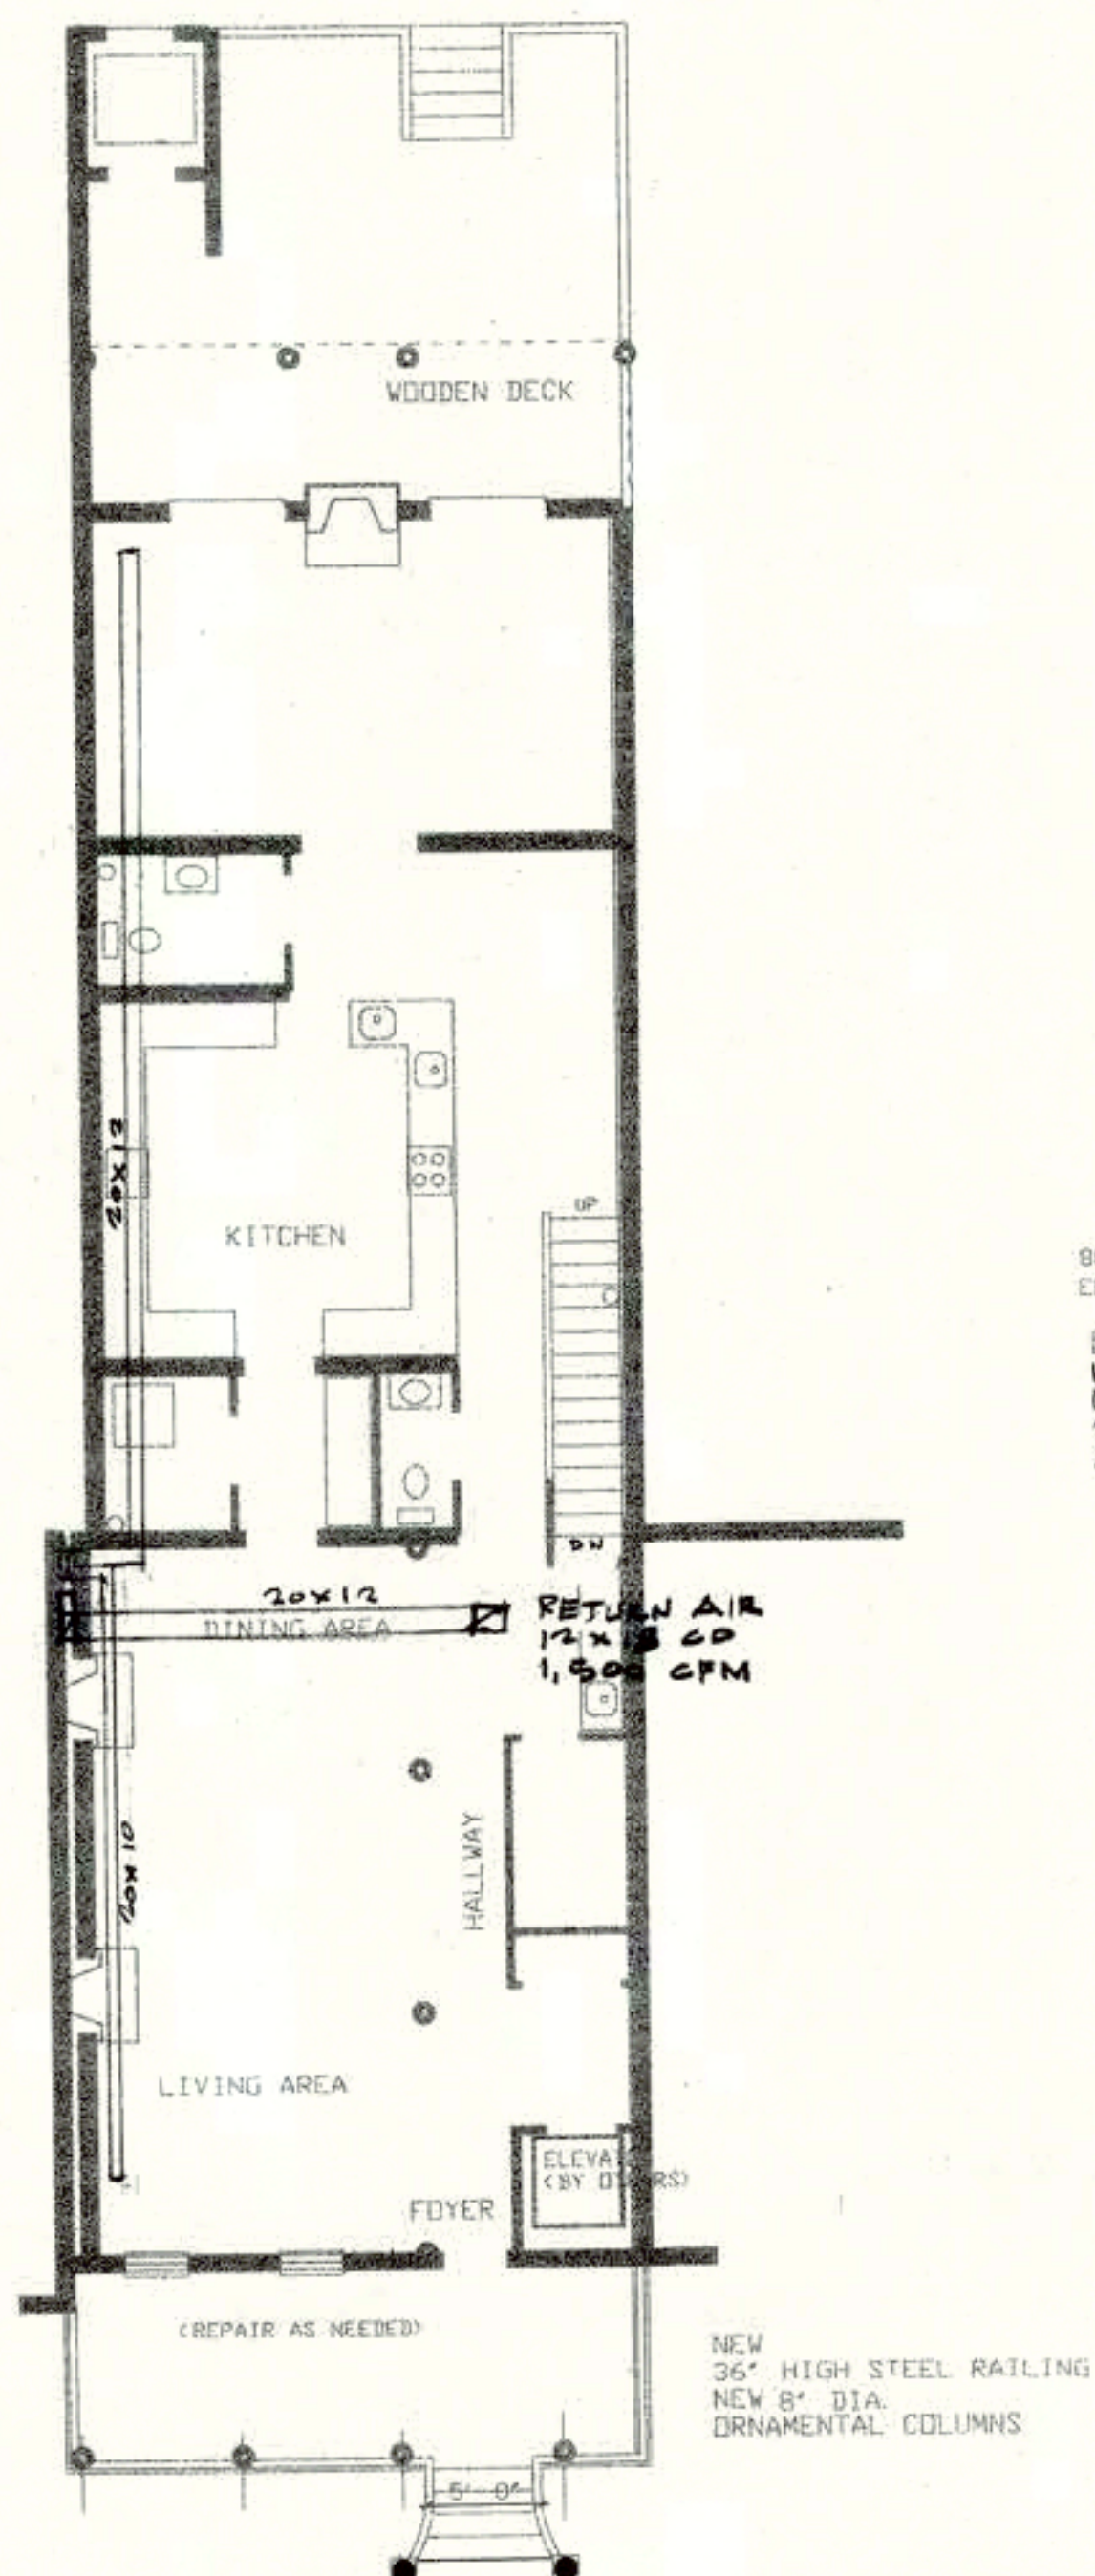

FIRST FLOOR PLAN
SCALE 1/8" = 1'-0"

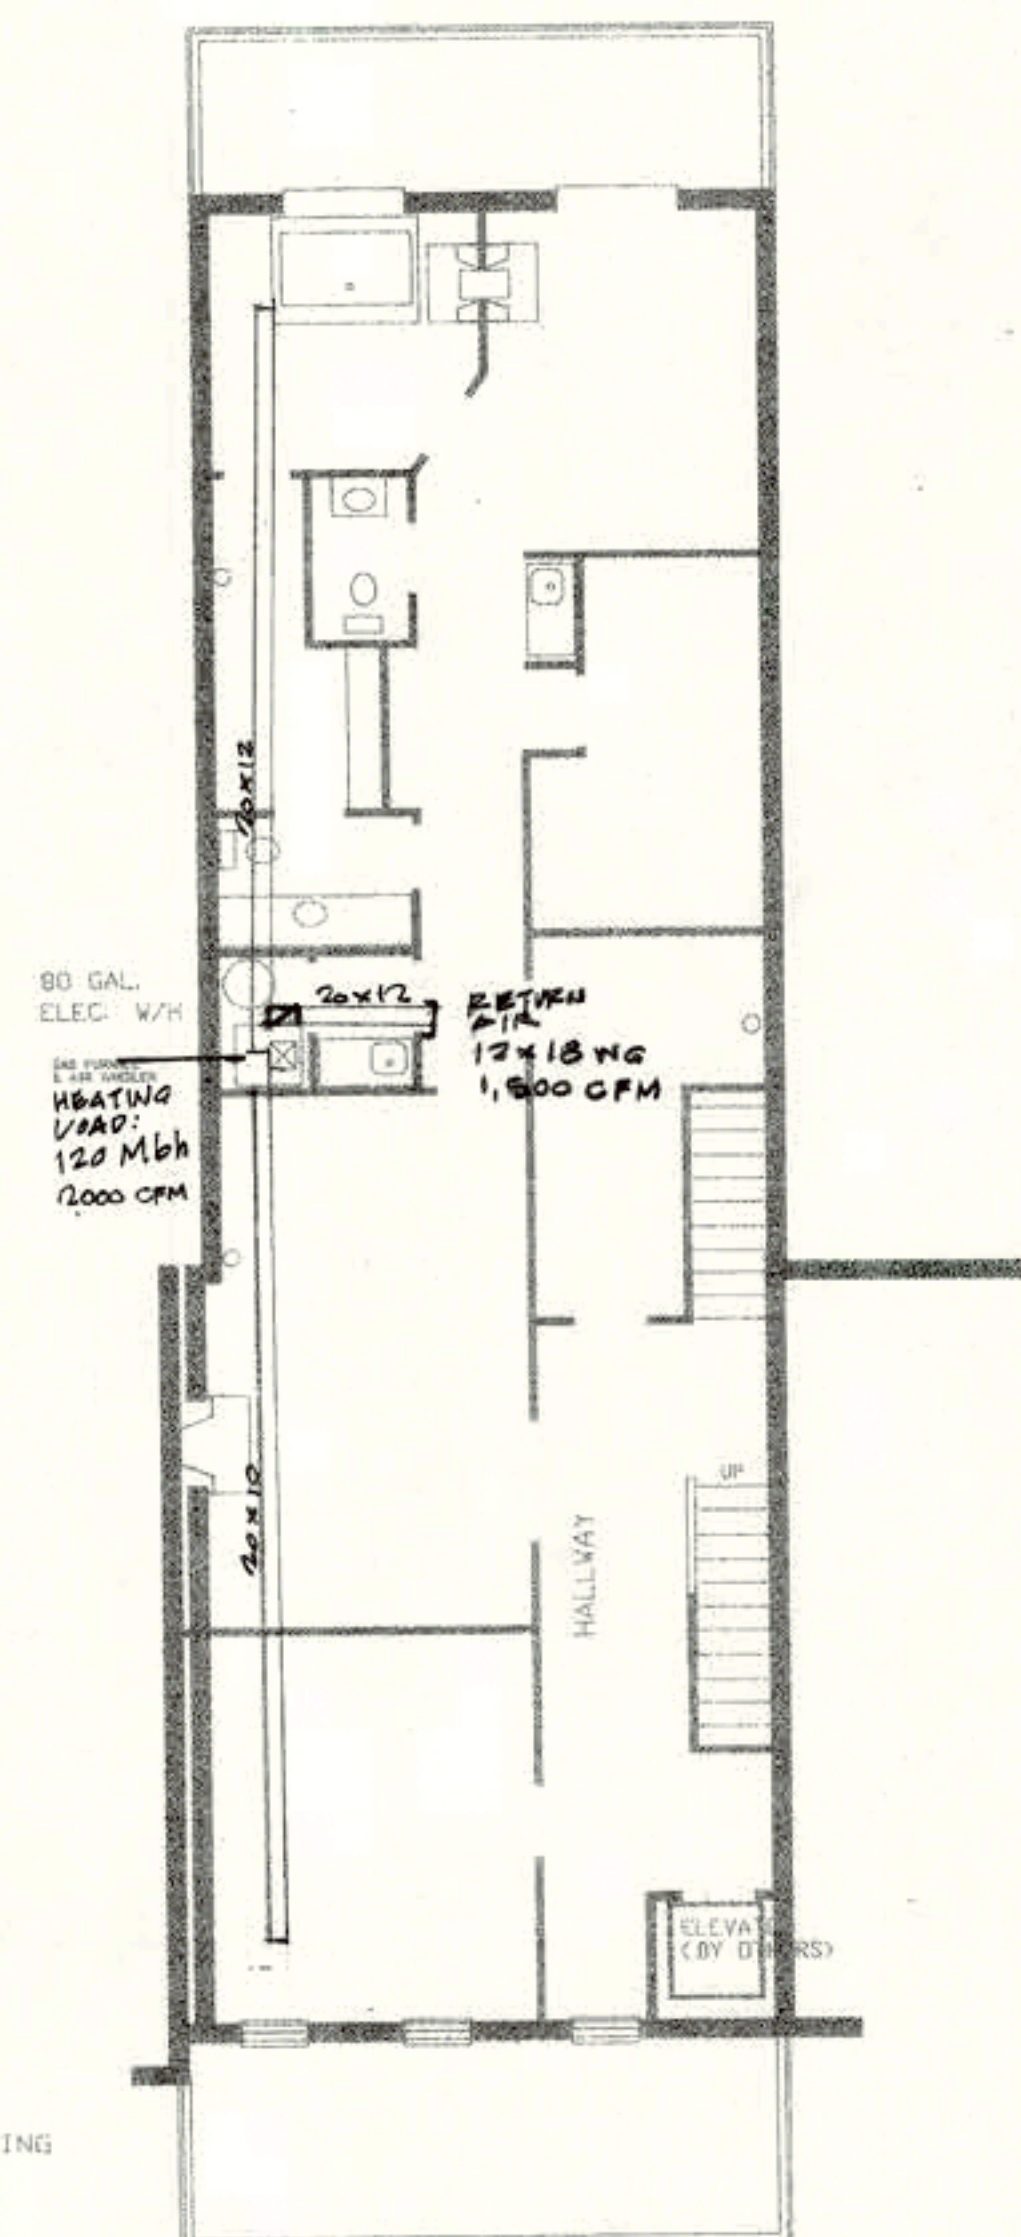

SECOND FLOOR PLAN
SCALE 1/8" = 1'-0"

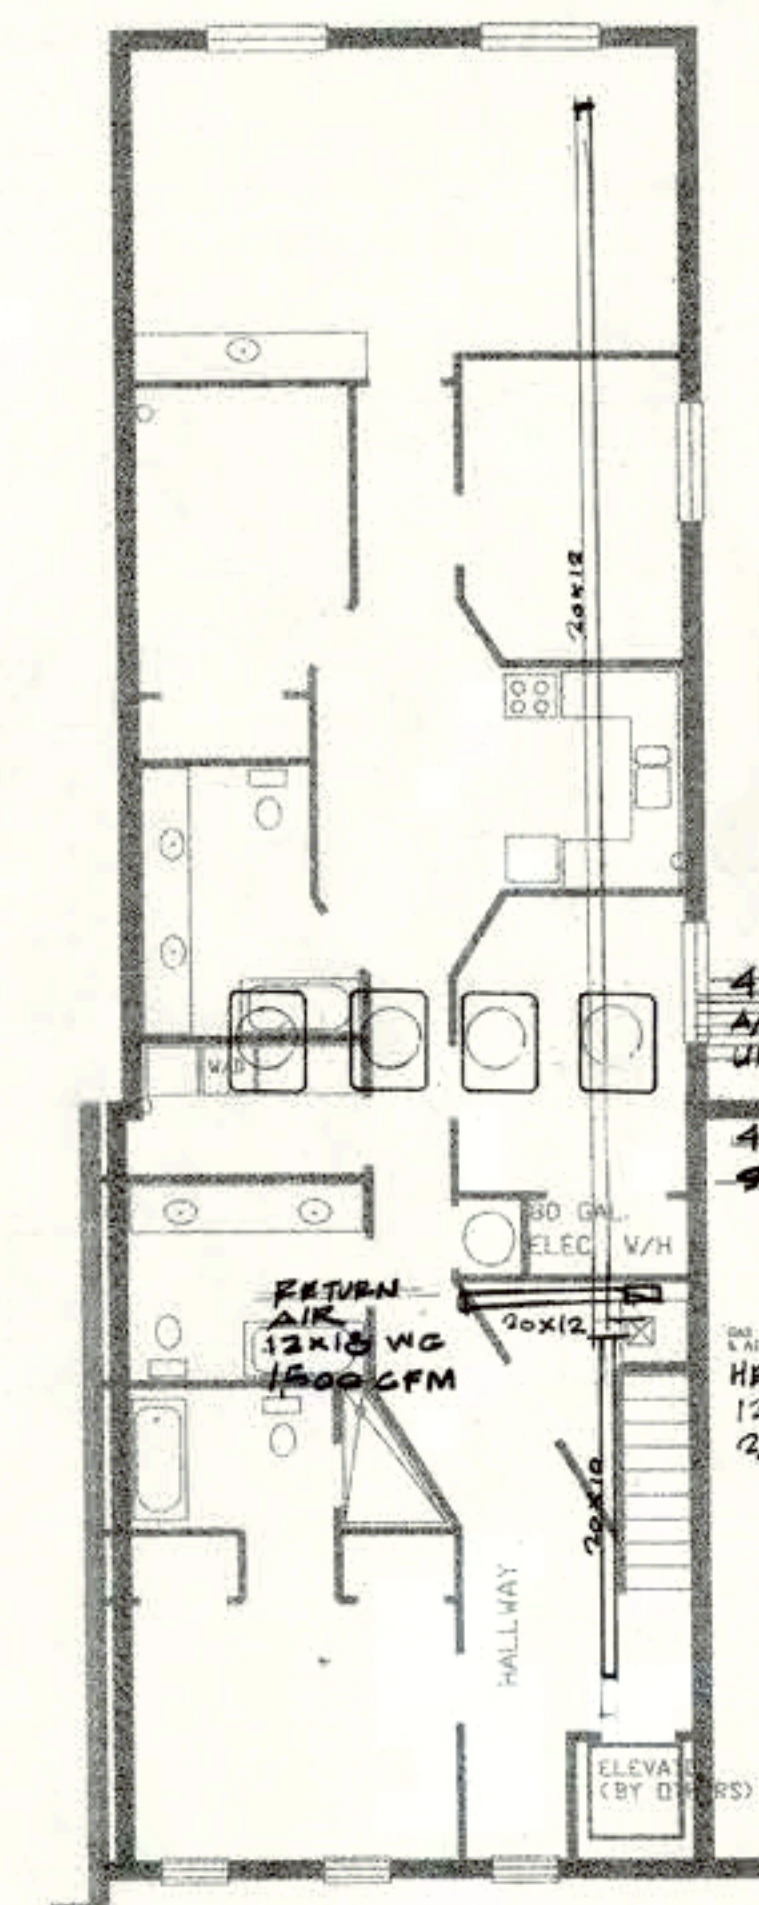

THIRD FLOOR PLAN
SCALE 1/8" = 1'-0"

WILLIE JAMES MAIDEN, AIA



MAIDEN AND ASSOCIATES
Architects / Engineers / Planners
8030-B Georgia Avenue
Silver Spring, MD 20910
(301) 608-0988

Owner's Name:

LORRAINE WILSON
324 Kenyon Street, NW
Washington, D. C. 200
(202) 462-5047

Project Name:

**INTERIOR
 ALTERATION & REPAIR
 TO EXISTING BUILDING
 FOR USE AS A
 SINGLE-FAMILY HOUSE
 (ROWHOUSE)
 AT**
**324 Kenyon Street, NW
 Washington, D. C. 200**
 DESIGNATION: **R4** LOT AREA:
 DT: **842** **3,707 S.F.**
 SQUARE: **2848**
 Applicable Building Code:
 Use Group: **B**
 Construction Type: **1996 BDCA**

Revision Number	Revision Name	Revision Date
-----------------	---------------	---------------

REVISION	SCHEDULE
----------	----------

wing None

BASEMENT FLOOR PLAN
FIRST FLOOR PLAN
SECOND FLOOR PLAN
THIRD FLOOR PLAN

ELECTRICAL

Contract Date:	Designed by:	Drawing Sheet Number:
----------------	--------------	-----------------------

Designed by:	
Reviewed by:	

172000	Advised by:	E1
	Checked by:	

Director's cert	Checked by:	EL
--------------------	-------------	----


Checked by:
Checked by:

950 _____ Sheet _____ of _____

ELECTRICAL NOTES

- THE CONTRACTOR SHALL OBTAIN A SEPARATE ELECTRICAL PERMIT PRIOR TO STARTING THIS WORK AND OBTAIN ALL REQUIRED OCEA INSPECTIONS AND APPROVALS. ALL WORK SHALL BE DONE BY A LICENSEE ELECTRICIAN, REGISTERED IN D.C.
3. THE ELECTRICIAN SHALL TEST EXISTING ELECTRICAL SERVICE AND WIRING AND DEVICES, ETC. AND MAKE REPAIRS AND NEW INSTALLATIONS AS NEEDED AND OWNER, AS REQUIRED BY N.E.C. AND THE A. F. I. C. U. R. S. SHALL BE SELECTED BY THE OWNER.

ELECTRICAL SYMBOLS



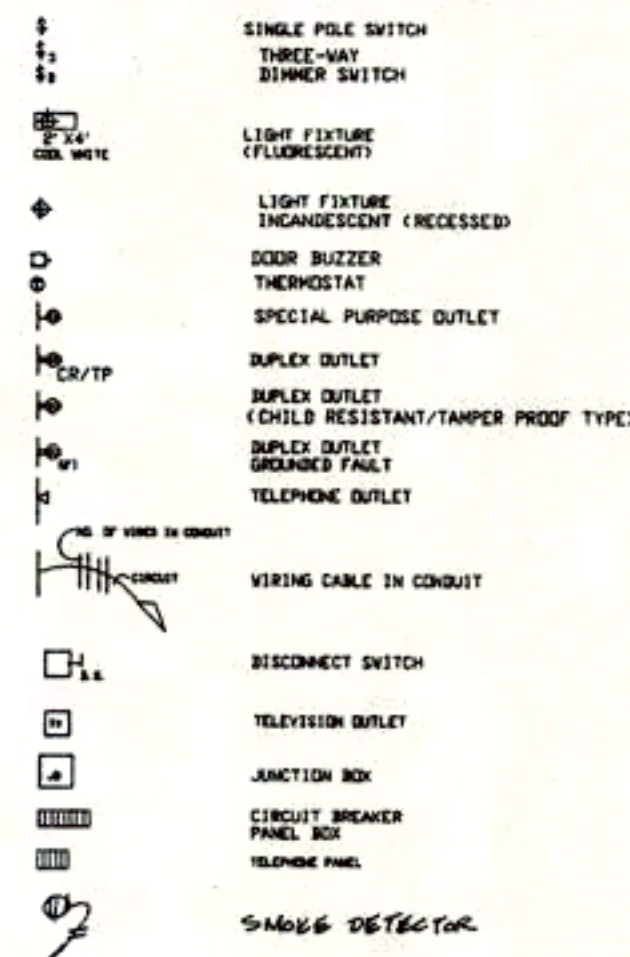


ELECTRIC PANEL SCHEDULE
(40 SPACE SINGLE PHASE CIRCUIT BREAKER PANEL w/ MAIN SWITCH)


ITEM	WATTS	POLE	FUSE	WIRE	MAIN BREAKER 200 AMP	WIRE	FUSE	POLE	WATTS	ITEM	
LIGHTS	600		15	14-2	1	2	14-2	15	1, 440	RECEPTACLES	
LIGHTS	600		15	14-2	3	4	14-2	15	1, 440	RECEPTACLES	
LIGHTS	600		15	14-2	5	6	14-2	15	1, 440	GFI RECEPTACLES	
LIGHTS	600		15	14-2	7	8	12-2	20	1, 800	RECEPTACLES (REFRIG.)	
LIGHTS	600		15	14-2	9	10	12-2	20	1, 800	RECEPTACLES (WIRING)	
LIGHTS	600		15	14-2	11	12	14-2	15	1, 440	RECEPTACLES	
LIGHTS	600		15	14-2	13	14	14-2	15	1, 440	RECEPTACLES	
BATHROOM EXHAUST FAN	900		20	12-2	15	16	14-2	15	1, 440	RECEPTACLES	
BATHROOM EXHAUST FAN	900		20	12-2	17	18	14-2	15	1, 440	GFI RECEPTACLES	
					19	20	14-2	15	1, 440	RECEPTACLES	
DOOR BELL / SMOKE DETECTORS	800		20	12-2	21	22	14-2	15	1, 440	RECEPTACLES	
SECURITY ALARM SYSTEM	400		15	14-2	23	24	14-2	15	1, 440	GFI RECEPTACLES	
HEAT PUMP UNIT (HVAC SYSTEM)	5, 775		60	8-3	25	26	12-2	20	950	GARBAGE DISPOSAL	
					27	28	12-2	20	1	750	RANGE HOOD
SPARE					29	30	12-2	20	1	1, 800	WASHER
SPARE					31	32	12-2		1	1, 600	DISHWASHER
SPARE					33	34					
SPARE					35	36	10-3	30	2	5, 760	CLOTHES DRYER
SPARE					37	38					
SPARE					39	40	8-3	60	2	5, 775	HEAT PUMP UNIT (HVAC SYSTEM)

SUBTOTALS:	LIGHTING	600w x 7 x 100% =	4,200w				
	RECEPTACLES	1,440w x 10 x 50% =	7,200w				
		1,800w x 2 x 100% =	3,600w				
EQUIPMENT	900 + 900 + 1,350 + 800 + 400 +	950 + 750 + 1,800 + 1,600 + 5,760 + 11,550w	x 100%	=	26,760w		
TOTAL:	41,760w / 240v = 174 AMPS (SPARE = 30 AMPS)						
 REQUIRED SERVICE: 200 AMP, 120/240V, 1 Ph., 3w, 60 Hz.							
UNDERGROUND SERVICE CABLE, 3-#1/0 RHW							
in 2-2" CONDUIT, w/ SPARE in 1-2" CONDUIT.							

NOTE: THIS PLAN SHOWS THE BASIC ELECTRICAL LAYOUT.
MODIFICATIONS MAY BE MADE BY THE ELECTRICIAN, OWNER
AND THE DORA ELECTRICAL INSPECTOR.

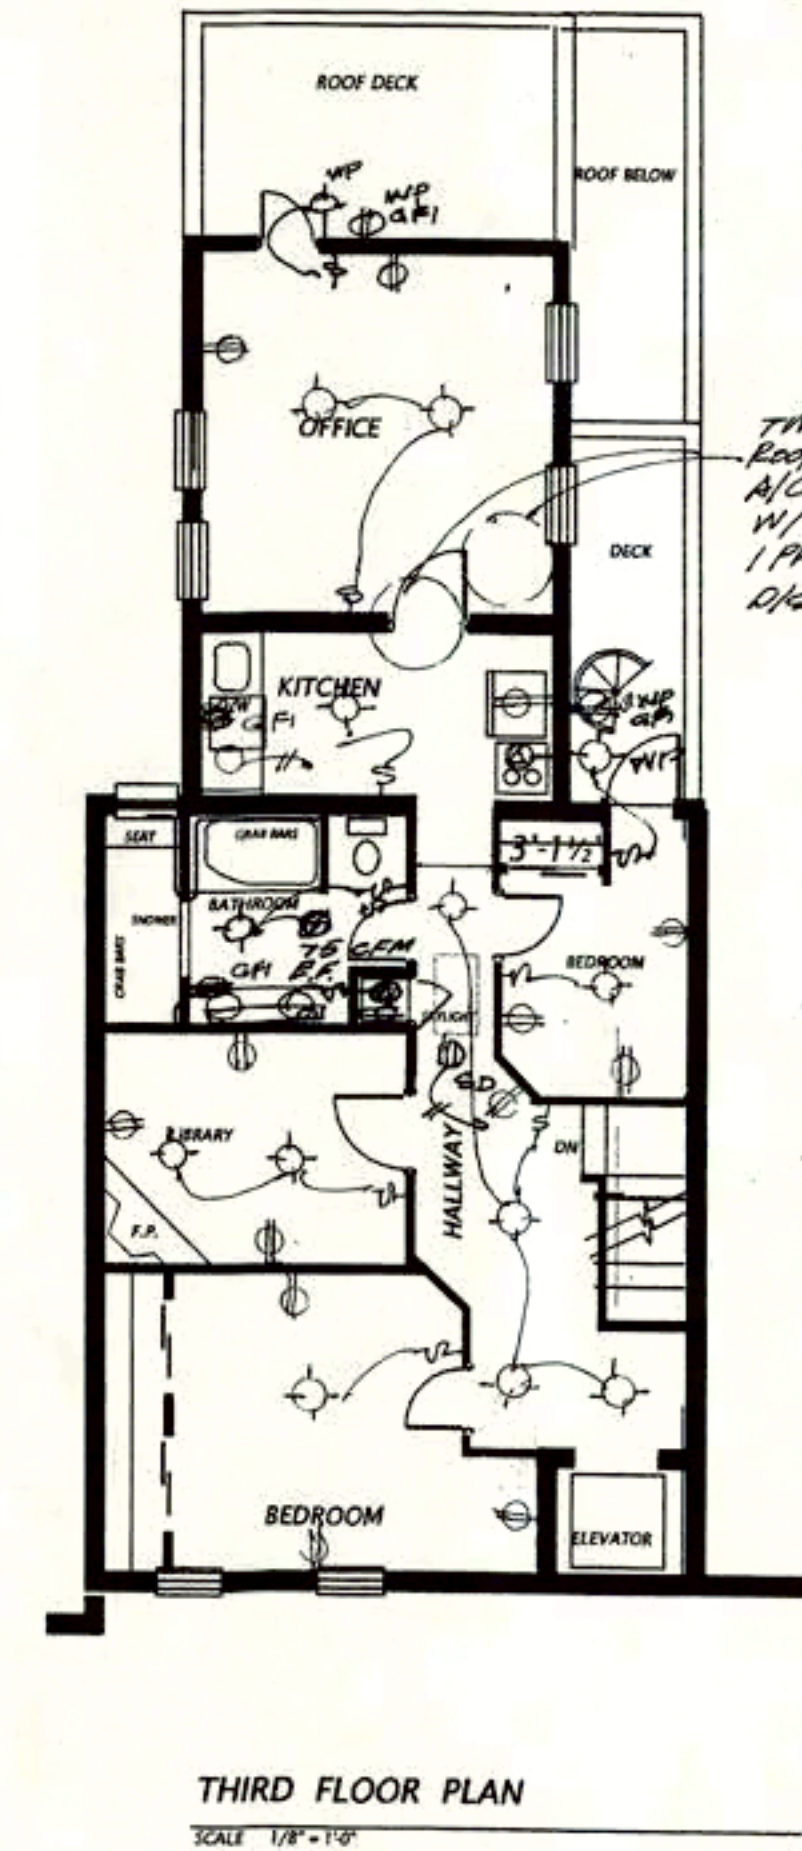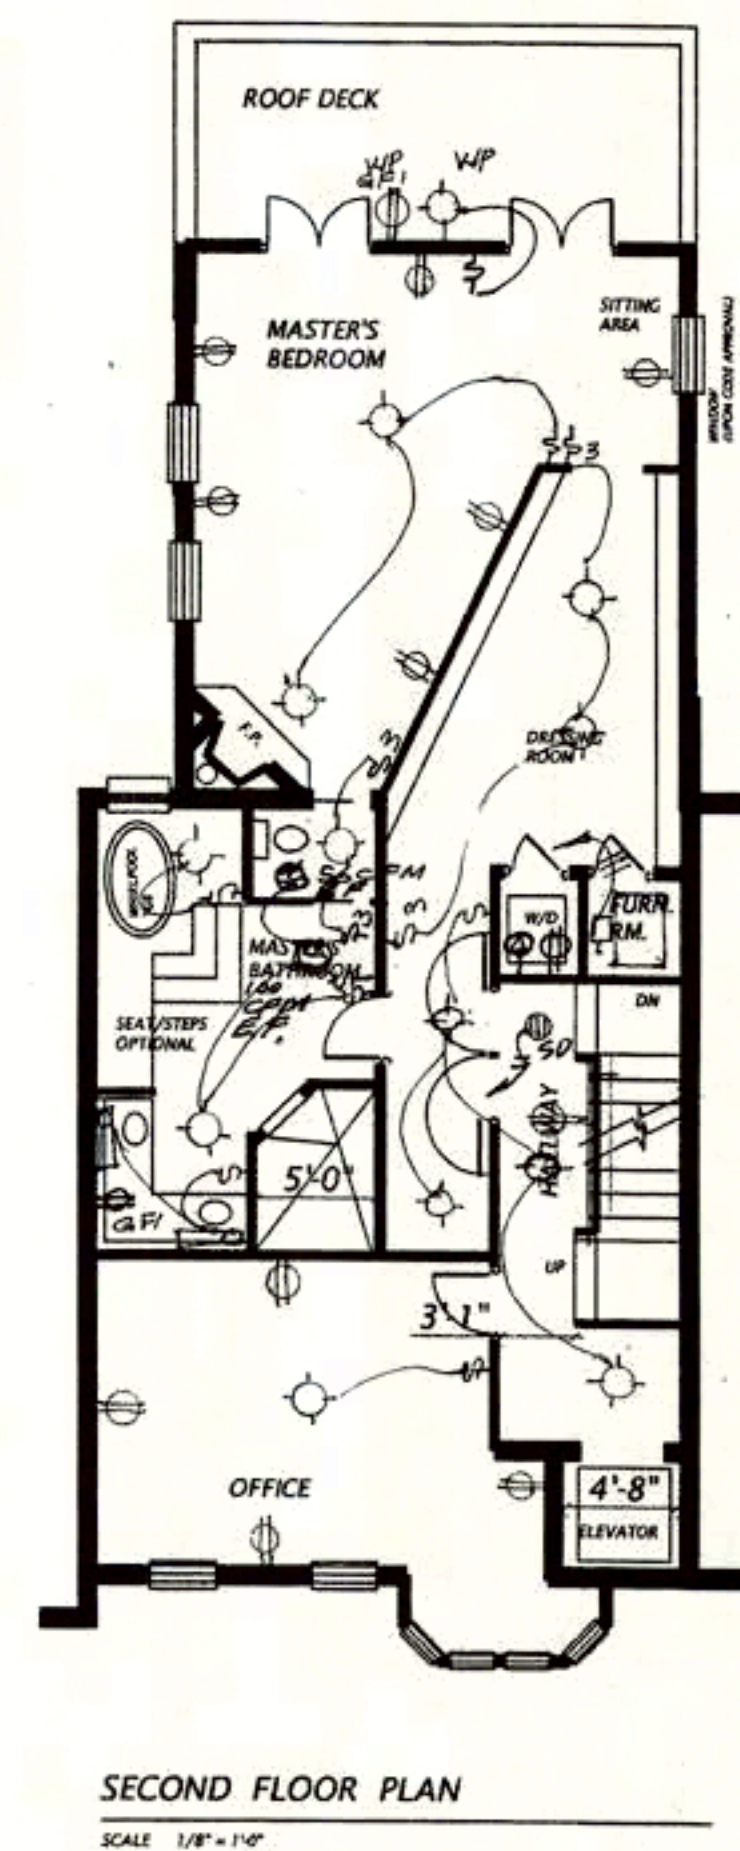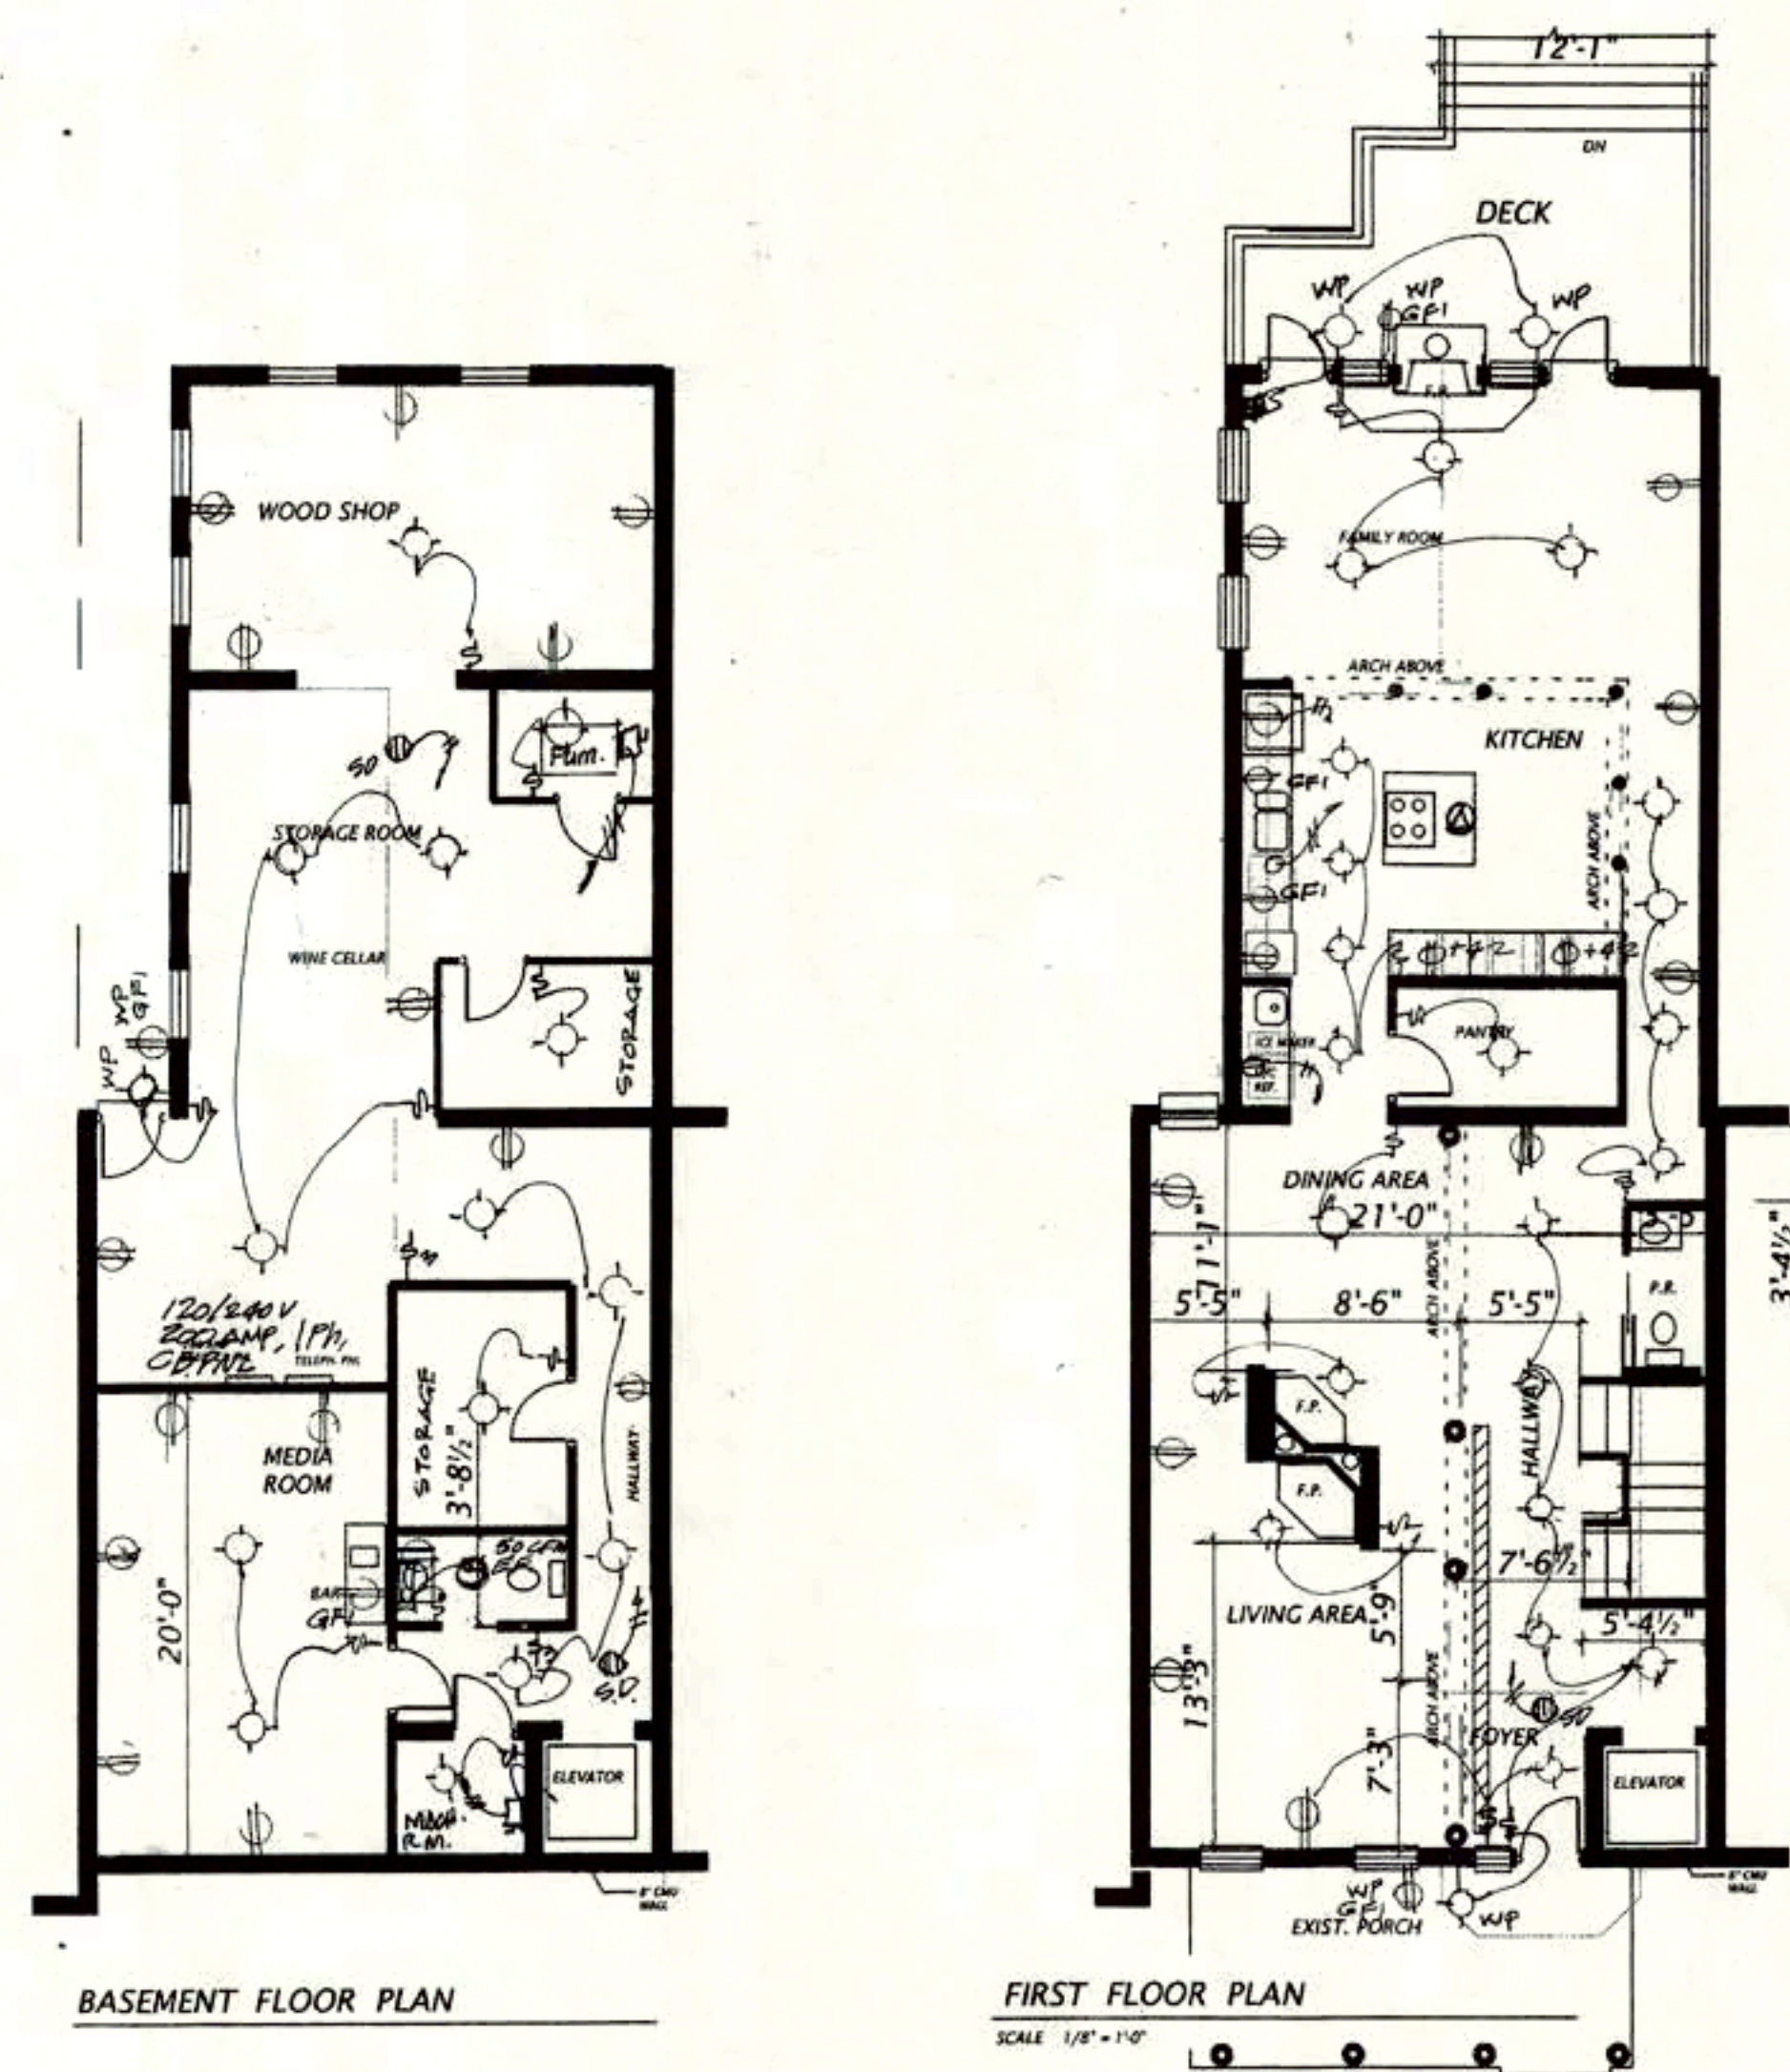

TWO
ROOF TOP
A/C UNITS
W/ 30 AMP
1 Ph, 240V 60Hz
D/K, EDC4

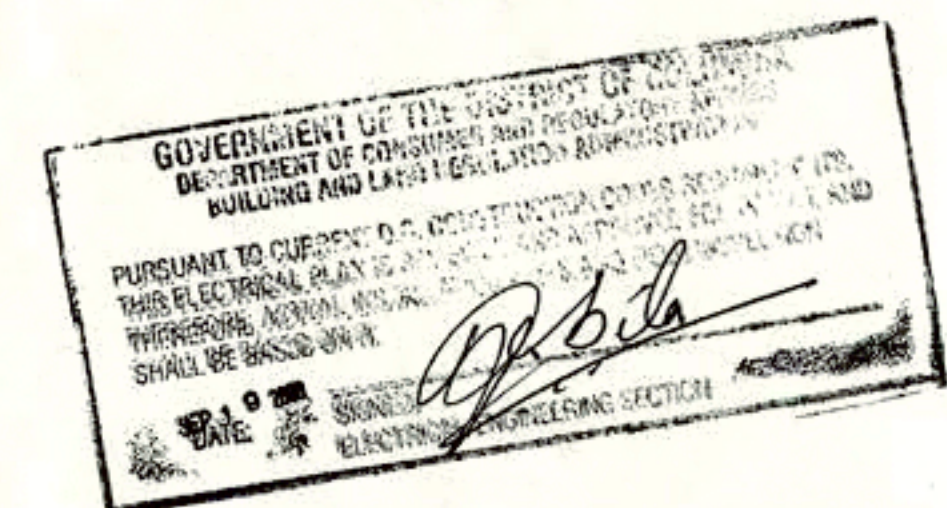

NEW SUB PANEL									
ITEM	TYP	WATTS	MAIN BREAKER		WATTS		ITEM		
			POLE/PHASE	WIRE	WIRE	POLE			
LIGHTS		600	1	ØØ	1Ø-Ø	1	1,440	RECEPTACLES	
LIGHTS		600	1	ØØ	1Ø-Ø	1	1,440	RECEPTACLES	
LIGHTS		600	1	ØØ	1Ø-Ø	1	1,440	Ø1 RECEPTACLES	
LIGHTS		600	1	ØØ	1Ø-Ø	1	1,600	RECEPTACLES (WET/UL)	
					1Ø-Ø	ØØ	1,900	RECEPTACLES (WET/UL)	
					1Ø-Ø	ØØ	1,900	RECEPTACLES (EQUIP.)	
BATHROOM EXHAUST FAN		900	1	ØØ	1Ø-Ø	1	1,600	RECEPTACLES (EQUIP.)	
BATHROOM EXHAUST FAN		900	1	ØØ	1Ø-Ø	1	1,600	RECEPTACLES (EQUIP.)	
					1Ø-Ø	ØØ	1,600	RECEPTACLES (EQUIP.)	
FIRE ALARM		1,800	1	ØØ	1Ø-Ø	1	1,800	RECEPTACLES (EQUIP.)	
(EQUIP.)		1,800	Ø	ØØ	1Ø-Ø	1	1,800	(EQUIP.)	
(EQUIP.)		1,800	Ø	ØØ	1Ø-Ø	Ø	1,800	(EQUIP.)	
(EQUIP.)		1,800	Ø	ØØ	1Ø-Ø	Ø	1,800	(EQUIP.)	
SPARE					Ø-Ø	4Ø	Ø,780	ØVAC SYSTEM	
SPARE									
SPARE									
SPARE									
SUBTOTALS: LIGHTING RECEPTACLES									
EQUIPMENT									
TOTAL:									





REQUIRED SERVICE:
ØØAMP, 1ØØ/ØVØ, 3Ø, 4ØØ, SINGLE PHASE,
5-Ø1/Ø RØØ IN 1-Ø" CONDUIT, Ø/ SPØØ IN 1-Ø" CONDUIT.

ITEM		VOLTS	W/TH BREAKER 200 AMP			WATTS	ITEM	
			POLAR	FUSE	WIRE			WIRE
LIGHTS	600	1	20	12-2	12-2	20	1,440	RECEPT
LIGHTS	600	1	20	12-2	12-2	20	1,440	RECEPT
LIGHTS	600	1	20	12-2	12-2	20	1,440	RECEPT
LIGHTS	600	1	20	12-2	12-2	20	1,440	RECEPT
							1,900	RECEPT
							1,900	RECEPT
							1,900	RECEPT
							1,900	RECEPT
BATHROOM EXHAUST FAN	900	1	20	12-2	12-2	20	1,800	RECEPT
BATHROOM EXHAUST FAN	900	1	20	12-2	12-2	20	1,800	RECEPT
							1,800	RECEPT
FIRE ALARM	1,900	1	20	12-2	12-2	20	1,800	RECEPT
(EQUIP.)	1,900	2	20	12-2	12-2	20	1,800	RECEPT
							1,800	RECEPT
(EQUIP.)	1,900	2	20	12-2	12-2	20	1,800	RECEPT
							1,800	RECEPT
(EQUIP.)	1,900	2	20	12-2	12-2	20	1,800	RECEPT
							1,800	RECEPT
SPARE						0-3	40	2,760
SPARE								
SPARE								
SPARE								
SUBTOTALS								
EQUIPMENT								
TOTAL:								

REQUIRED SERVICE:
200AMP, 120/240V, 2- 60HZ, SINGLE PHASE,
3-WIRE W/ GND, 2- 20 AMP, 12-2" CONDUIT

ELECTRIC PANEL SCHEDULE									
NEW SUB PANEL									
ITEM	WATTS	MAIN RECEIVER 100 AMP			WATTS	ITEM			
		POLE/USE	WIRE	WIRE/POLE					
LIGHTS	600	1	20	12-2	1-8	20	1, 440	RECEIPT	
LIGHTS	600	1	20	12-2	1-8	20	1, 440	RECEIPT	
LIGHTS	600	1	20	12-2	1-8	20	1, 440	RECEIPT	
LIGHTS	600	1	20	12-2	1-8	20	1, 800	RECEIPT	
		1	20	12-2	1-8	20	1, 800	RECEIPT	
		1	20	12-2	1-8	20	1, 800	RECEIPT	
BATHROOM EXHAUST FAN	900	1	20	12-2	1-8	20	1, 800	RECEIPT	
BATHROOM EXHAUST FAN	900	1	20	12-2	1-8	20	1, 800	RECEIPT	
		1	20	12-2	1-8	20	1, 800	RECEIPT	
FIRE ALARM	1, 800	1	20	12-2	1-8	20	1, 800	RECEIPT	
(EQUIP.)	1, 800	2	20	12-2	1-8	20	1, 800	RECEIPT	
(EQUIP.)	1, 800	2	20	12-2	1-8	20	1, 800	RECEIPT	
(EQUIP.)	1, 800	2	20	12-2	1-8	20	1, 800	RECEIPT	
SPAC					8-3	40	5, 760	SPAC	
SPAC									
SPAC									
SPAC									
SUBTOTAL									
EQUIPMENT									
TOTAL									

REQUIRES SERVICE
200AMP 120/240V 2N, GNC, SINGLE PHASE,
3-#1/0 BHN IN 2" CONDUIT, w/ SPARE IN 1-2" CONDUIT

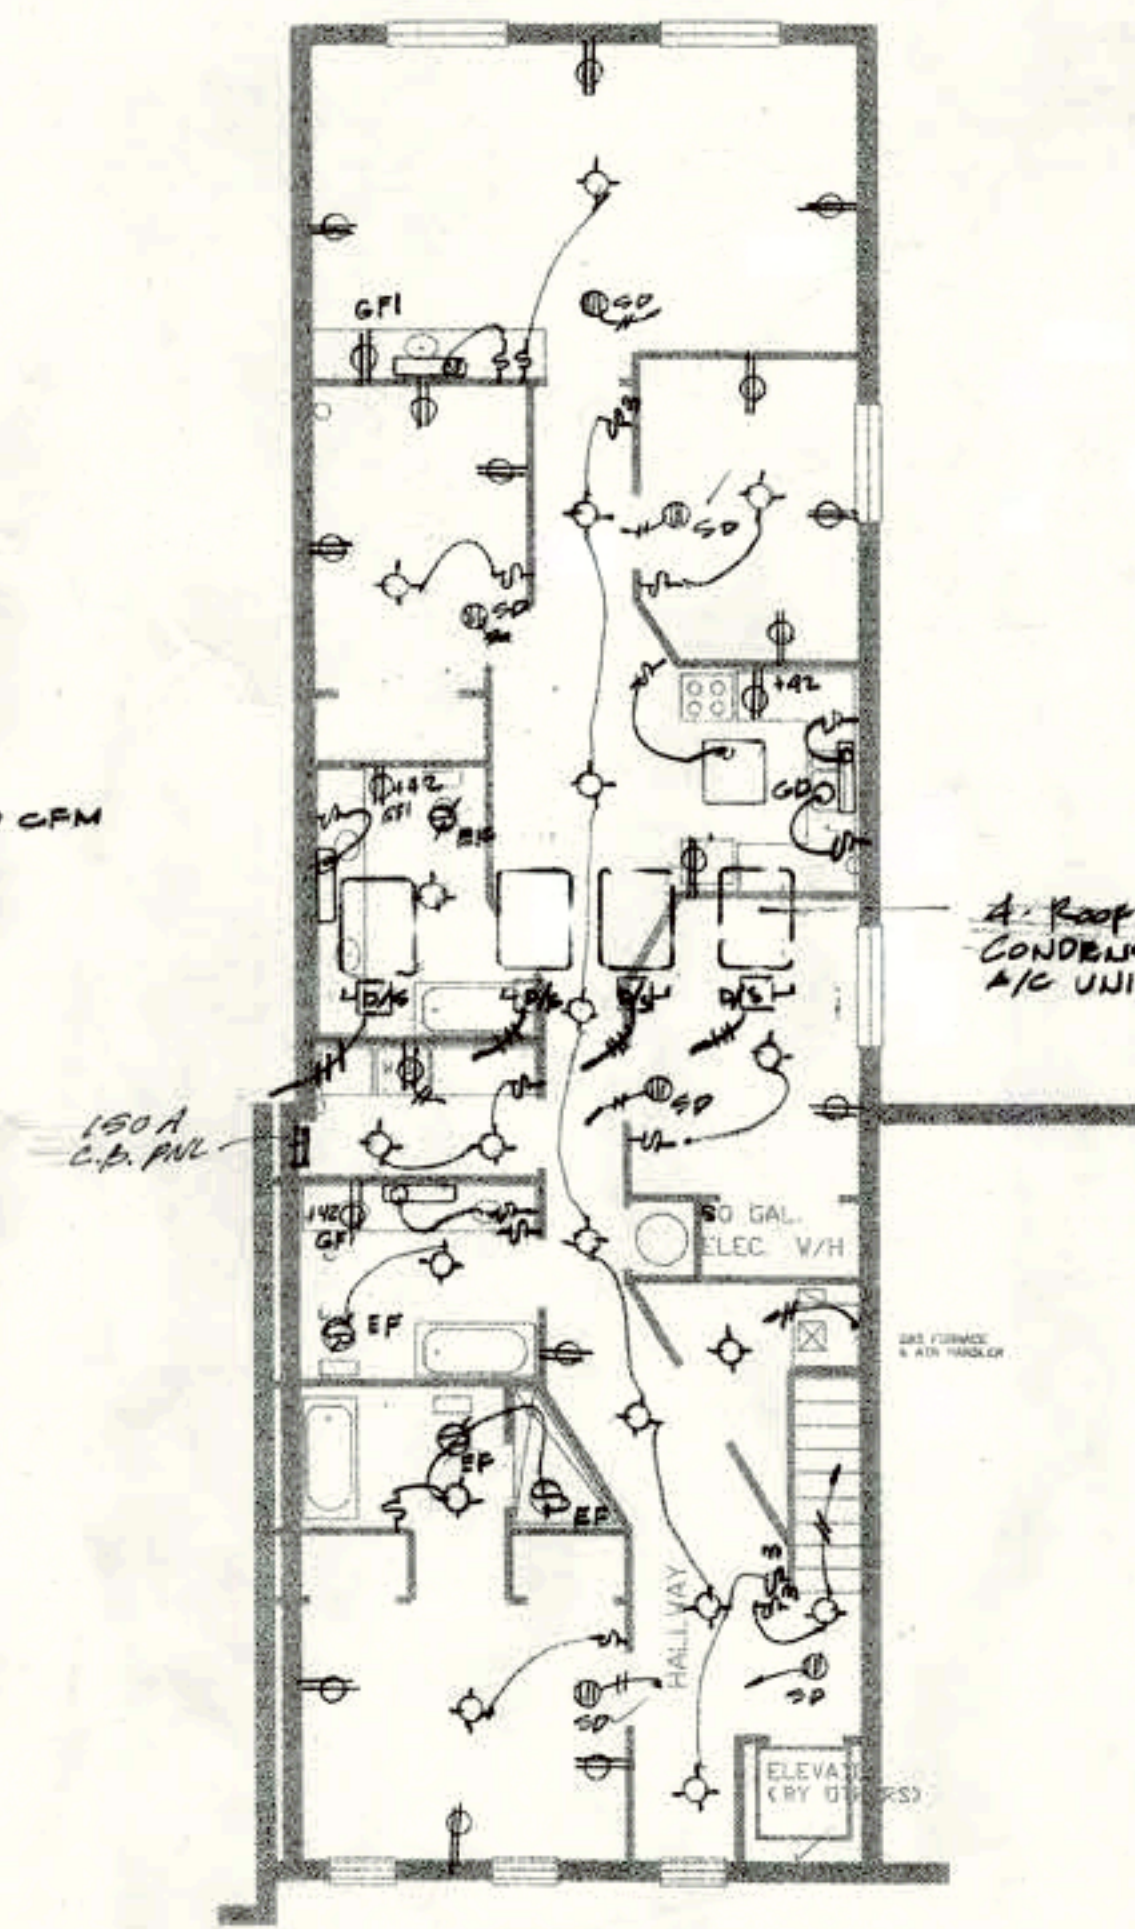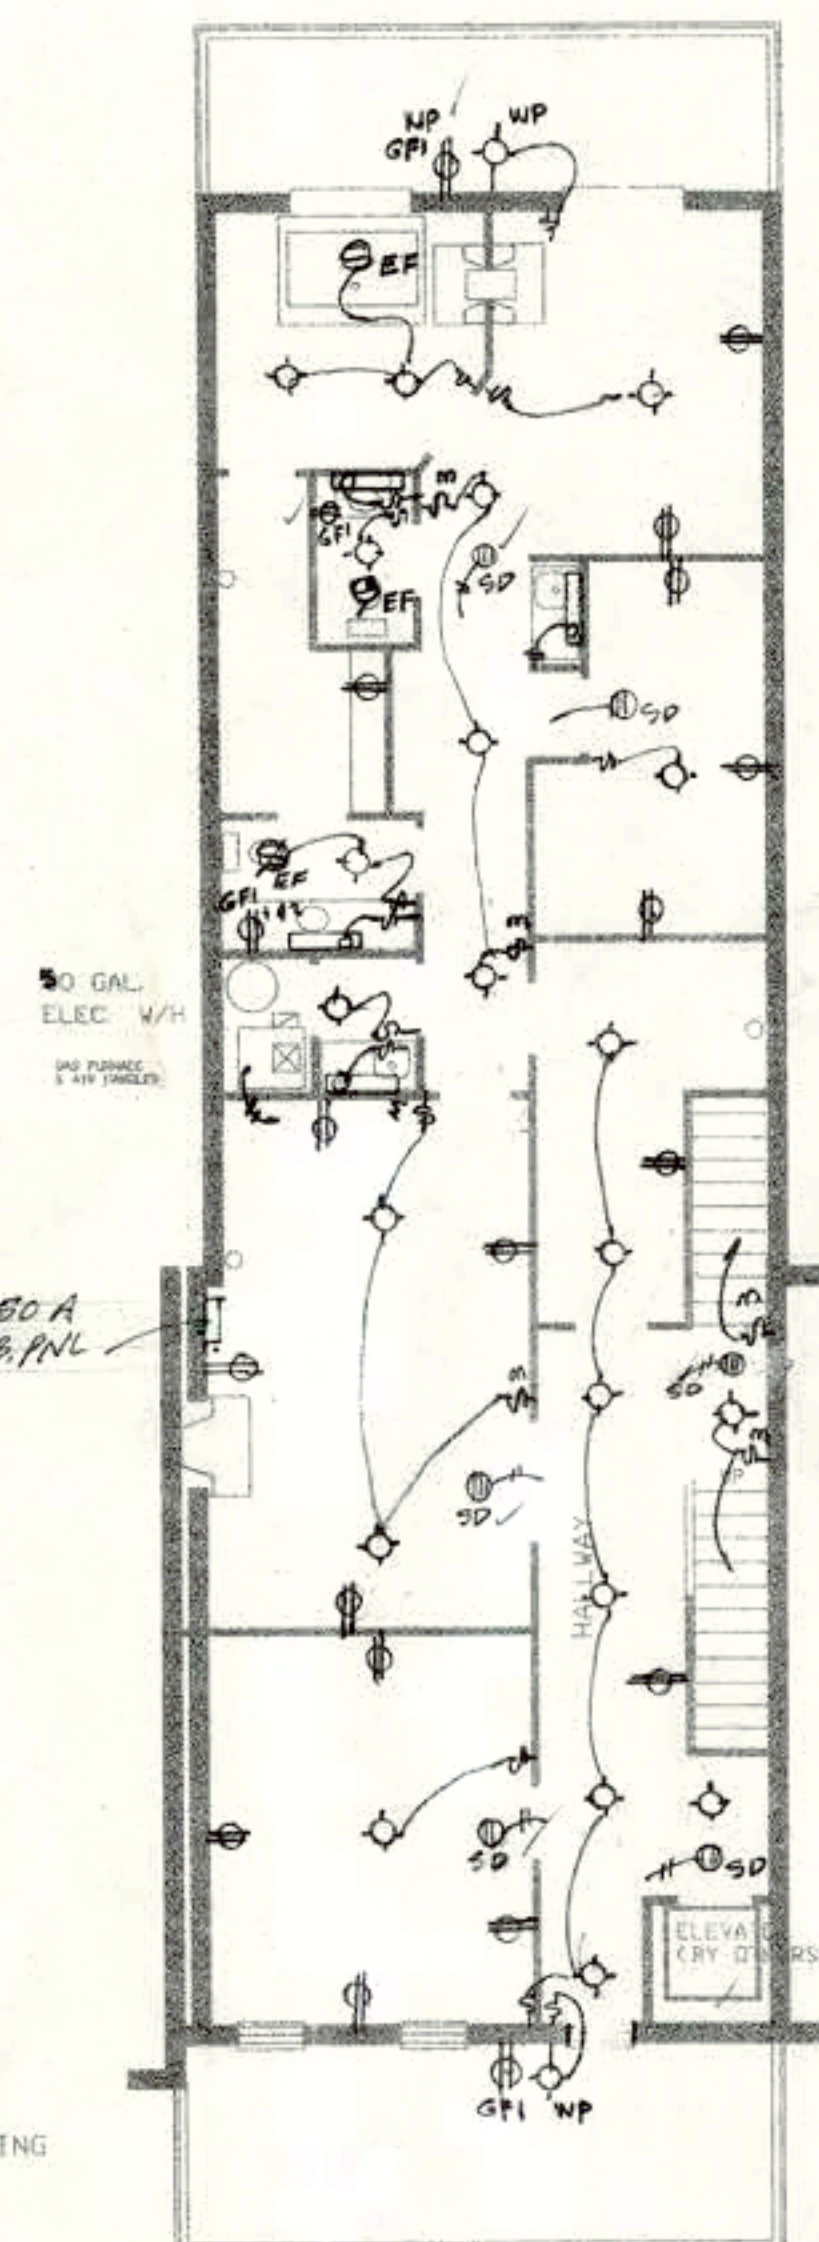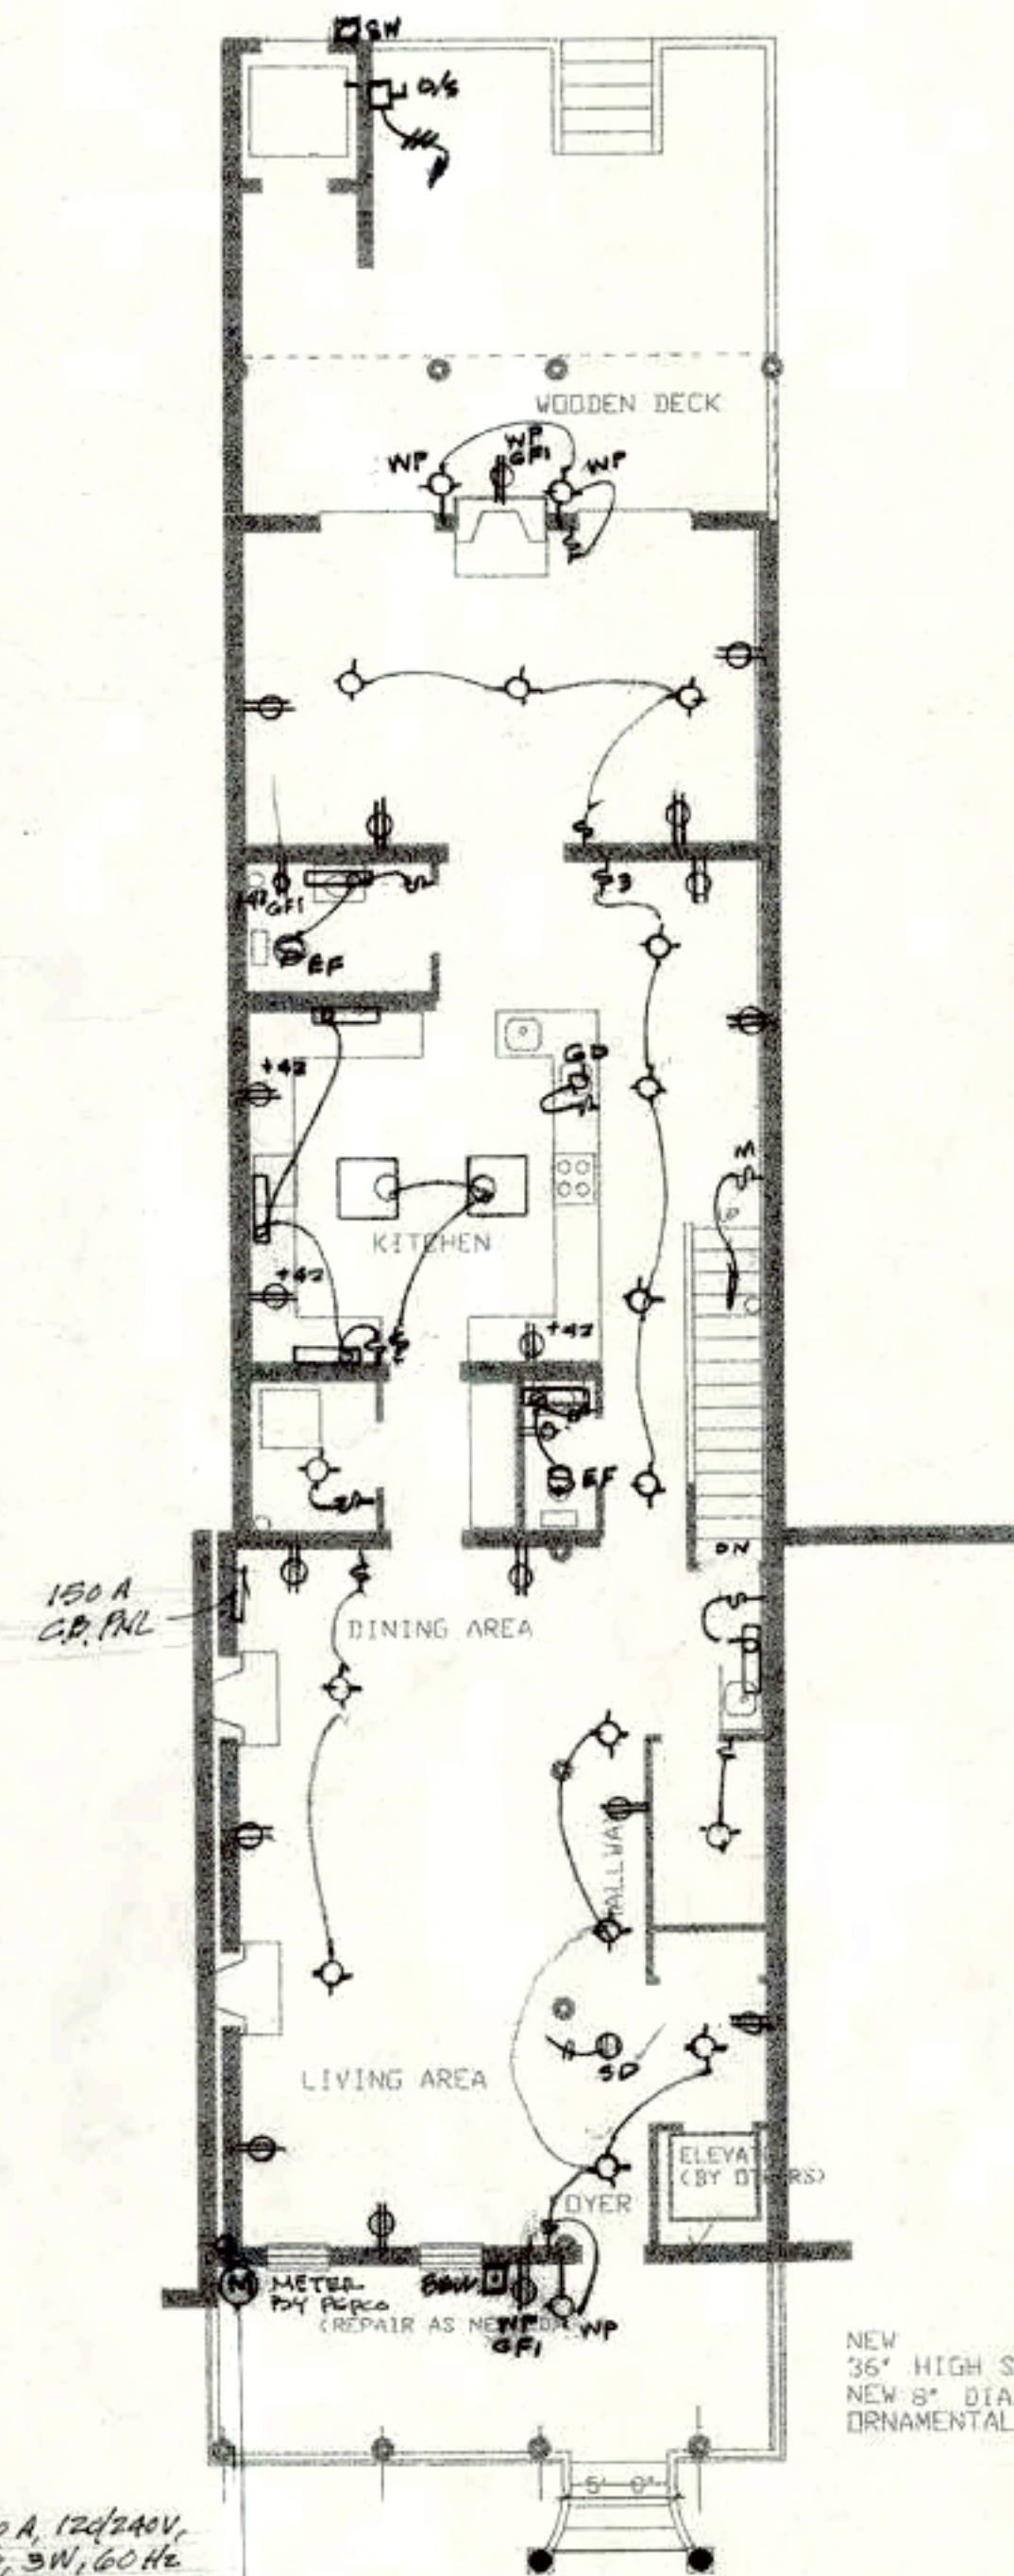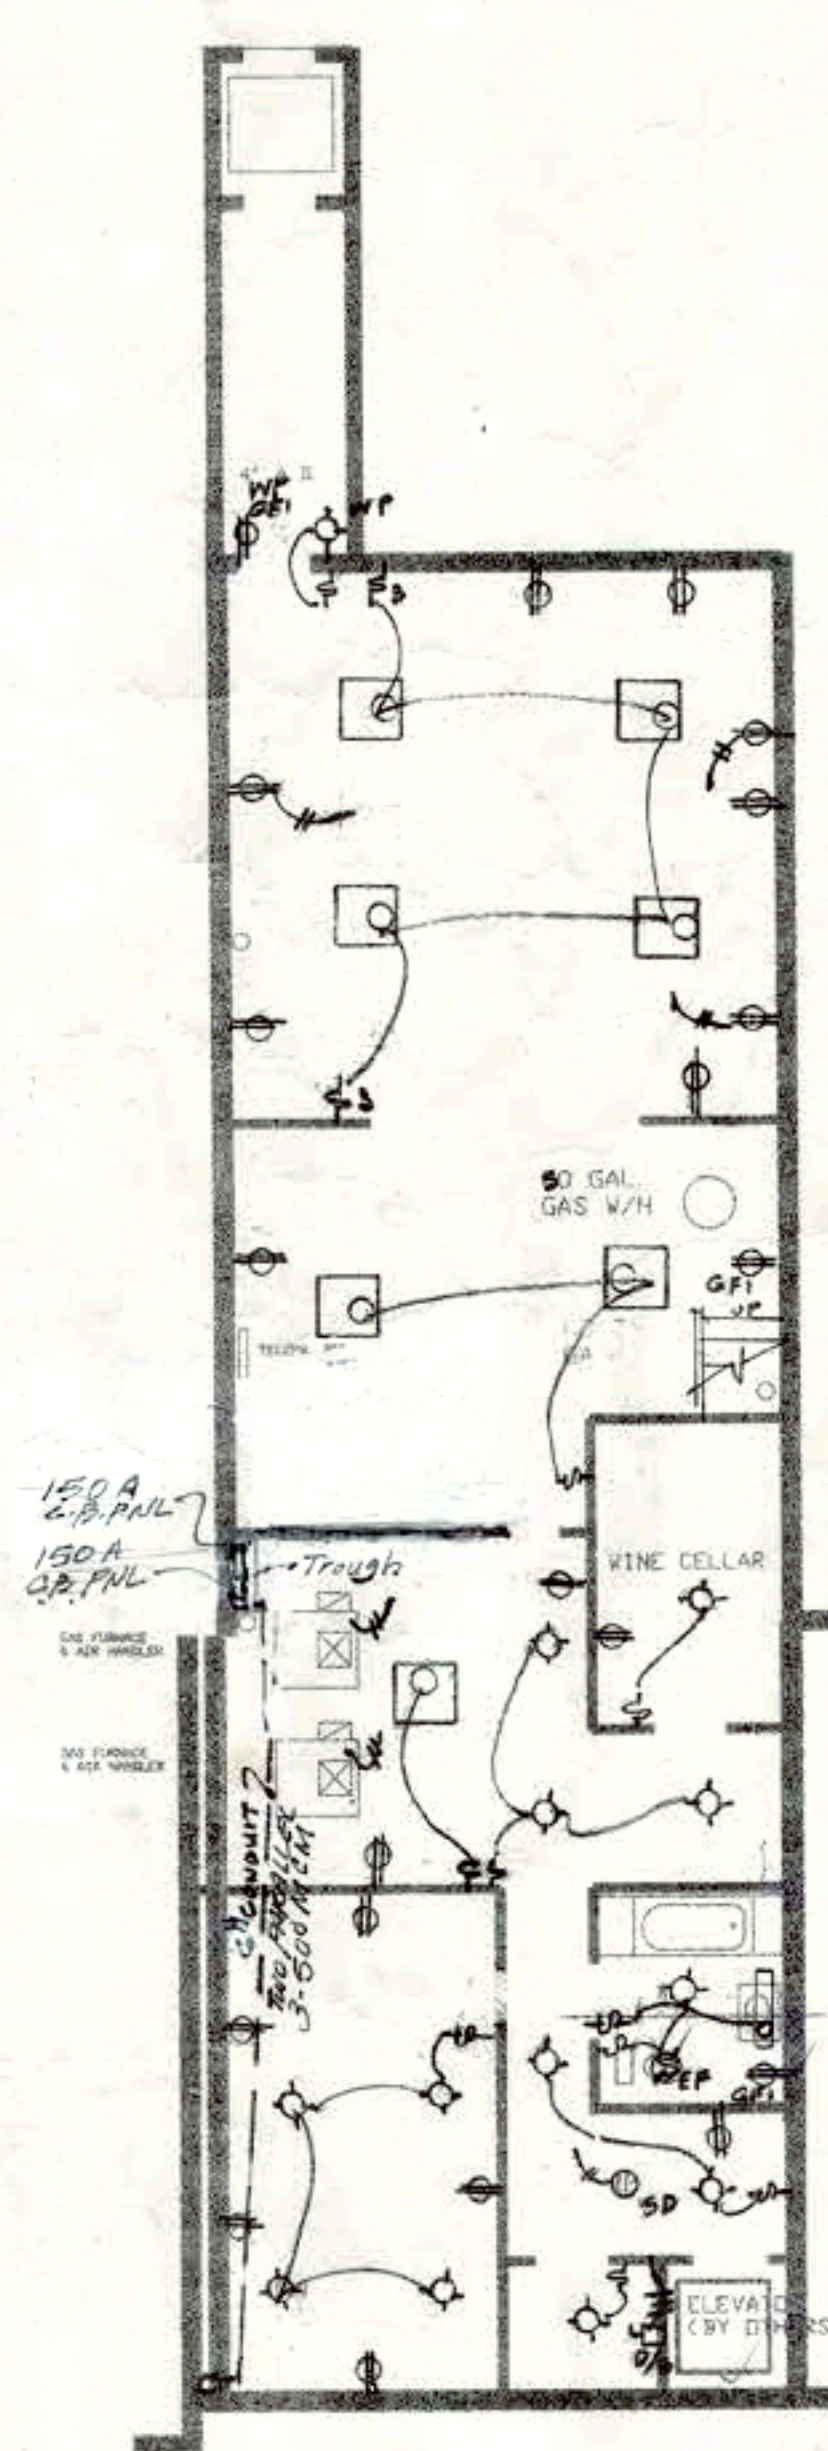

1. ALL ELECTRICAL WORK SHALL COMPLY WITH ALL APPLICABLE D.C. ELECTRICAL CODES.
2. ALL WORK SHALL BE PERFORMED BY A LICENSED ELECTRICIAN.
3. ELECTRICIAN SHALL GISS FUSES, DISCONNECTS, WIRING, SWITCHES, ETC. TO MEET MANUFACTURER'S SPECIFICATION EQUIPMENT RATING & DC CODES.
4. LIGHTING FIXTURES, DEVICES, SWITCHES MAY VARY FROM VOLTAGE IS SHOWN ON THIS PLAN BUT POWER DEMANDS SHALL NOT EXCEED THE SERVICE OR SUPPLY.

-  SINGLE POLE SWITCH
 THREE-WAY SWITCH
 DIMMER SWITCH
 LIGHT FIXTURE (FLUORESCENT)
 LIGHT FIXTURE INCANDESCENT (RECESSED)
 DOOR BUZZER
 THERMOSTAT
 SPECIAL PURPOSE OUTLET
 DUPLEX OUTLET
 DUPLEX OUTLET (CHILD RESISTANT/TAMPER PROOF TYPE)
 DUPLEX OUTLET GROUNDING PAINT
 BULB
 WIRING CABLE IN CONDUIT
 DISCONNECT SWITCH
 TELEVISION OUTLET
 JUNCTION BOX
 CIRCUIT BREAKER
 PANEL 305
 TELEPHONE PANEL

(301) 608-0988 OFFICE
(301) 608-0666 FAX
E-Mail: WJMAIDEN@AOL.COM
Web Site: 1stPage.COM/MAAE

LORRAINE WILSON
1324 Kenyon Street, NW
Washington, D. C. 200
(202) 462-5047

AT
1324 Kenyon Street,
Washington, D. C.
R4 LOT AF
842 3,707
2848

[illegible]

Revision Number	Revision Name
REVISION SCHEDULE	
Drawing Name:	

ELECTRICA	
(C) Copyright 2001	
This Drawing and Design in-whole or not be reproduced without written permission and Association.	
Contract Date 01/20/01	Designed by: _____
REV. 5/18/2001	Designed by: _____
	Autocad by: _____
	Checked by: _____
Architect's Project Number	Checked by: _____
	Checked by: _____
0950	Checked by: _____

BASEMENT FLOOR PLAN
SCALE 1/8" = 1'-0"


FIRST FLOOR PLAN
SCALE 1/8" = 1'-0"

SECOND FLOOR PLAN
SCALE 1/8" = 1'-0"


THIRD FLOOR PLAN
SCALE 1/8" = 1'-0"

PLUMBING SYMBOLS


- ⊗ CONNECTION POINT OF NEW LINES
- NEW DRAIN & WASTE LINE
- - - NEW VENT LINE
- ↗ NEW 45 DEGREE 'ELL'
- └ NEW 90 DEGREE 'ELL'

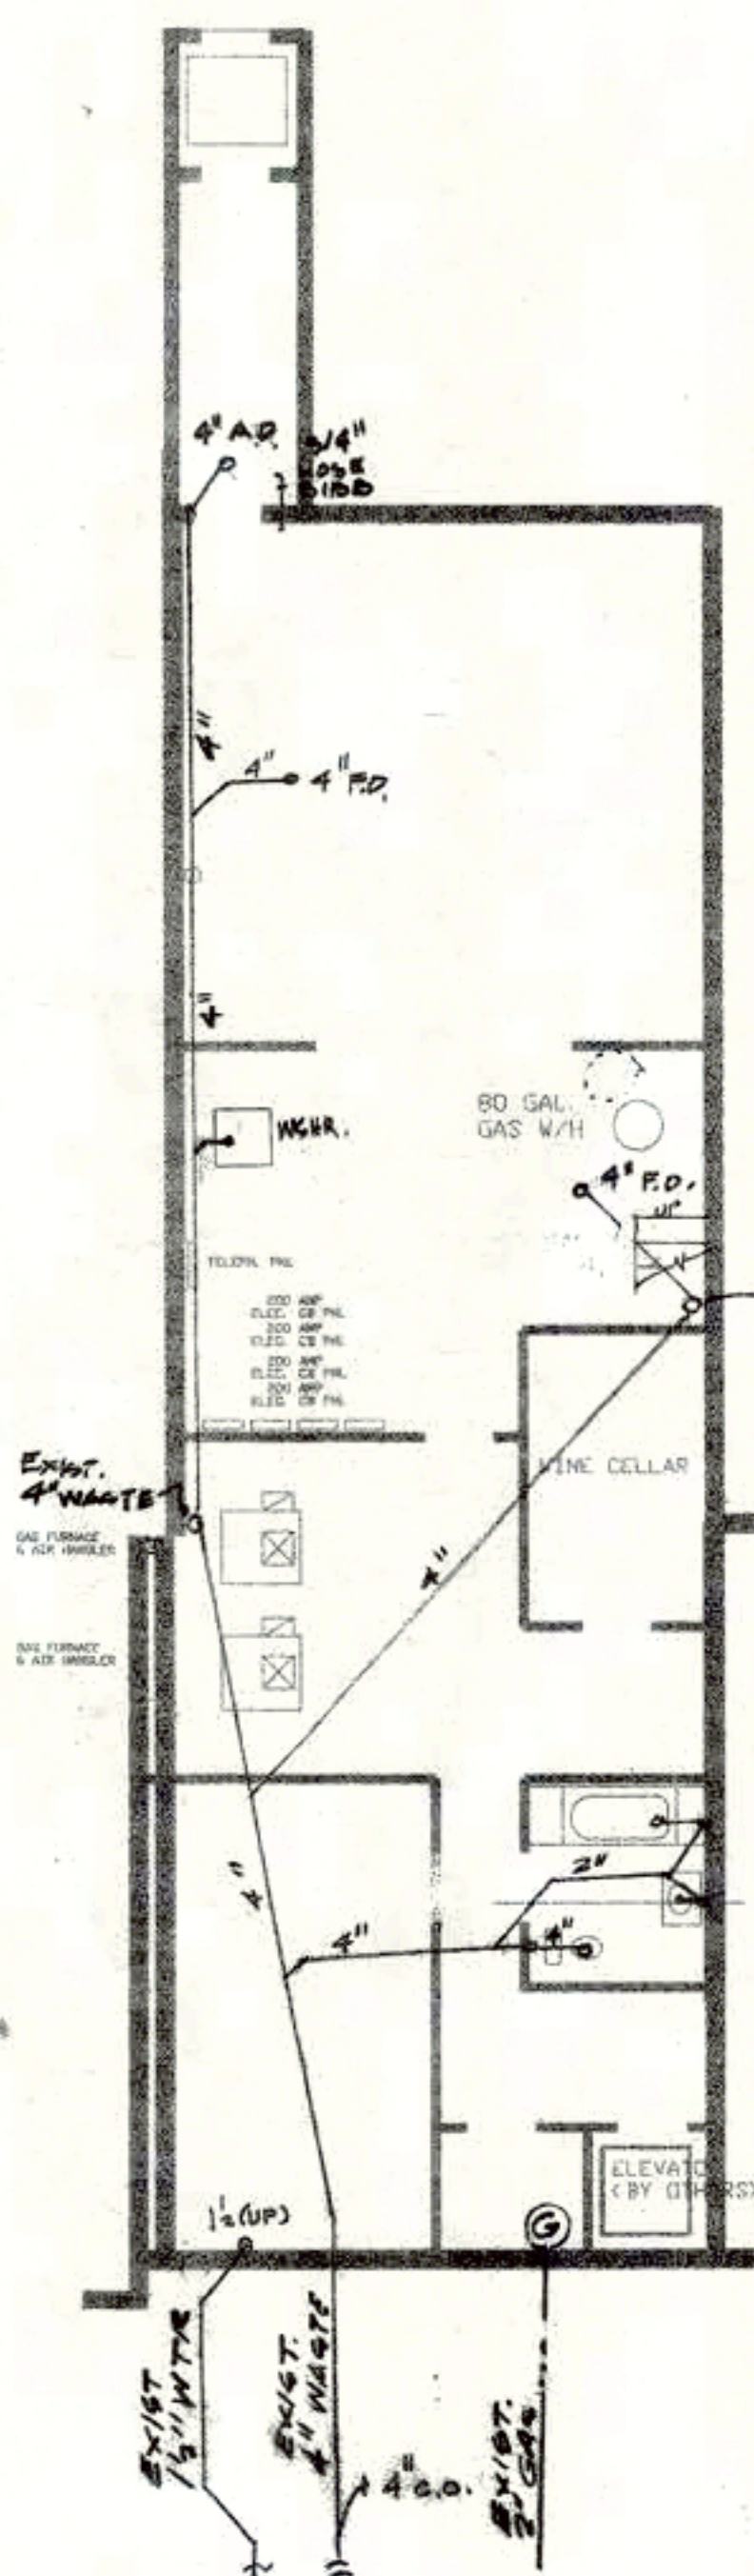


BASEMENT FLOOR PLAN
SCALE 1/8" = 1'-0"

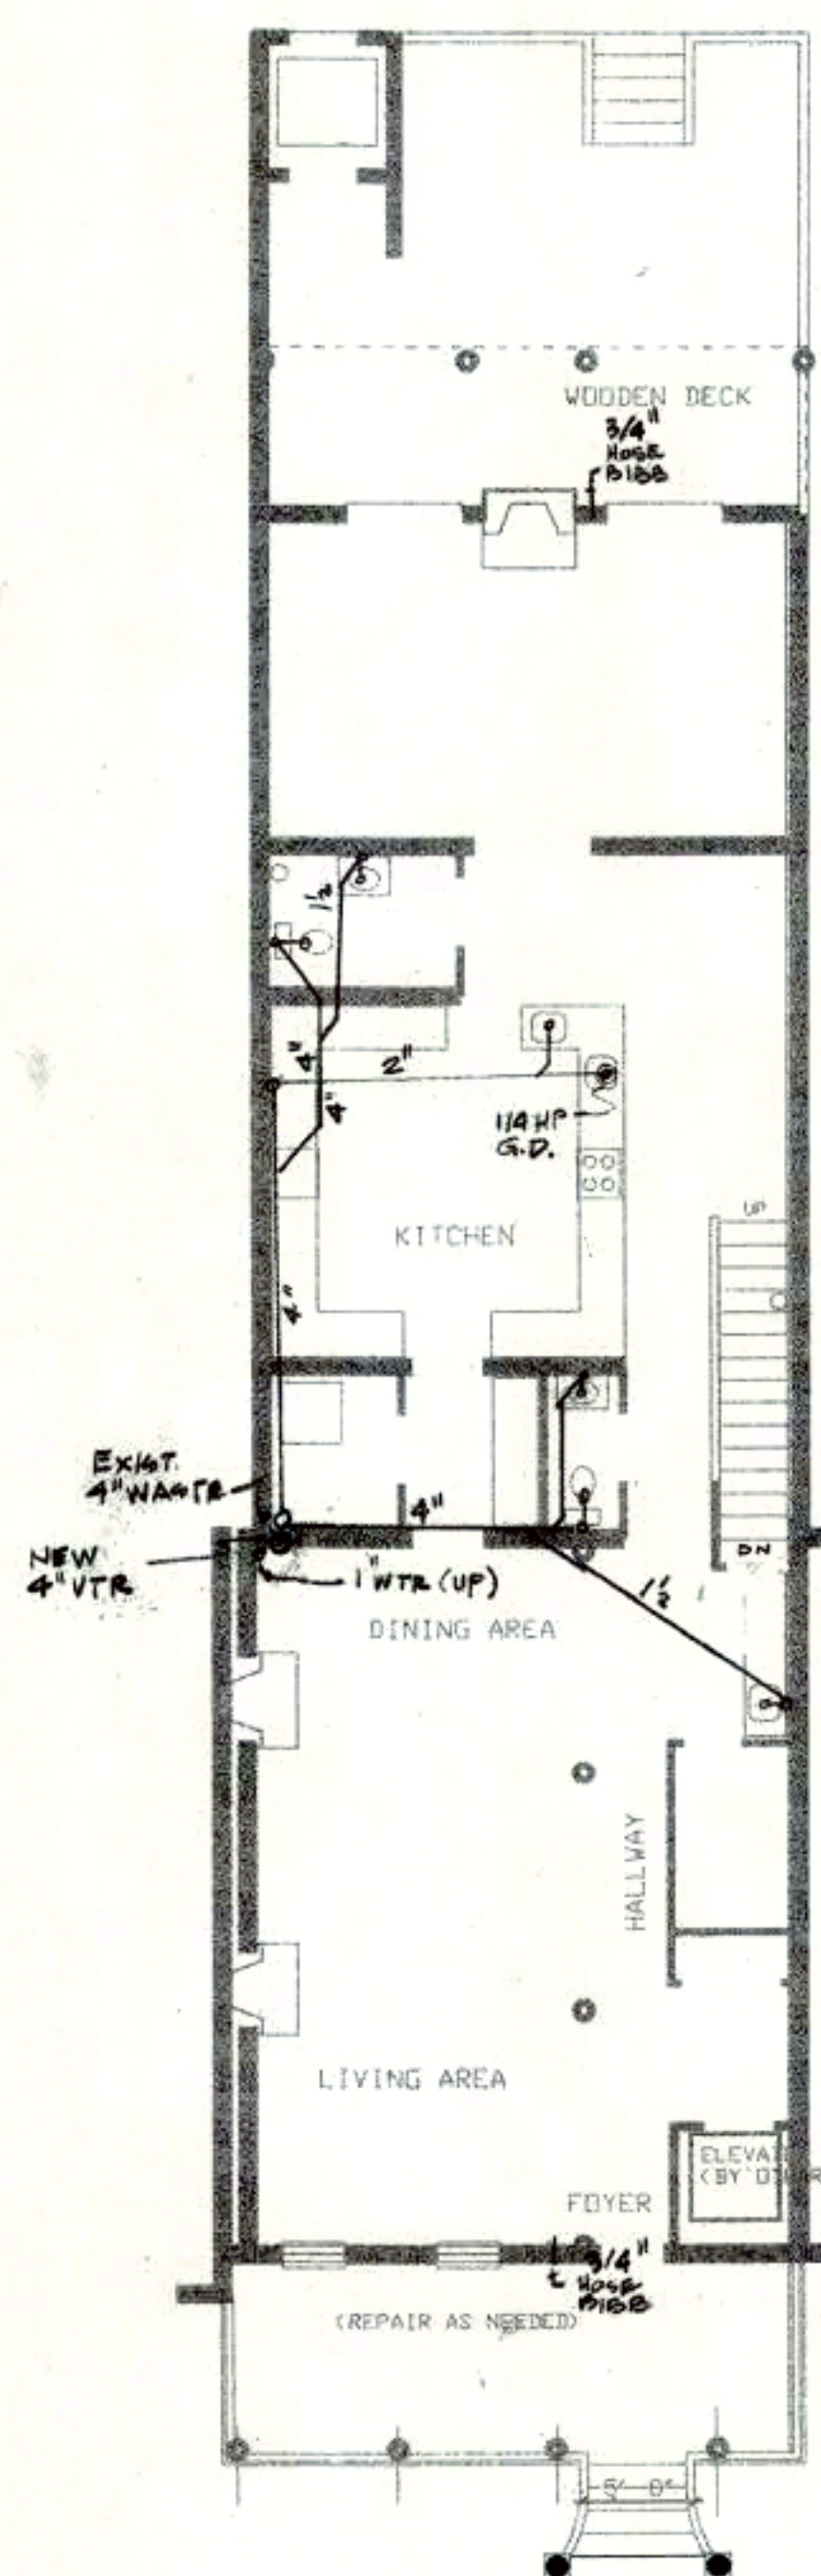


FIRST FLOOR PLAN
SCALE 1/8" = 1'-0"

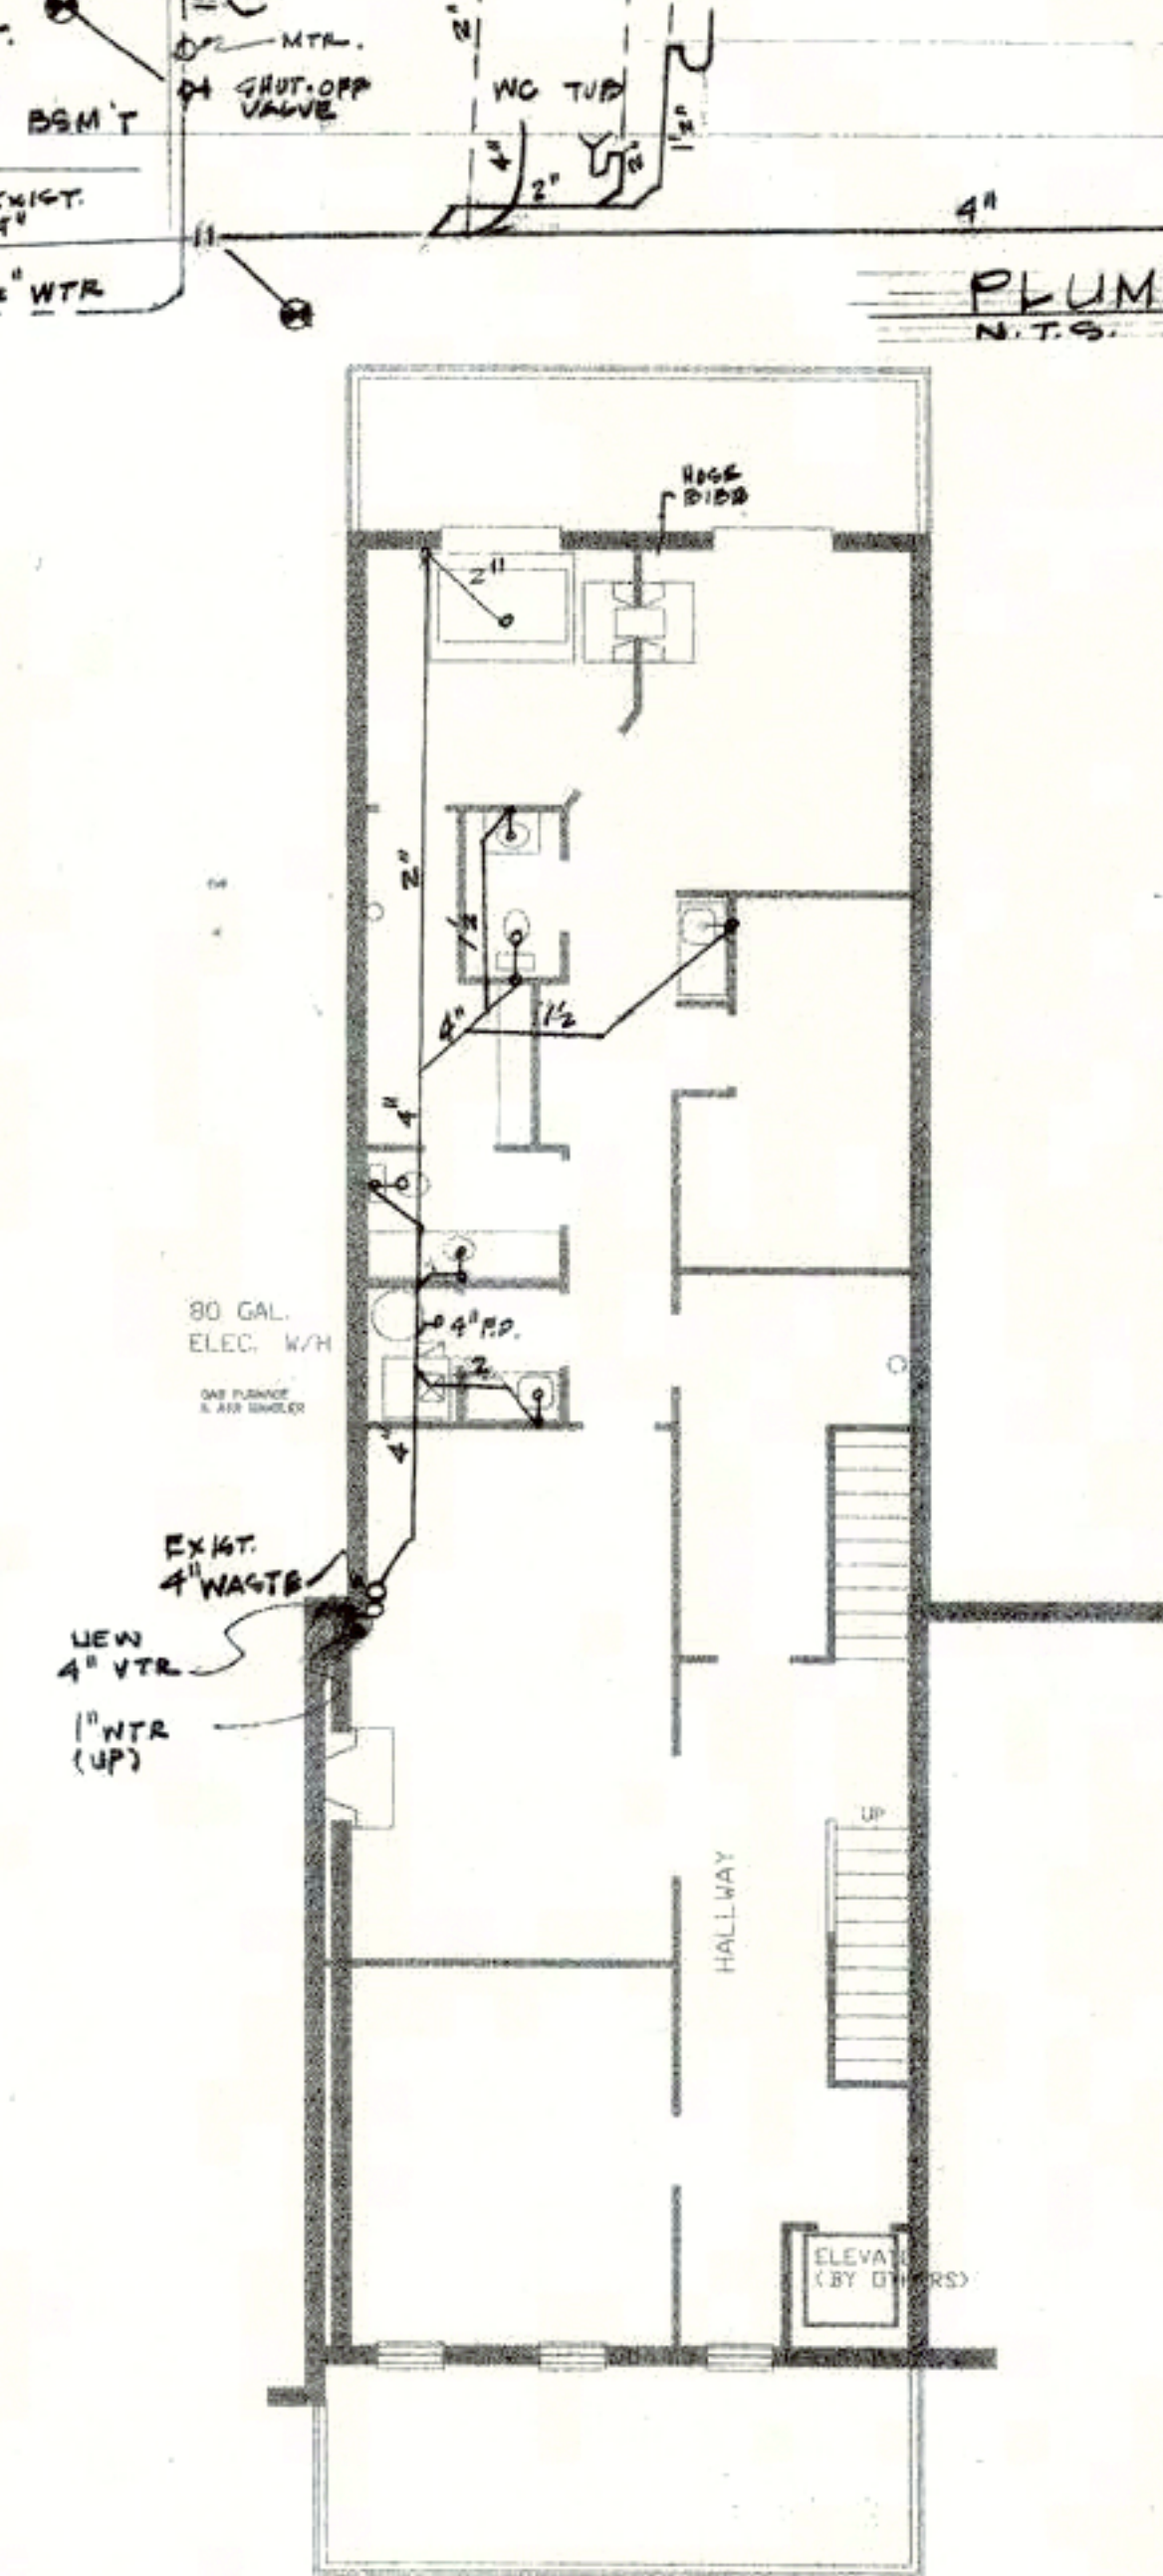

SECOND FLOOR PLAN
SCALE 1/8" = 1'-0"

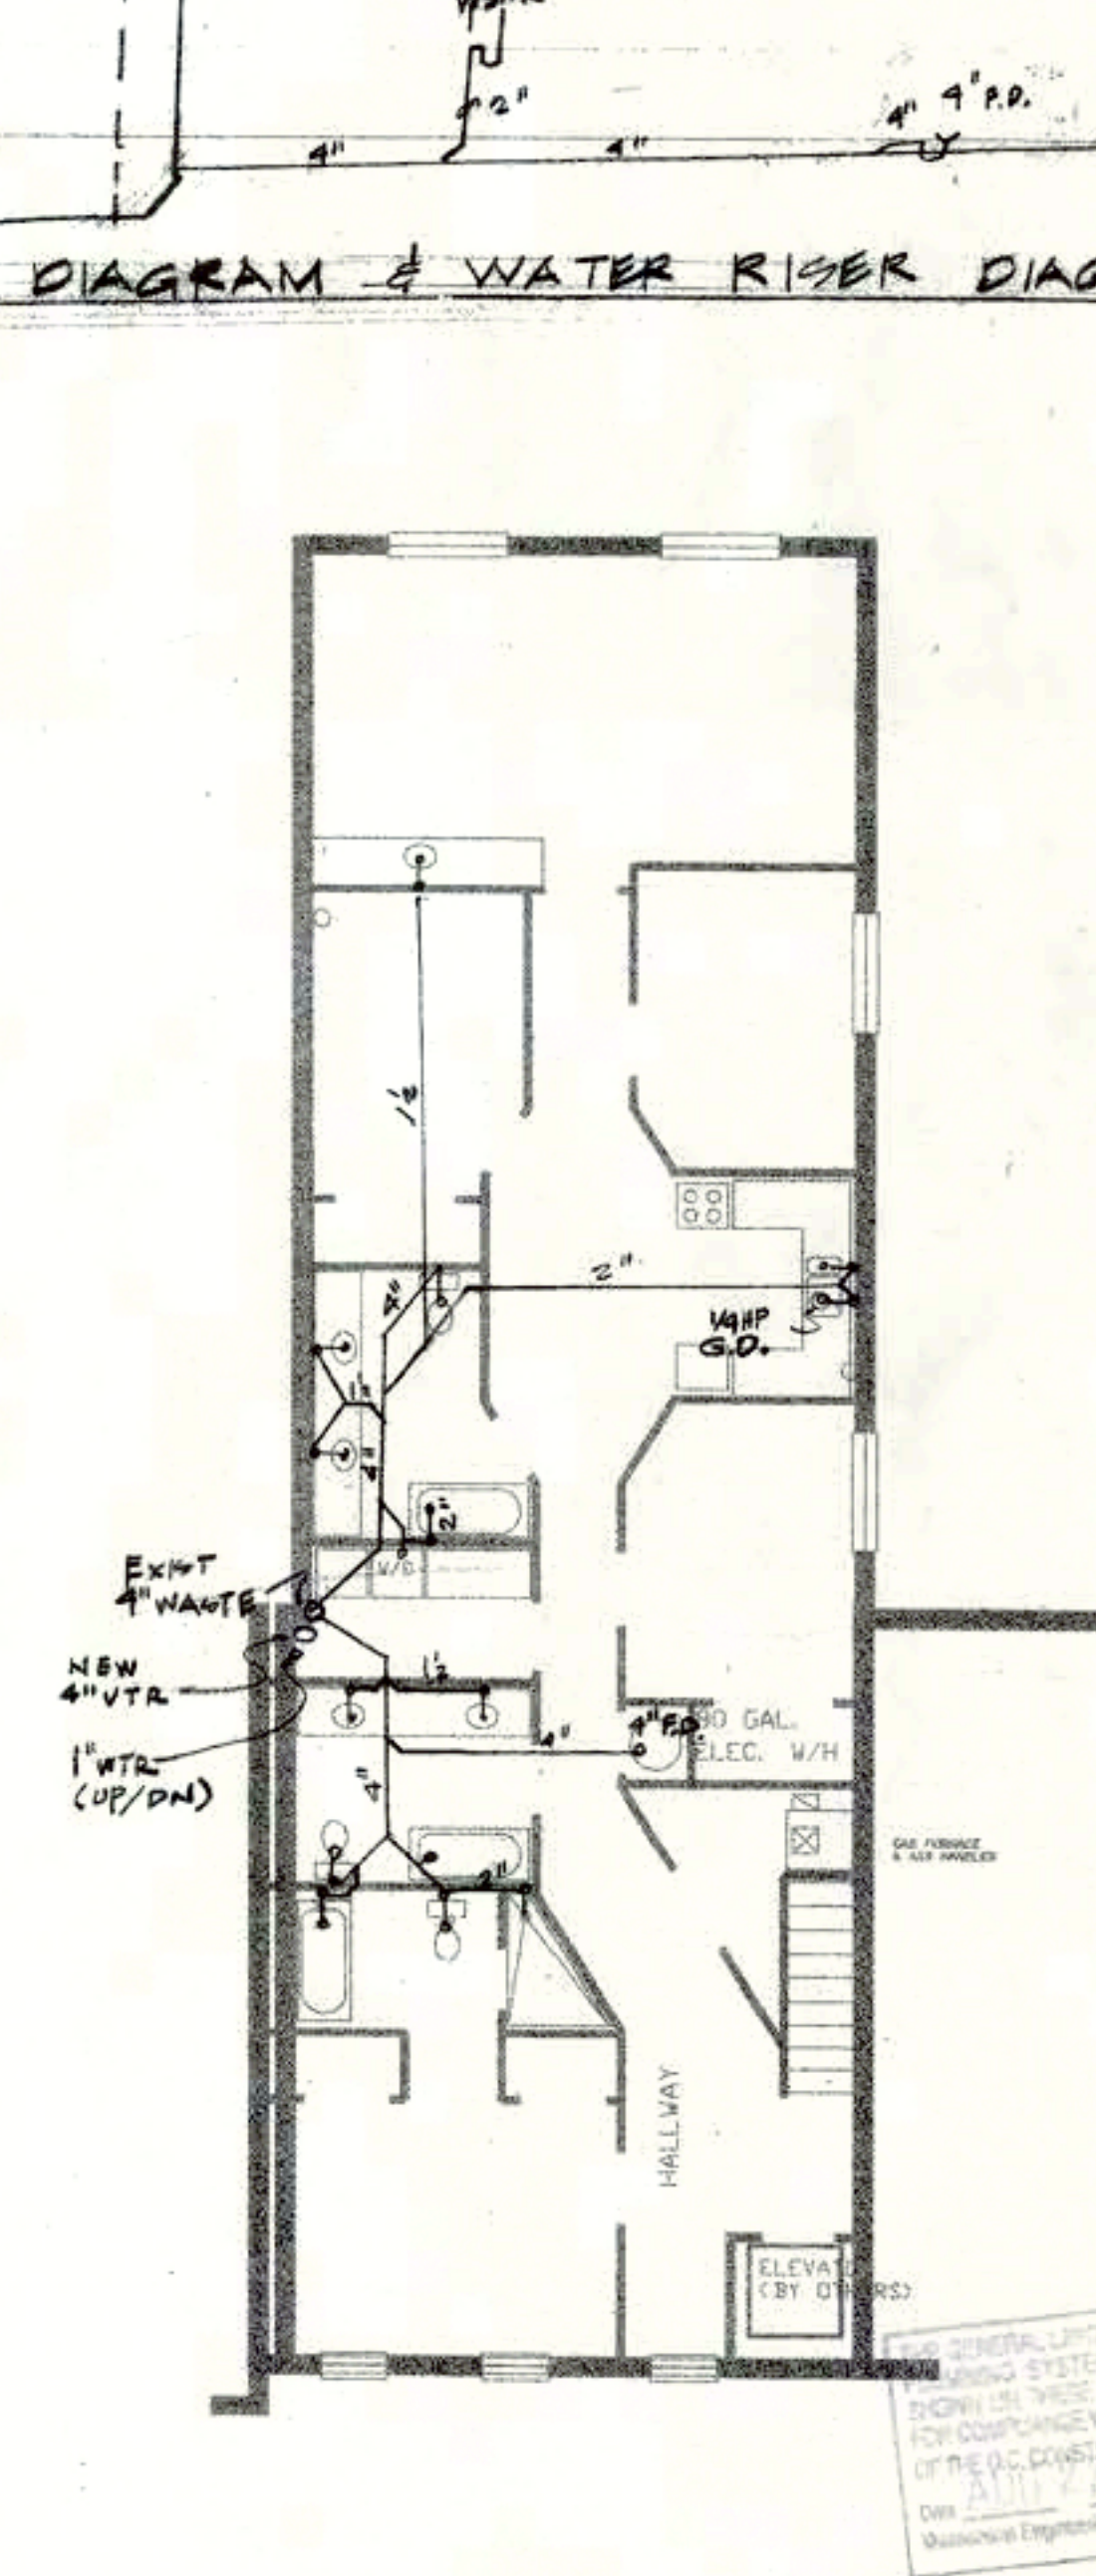


THIRD FLOOR PLAN
SCALE 1/8" = 1'-0"

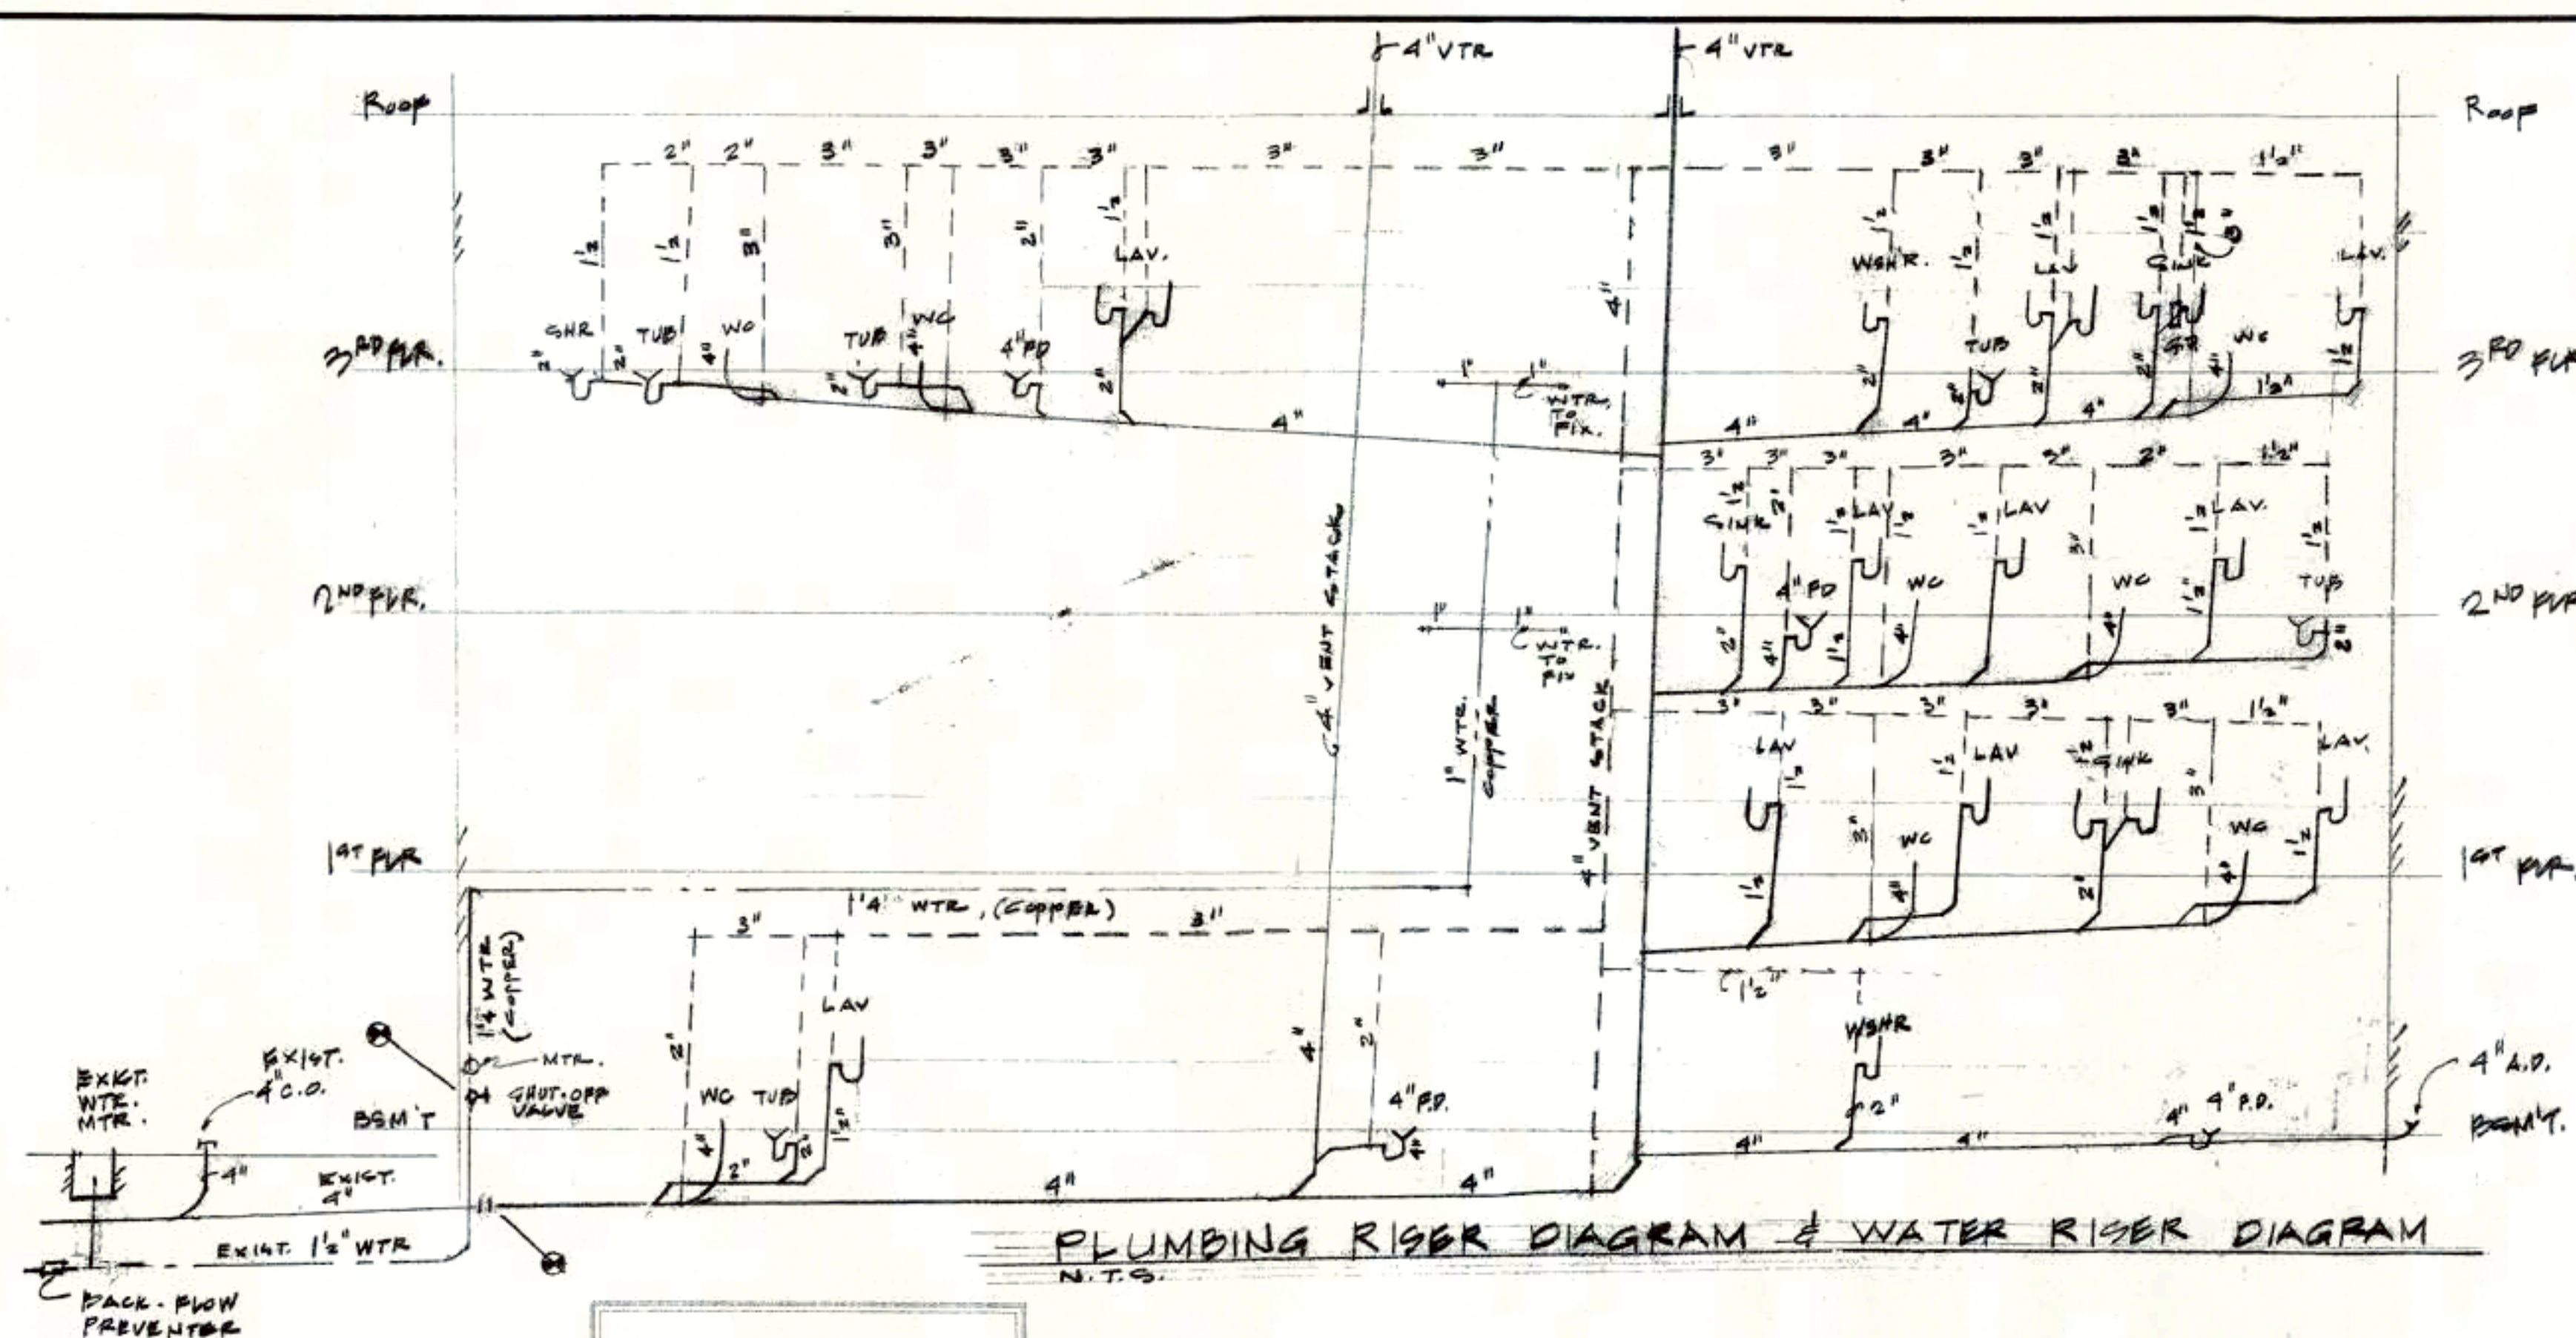

PLUMBING RISER DIAGRAM & WATER RISER DIAGRAM
N.T.S.

Architect:
WILLIE JAMES MAIDEN, AIA

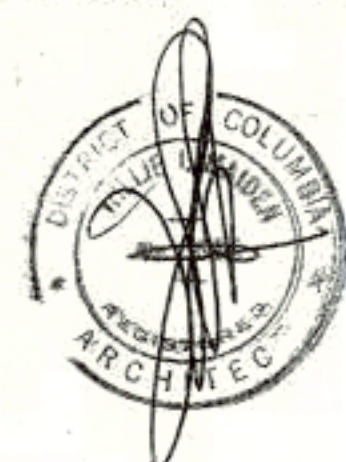

MAIDEN AND ASSOCIATES
Architects / Engineers / Planners

8030-B GEORGIA AVENUE
SILVER SPRING, MD 20910

(301) 608-0988 OFFICE
(301) 608-0666 FAX
E-Mail: WJMAIDEN@AOL.COM
Web Site: 1stPage.COM/MAAE

Owner's Name:

LORRAINE WILSON
1324 Kenyon Street, NW
Washington, D. C. 200
(202) 462-5047

Project Name:

ALTERATION & REPAIR
TO EXISTING BUILDING
FOR USE AS A
SINGLE-FAMILY HOUSE
(ROWHOUSE)

AT
1324 Kenyon Street, NW
Washington, D. C. 200

R4 LOT AREA:
842 3,707 S. F.
2848

Revision Number Revision Name Revision Date


REVISION SCHEDULE

Drawing Name

PLUMBING

© Copyright 2001
This Drawing and Design in whole or in part shall
not be reproduced without written permission from
Maiden and Associates.

Contract Date: 01/20/01
Designed by: [Signature]
REV. 5/18/2001
Autocad by: [Signature]
Checked by: [Signature]
Architect's Project Number: 0950
Drawing Sheet Number: 101
Sheet of 1

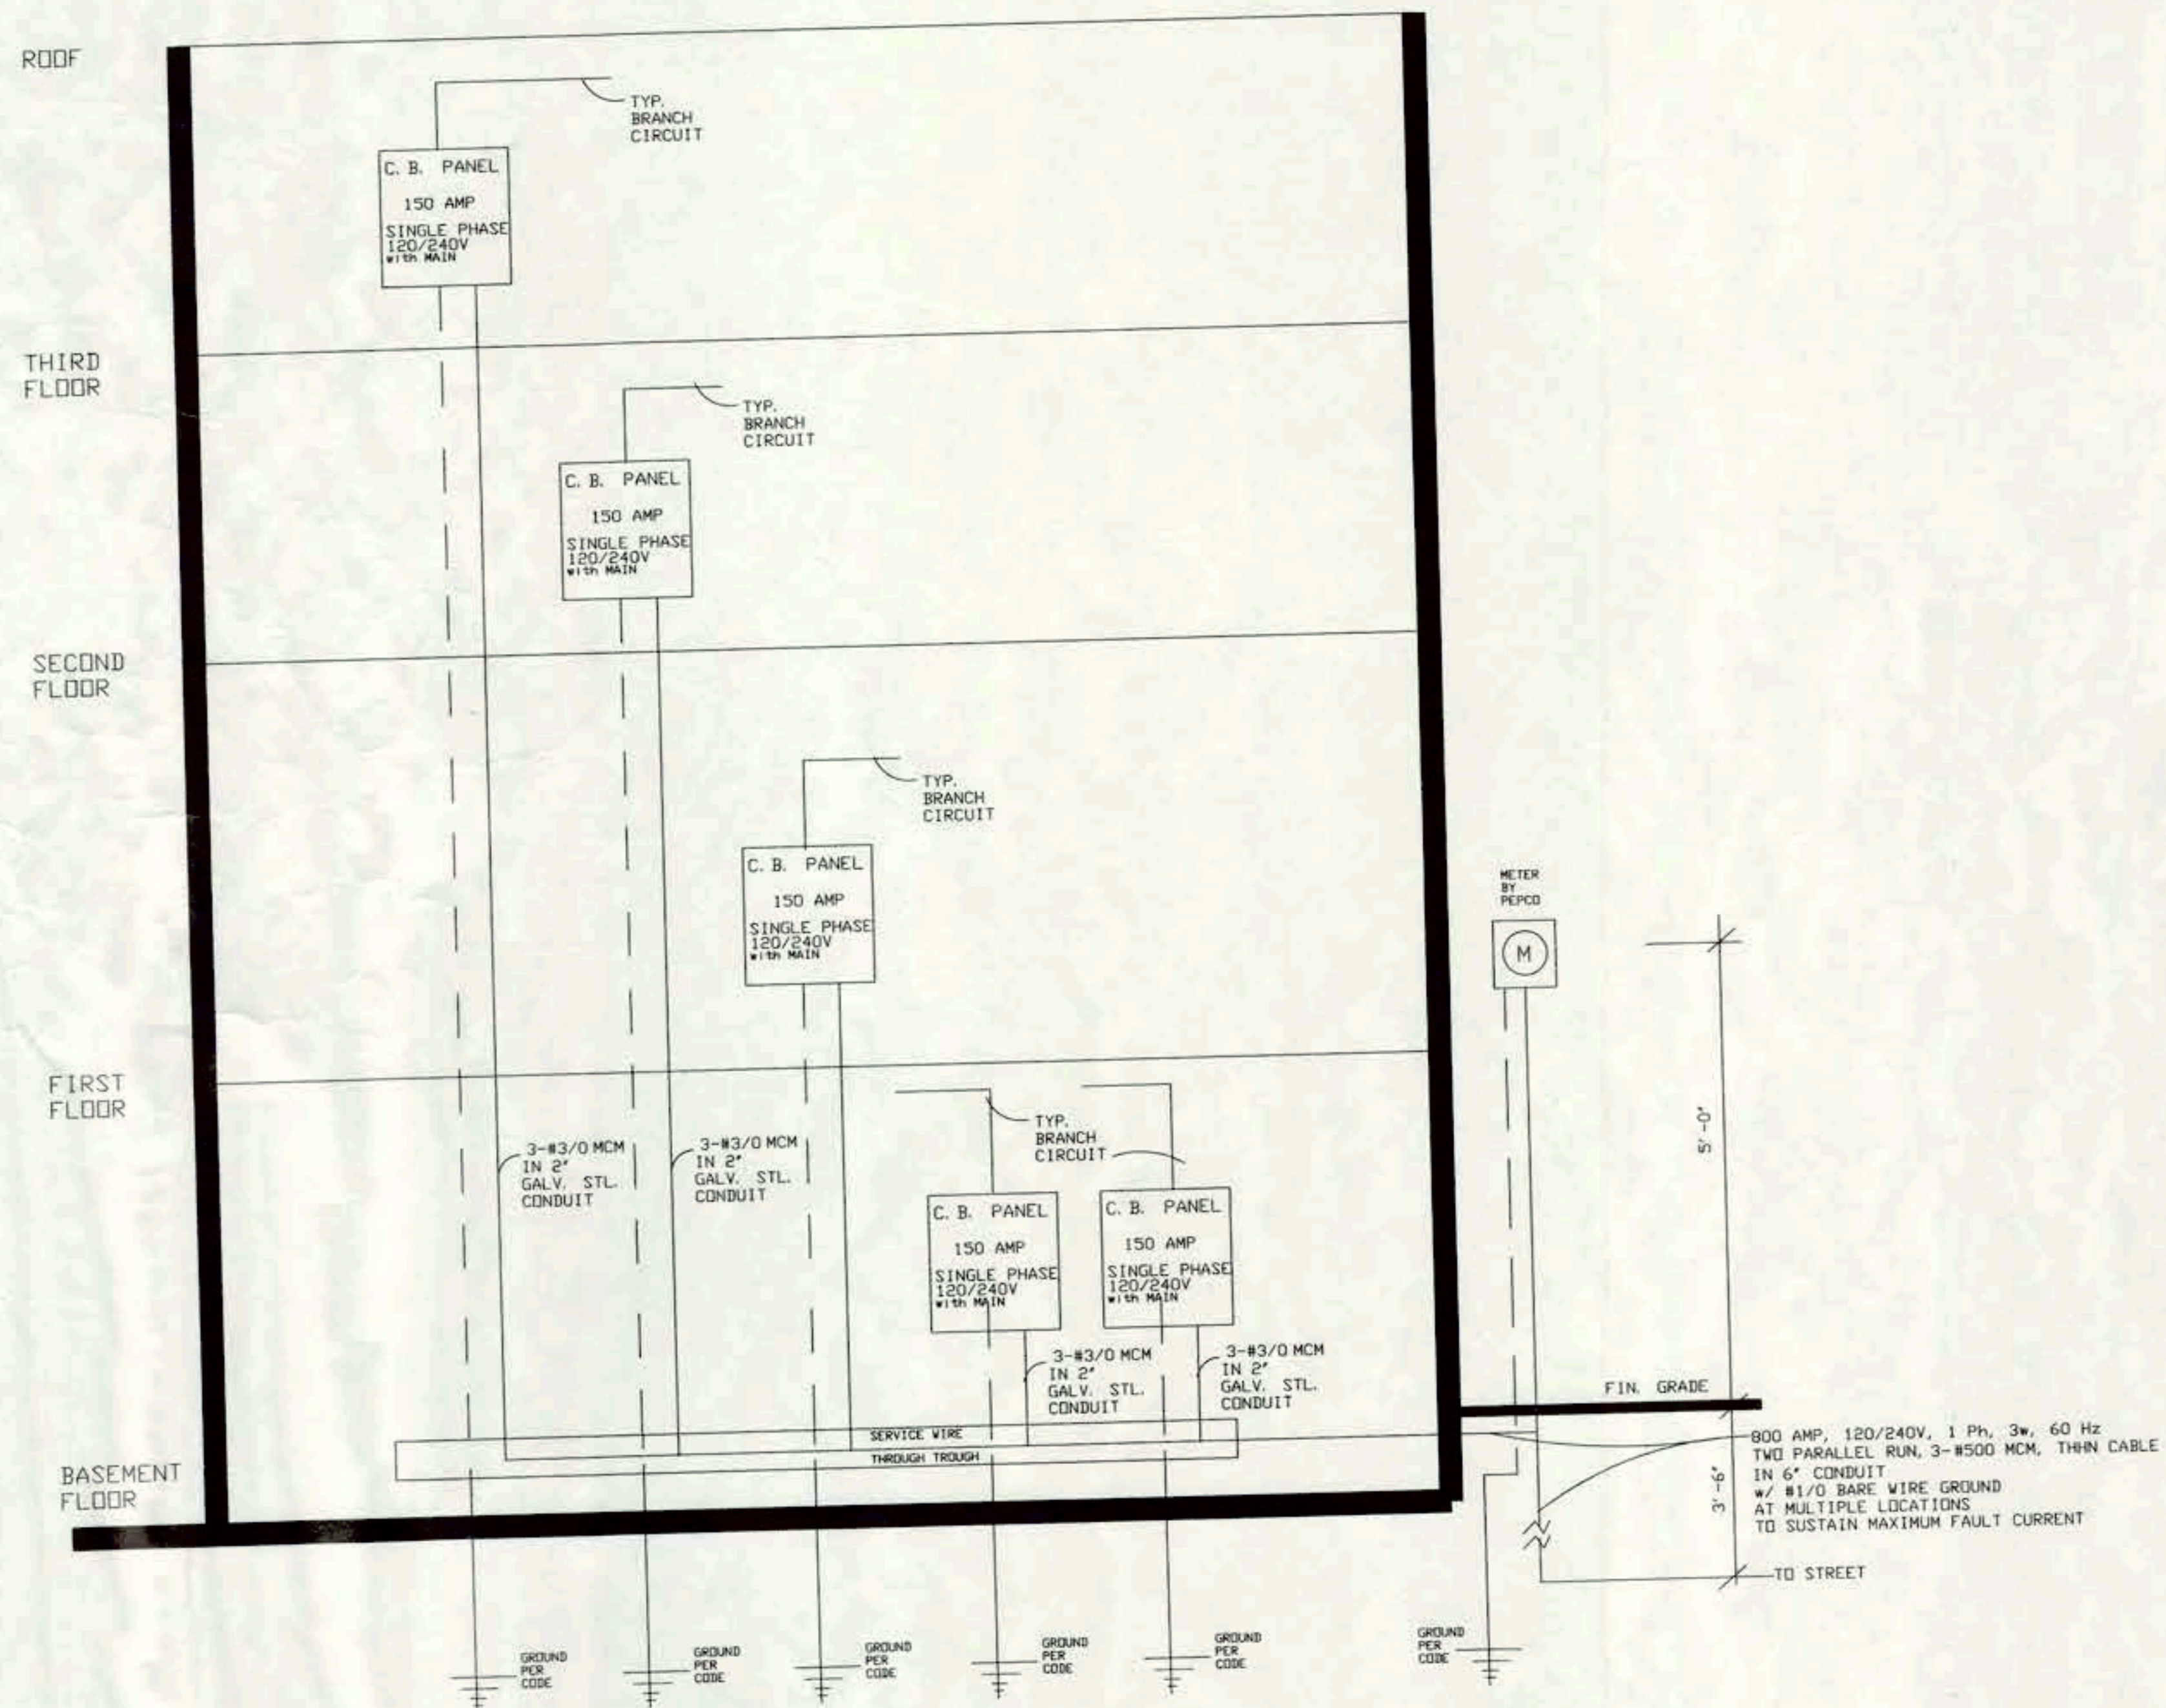

ELECTRICAL RISER DIAGRAM
N.T.S.

The undersigned certify that they are owners in fee simple of the property to be subdivided and are in peaceful occupation thereof; that there are no pending suits or actions that affect title to the property; that parties to any deeds of trust have hereon indicated their assent; and that there are no interests or claims affecting title to the property other than such deeds of trust. The undersigned hereby subdivides part of Lot 22 in "Columbian Heights, Blk 36", (Book Co. 17 Page 95) into one Lot and Square 2848 and requests that this subdivision be recorded in the Office of the Surveyor of the District of Columbia.

WITNESSES

OWNERS

LORRAINE B. WILSON

Subscribed and sworn before me this _____ day of _____ 2001

Notary Public

My Commission Expires

NUMBER OF TRUSTS: _____

ASSENT BY TRUSTEES:

SURVEYOR'S OFFICE, D.C.

Made by: LORRAINE WILSON

Drawn by: L.E.S. Checked by: FS

Record and computations by: F. SLEEM

Recorded at: _____

Recorded in Book _____ Page _____ S.O. 02202

Scale: 1 inch = 20 feet

File No. 01-406

OFFICE OF TAX AND REVENUE

_____, 2001

I certify that the following statements relating to this subdivision are correct.

1 Ownership agrees with our records: _____

2 Real estate taxes are paid to: _____

3 There are no unpaid assessments: _____

Chief Assessor, Assessment Division

I acknowledge for the owners that this is not a tax certificate as intended by D.C. Code Section 47-405.

DEPARTMENT OF CONSUMER AND REGULATORY AFFAIRS

_____, 2001

I certify that this subdivision complies with all applicable provisions of DCMR11, Zoning Regulation of the District of Columbia.

Zoning District: _____

Zoning Administrator

_____, 2001

HISTORIC PRESERVATION

OFFICE OF THE SURVEYOR

_____, 2001

I certify that this plat is correct and is hereby recorded.

Surveyor, D.C.

SUBDIVISION
SQUARE 2848

KENYON STREET, N.W.

