


Landscape



October 27, 2016

NOTE: PUBLIC SPACE WILL BE CONSTRUCTED TO DDOT STANDARDS CONSISTENT WITH UNION MARKET STREETScape GUIDELINES. FINAL PUBLIC SPACE DESIGN WILL BE DETERMINED DURING THE PUBLIC SPACE PERMITTING PROCESS.

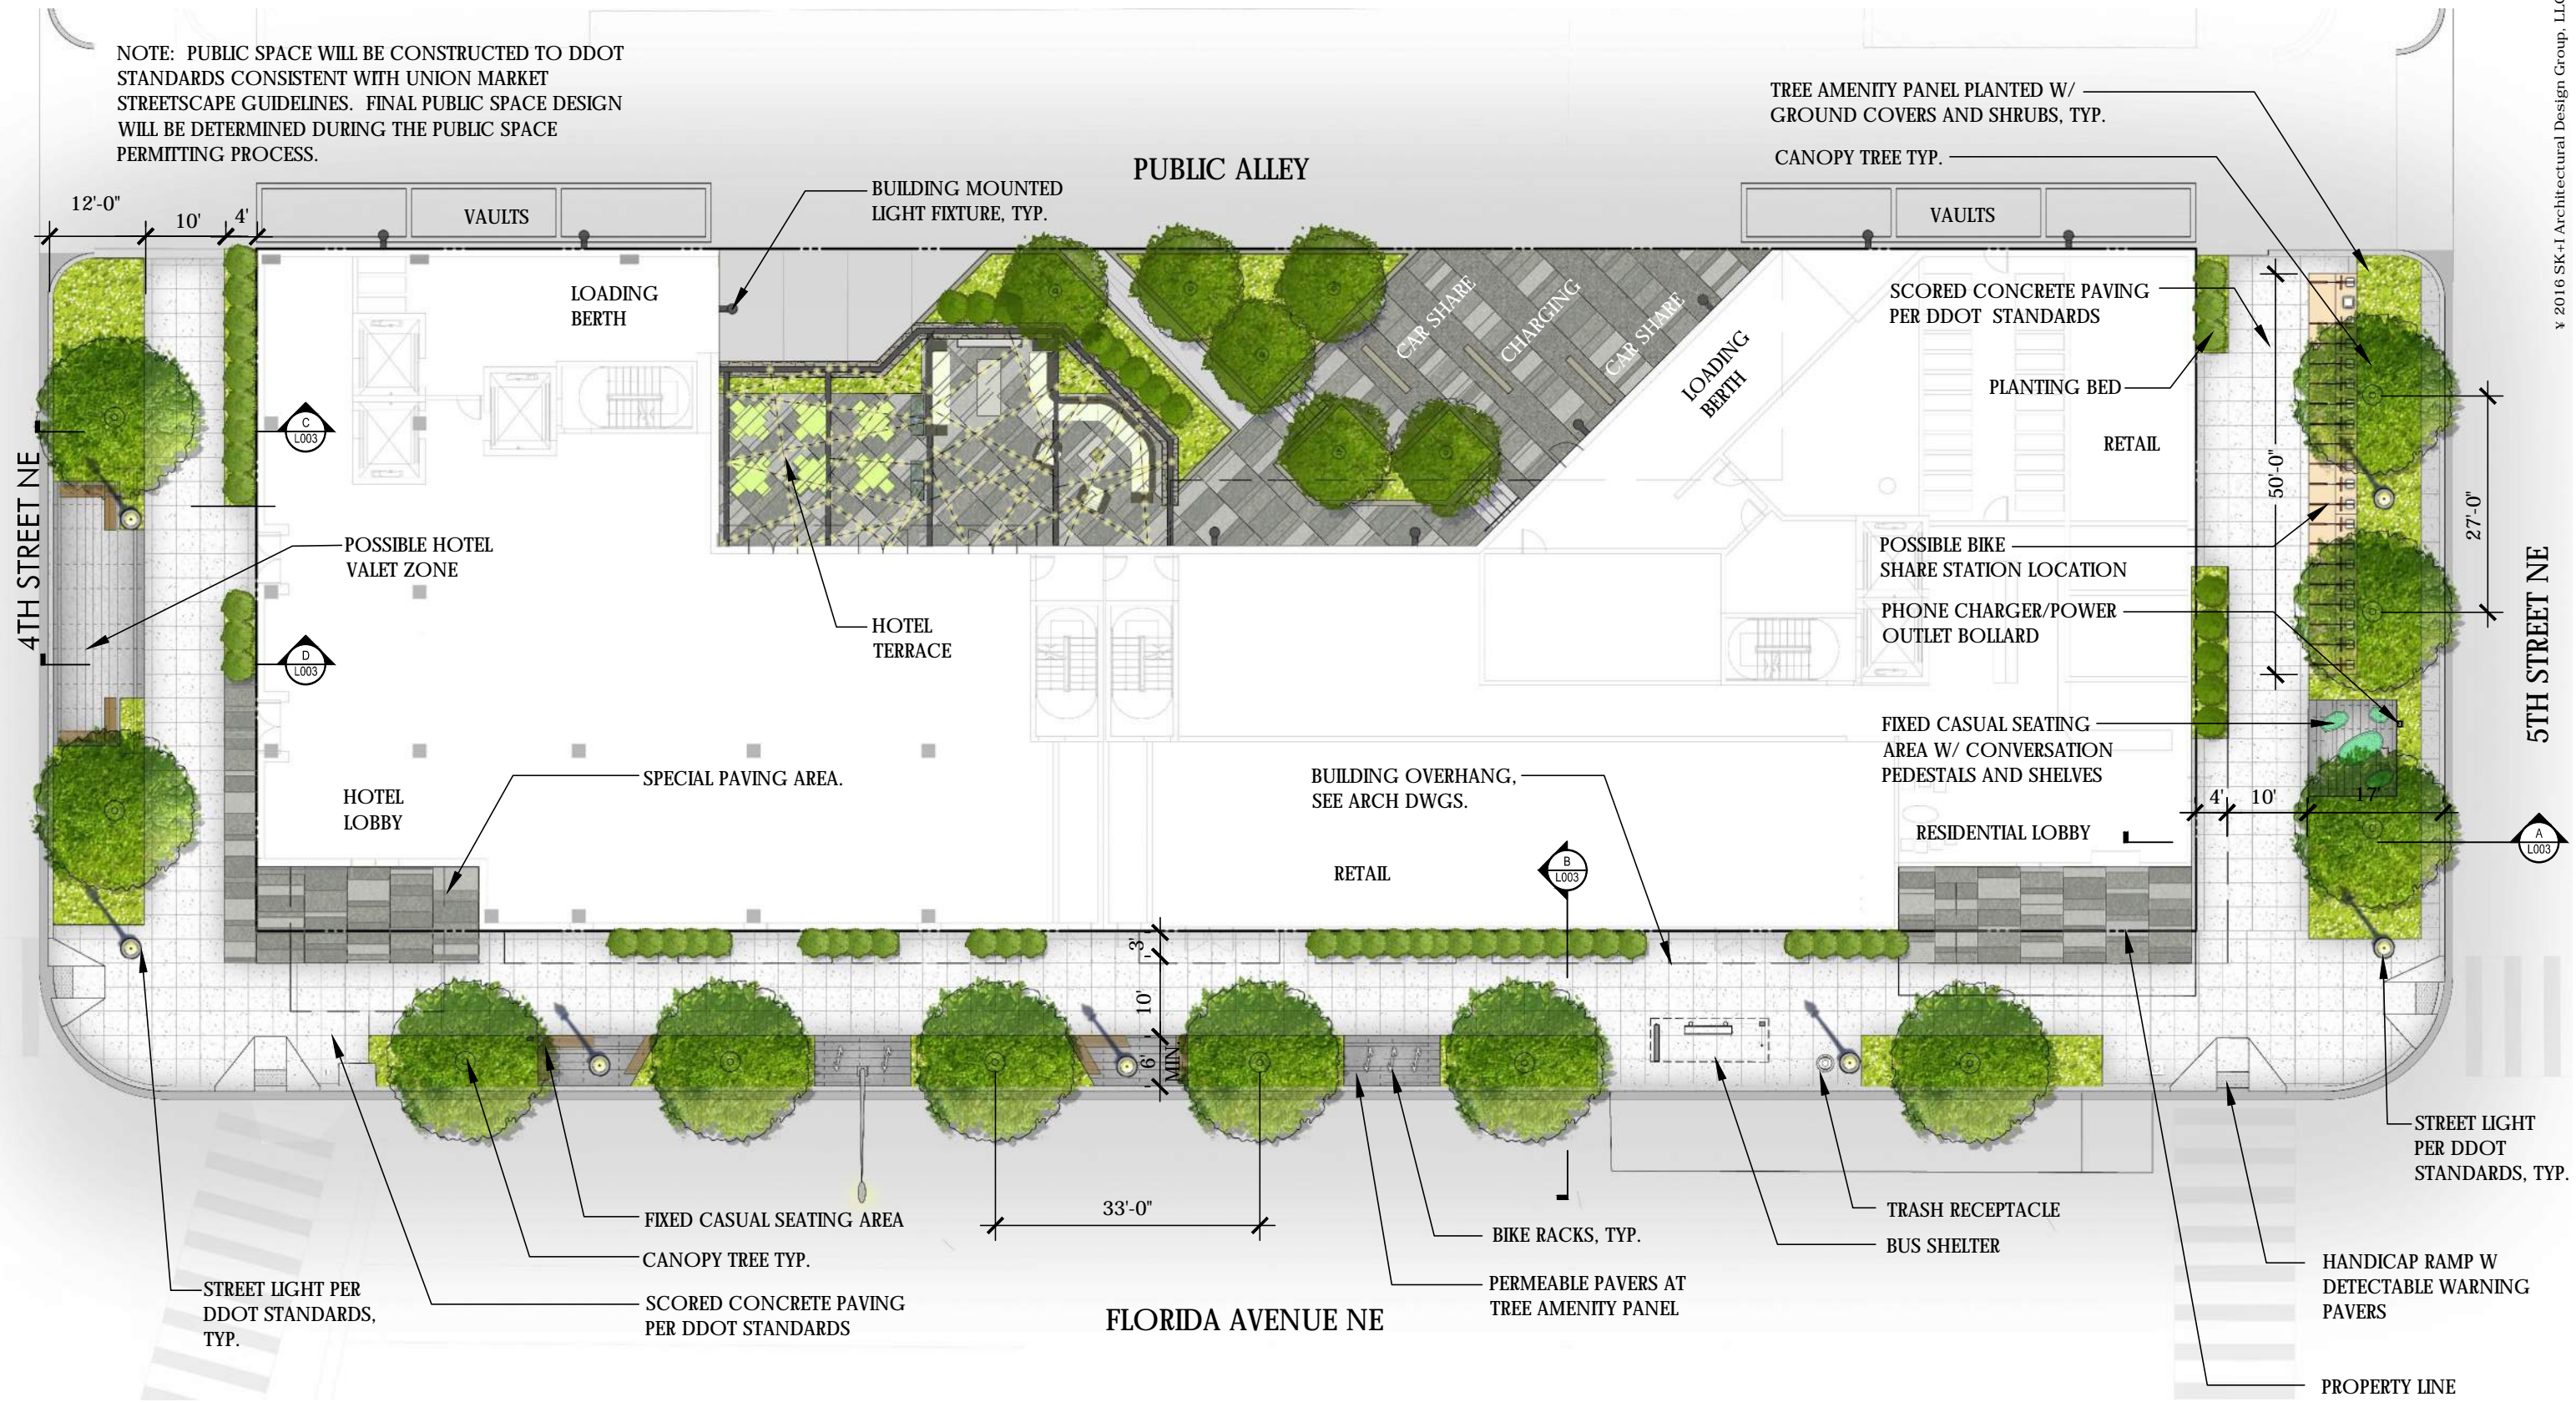



400 Florida Avenue | Washington DC

PUD SET
OCT 25, 2016 | L001



 Ground Level Landscape Plan



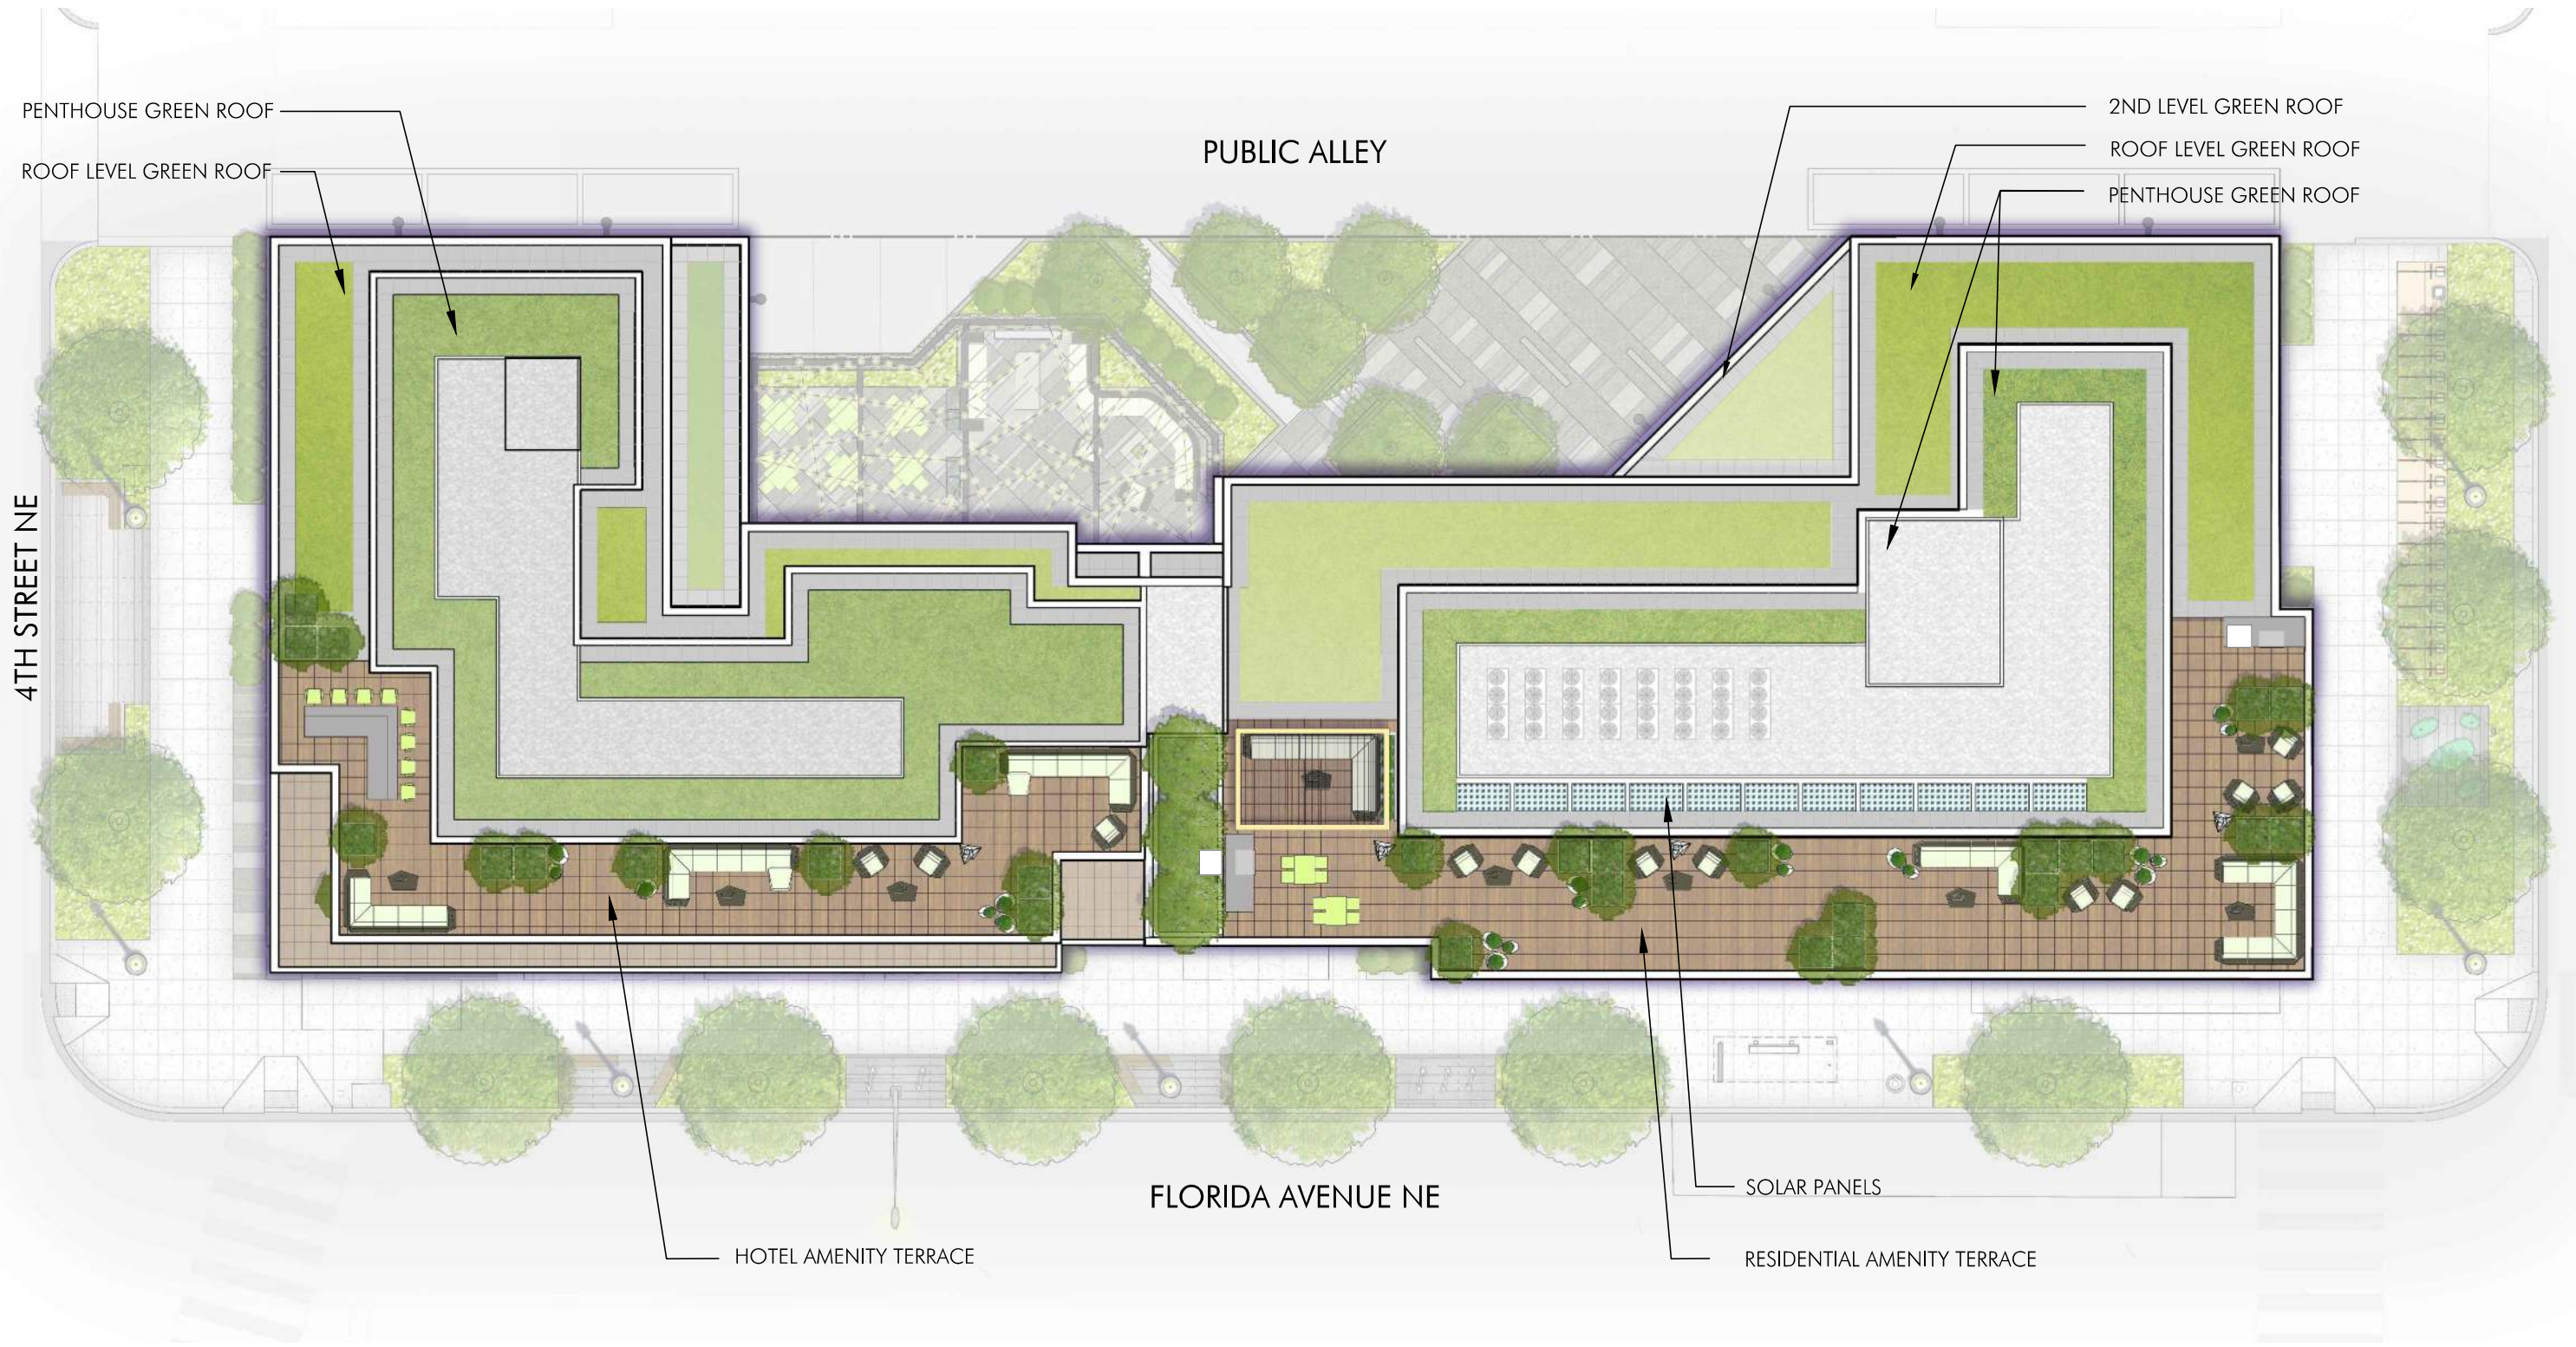



400 Florida Avenue | Washington DC

PUD SET
OCT 25, 2016 | L002



 Roof Level Landscape Plan



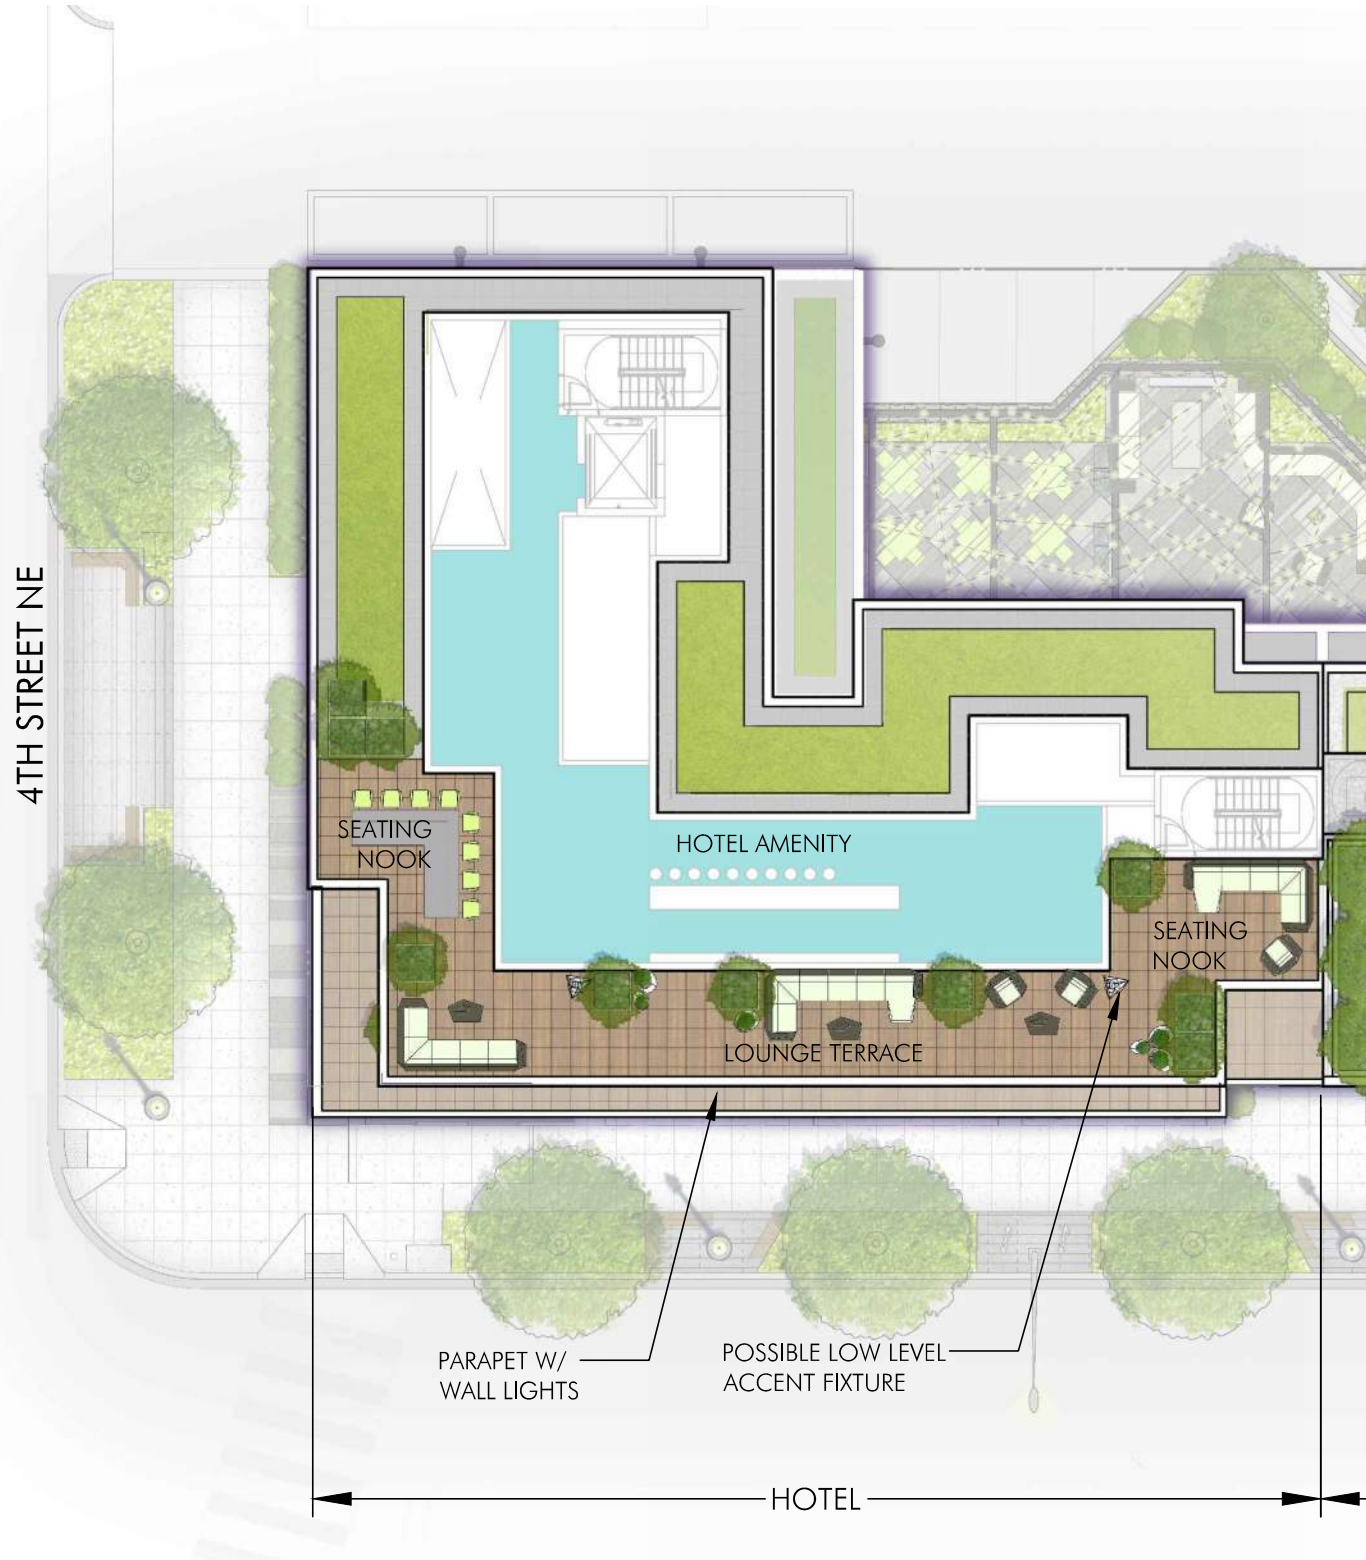

HOTEL ROOFTOP LIGHTING

- MOOD - INTIMATE AND AMBIENT
- USES LOW LEVEL LIGHTING FIXTURES
- PROVIDES SAFE PASSAGE ACCESSIBILITY FOR PATRONS AND GUESTS



POSSIBLE WALL LIGHTS



POSSIBLE ACCENT FIXTURE



SMALL ACCENT LAMPS



POSSIBLE ACCENT FIXTURE



PUD SET




400 Florida Avenue | Washington DC

NOV 11, 2016 | L02B



Hotel Roof Level Lighting Precedence



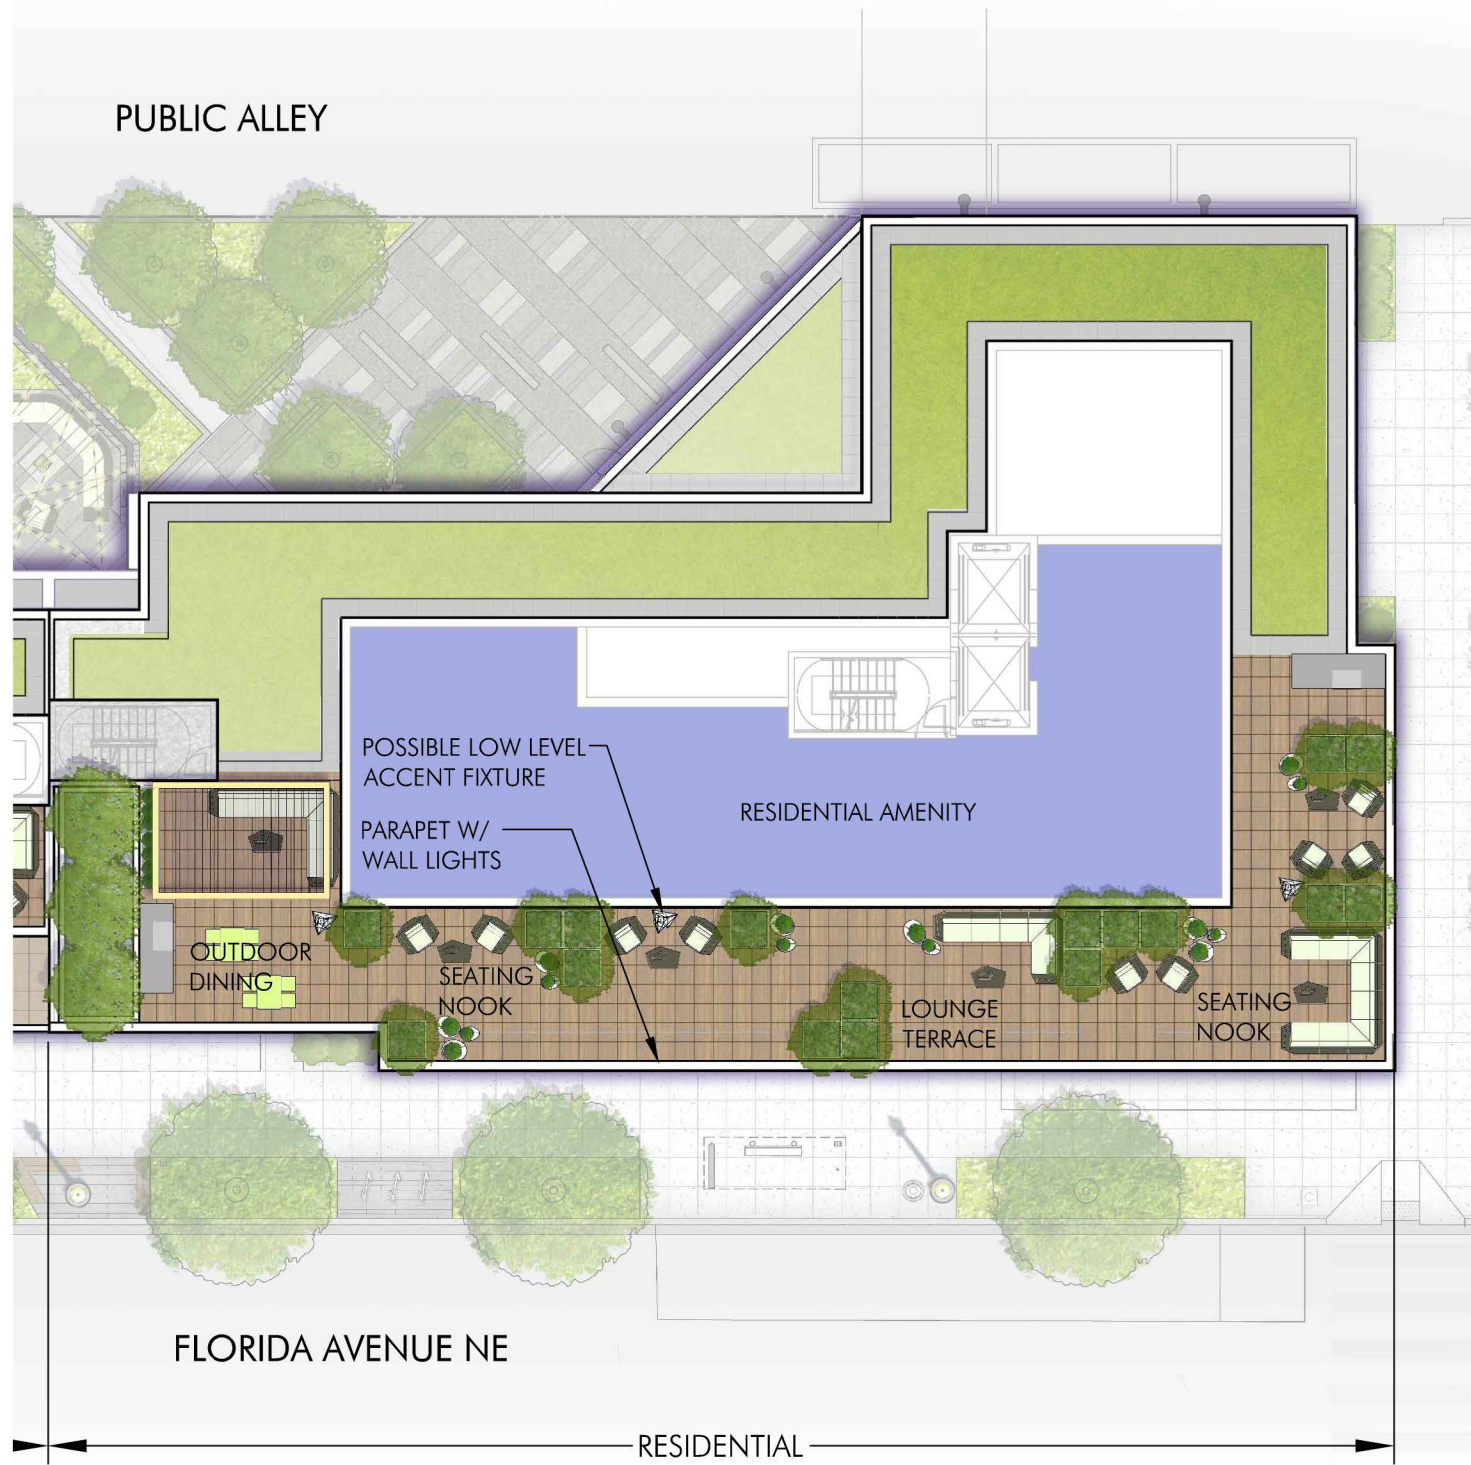

RESIDENTIAL ROOFTOP LIGHTING

- MOOD - INTIMATE AND AMBIENT
- USES LOW LEVEL LIGHTING FIXTURES
- PROVIDES SAFE PASSAGE ACCESSIBILITY FOR RESIDENTS AND GUESTS



POSSIBLE WALL LIGHTS



POSSIBLE ACCENT FIXTURE



SMALL ACCENT LAMPS



SMALL ACCENT LAMPS



POSSIBLE ACCENT FIXTURE



PUD SET

NOV 11, 2016 | L02C




400 Florida Avenue

Washington DC

Residential Roof Level Conceptual Lighting



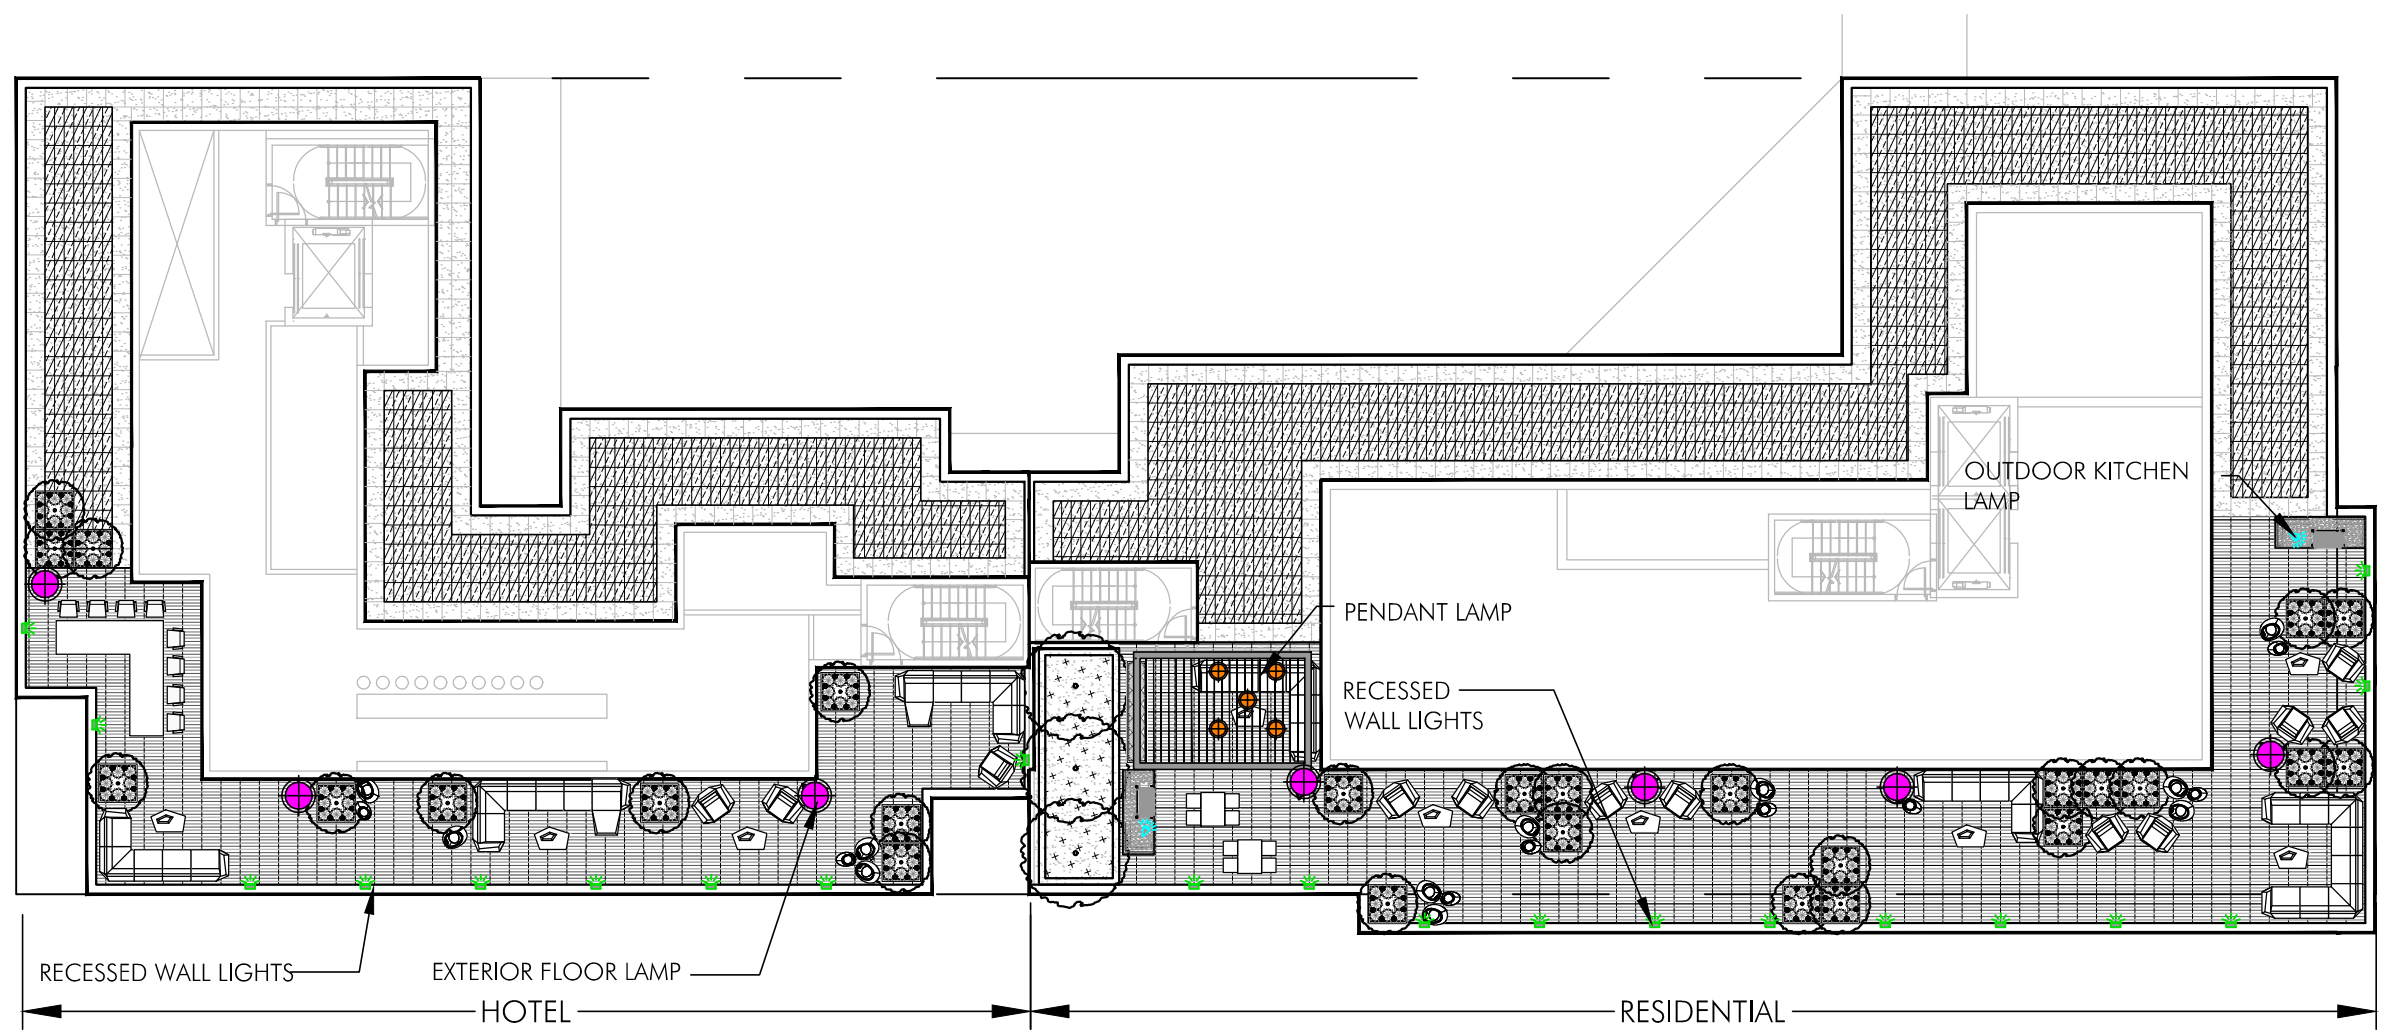

RECESSED WALL LIGHTS



EXTERIOR FLOOR LAMP - ALT A



EXTERIOR FLOOR LAMP - ALT B



OUTDOOR KITCHEN LAMP



PENDANT LAMP




400 Florida Avenue | Washington DC


PUD SET

NOV 11, 2016 | L02D




 Roof Level Conceptual Lighting Plan




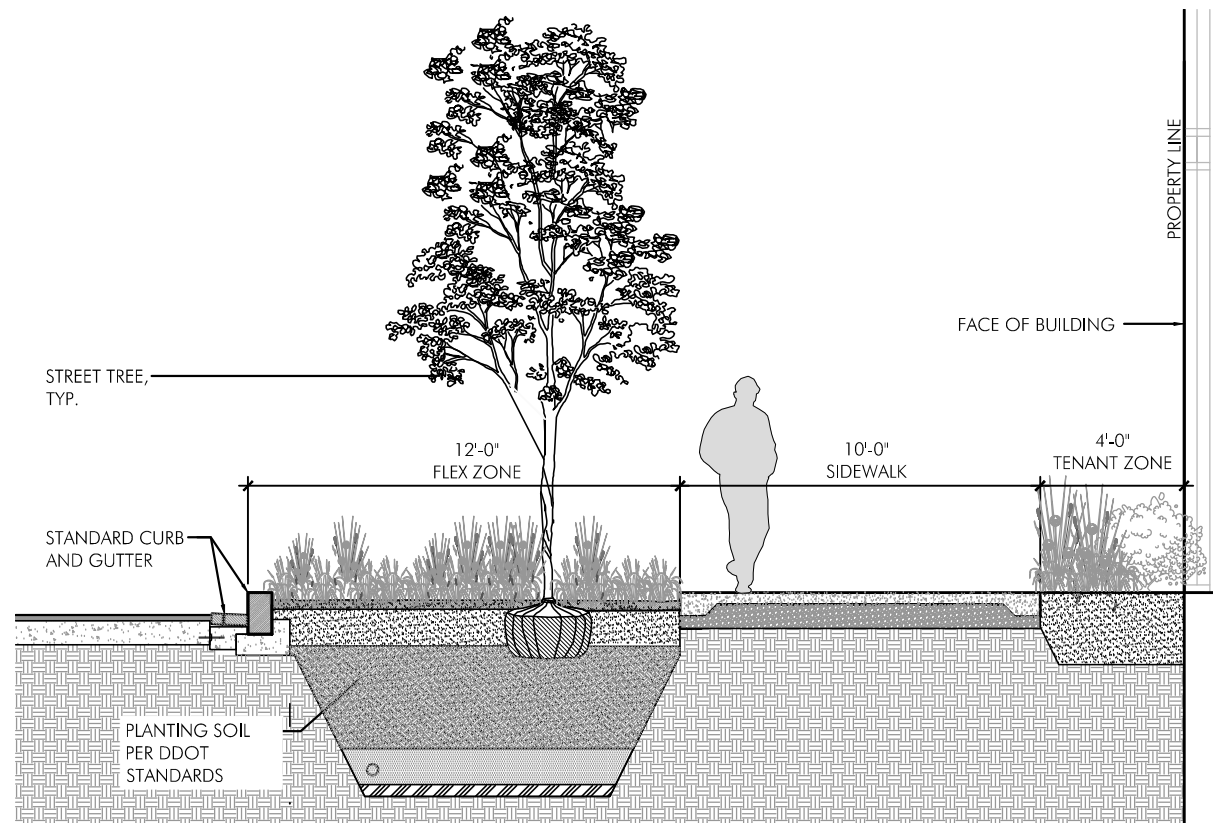


A. 4TH STREET - STREET TREE PIT - SECTION
SCALE: 3/16" = 1'-0"

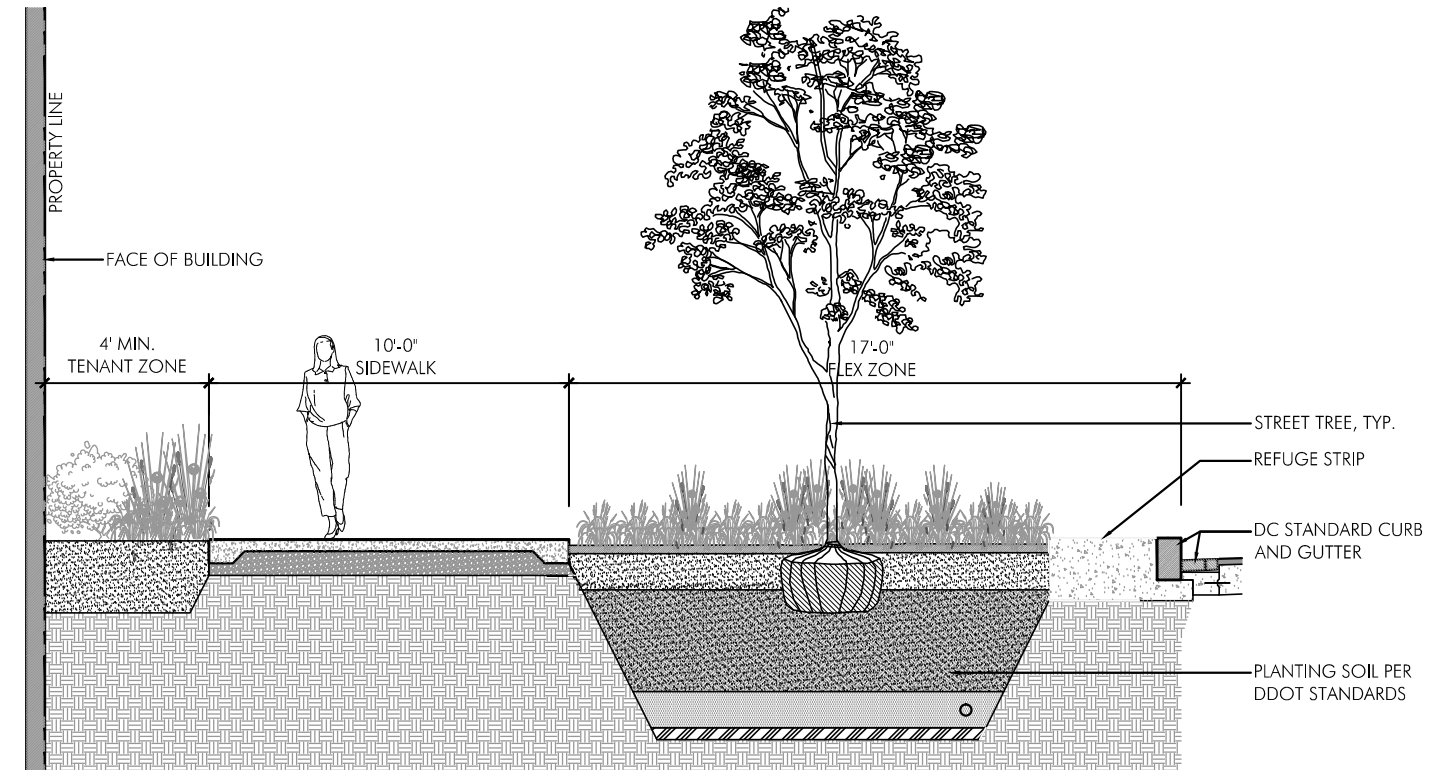

C. 5TH STREET - STREET TREE PIT - SECTION
SCALE: 3/16" = 1'-0"

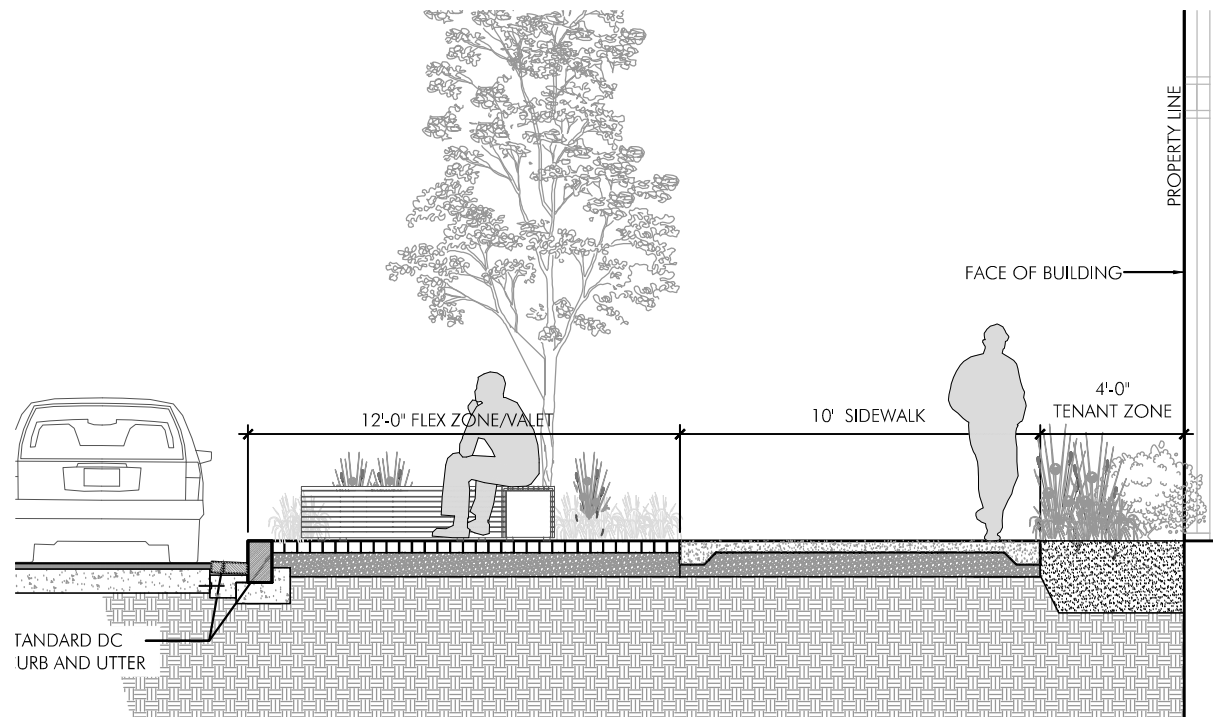


B. 4TH STREET - LAY-BY/DROP-OFF STREET SECTIONS
SCALE: 3/16" = 1'-0"

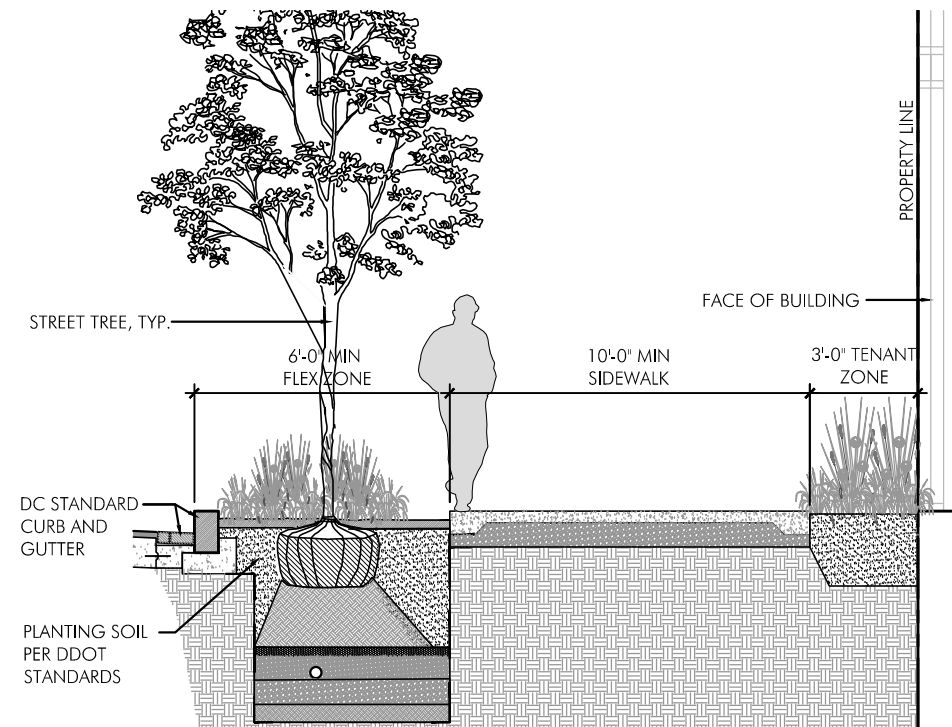

D. FLORIDA AVENUE - STREET TREE PIT - SECTIONS
SCALE: 3/16" = 1'-0"

NOTE: PUBLIC SPACE WILL BE CONSTRUCTED TO DDOT STANDARDS CONSISTENT WITH UNION MARKET STREETScape GUIDELINES. FINAL PUBLIC SPACE DESIGN WILL BE DETERMINED DURING THE PUBLIC SPACE PERMITTING PROCESS.

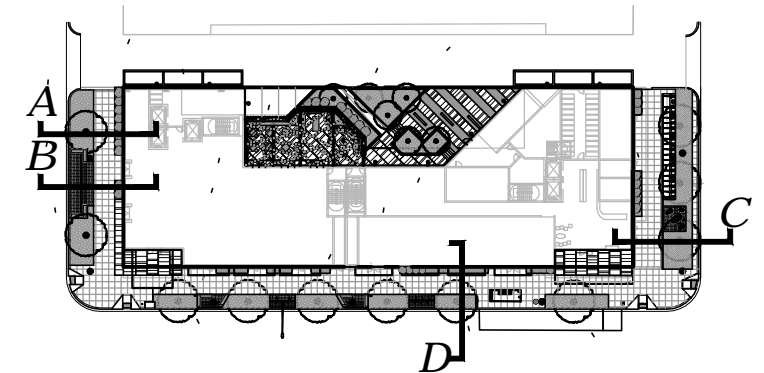

KEY PLAN

PUD SET



400 Florida Avenue | Washington DC

OCT 25, 2016 | L003



FLORIDA AVENUE TREE
Acer rubrum - Red Maple



4th AND 5th STREET TREE
Quercus lyrata 'QLFTB' P.P 13470 -
Highbeam Overcup Oak



CAPITAL BIKESHARE



STREETLIGHT - (DDOT standard)



CONCRETE SIDEWALK - 3X3 SCORING PATTERN



HOTEL TERRACE CHARACTER




FESTIVAL LIGHTING



TRASH RECEPTACLE



BIKE RACKS

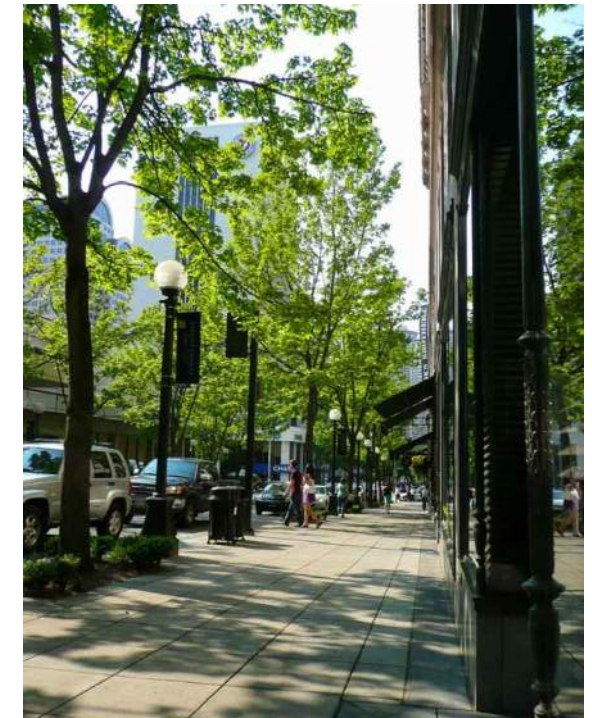

STREETSCAPE CHARACTER



HOTEL TERRACE CHARACTER



STREETSCAPE CHARACTER



STREETSCAPE CHARACTER



400 Florida Avenue | Washington DC

PUD SET

OCT 25, 2016 | L004



Ground Level Precedent Photos





Viburnum carlesii 'Spice Baby' (fragrant)



Sporobolus heterolepis



Schizachyrium scoparium 'Standing Ovation'



Crocosmia 'George Davison'



Agastache 'Apricot Sprite'



Rhus aromatica 'Low Gro' (fragrant)



Rosmarinus officinalis 'Arp' (fragrant)



Monarda didyma 'Cherry Pops' (fragrant)



Guara lindheimeri



Lysimachia nummularia



Ilex crenata 'Compacta'



Nassella tenuissima



Allium sphaerocephalon



CHARGING STATION



POSSIBLE FIXED CASUAL SEATING WITH CONVERSATION PEDESTALS AND SHELVES



SITE FURNISHINGS NOTE:
SITE FURNISHINGS IMAGERY SHOWN
ARE FOR ILLUSTRATIVE PURPOSES ONLY
AND MAY BE MODIFIED WITH FINAL
ENGINEERING AND DESIGN PROVIDED
THAT THE GENERAL QUALITY AND
CHARACTERISTICS ARE IN SUBSTANTIAL
CONFORMANCE WITH THAT SHOWN.

POSSIBLE SENSORY SHRUBS, PERENNIALS
AND GRASSES WITH SEASONAL COLORS,
TEXTURES AND FRAGRANCE.



400 Florida Avenue | Washington DC

PUD SET

OCT 25, 2016 | L005



Deaf Space Precedent Photos



POTENTIAL PEDESTAL DECKING



GREENROOF



SEATING AREAS



TABLES AND CHAIRS



AMBIENT LIGHTING



SEATING AREAS



ARBOR



SERVICE BAR



OUTDOOR GRILLS



PLANTER



LOUNGER

SITE FURNISHINGS NOTE:
SITE FURNISHINGS IMAGERY SHOWN ARE FOR ILLUSTRATIVE PURPOSES ONLY AND MAY BE MODIFIED WITH FINAL ENGINEERING AND DESIGN PROVIDED THAT THE GENERAL QUALITY AND CHARACTERISTICS ARE IN SUBSTANTIAL CONFORMANCE WITH THAT SHOWN.



400 Florida Avenue | Washington DC

PUD SET
OCT 25, 2016 | L006



Roof Level Precedent Photos